




Contractor must verify all dimensions on site before commencing any work or stop drawings.
If this drawing exceeds the quantities taken in any way, the building designers are to be informed before the work is initiated.
Only figured dimensions to be taken from this drawing. Do not scale off this drawing.
Drawing based on Ordnance Survey and/or existing record drawings - design and drawing content subject to Site Survey, Structural Survey, Site Investigations, Planning and Statutory Requirements and Approvals.
All drainage layouts are schematic and invert levels must be established prior to construction.

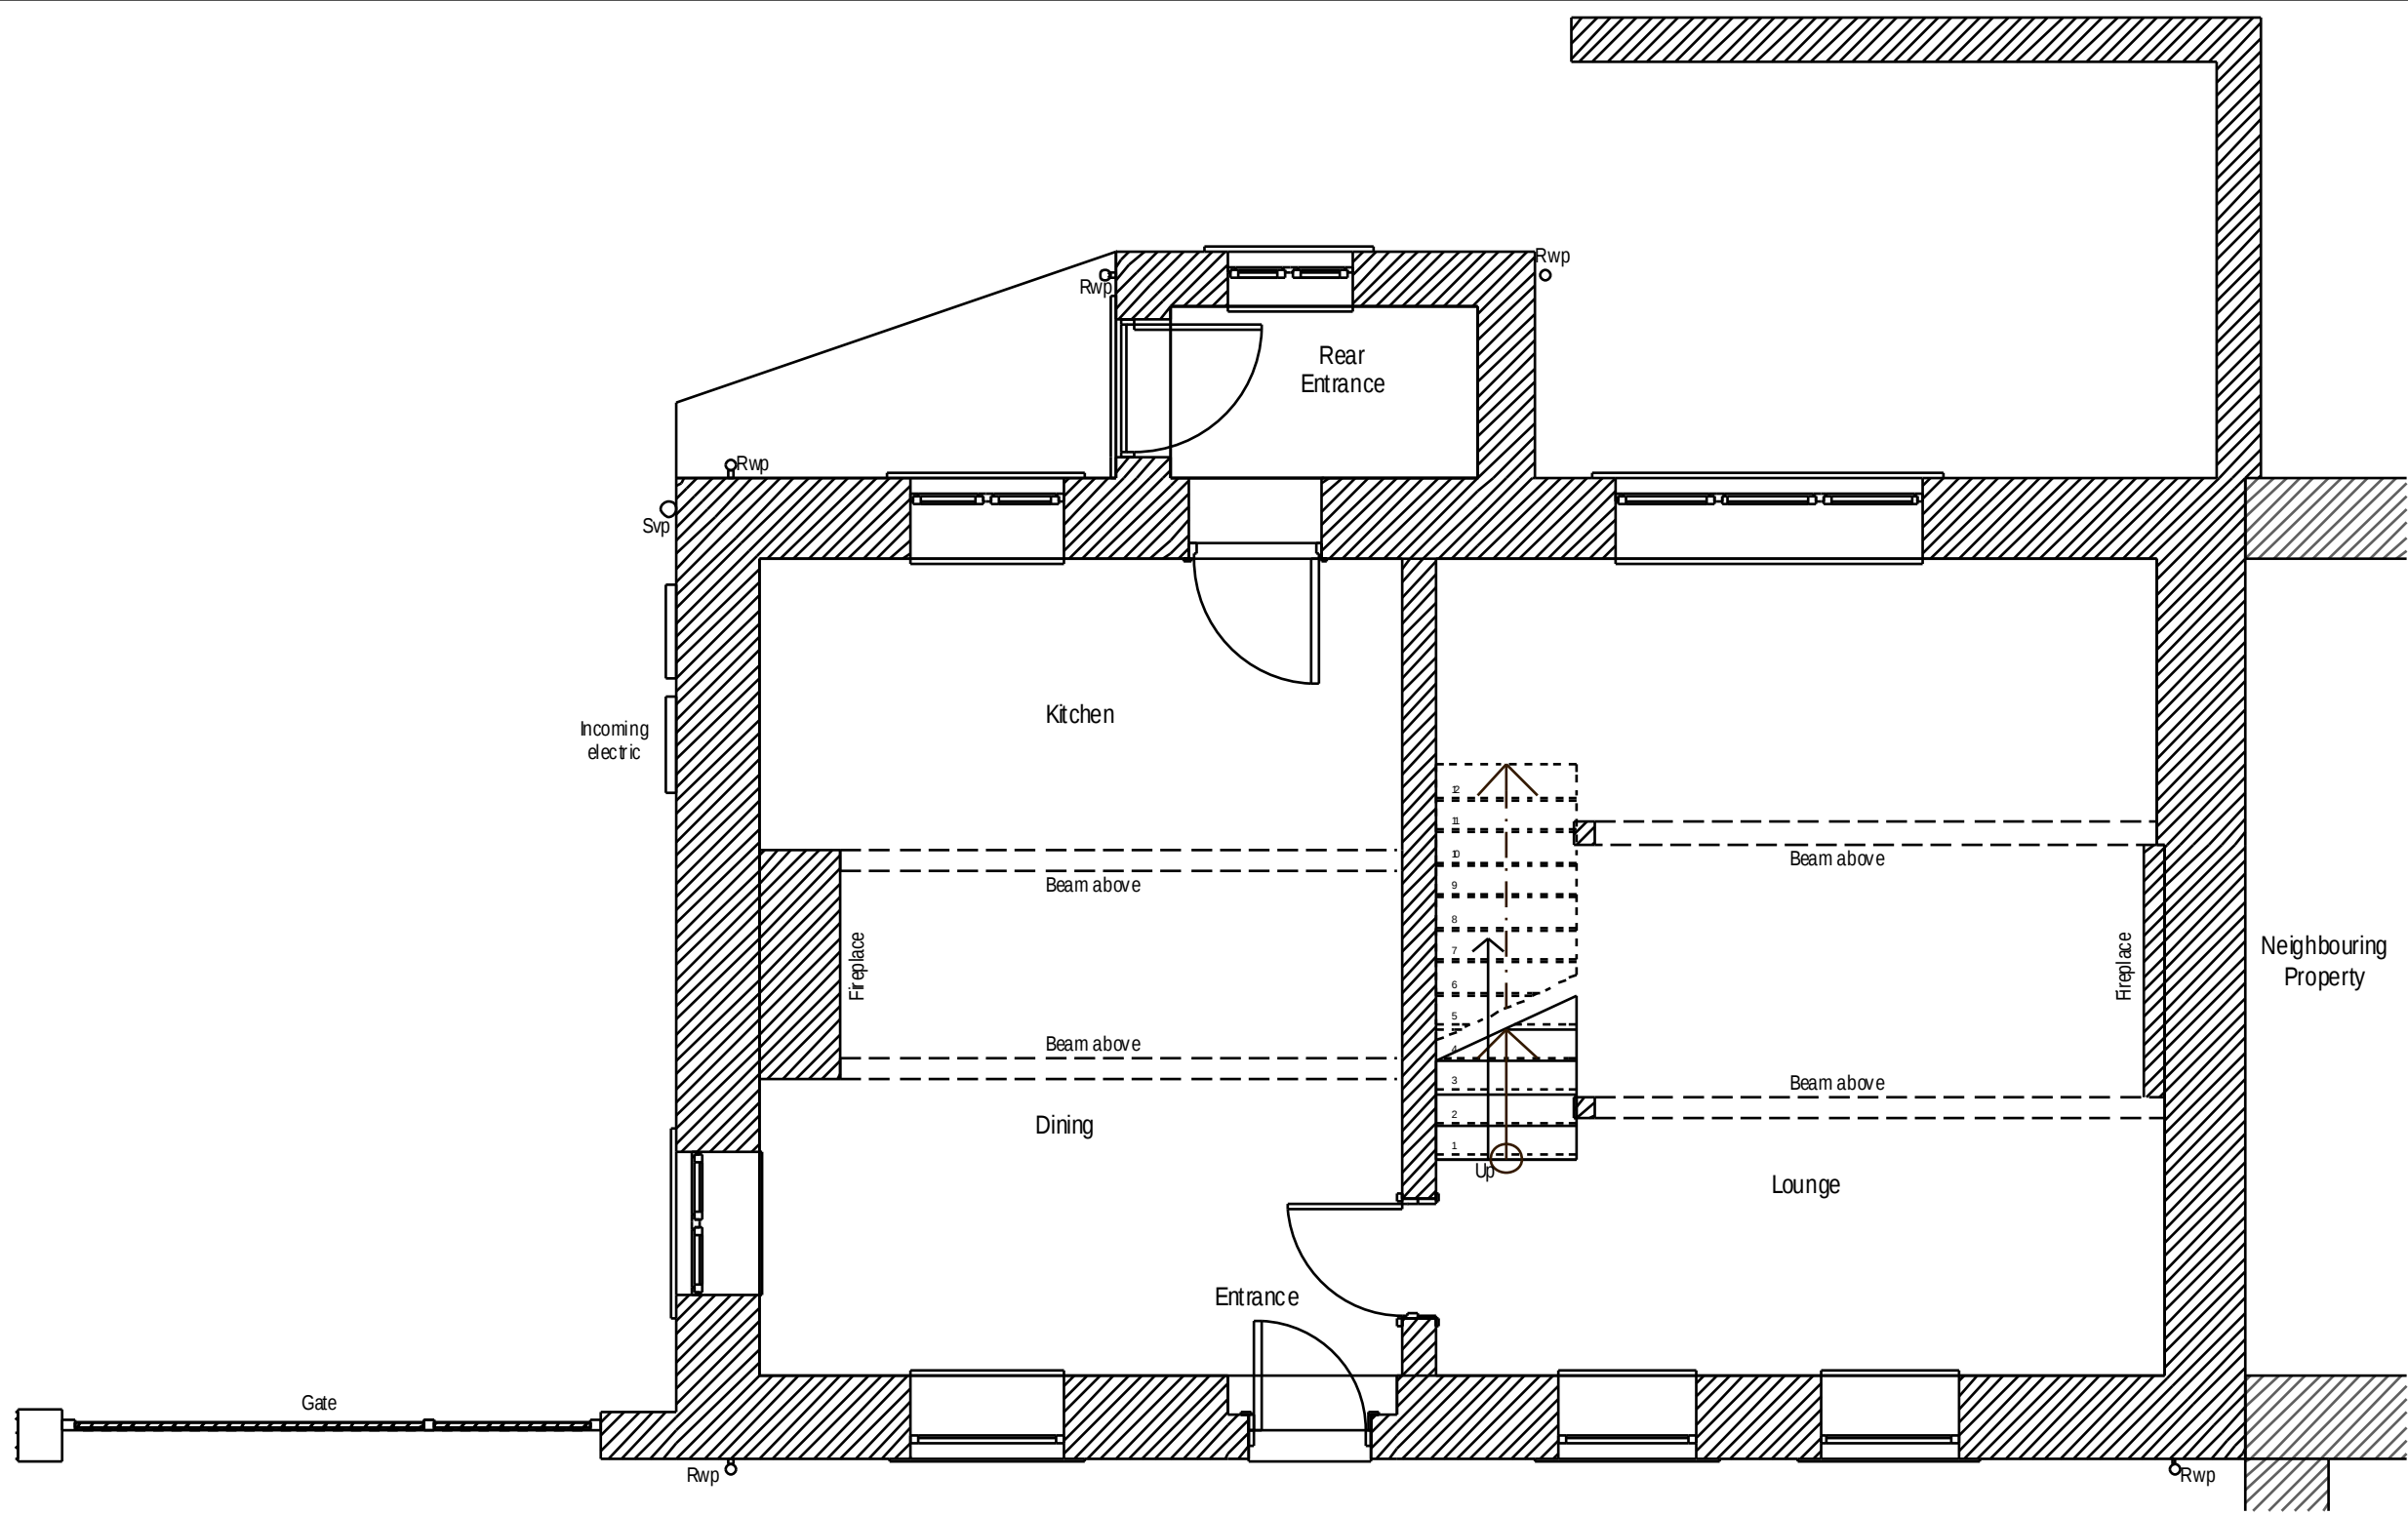


Ground Floor Plan 1:50

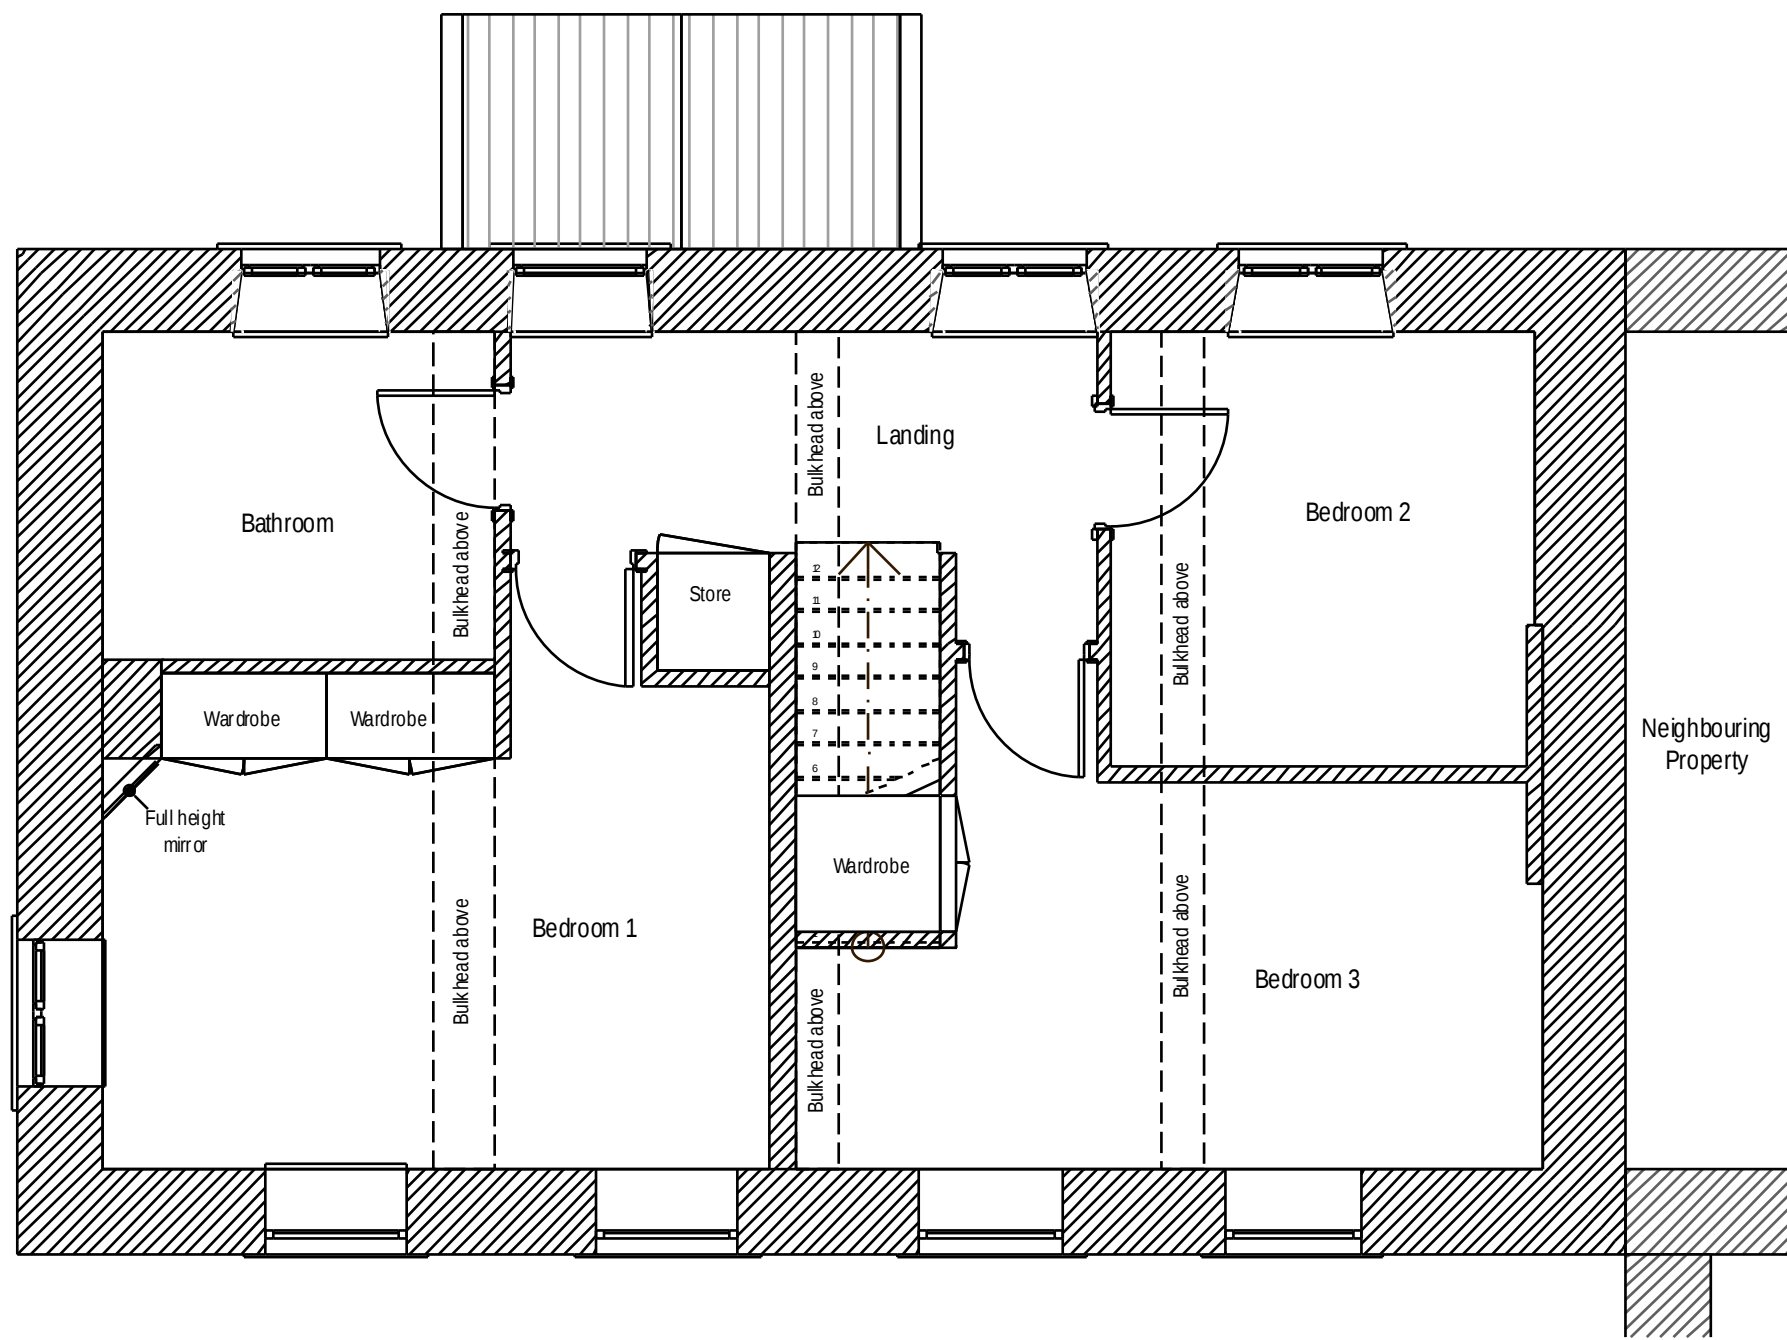


First Floor Plan 1:50

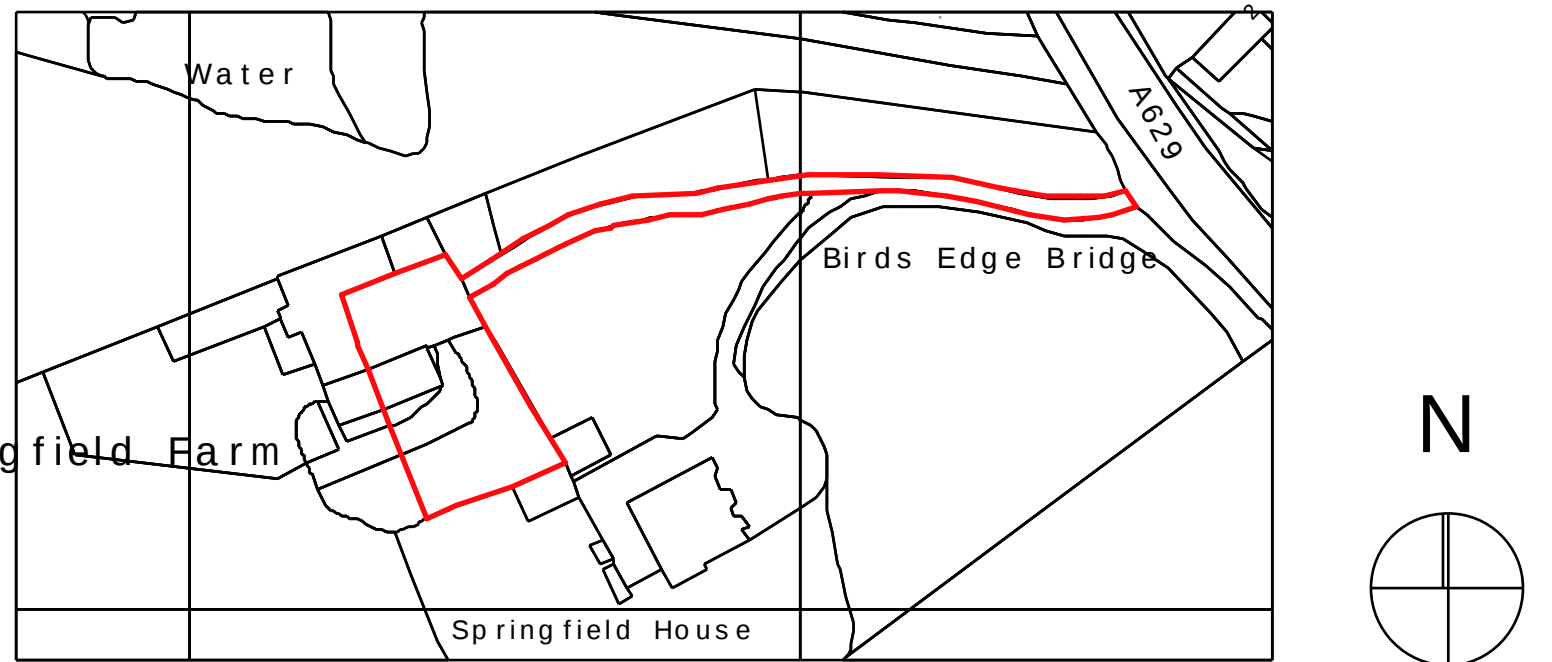


Site Location Plan 1:1250

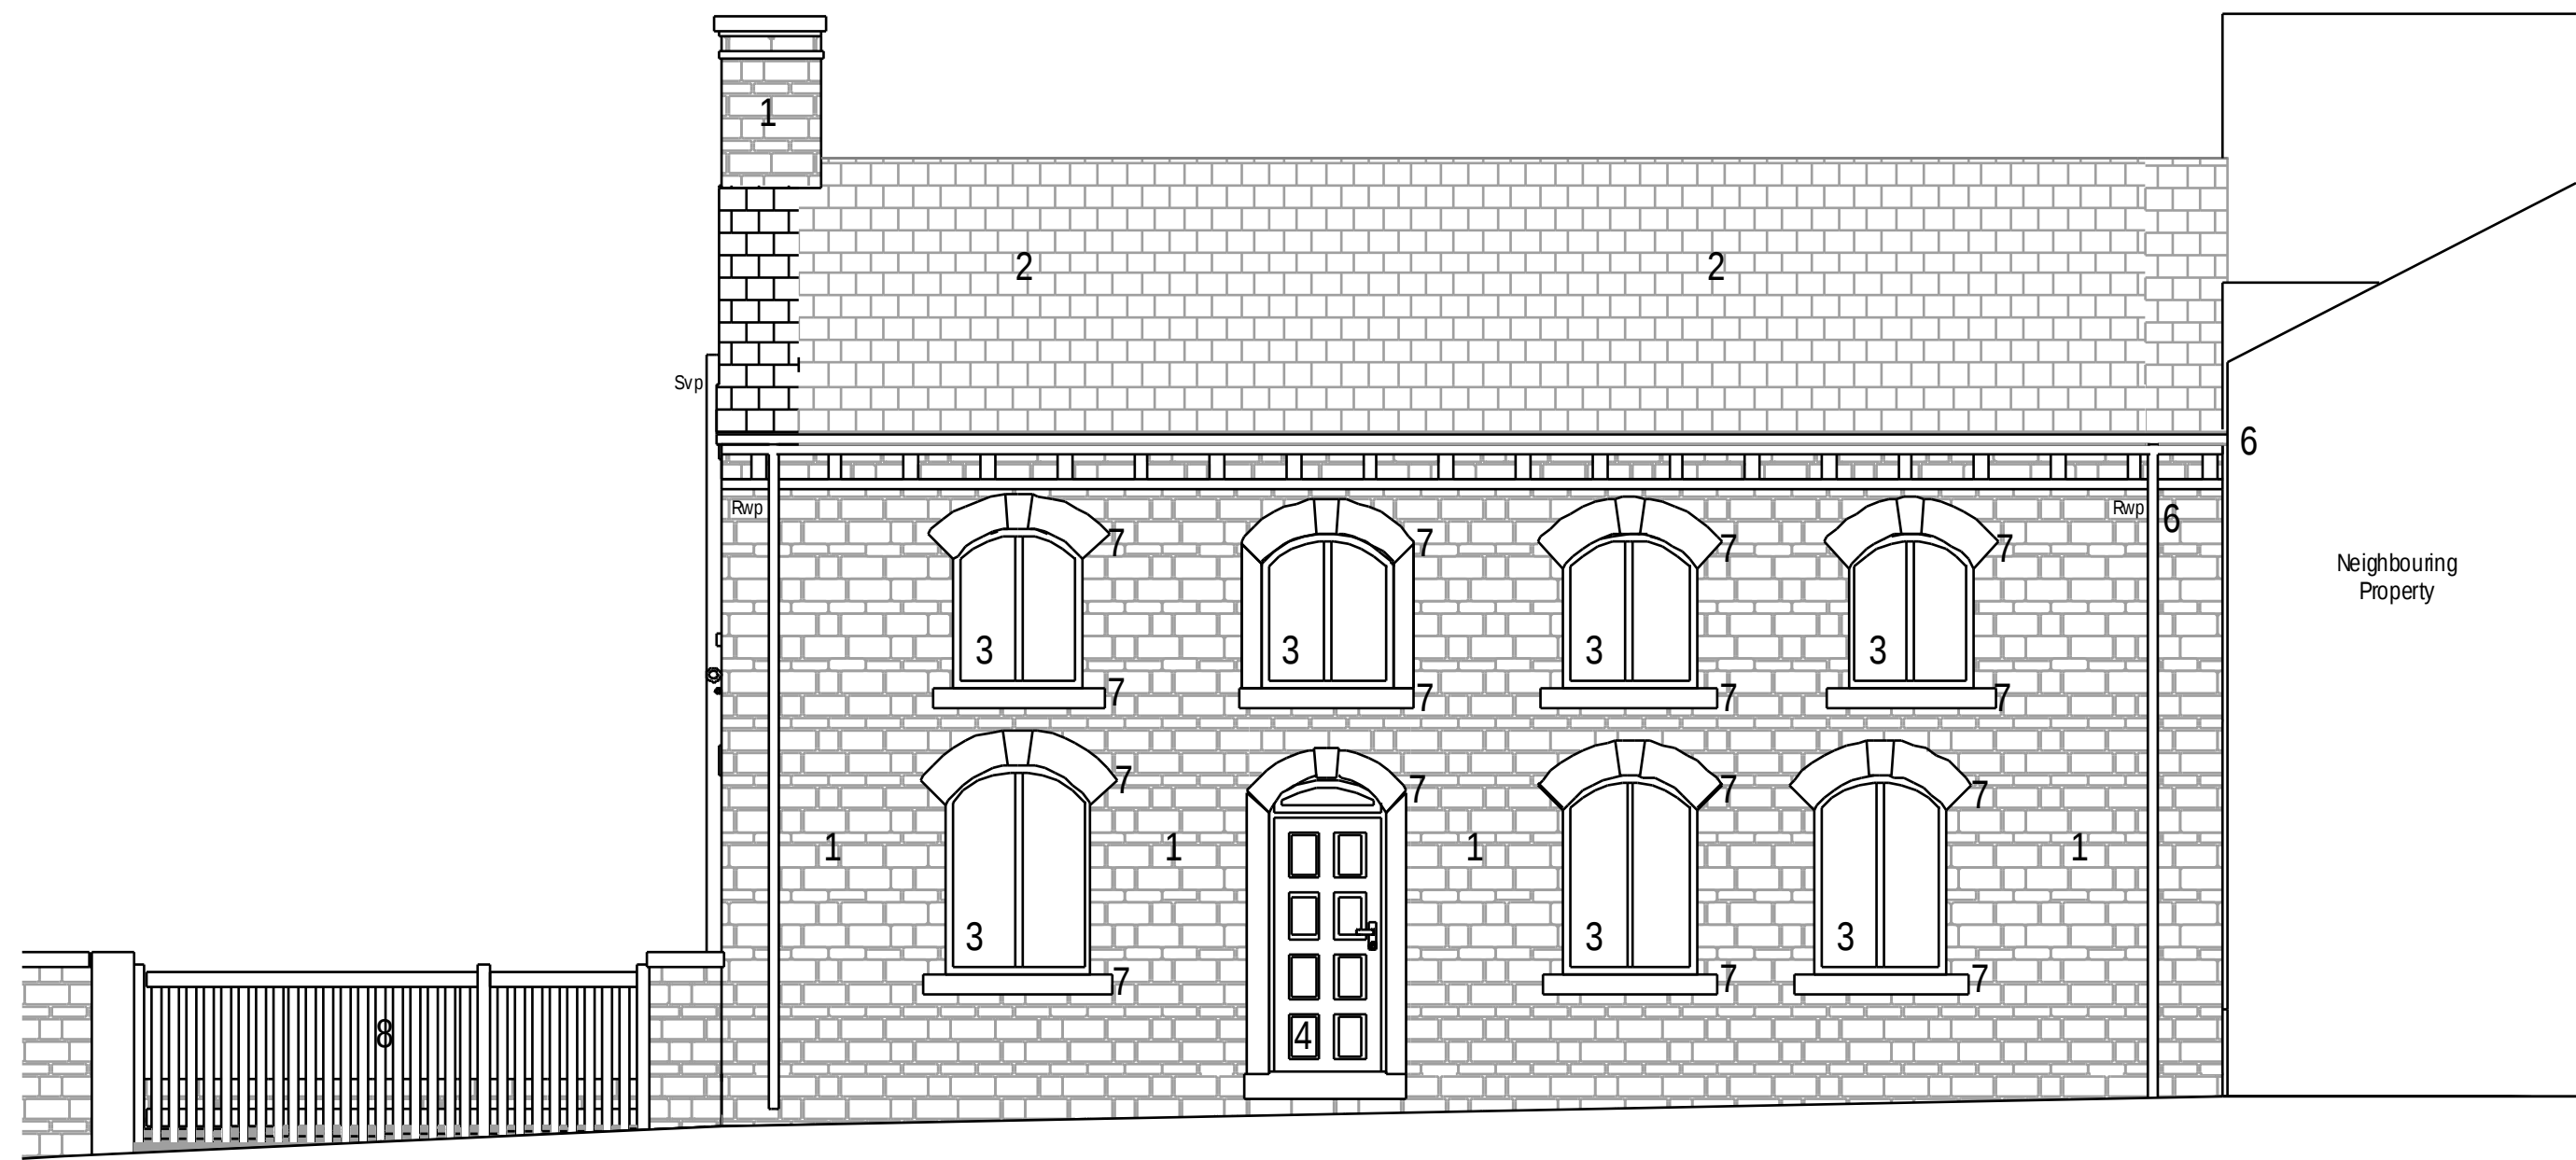

Front Elevation 1:50

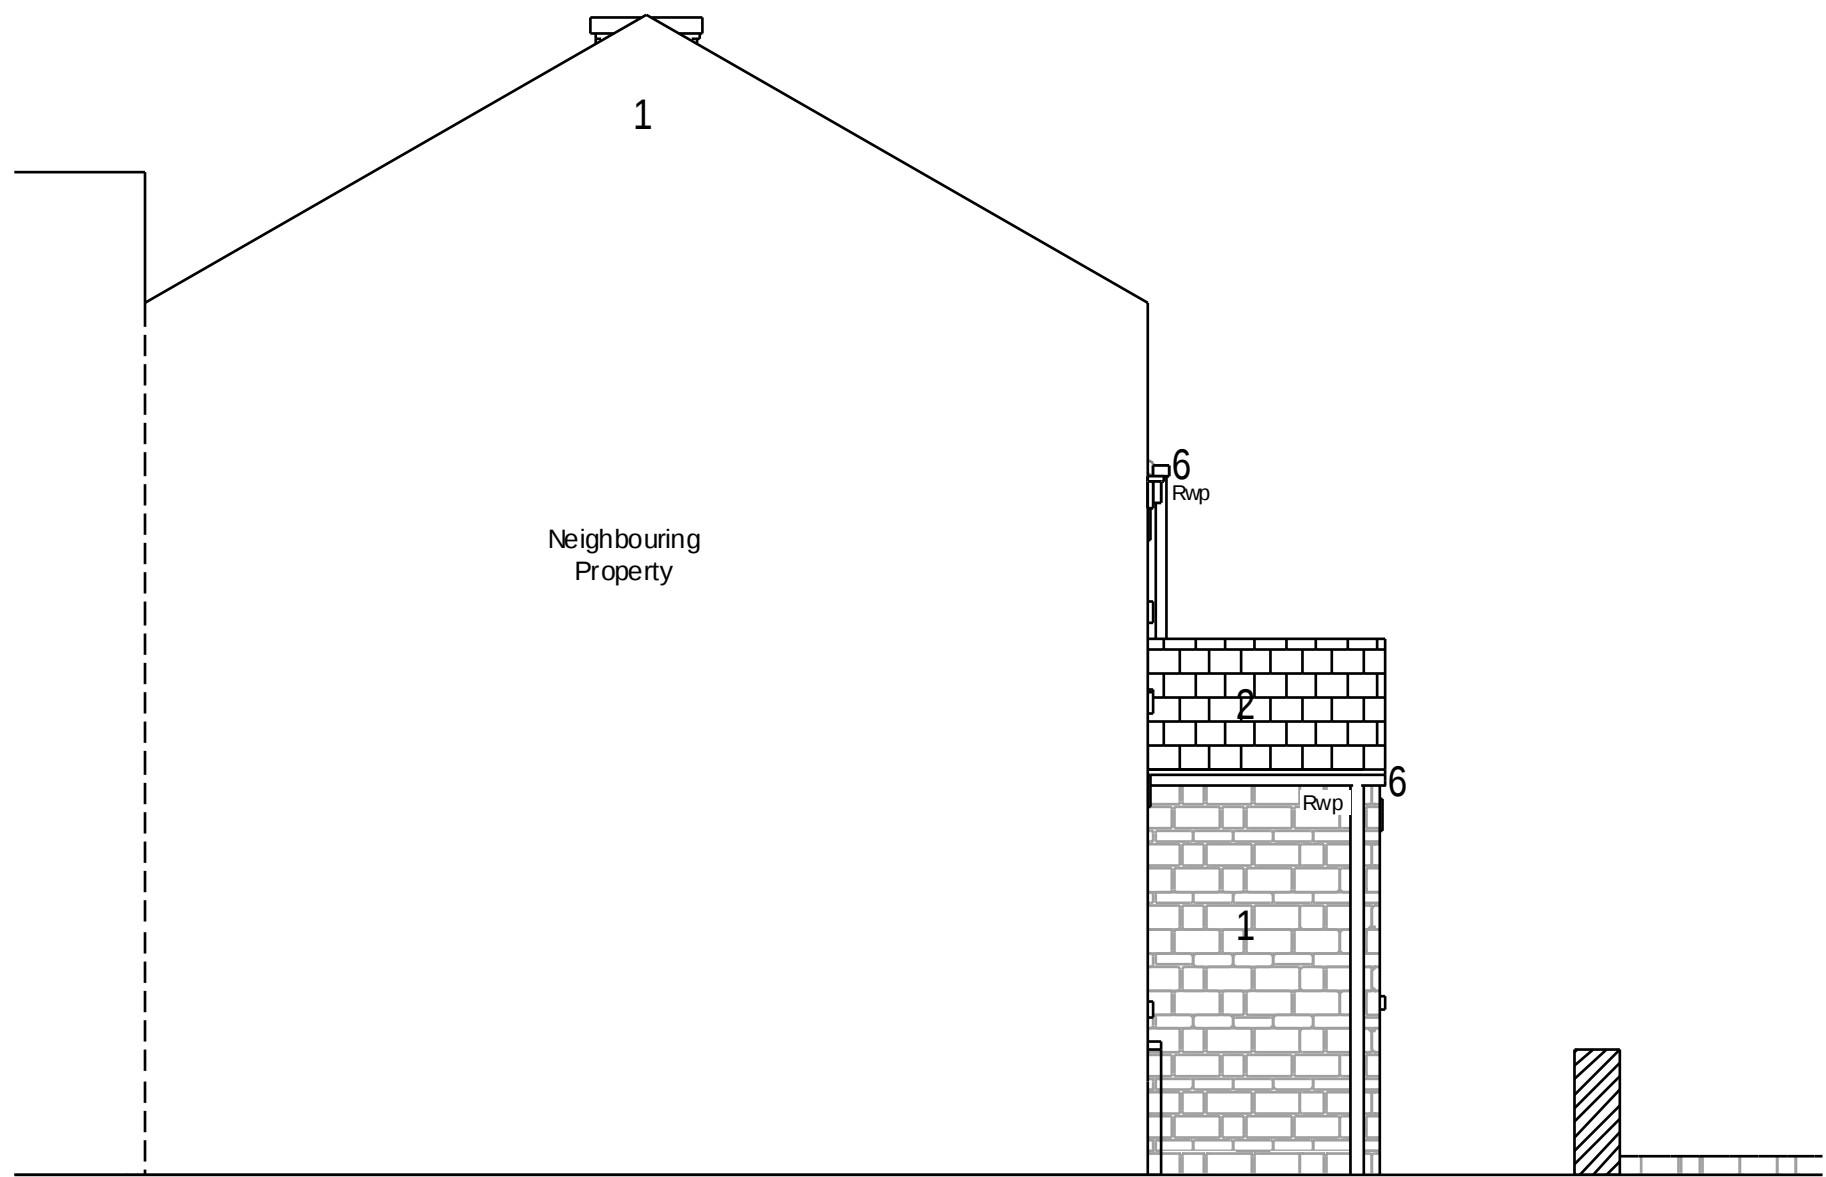

Side Elevation 1:50

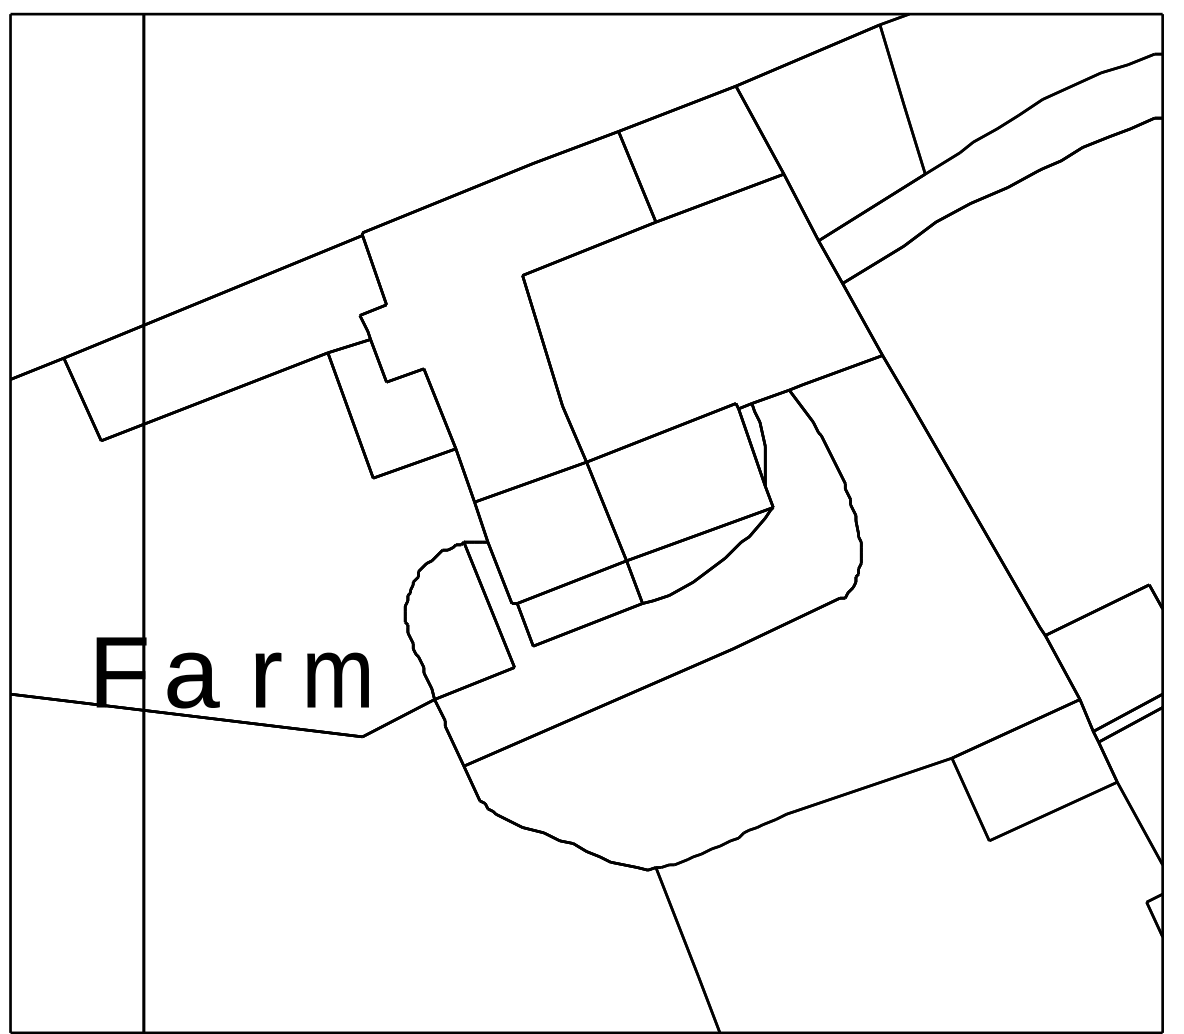

Site Block Plan 1:500



Rear Elevation 1:50

Key:

1. Stone.
2. Brown concrete roof tiles.
3. Timber window.
4. Timber door.
5. Timber door painted black.
6. Grey rainwater goods.
7. Stone cill and headers.
8. Timber gate.



Side Elevation 1:50

Rev A 10.08.2012 Updated location plan to planners request. NIP	
Project Status:	PLANNING ONLY
transform architects...	
4 Rushmead Court, Ossett, WF5 0NZ tel 01924 265 080 - fax: 0871 66 11 003 web: www.transformarchitects.co.uk email: info@transformarchitects.co.uk	
Project:	Springfield Farm, Birdsedge, Huddersfield, HD8 8XP
Client:	Mr and Mrs Barrett
Drawing Title:	Existing Plans and Elevations A1
Scale:	1:50, 1:500, 1:1250
Date:	21 - 05 - 2012
Drawn By:	MNB
Drawing Number:	T551 - PL01
Revision:	Rev A