



Proposed Ground floor plan 1:100


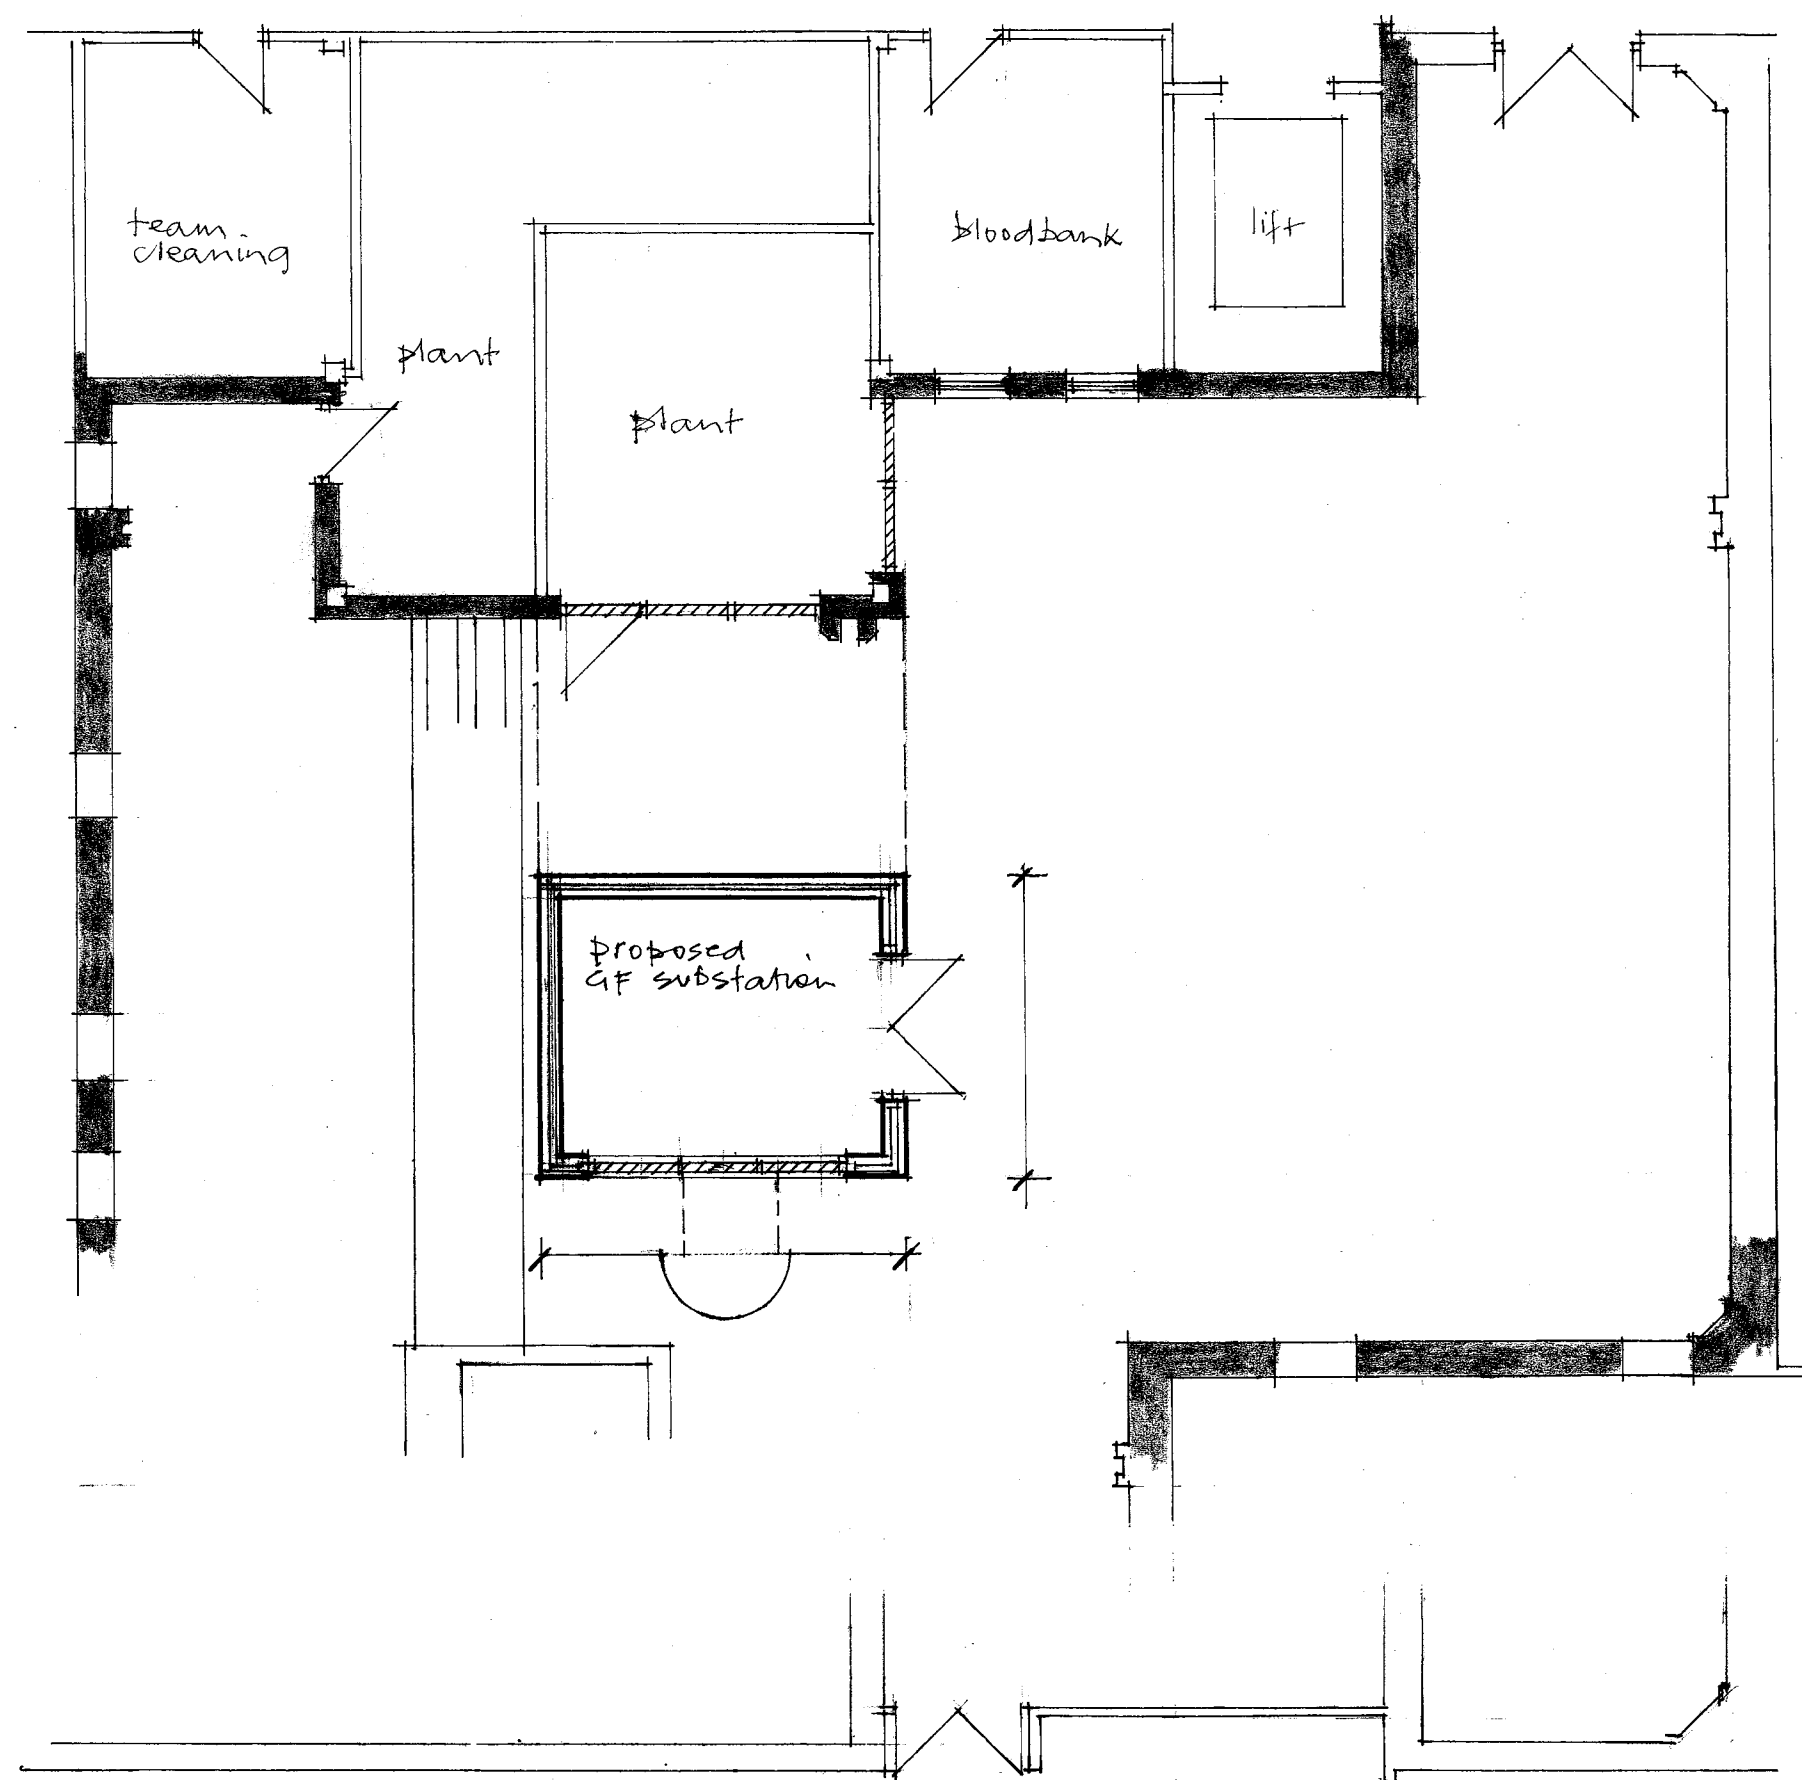


hospital street

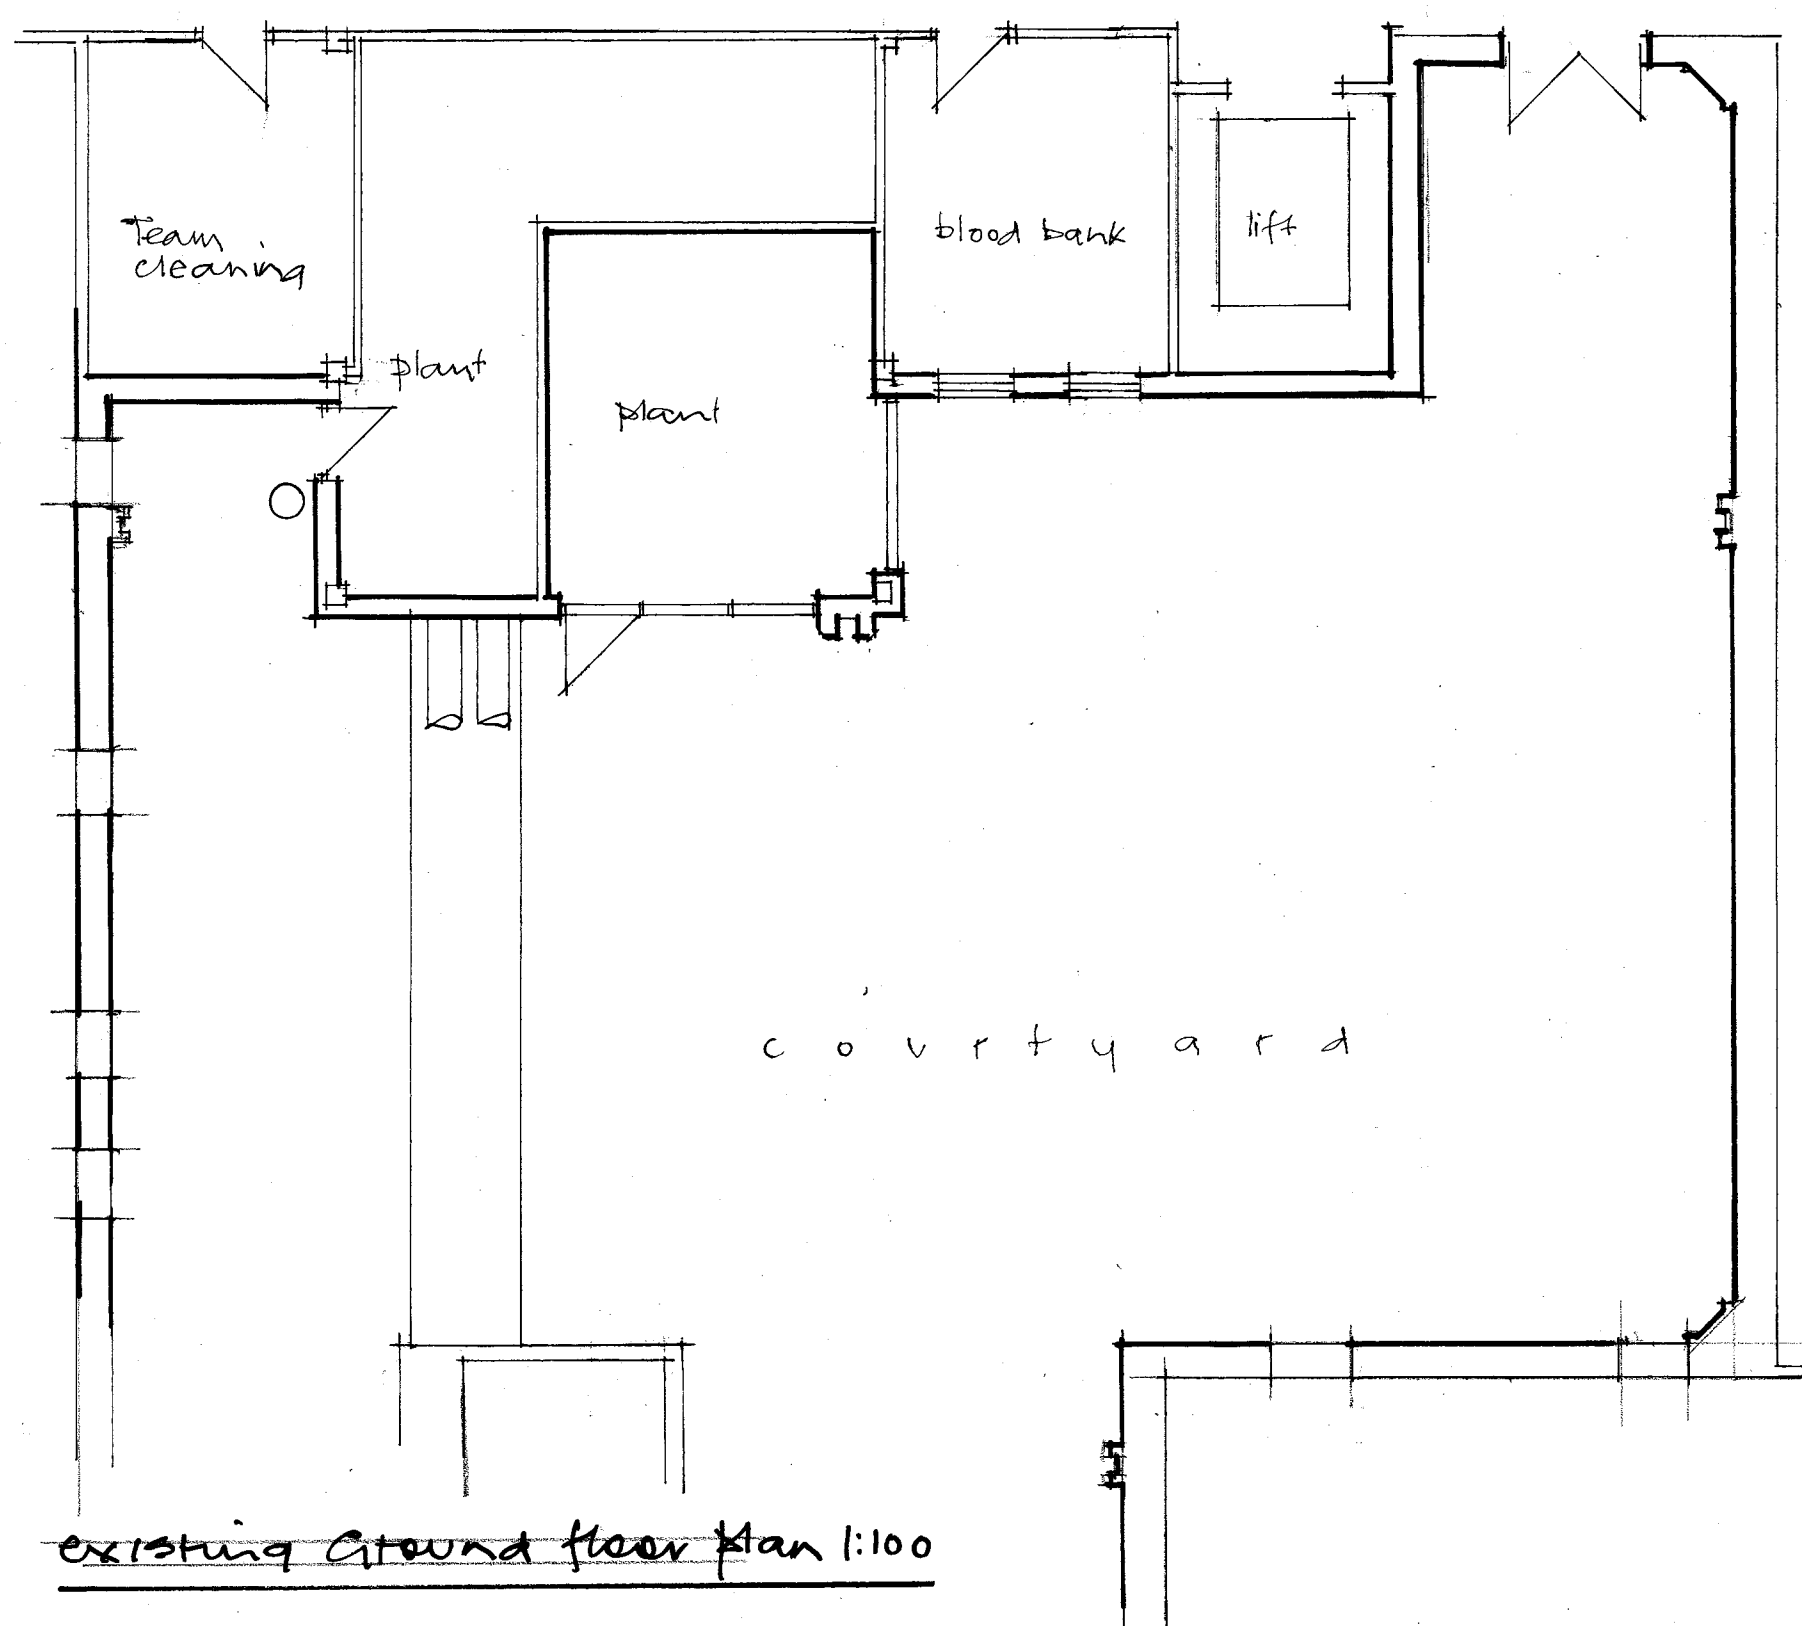


existing Ground floor plan 1:100


proposed first floor plan 1:100

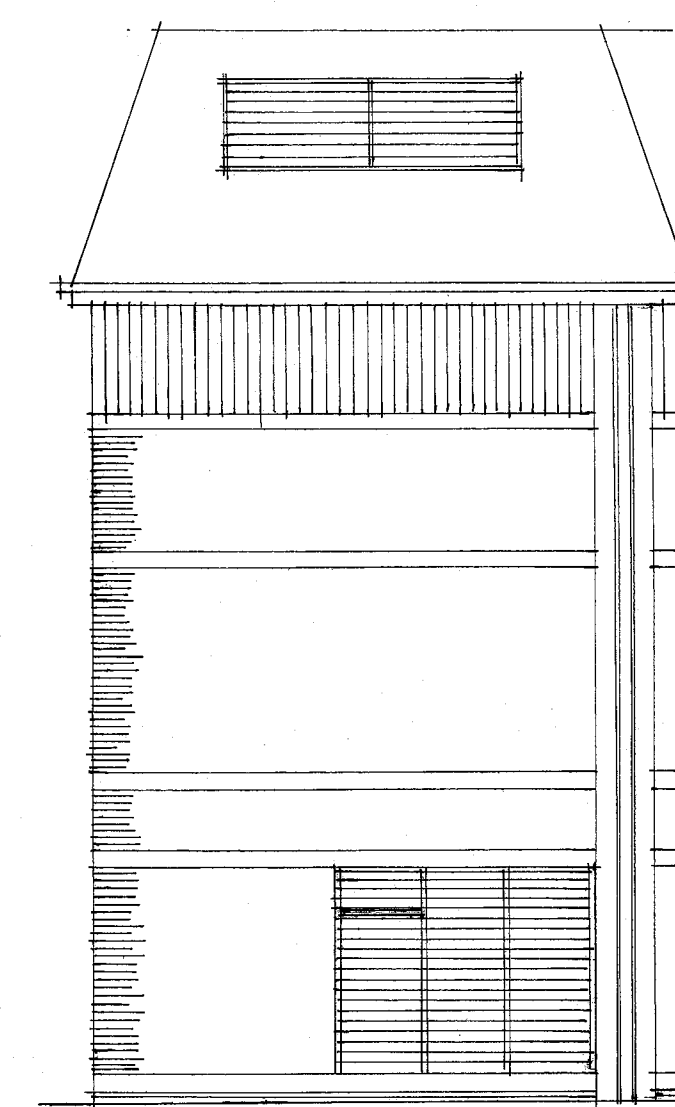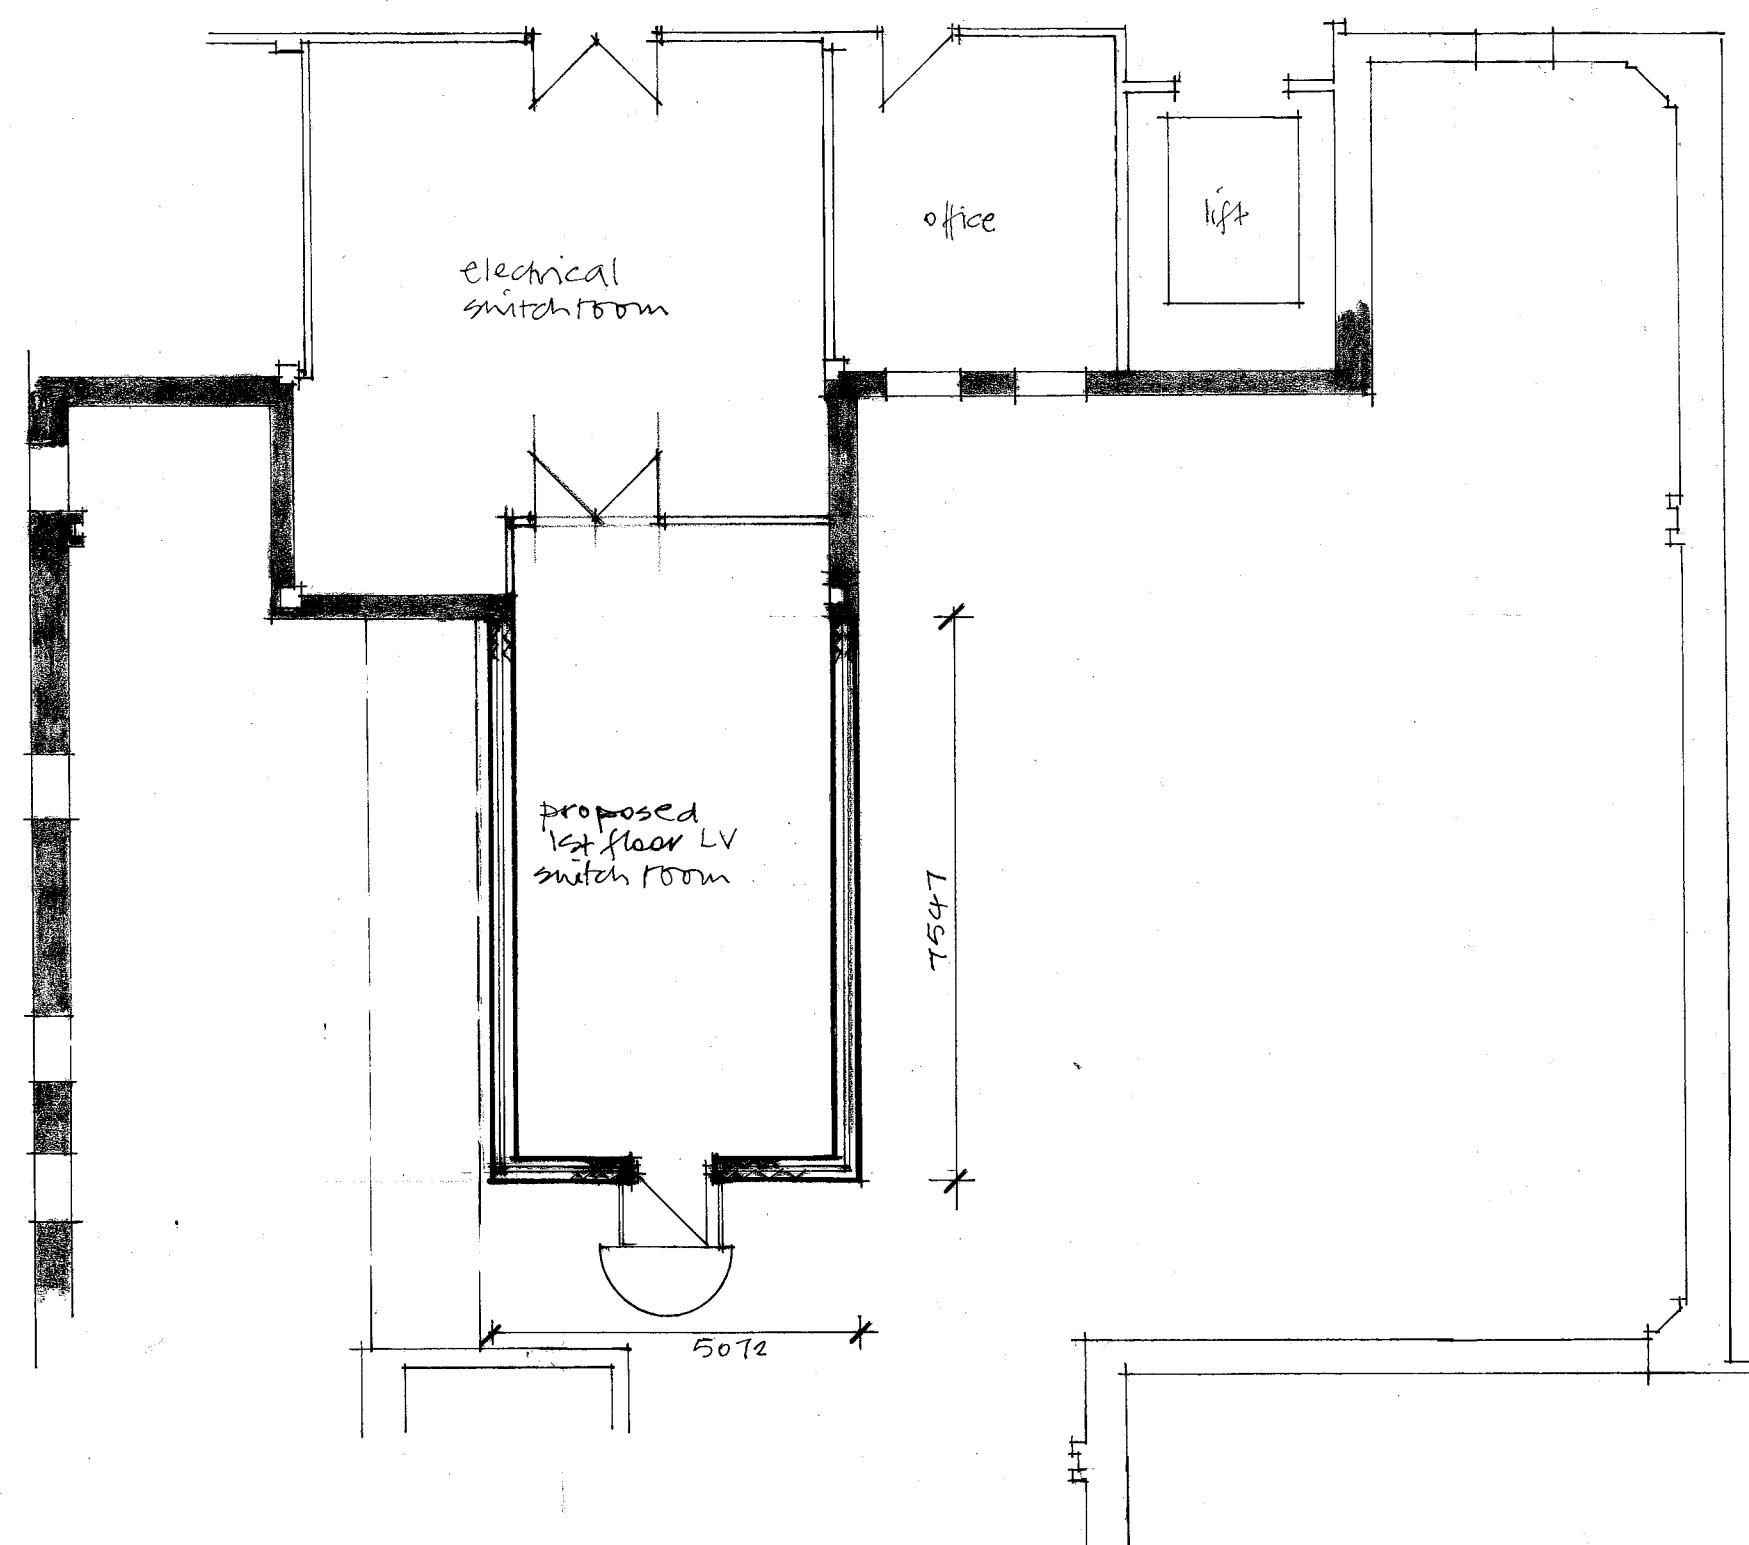


existing elevation 1:100

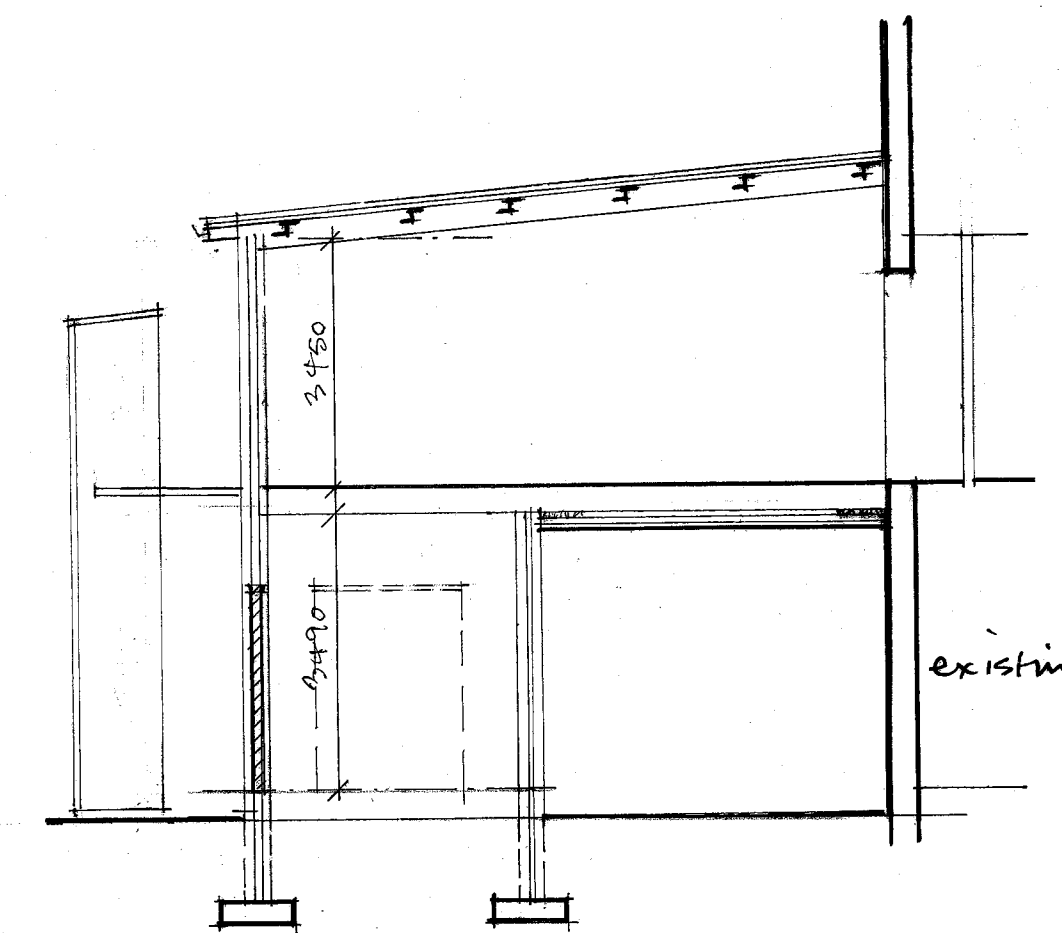


proposed section 1:100

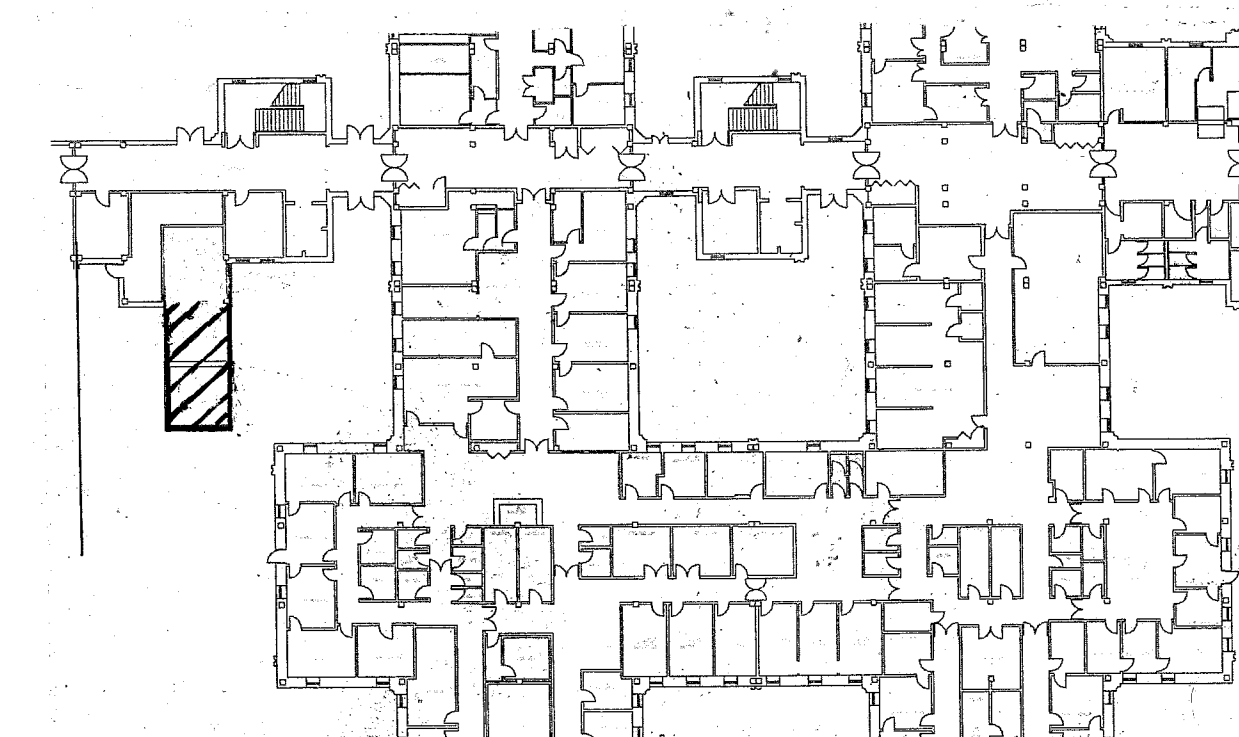


site location - proposed NTS

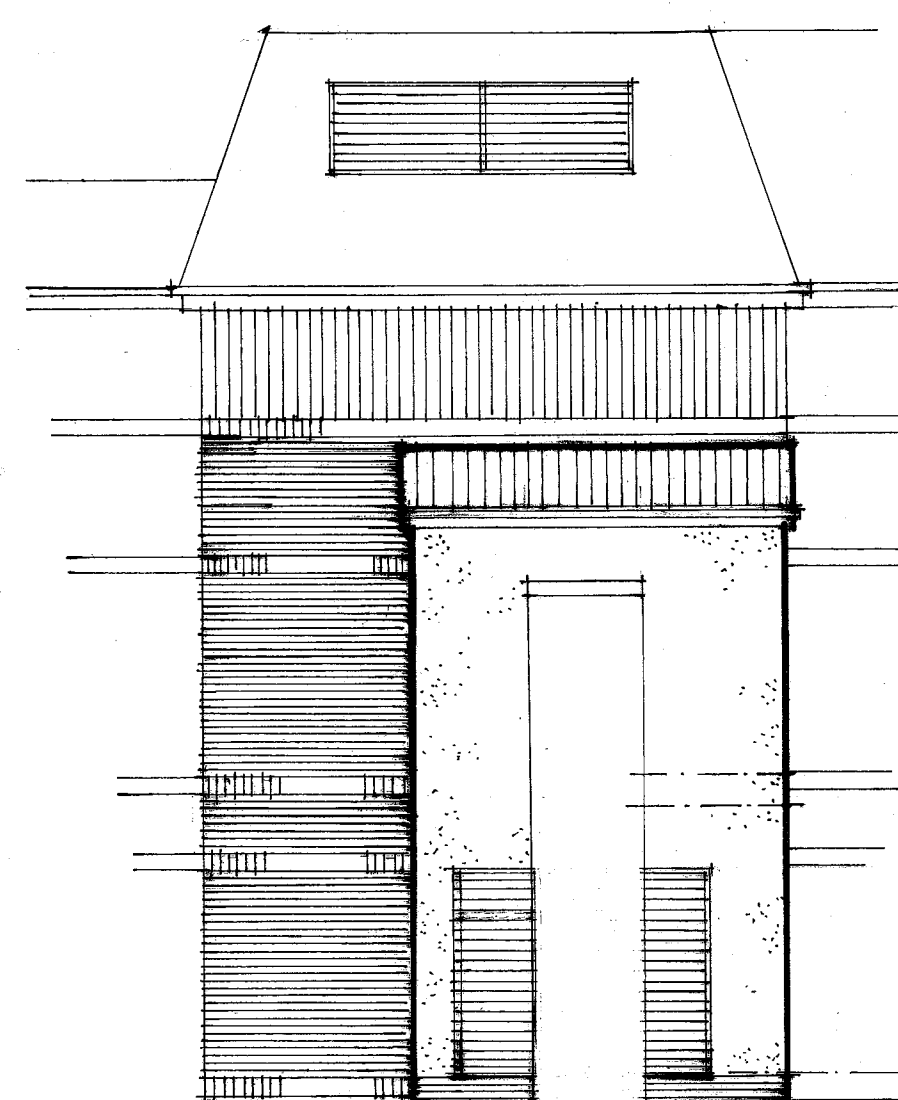

proposed front elevation 1:100

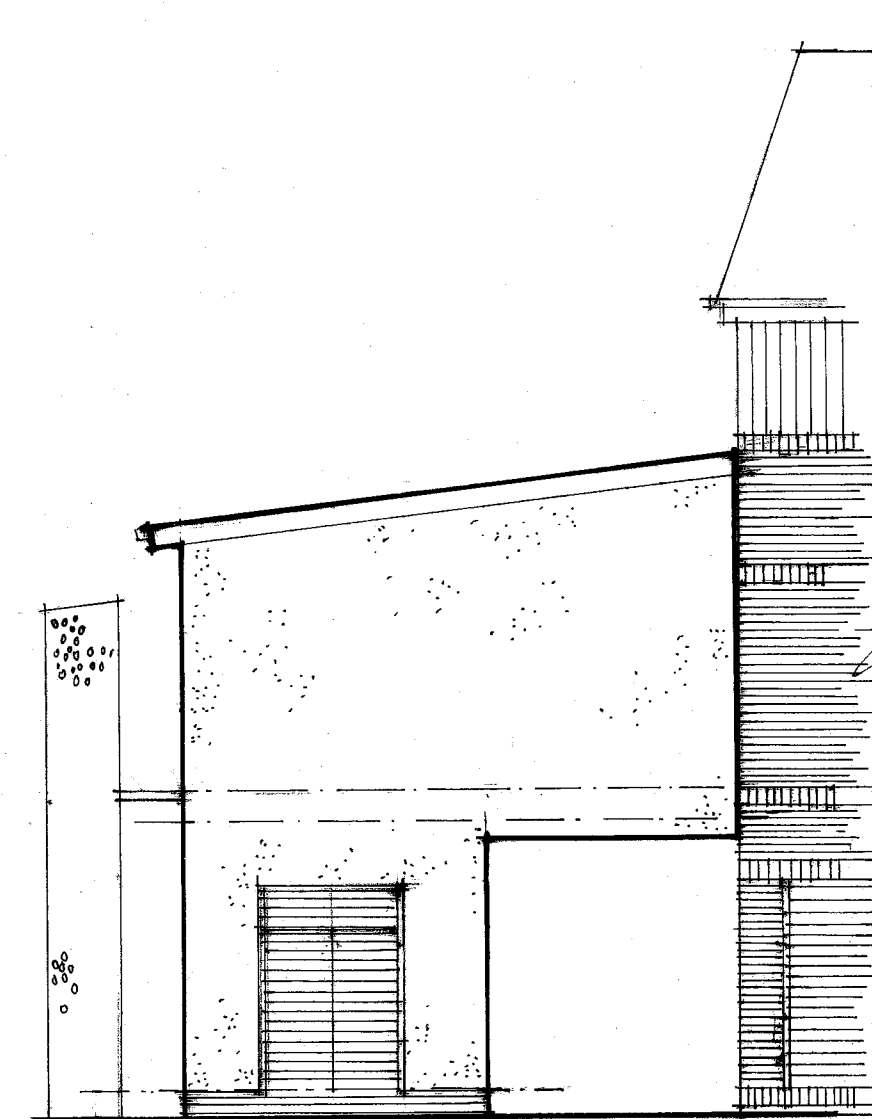

proposed side elevation

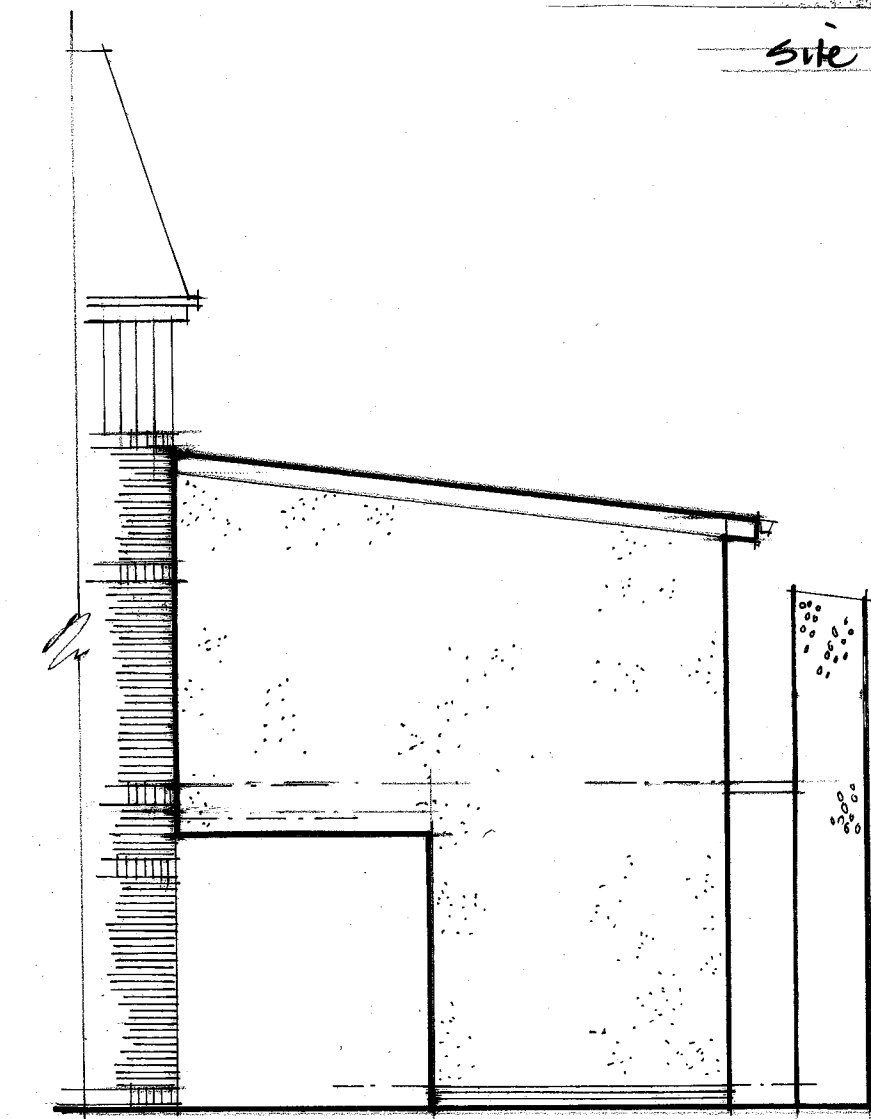

proposed side elevation 1:100

Rev	Description	Date
1	PLANNING	
Client:		
The Mid Yorkshire Hospitals NHS Trust NHS		
Project Title:		
LV Switch Plant Room		
Dewsbury & District Hospital		
Drawing Title:		
General Arrangements as Existing & Proposed		
Date:	Scale:	Sheet:
12.07.16	1:100	A1
Project No:	Drawing No:	Revision:
16029	[10] 01	-
Copthall Bridge House, Station Bridge, Harrogate, HG1 1SP		
Tel: 01423 790 146 - Fax: 01423 790 227		
Email: info@pmkdesignassociates.com		

pmk design associates