
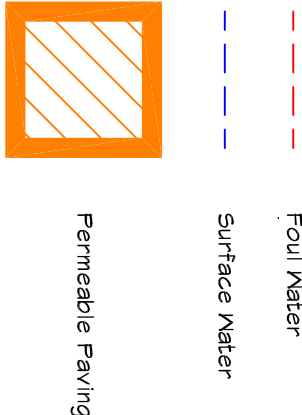
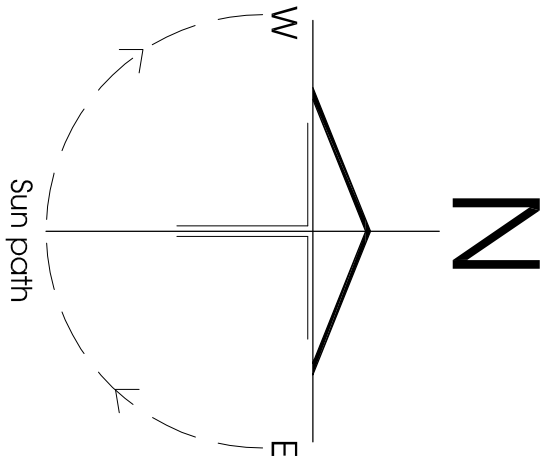


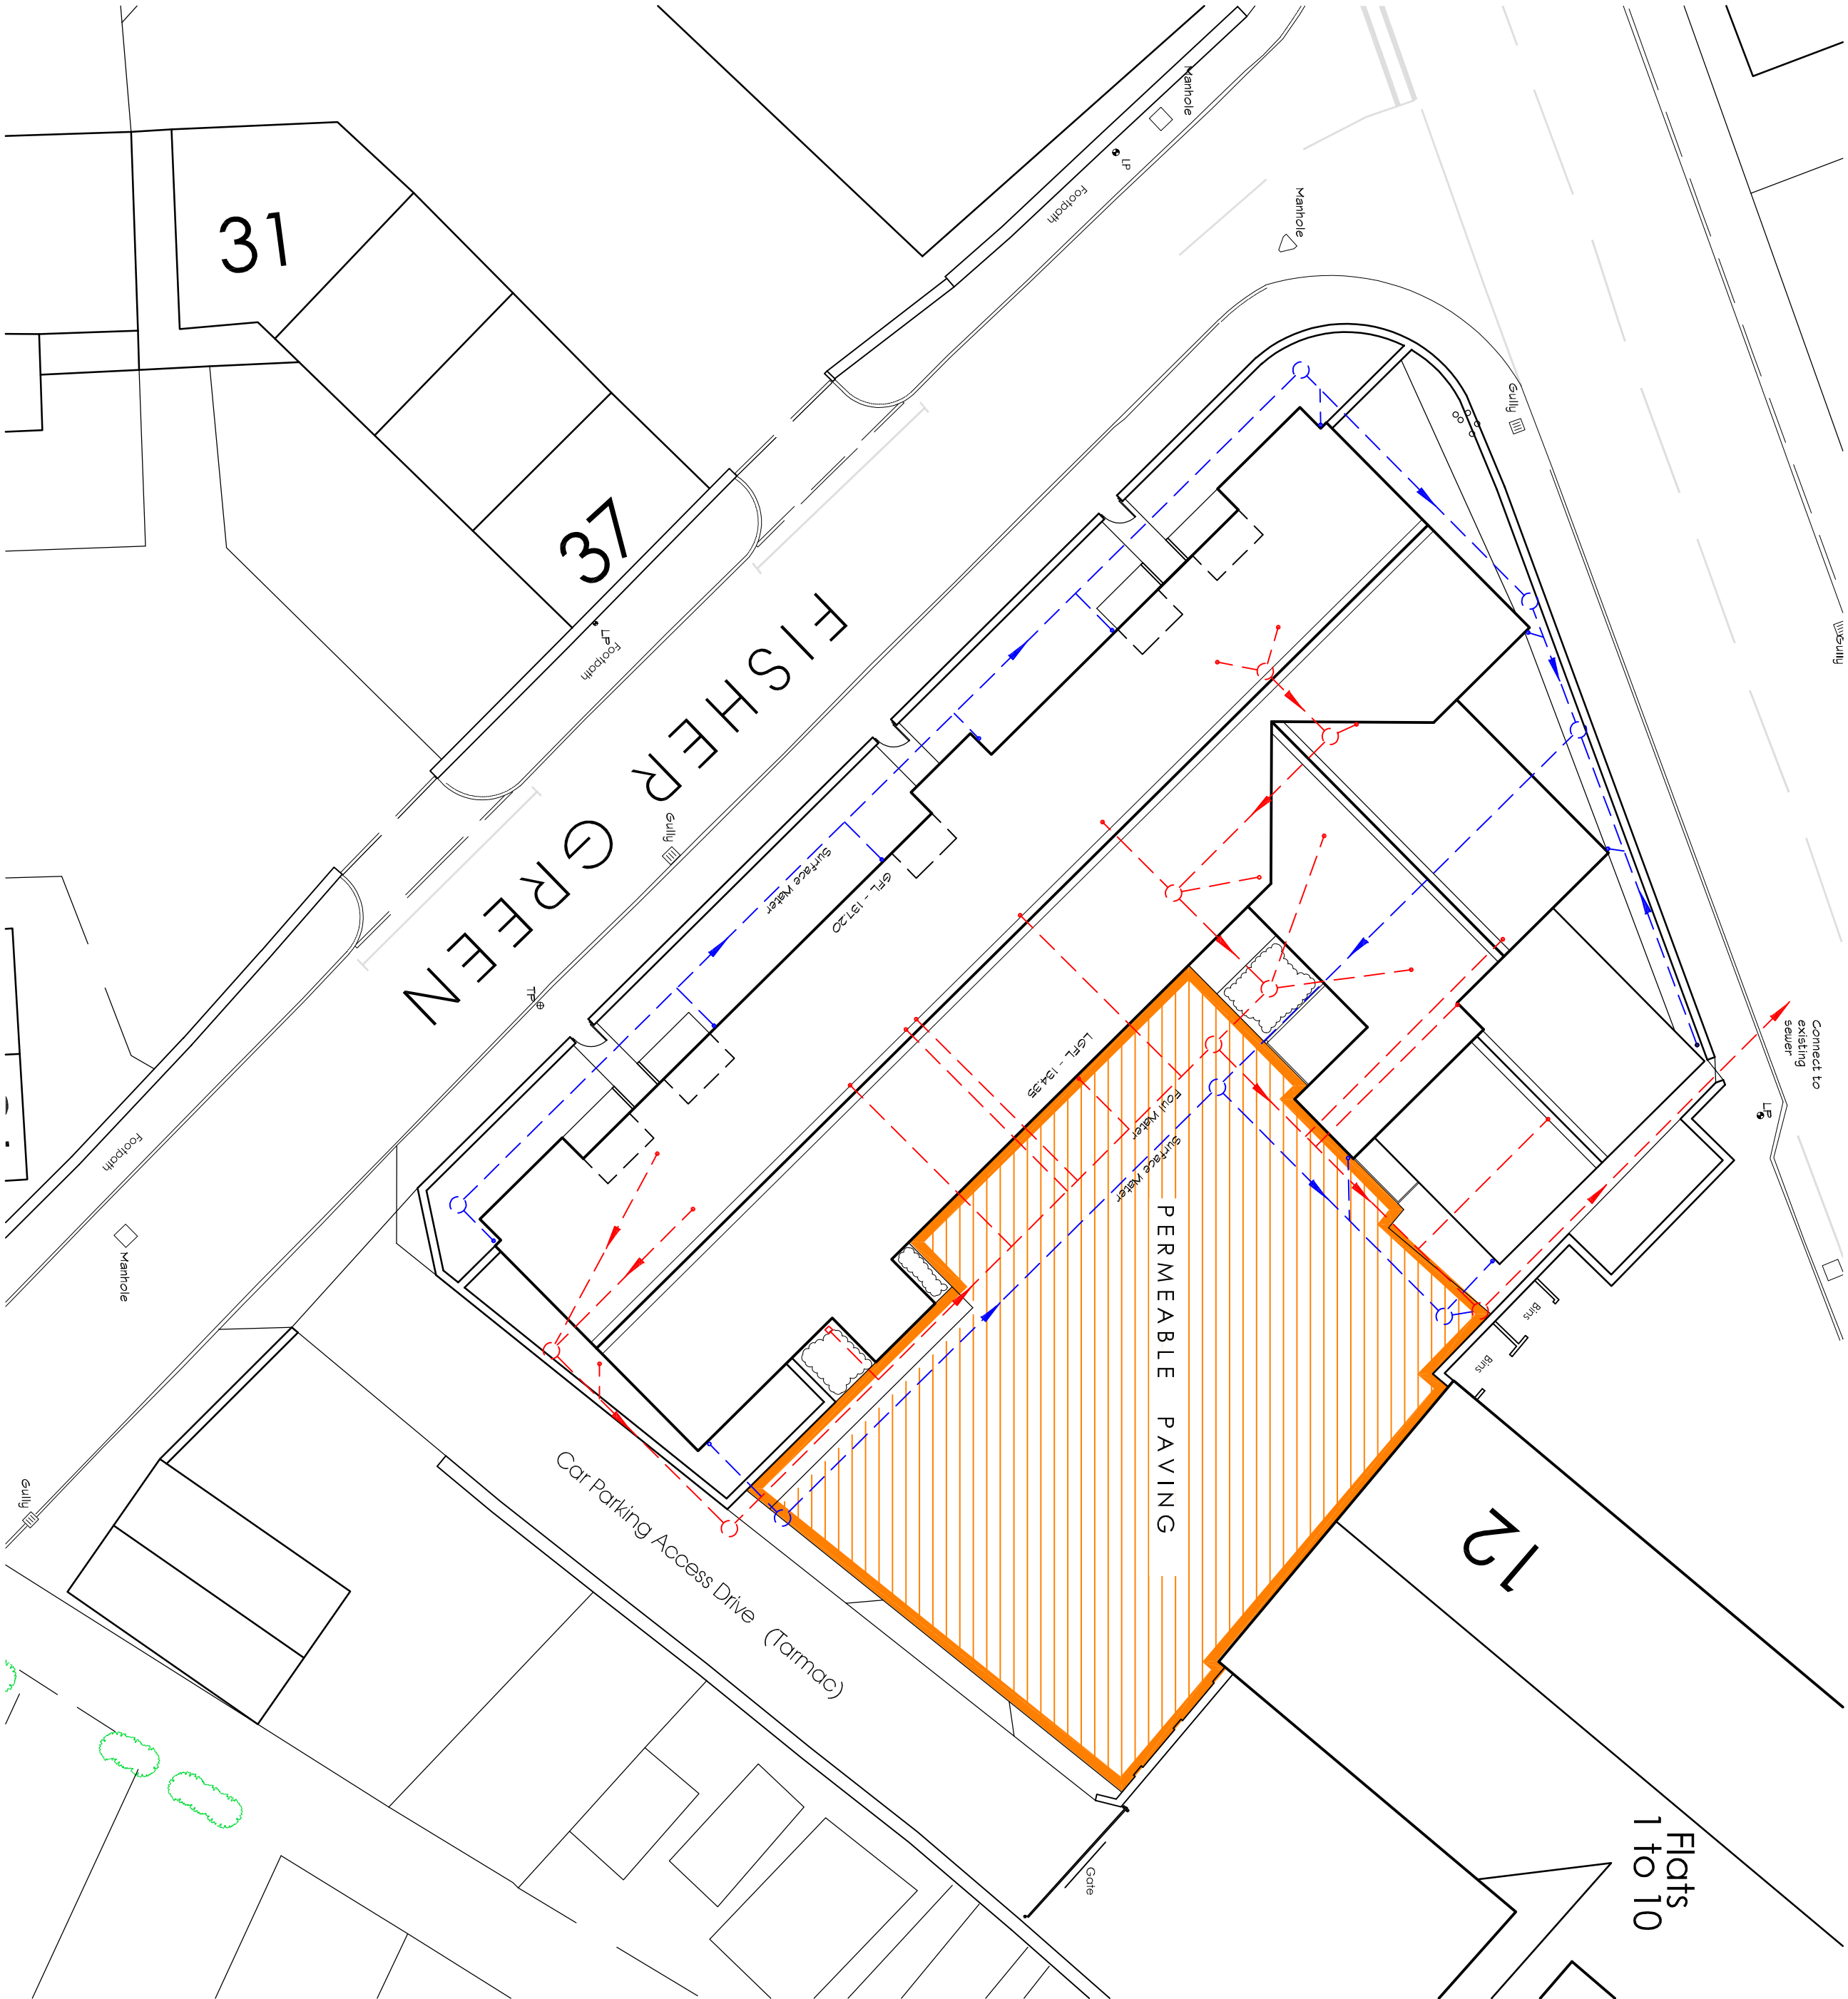

Revisions:

Residential Feasibility
at Fisher Green
Honley
Holmfirth
for Eastwood Homes Ltd

Drainage Layout

Farrar Bamforth Associates Ltd.

Chartered Architectural Technologists

51, Trinity Street, Huddersfield HD1 4DN
Tel. (01484) 424008 Fax. (01484) 512305
E-mail : design@farrarbamforth.co.uk
Website : www.farrarbamforth.co.uk

Drawn	JHS
Date	August 2016
Scales	1:200
Drawing No.	16/D03/19
Rev.	

