


Do Not Scale

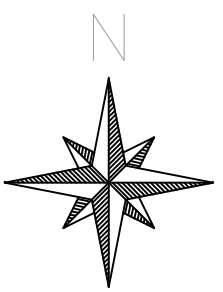


DESIGNERS HAZARD IDENTIFICATION

IT IS ASSUMED THAT ALL WORKS WILL BE UNDERTAKEN BY A COMPETENT CONTRACTOR WORKING, WHERE APPROPRIATE, TO AN APPROVED METHOD STATEMENT. IN ADDITION TO THE HAZARDS TYPICALLY ASSOCIATED WITH THE TYPES OF CONSTRUCTION DETAILED ON THIS DRAWING, ANY KNOWN ABNORMAL HAZARDS SPECIFIC TO THIS DRAWING HAVE BEEN IDENTIFIED.

ABNORMAL HAZARD REFERENCE

Notes

1. THIS DRAWING IS FOR INFORMATION ONLY.

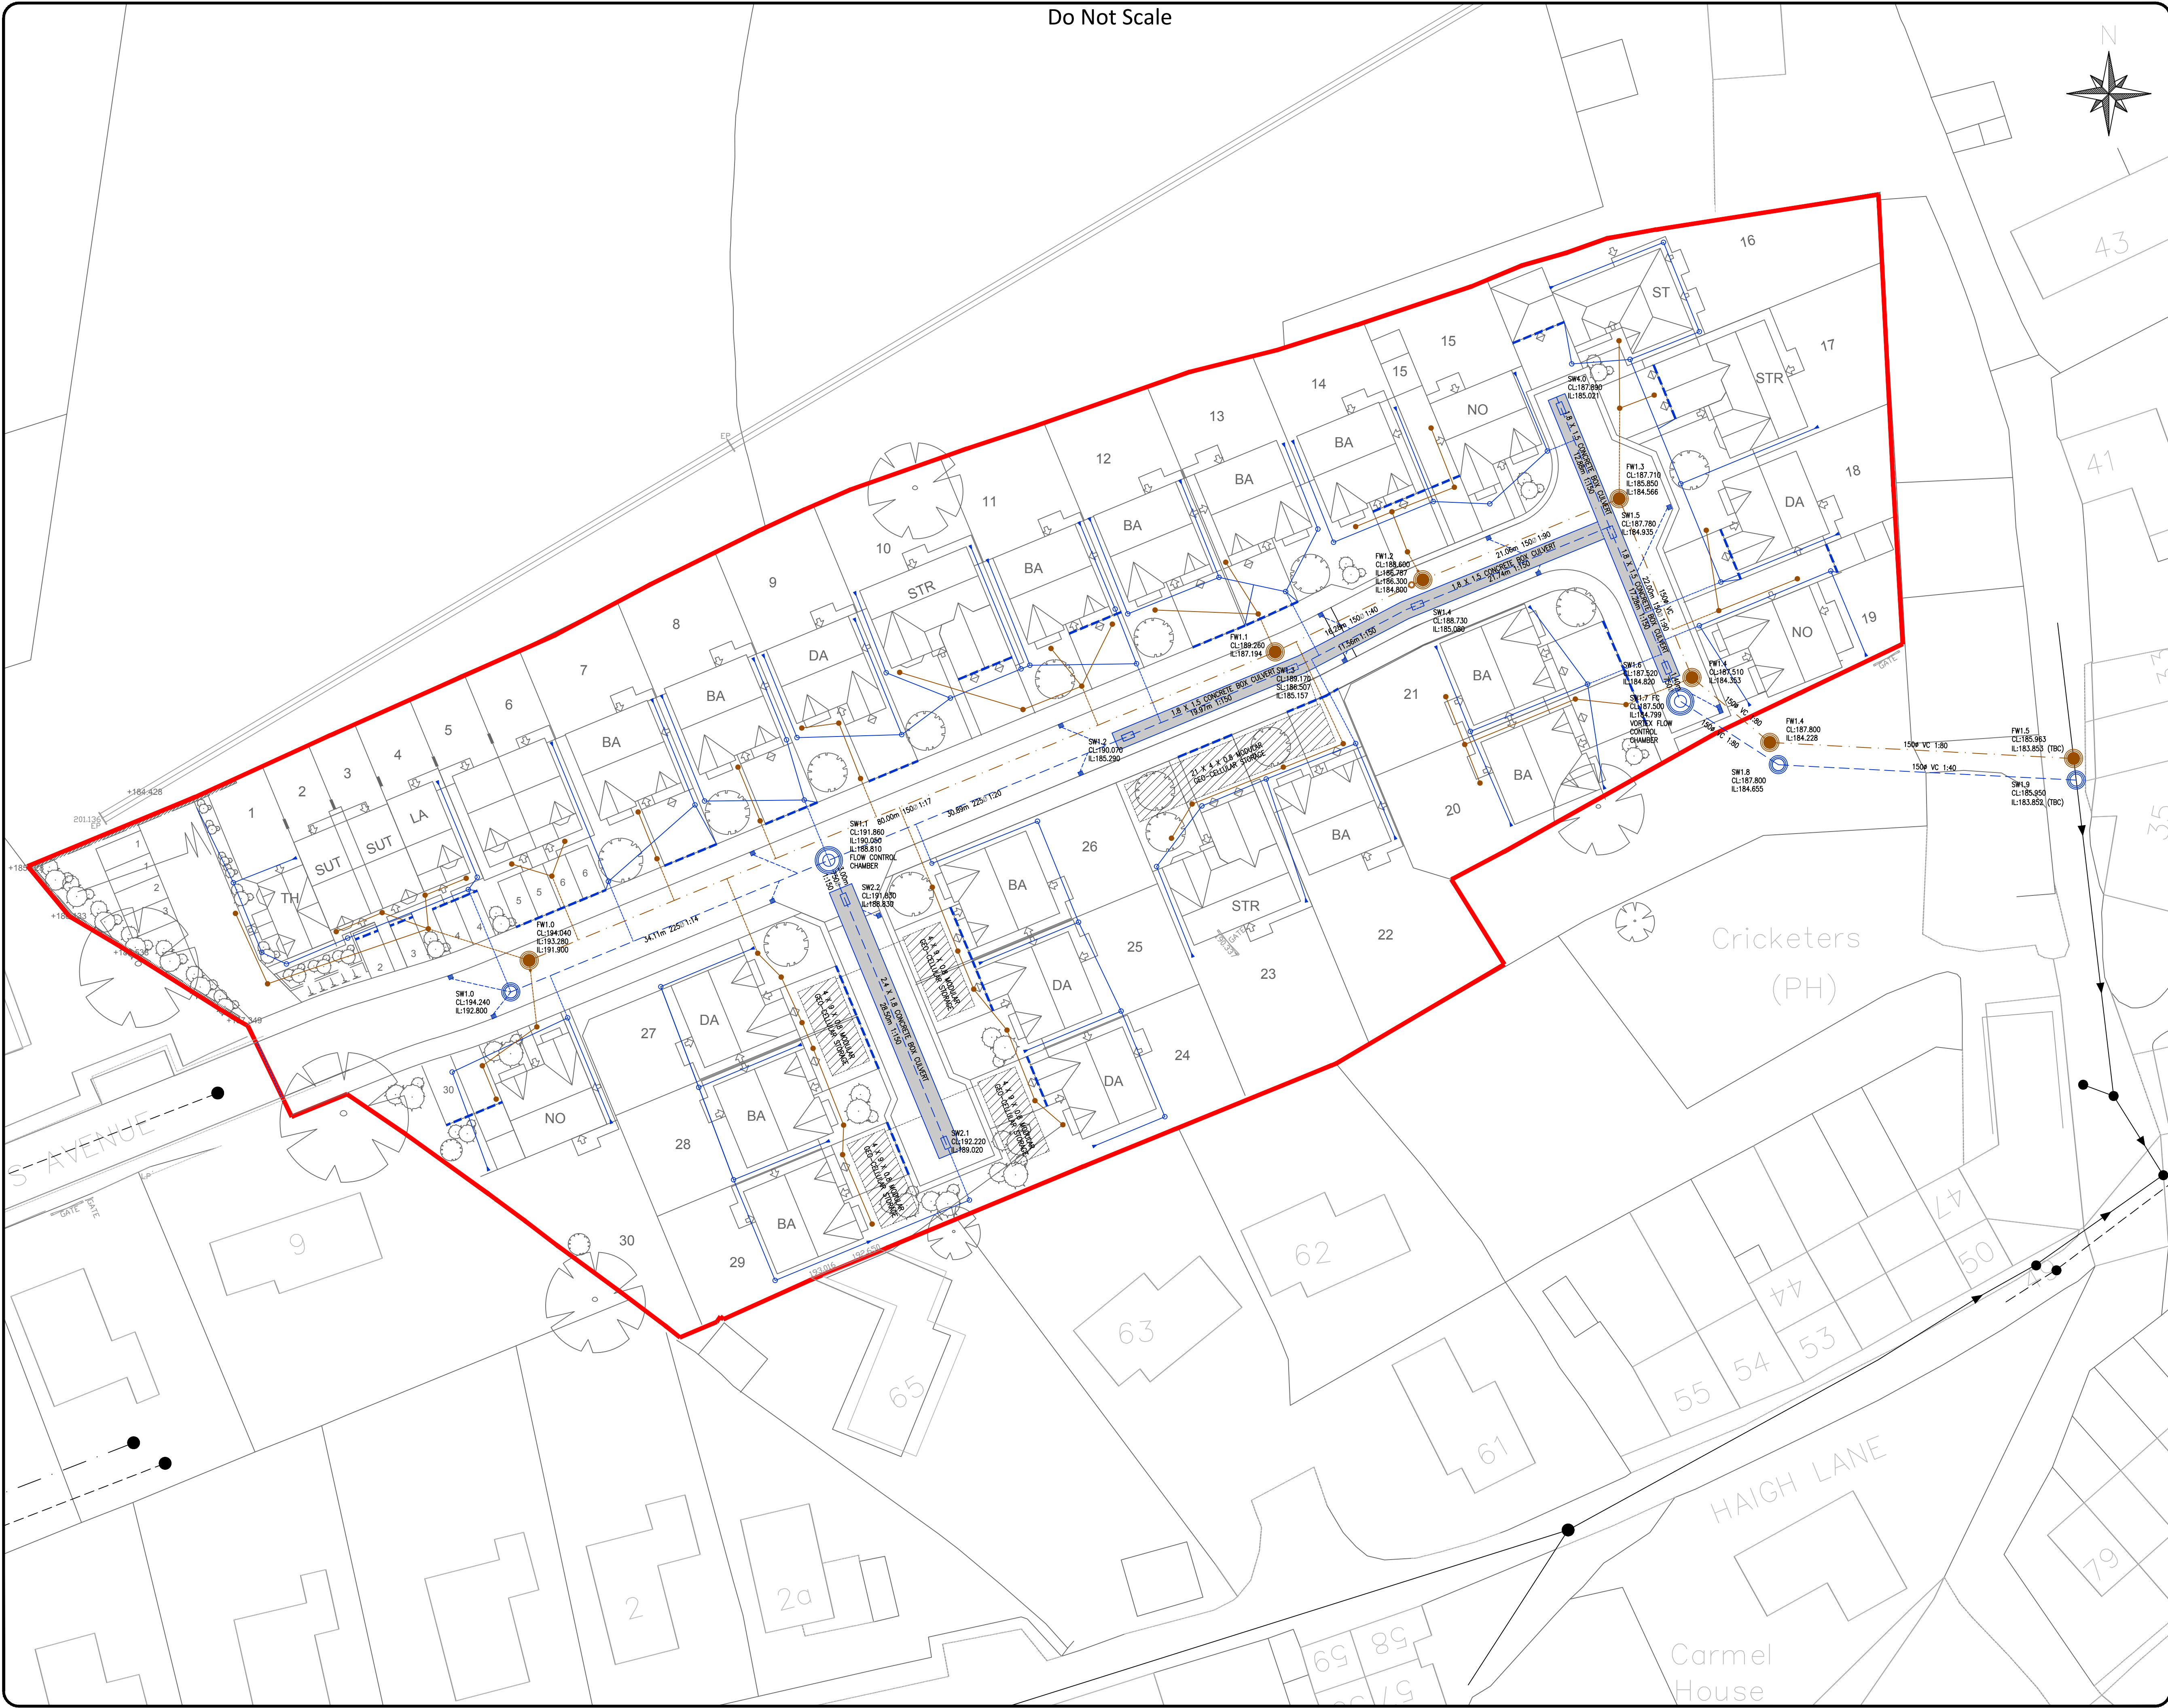

27/02/17	PRELIMINARY ISSUE	KB	VB	P1
Date	Revision	By	Chkd	Ref

dudleys
Structural & Civil Consultants

Suite 3, Tithe House
35 Town Street, Horsforth
Leeds, LS18 5LJ
Tel: 0113 258 3611
e-mail: info@dudleys.org.uk

Project
**ST MARY'S AVE,
NETHERTHONG,
JONES HOMES**

Title
**DRAINAGE LAYOUT
SITE WIDE**

Scale	NTS	Drawn	KB	Checked	VB
Date	FEB'17	Status	PRELIMINARY		
Drg. No.	16293/007				Rev. P1