
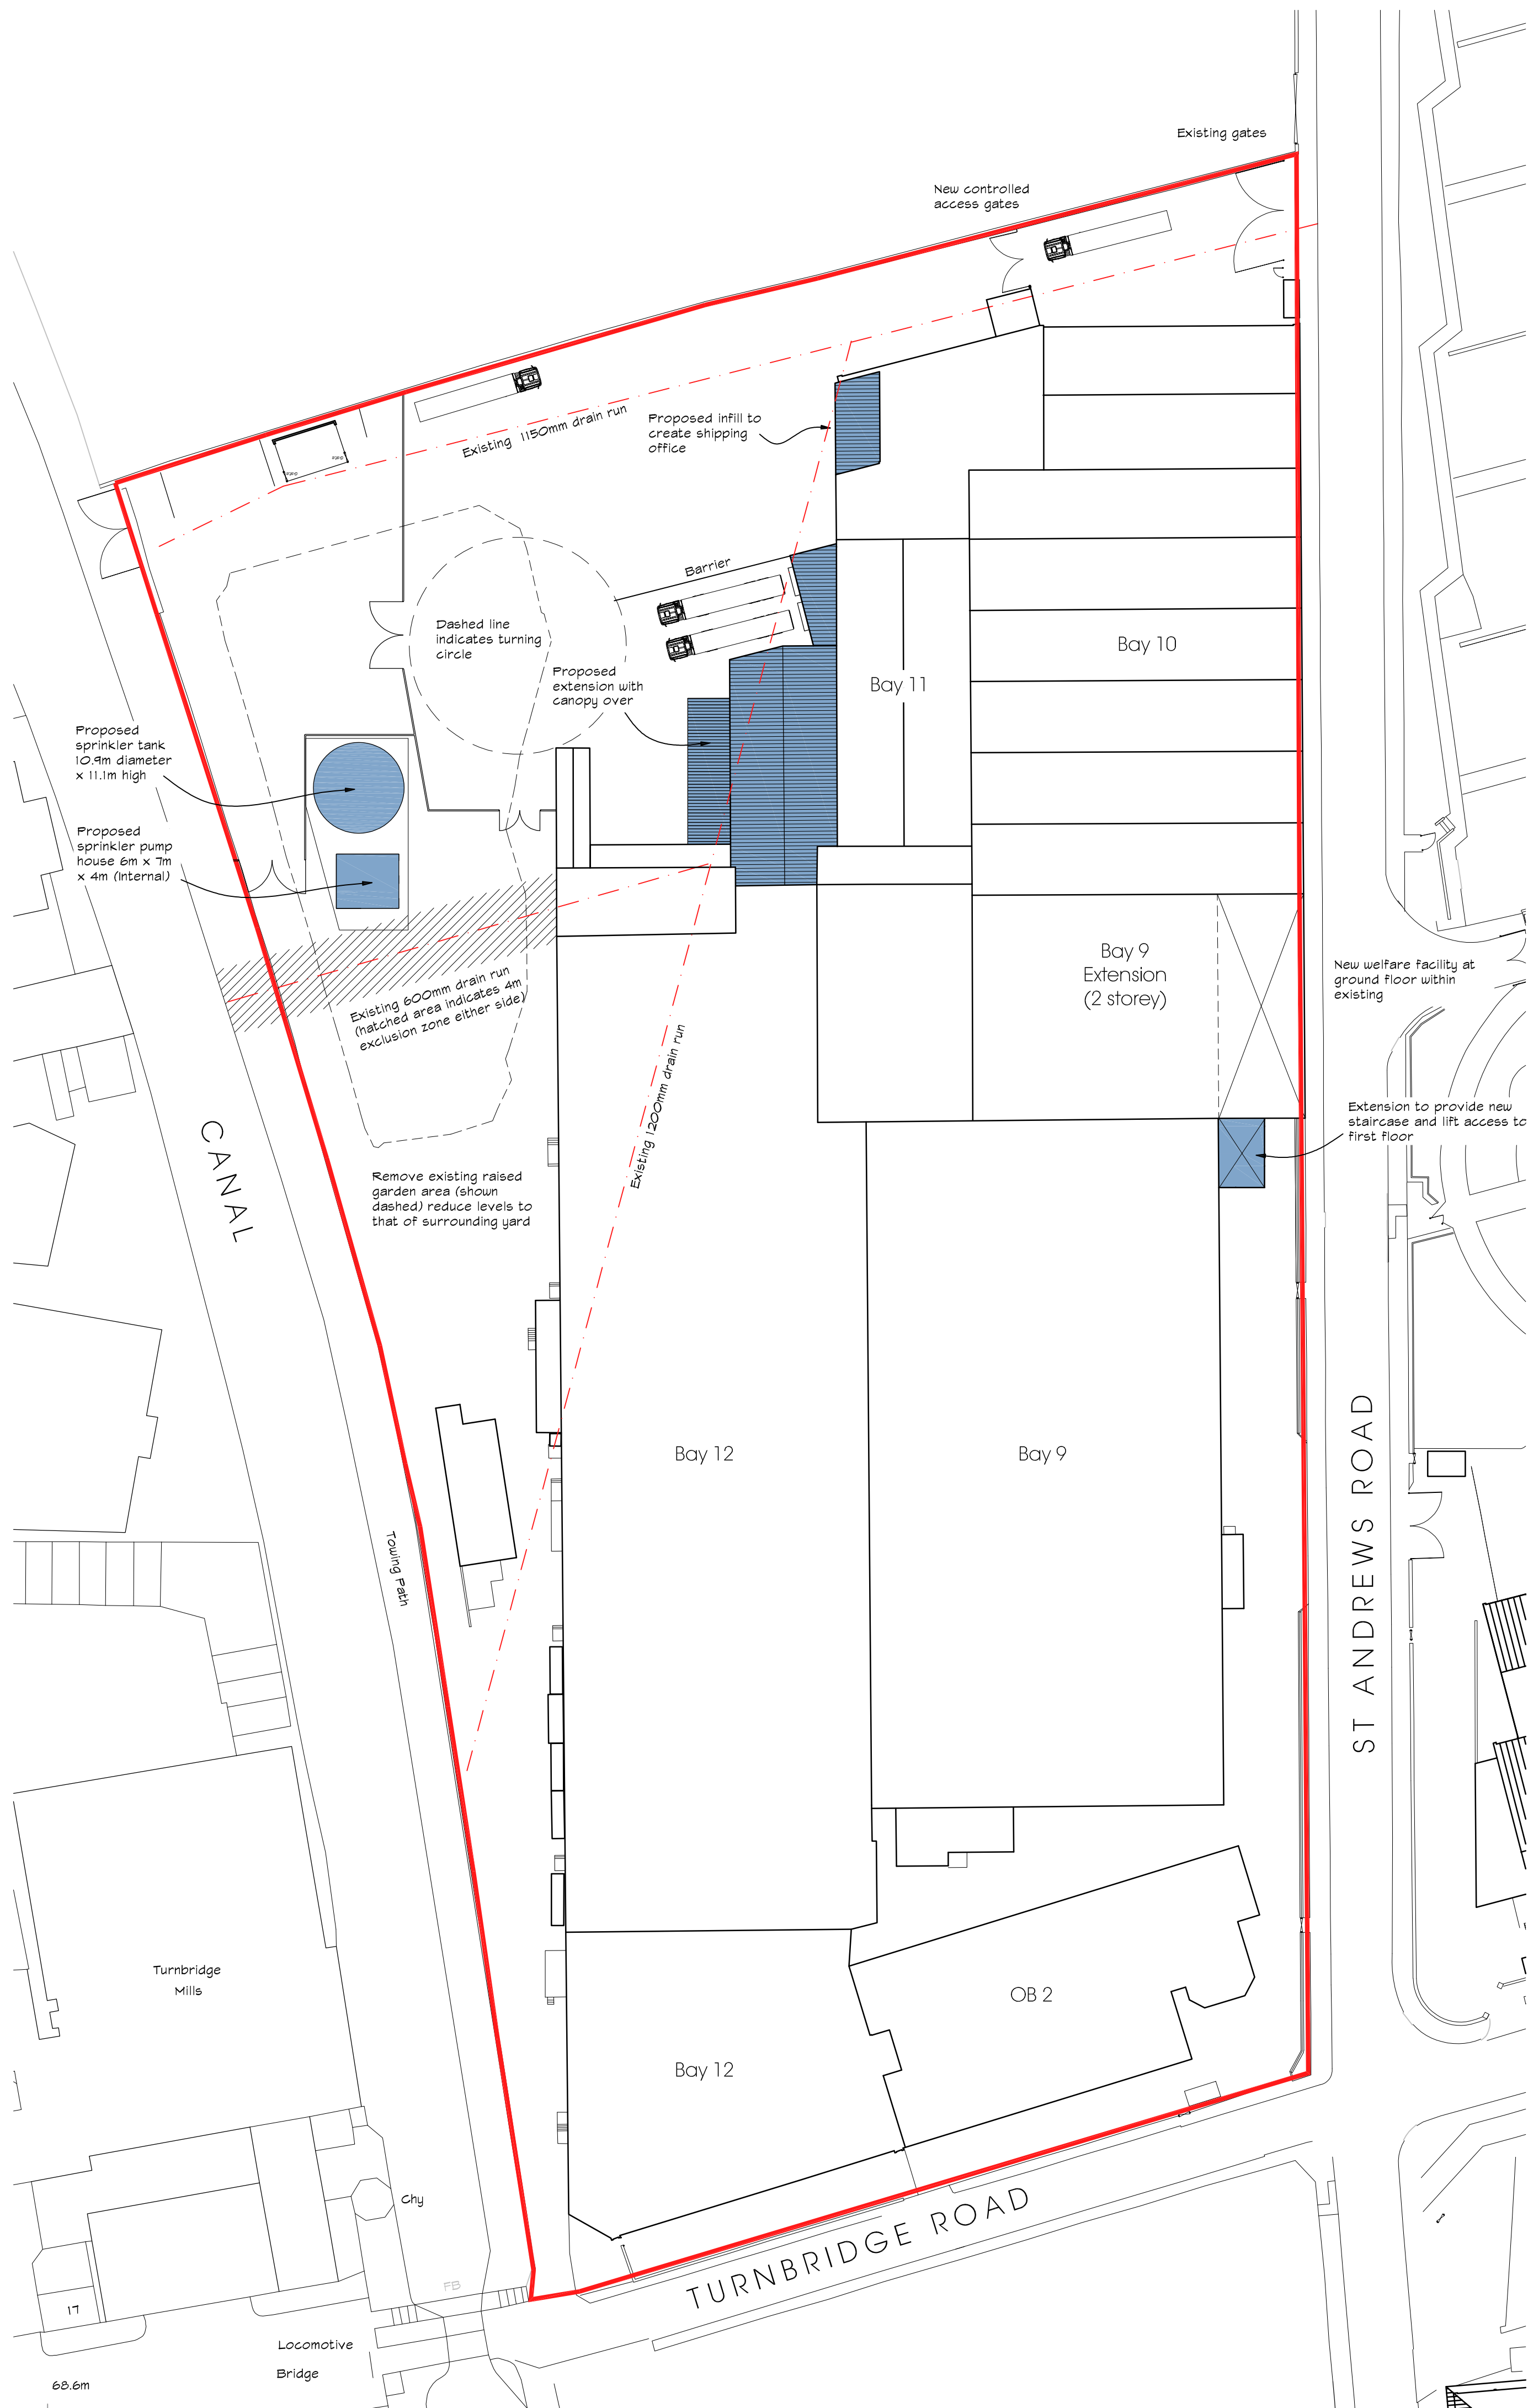


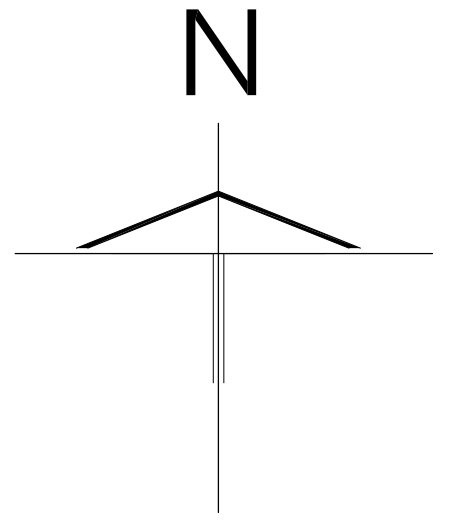

Rev.B: Sprinkler tank & pump house amended, exg drains added 22.08.17
Rev.A: Planning application drawing 15.06.17
Revision:

HTP Consolidation Project

at St Andrews Road
Huddersfield

for Cummins Turbo
Technologies Ltd

Site Plan

Farrar Bamforth Associates Ltd.

Chartered Architectural Technologists

51, Trinity Street, Huddersfield HD1 4DN
Tel. (01484) 424008 Fax. (01484) 512305
E-mail: design@farrarbamforth.co.uk
Website: www.farrarbamforth.co.uk

Drawn JHS

Date May 2016

Scales 1:500 @ A1

Drawing No. 16-C34-08

Rev. B