



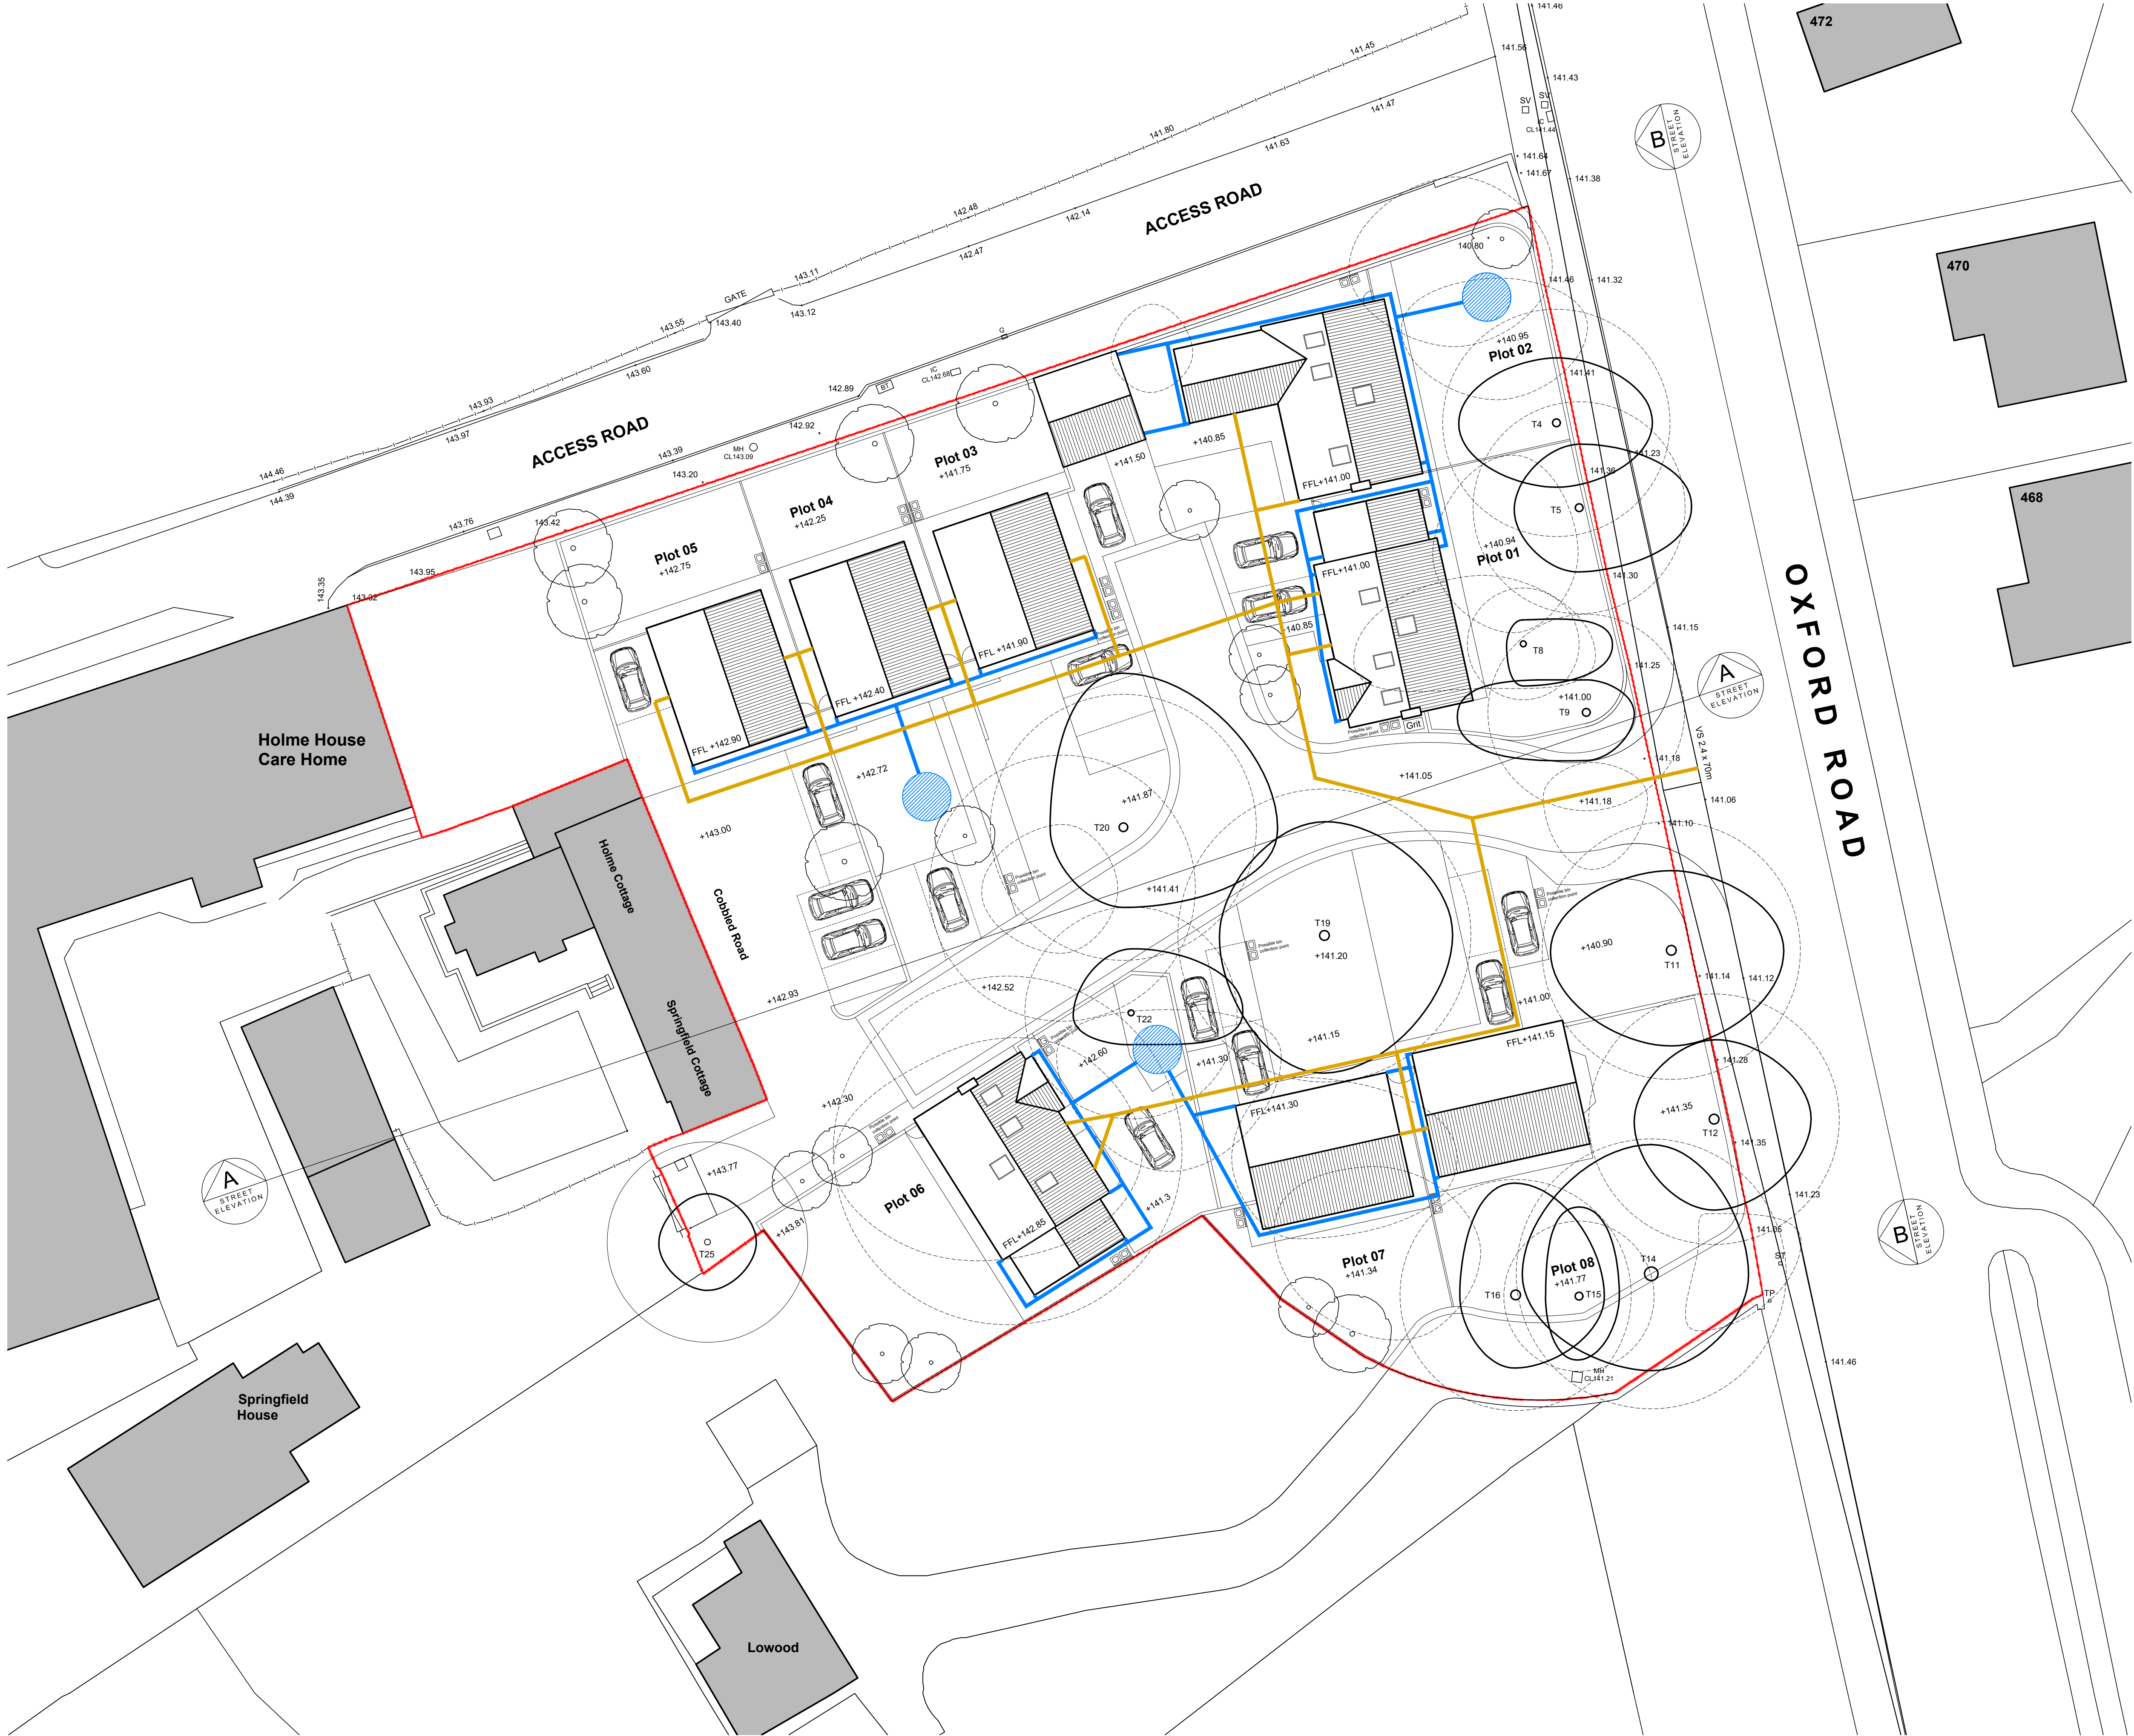

"For the purposes of Planning Consent the following applies to any copy of this drawing made by the Local Authority:
This copy has been made by and with the authority of the person required to make the plan and drawing open to public inspection pursuant to Section 47 of the Copyright, Designs and Patents Act 1988. Unless that Act provides a relevant exception to copyright, the copy must not be copied without the prior permission of the copyright owner. If any copy is made under the authority only the whole drawing including the copyright holder's name and this notice, is to be copied."

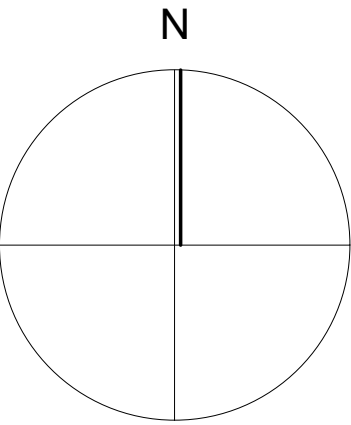

- Key
- Indicative Foul Route
 - Indicative Surface Water Route
 - Soakaway [5m from dwelling]



Rev C: 21.06.2018: Levels around T19, T20 and T22 increased by 200mm and the FFL to plots 7 & 8 lifted
Rev B: 16.06.2018: Road widened, grit box added, 3 spaces shown for plots 7 & 8 and refuse collection areas shown
Rev A: 02.06.2018: T21 removed

Issue Purpose: PLANNING APPLICATION

AHJ architects
The Courtyard
12a Commercial Road
Skelmanthorpe
Huddersfield
HD8 8AA
www.ahjarchitects.co.uk

t | 07968944840
e | info@ahjarchitects.co.uk

AHJ
architects

Client	Mr Cregan	Issued From	
Project	1626 Holme House Residential	Date	April 18
Title	Indicative Drainage Layout	Scale	1:200 @ A1
Drawn	BH	Auth	BH
Drawing Number	Revision		
1626 - D - 20 - 005	- C		

Do not scale from this drawing. Work to figure dimensions, and any discrepancy to be reported to the Architect.
Refer to larger scale drawings where available.

INDICATIVE DRAINAGE LAYOUT 1:200 @ A1