

KEY

----- FIRE COMPARTMENTATION

 WATER EXTINGUISHER

 FOAM EXTINGUISHER

 FIRE ALARM CONTROL PANEL

S SMOKE DETECTOR

K HEAT DETECTOR


**INTEGRAL SOUNDER AND
CALL POINT UNIT**

FS30 HALF-HOUR FIRE AND
SC SMOKE RESISTING
SELF-CLOSING DOOR

FS30 HALF-HOUR FIRE AND SMOKE RESISTING DOOR TO BE KEPT SHUT


FS20 TWENTY MINUTE FIRE AND
SMOKE RESISTING DOOR
TO BE KEPT SHUT

 EMERGENCY LIGHT UNIT

 EXTERNAL ESCAPE LIGHTING

ES(1) FIRE EXIT SIGN OVER
DOOR (LUMINOUS TYPE)
ADJACENT TO EMERGENCY
LIGHT FITTING WITH
DIRECTION ARROW

ES(2) FIRE EXIT SIGN OVER
DOOR (LUMINOUS TYPE)
ADJACENT TO EMERGENCY
LIGHT FITTING

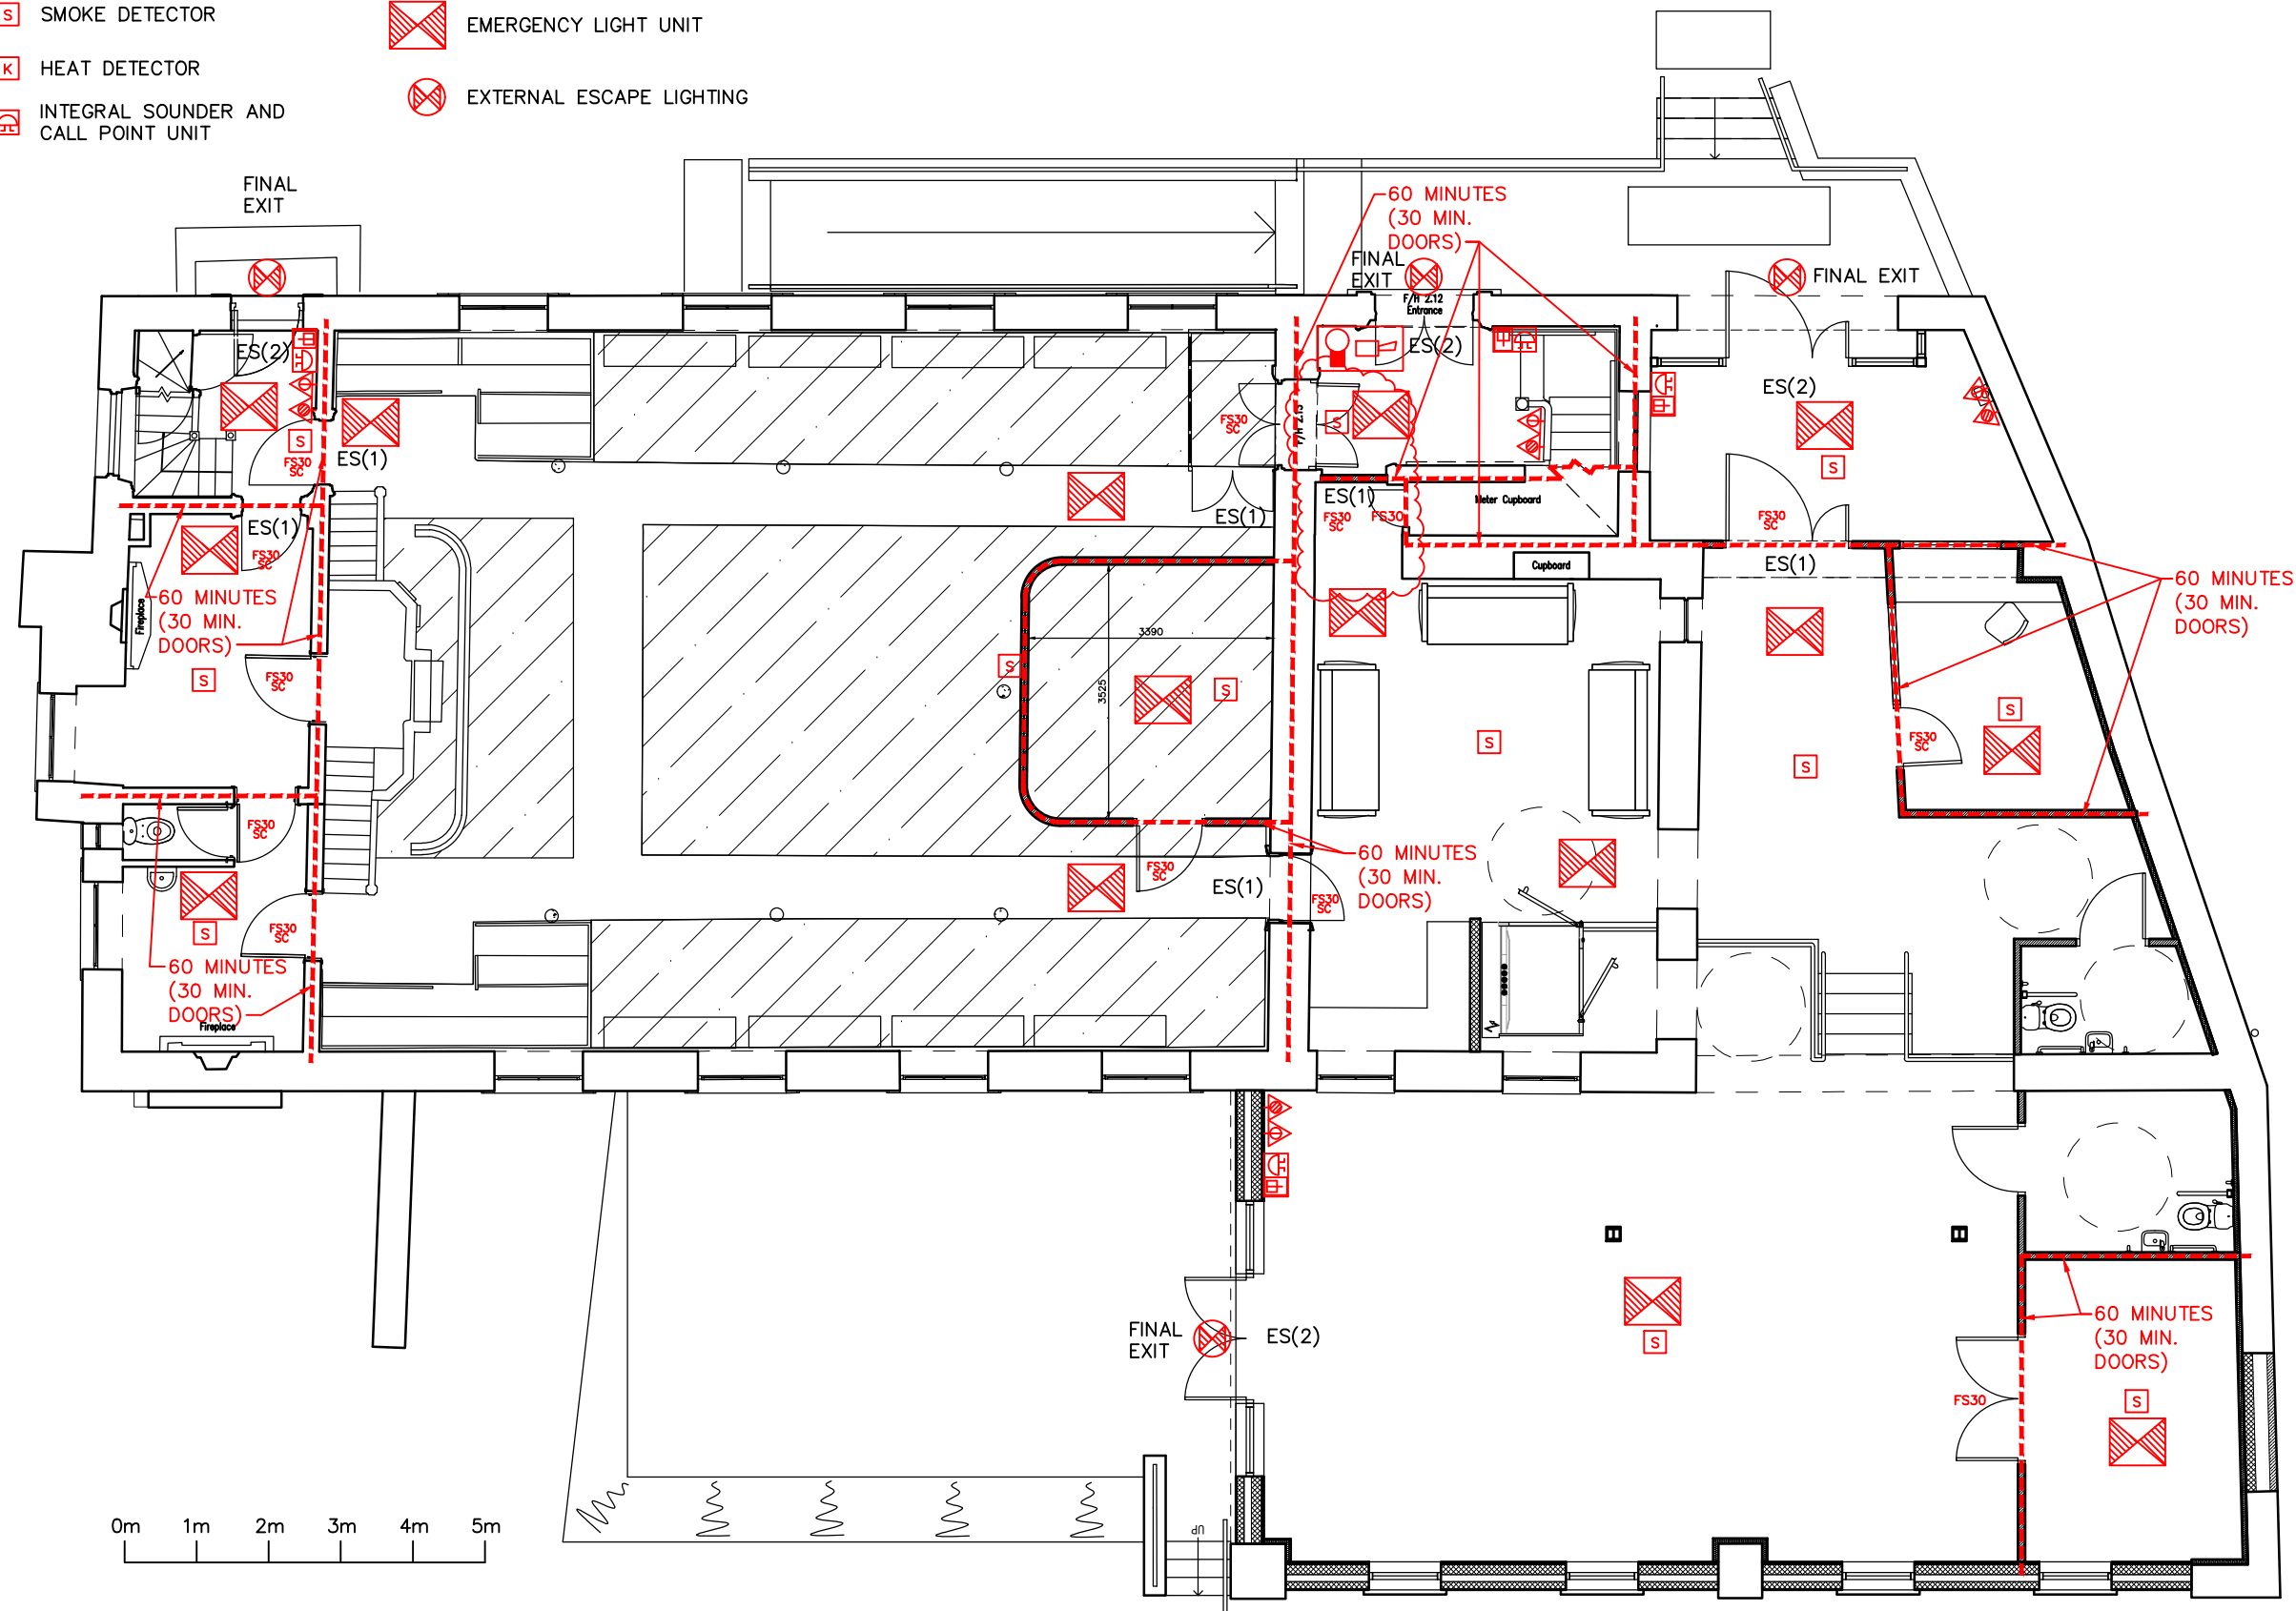

Notes.

- All dimensions to be checked on site.
- No dimensions to be scaled from this drawing unless otherwise stated.

B	27.08.19	FLOOR PLAN UPDATED.			S
A	02.08.19	THE STRATEGY PLAN UPDATED WITH NEW PARTITION BETWEEN MEETING ROOM AND LOBBY TO NEW FLAT INDICATED			S
Revision No. Date			Checked By Date		D

**BYROM
CLARK
ROBERTS**

ARCHITECTS / SURVEYORS / ENGINEERS

MacLaren House | Talbot Road | Old Trafford | Manchester | M32 0FP
 0161 875 0600 | manchester@bcmet.eu | www.byromclarkroberts.com
 First Floor | Swan House | Russell Street | Chester | CH3 5AL
 01244 348849 | chester@bcmet.eu | www.byromclarkroberts.com
 Unit 2 (Millwright) | 49 Byron Street | Leeds | LS2 7NA
 0113 388 8000 | leeds@bcmet.eu | www.byromclarkroberts.com

Client: SHABANG INCLUSIVE
LEARNING LTD
SLAITHWAITE

Project:
FORMER PROVIDENCE
BAPTIST CHAPEL
CONVERSION WORKS

Drawing Title.

GROUND FLOOR FIRE STRATEGY
PLAN

Scale.	Date.	Drawn.	Check.
1:100 @A3	05 19	SLW	

Job No.	Drawing No.	Rev.
5117/0953	34	B