


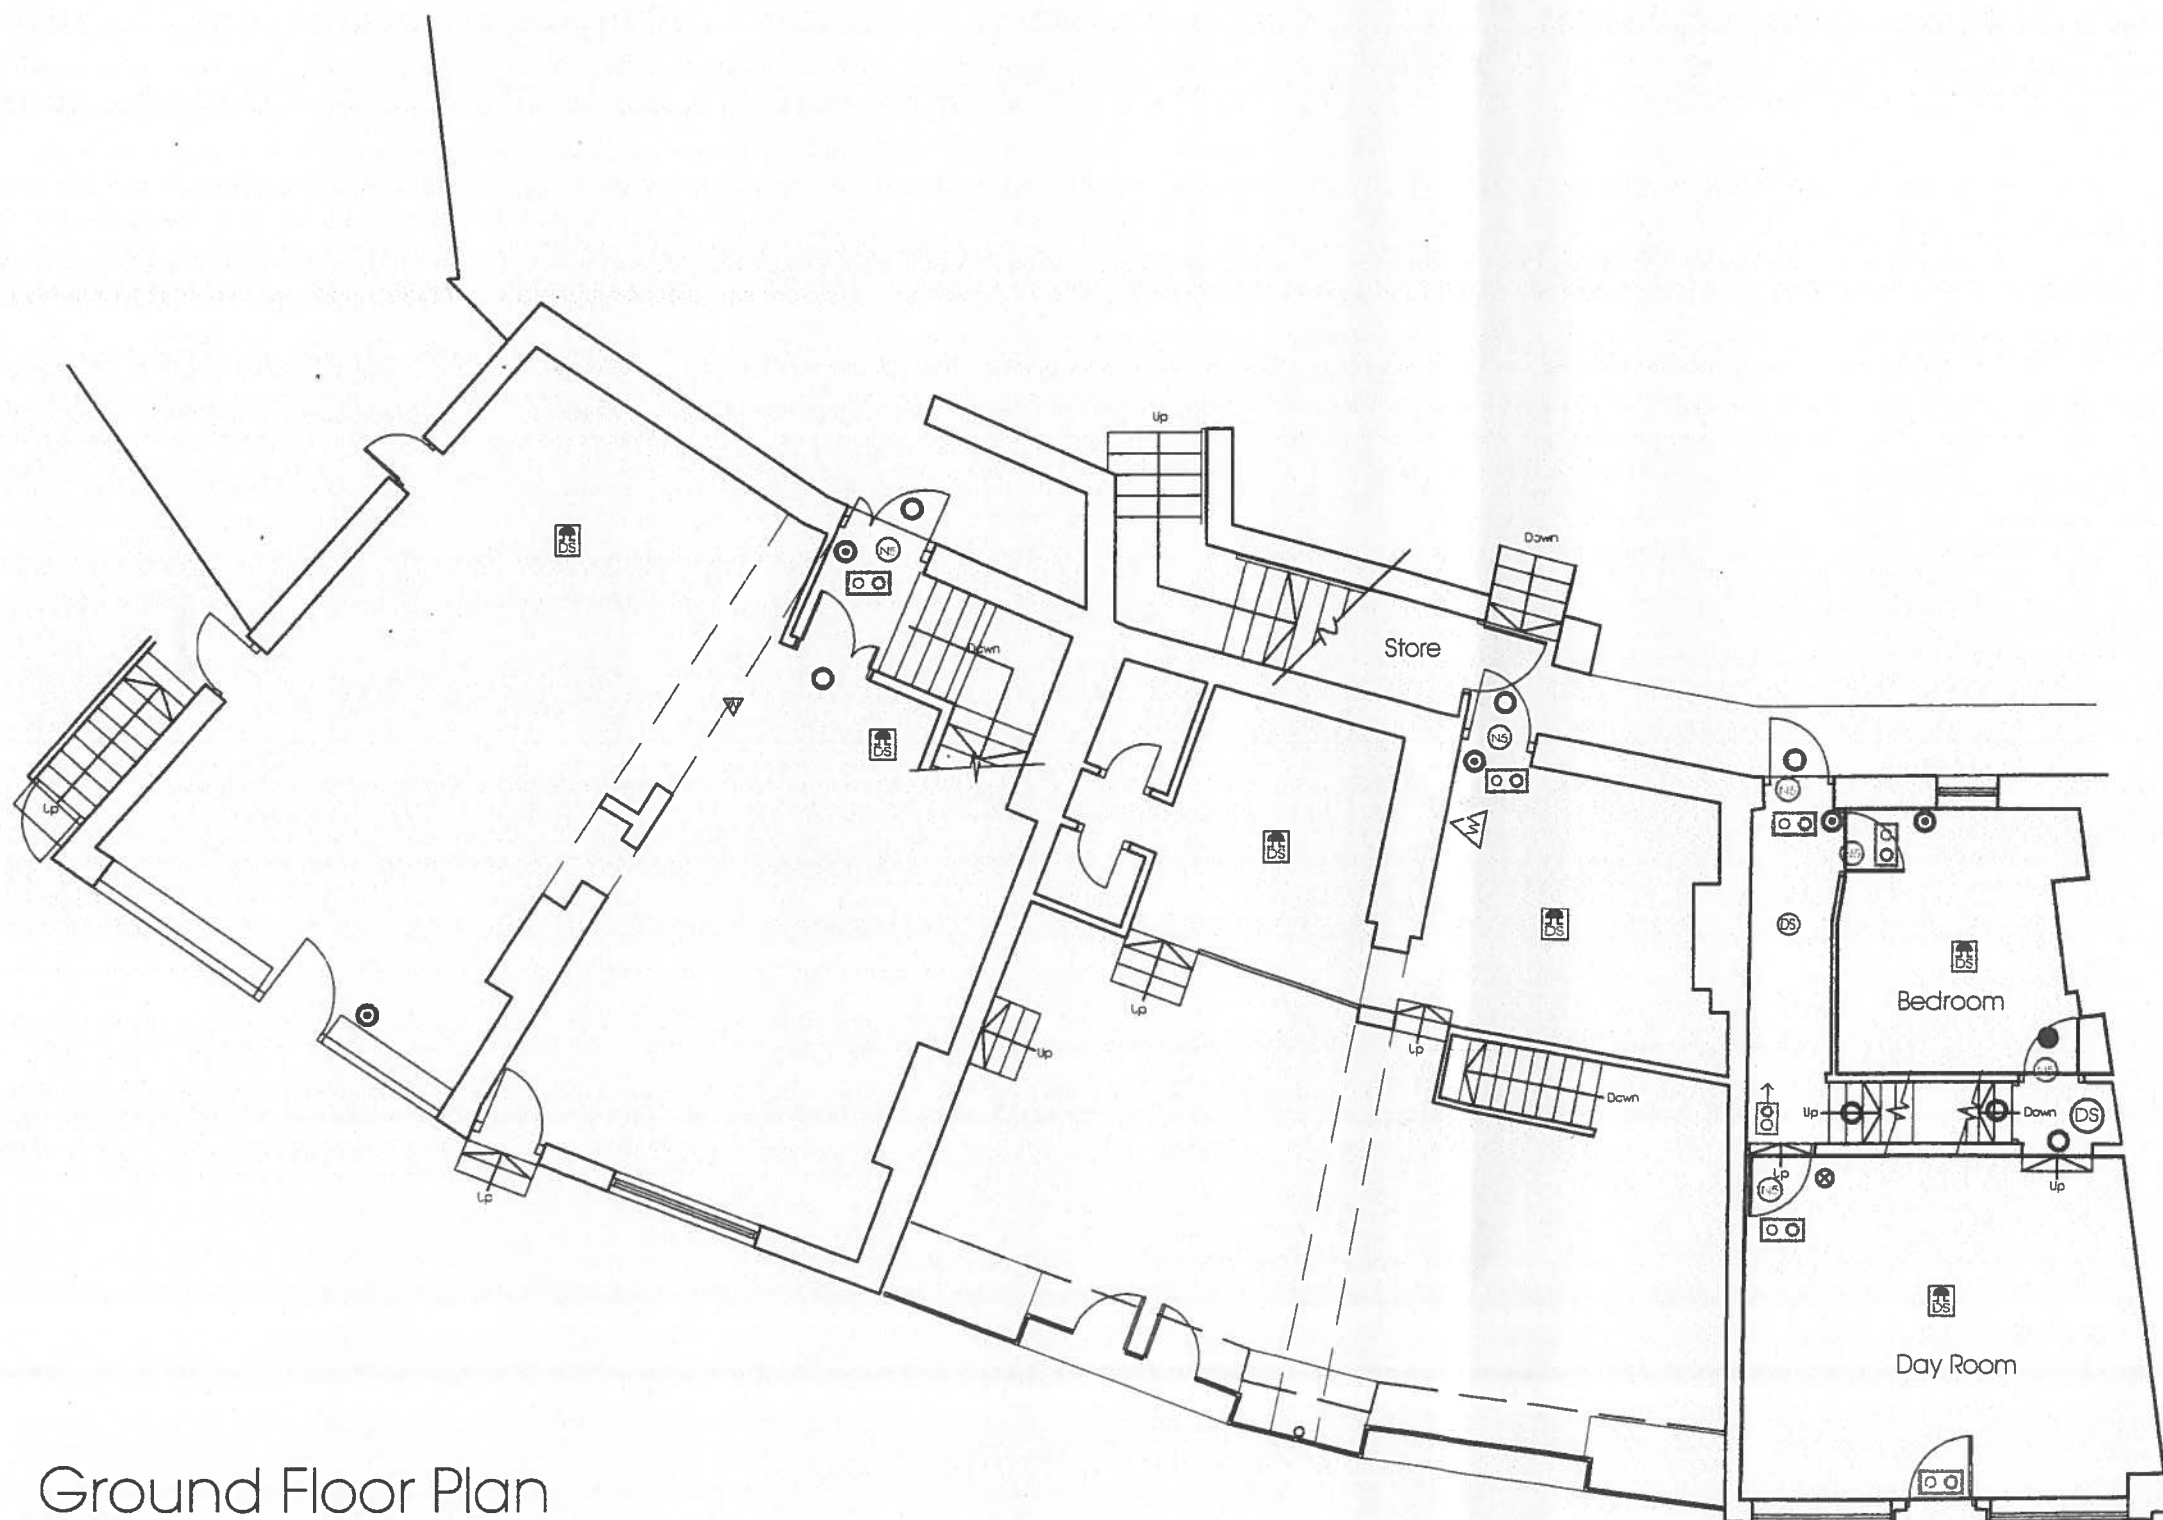

KEY

- | | | | |
|------|--|------|-----------------------------------|
| (DS) | Automatic fire detection smoke | (N3) | Notice: keep locked shut |
| (DS) | Automatic fire detection smoke - with sounder | (N5) | Notice: fire exit keep clear |
| (DS) | Automatic fire detection smoke in ceiling void | (N7) | Notice: Fire door - keep shut |
| (DH) | Automatic fire detection heat | ↓ | Illuminated exit directional sign |
| ⊙ | Fire alarm call point | ⊗ | E60Sa/FD60S Fire door |
| 🔊 | Sounder | ● | E30Sa/FD30S Fire door |
| 🔊 | audible warning device link from Central Lodge | | |
| (IP) | Fire alarm indicator pannel | | |
| △W | Water Fire extinguisher | | |
| △Co2 | Co2 fire extinguisher | | |
| △P | Powder fire extinguisher | | |
| ○ | Emergency lighting | | |

The Huddersfield Central Mews
at 31-37 Beast Market
and 1, Southgate
Huddersfield

Ground Floor

Farrar Bamforth Associates Ltd.

Architectural & Building Consultants

51, Trinity Street, Huddersfield HD1 4DN
Tel. (01484) 424008 Fax. (01484) 512305
E-mail : design@farrarbamforth.co.uk
Website : www.farrarbamforth.co.uk

Drawn DRH

Date March 2013

Scales 1:100

Drawing No. 13/C10/04

Ground Floor Plan