


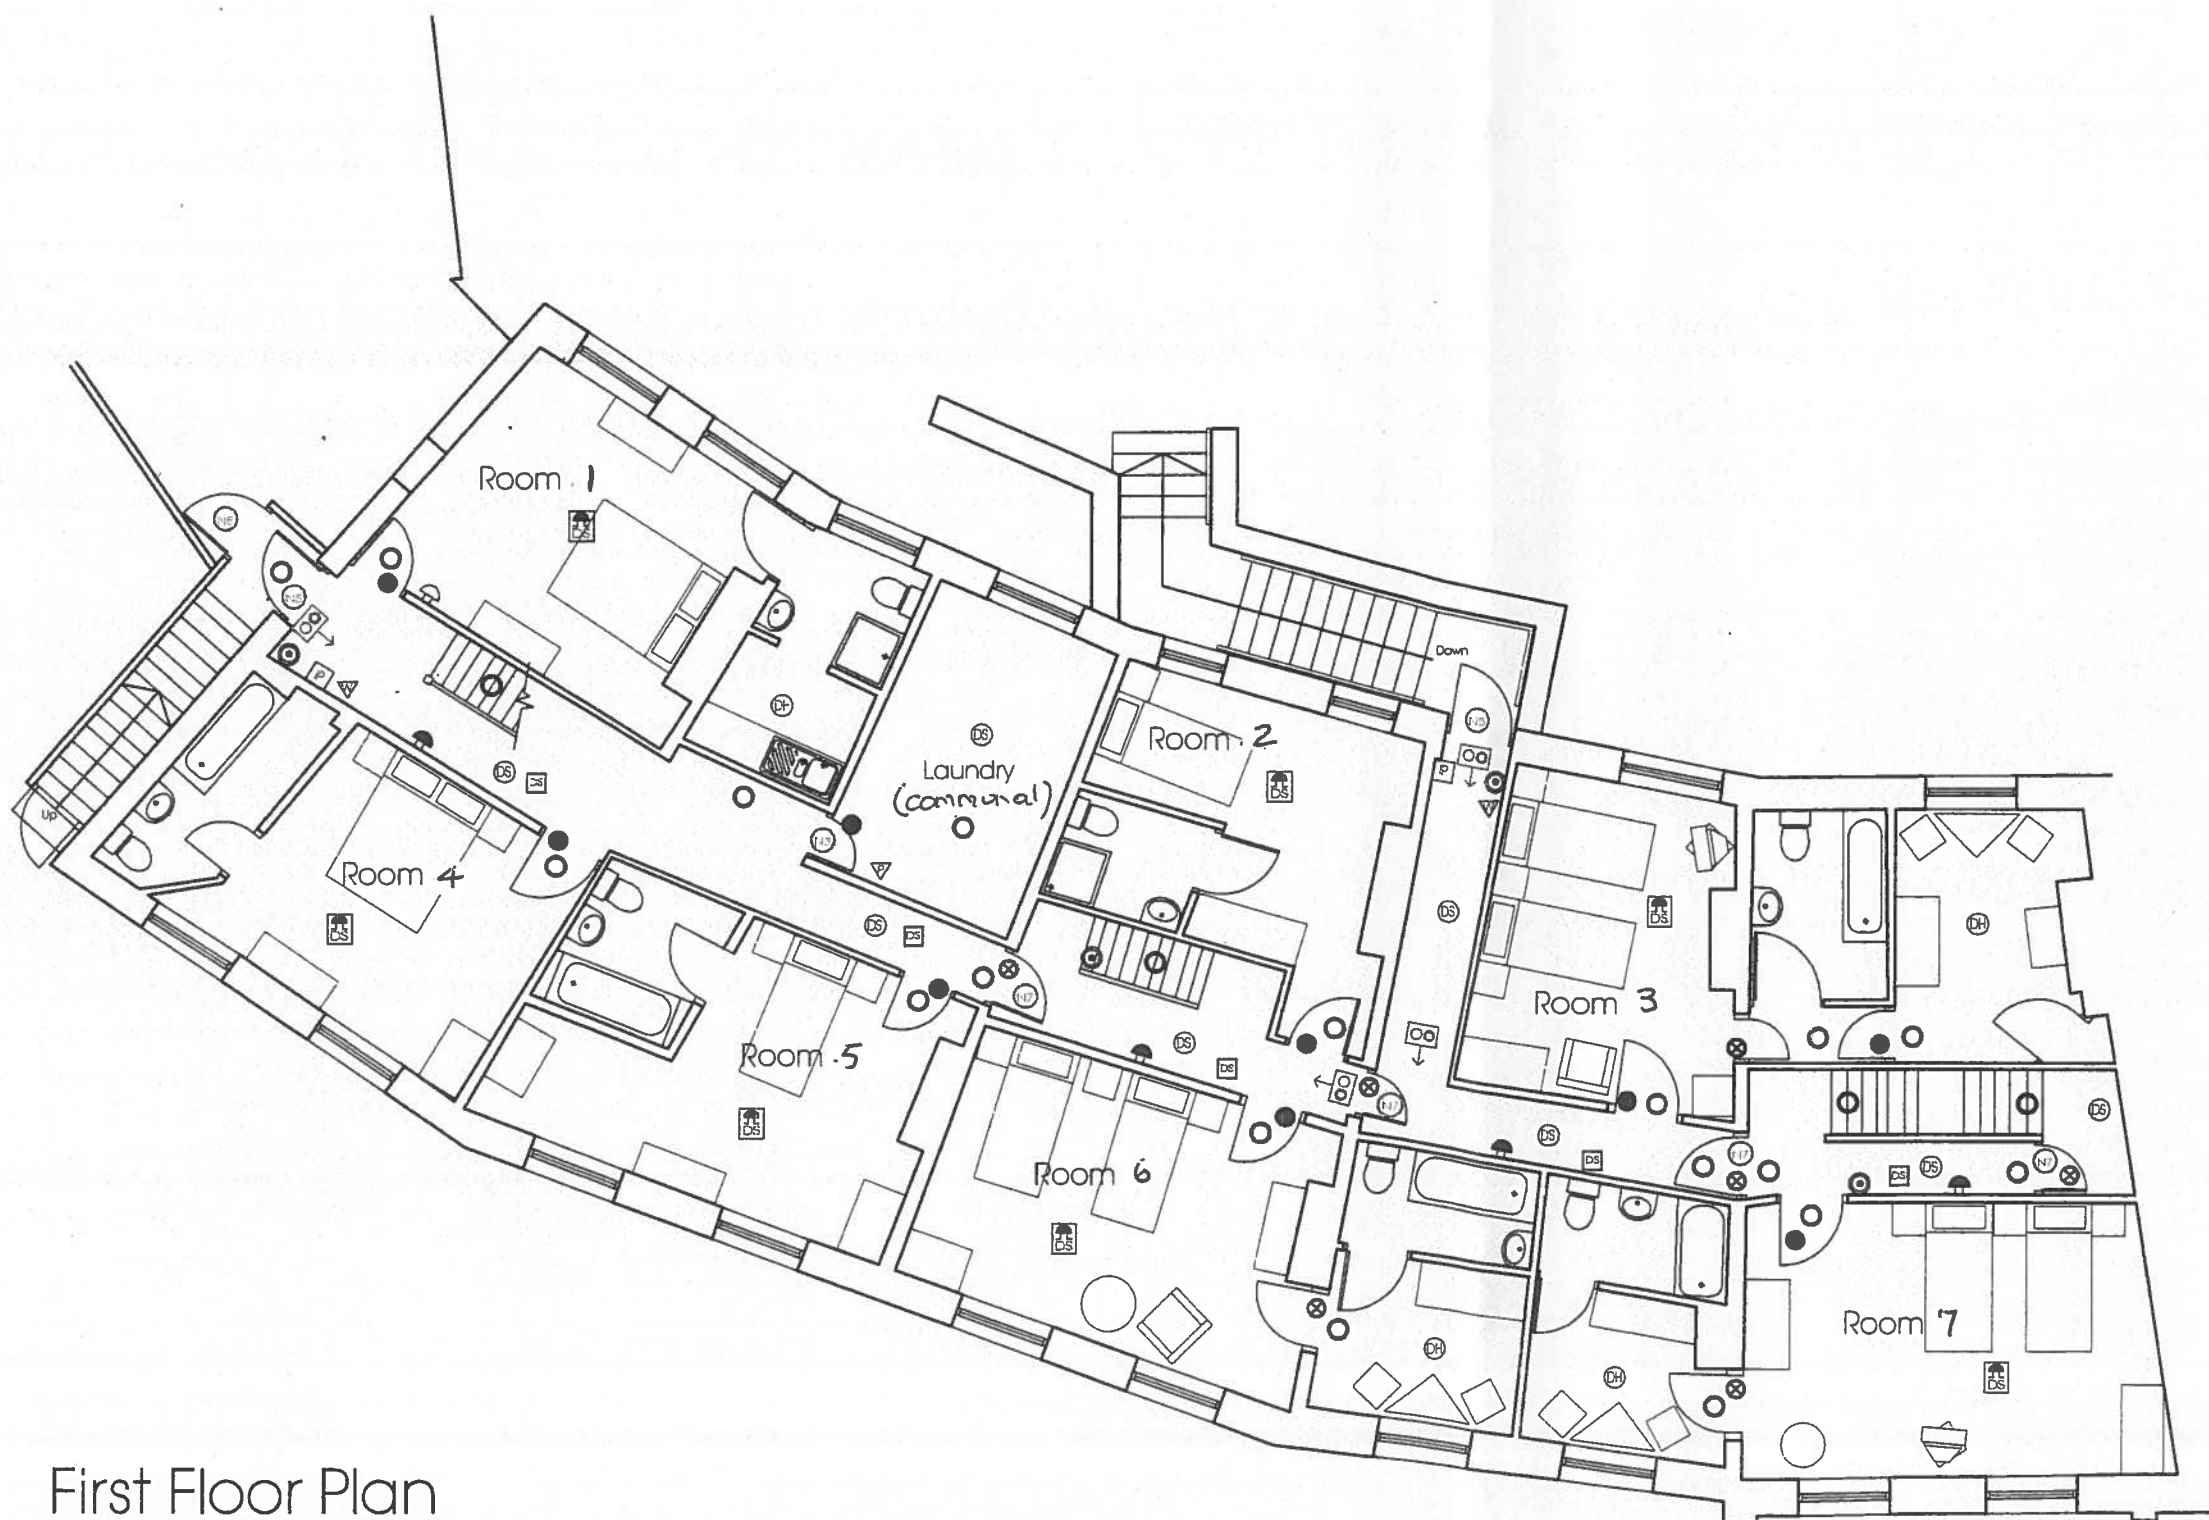

KEY

(DS)	Automatic fire detection smoke	(N3)	Notice: keep locked shut
(DS)	Automatic fire detection smoke - with sounder	(N5)	Notice: fire exit keep clear
(DS)	Automatic fire detection smoke in ceiling void	(N7)	Notice: Fire door - keep shut
(DH)	Automatic fire detection heat	(O)	Illuminated exit directional sign
(C)	Fire alarm call point	(X)	E60Sa/FD60S Fire door
(S)	Sounder	(●)	E30Sa/FD30S Fire door
(L)	audible warning device link from Central Lodge		
(IP)	Fire alarm indicator pannel		
(W)	Water Fire extinguisher		
(Co2)	Co2 fire extinguisher		
(P)	Powder fire extinguisher		
(O)	Emergency lighting		

The Huddersfield Central Mews
at 31-37 Beast Market
and 1 Southgate
Huddersfield

First Floor Plan

Farrar Bamforth Associates Ltd.

Architectural & Building Consultants

51, Trinity Street, Huddersfield HD1 4DN
Tel. (01484) 424008 Fax. (01484) 512305
E-mail : design@farrarbamforth.co.uk
Website : www.farrarbamforth.co.uk

Drawn DRH

Date March 2013

Scales 1:100

Drawing No 13/C10/05

First Floor Plan