


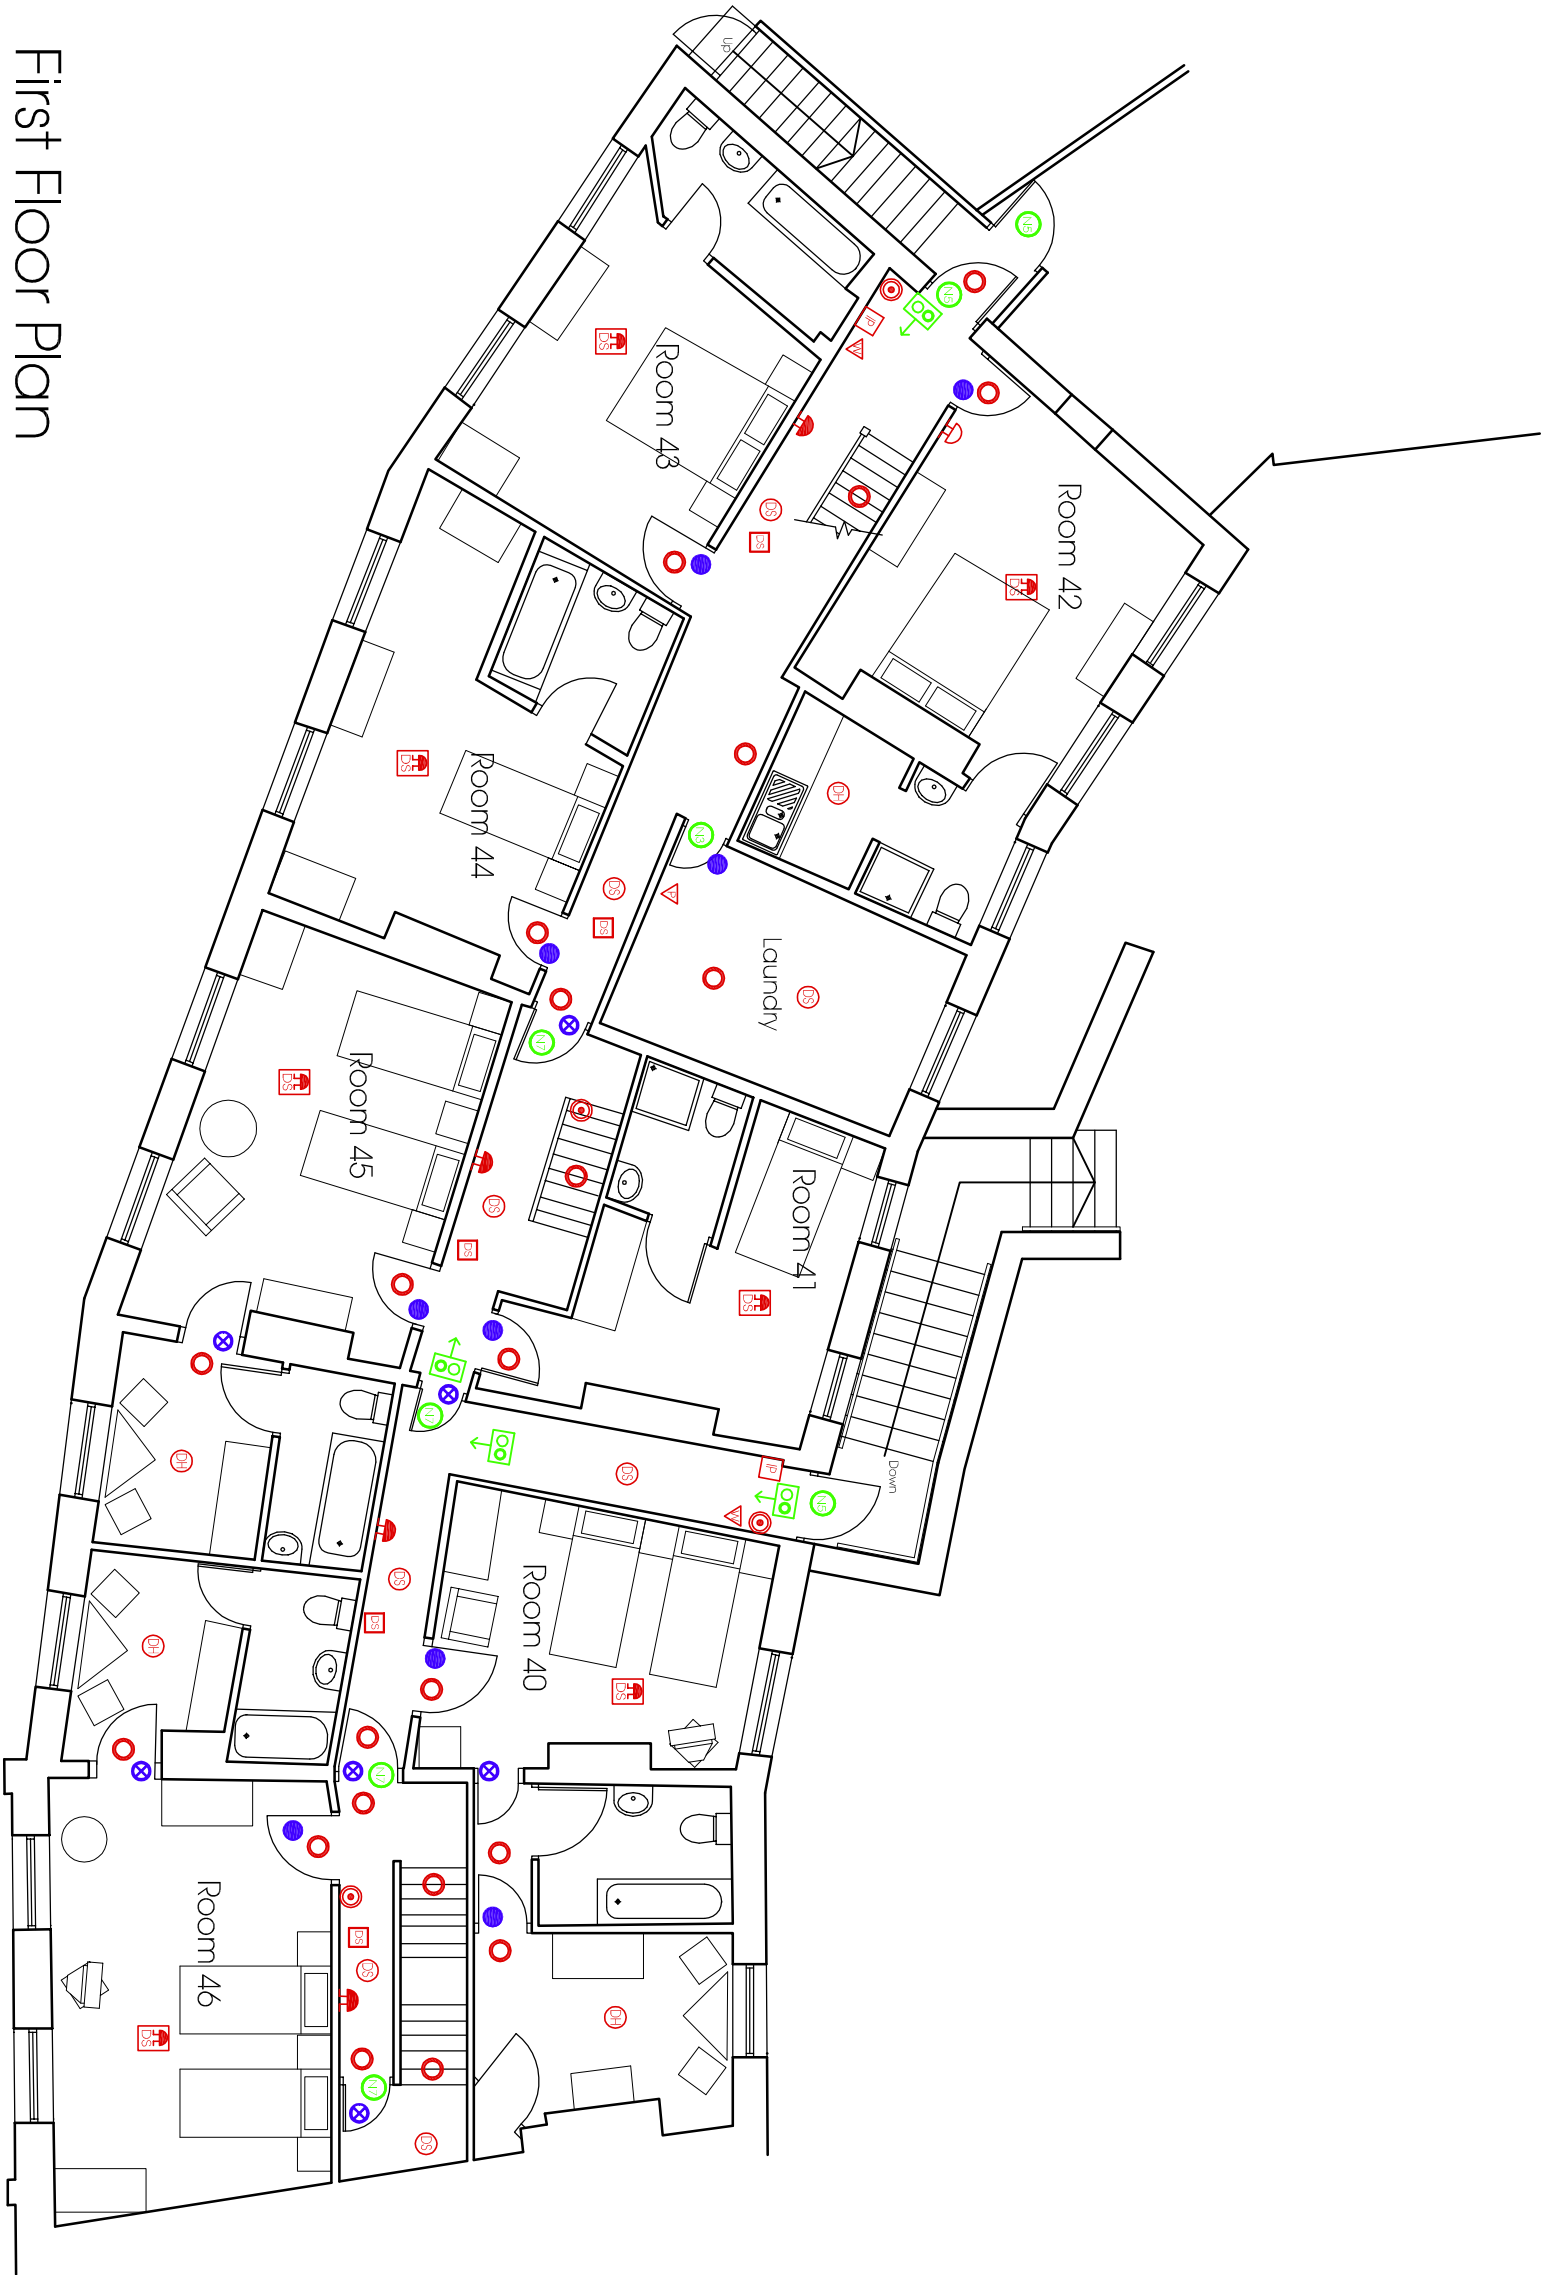

First Floor Plan

KEY	
	Automatic fire detection smoke
	Notice: keep locked shut
	Automatic fire detection smoke - with sounder
	Notice: fire exit keep clear
	Automatic fire detection smoke in ceiling void
	Notice: Fire door - keep shut
	Automatic fire detection heat
	Illuminated exit directional sign
	Fire alarm call point
	E60Sd/FD60S Fire door
	Sounder
	E30Sd/FD30S Fire door
	audible warning device link from Central Lodge
	Fire alarm Indicator pannel
	Water Fire extinguisher
	Co2 fire extinguisher
	Powder fire extinguisher
	Emergency lighting

Conversion to Bedroom Wing at
The Huddersfield Central Mews
at 31-37 Beast Market
and 1 Southgate
Huddersfield

for Johnny's Caterer's

First Floor Plan
Licencing Plans

Farrar Bamforth Associates Ltd.

Architectural & Building Consultants
51, Trinity Street, Huddersfield HD1 4DN
Tel: (01484) 424008 Fax: (01484) 512305
E-mail: design@farrarbamforth.co.uk
Website: www.farrarbamforth.co.uk

Drawn	DRH
Date	March 2013
Scales	1:100
Drawing No.	13/C10/05
	-