


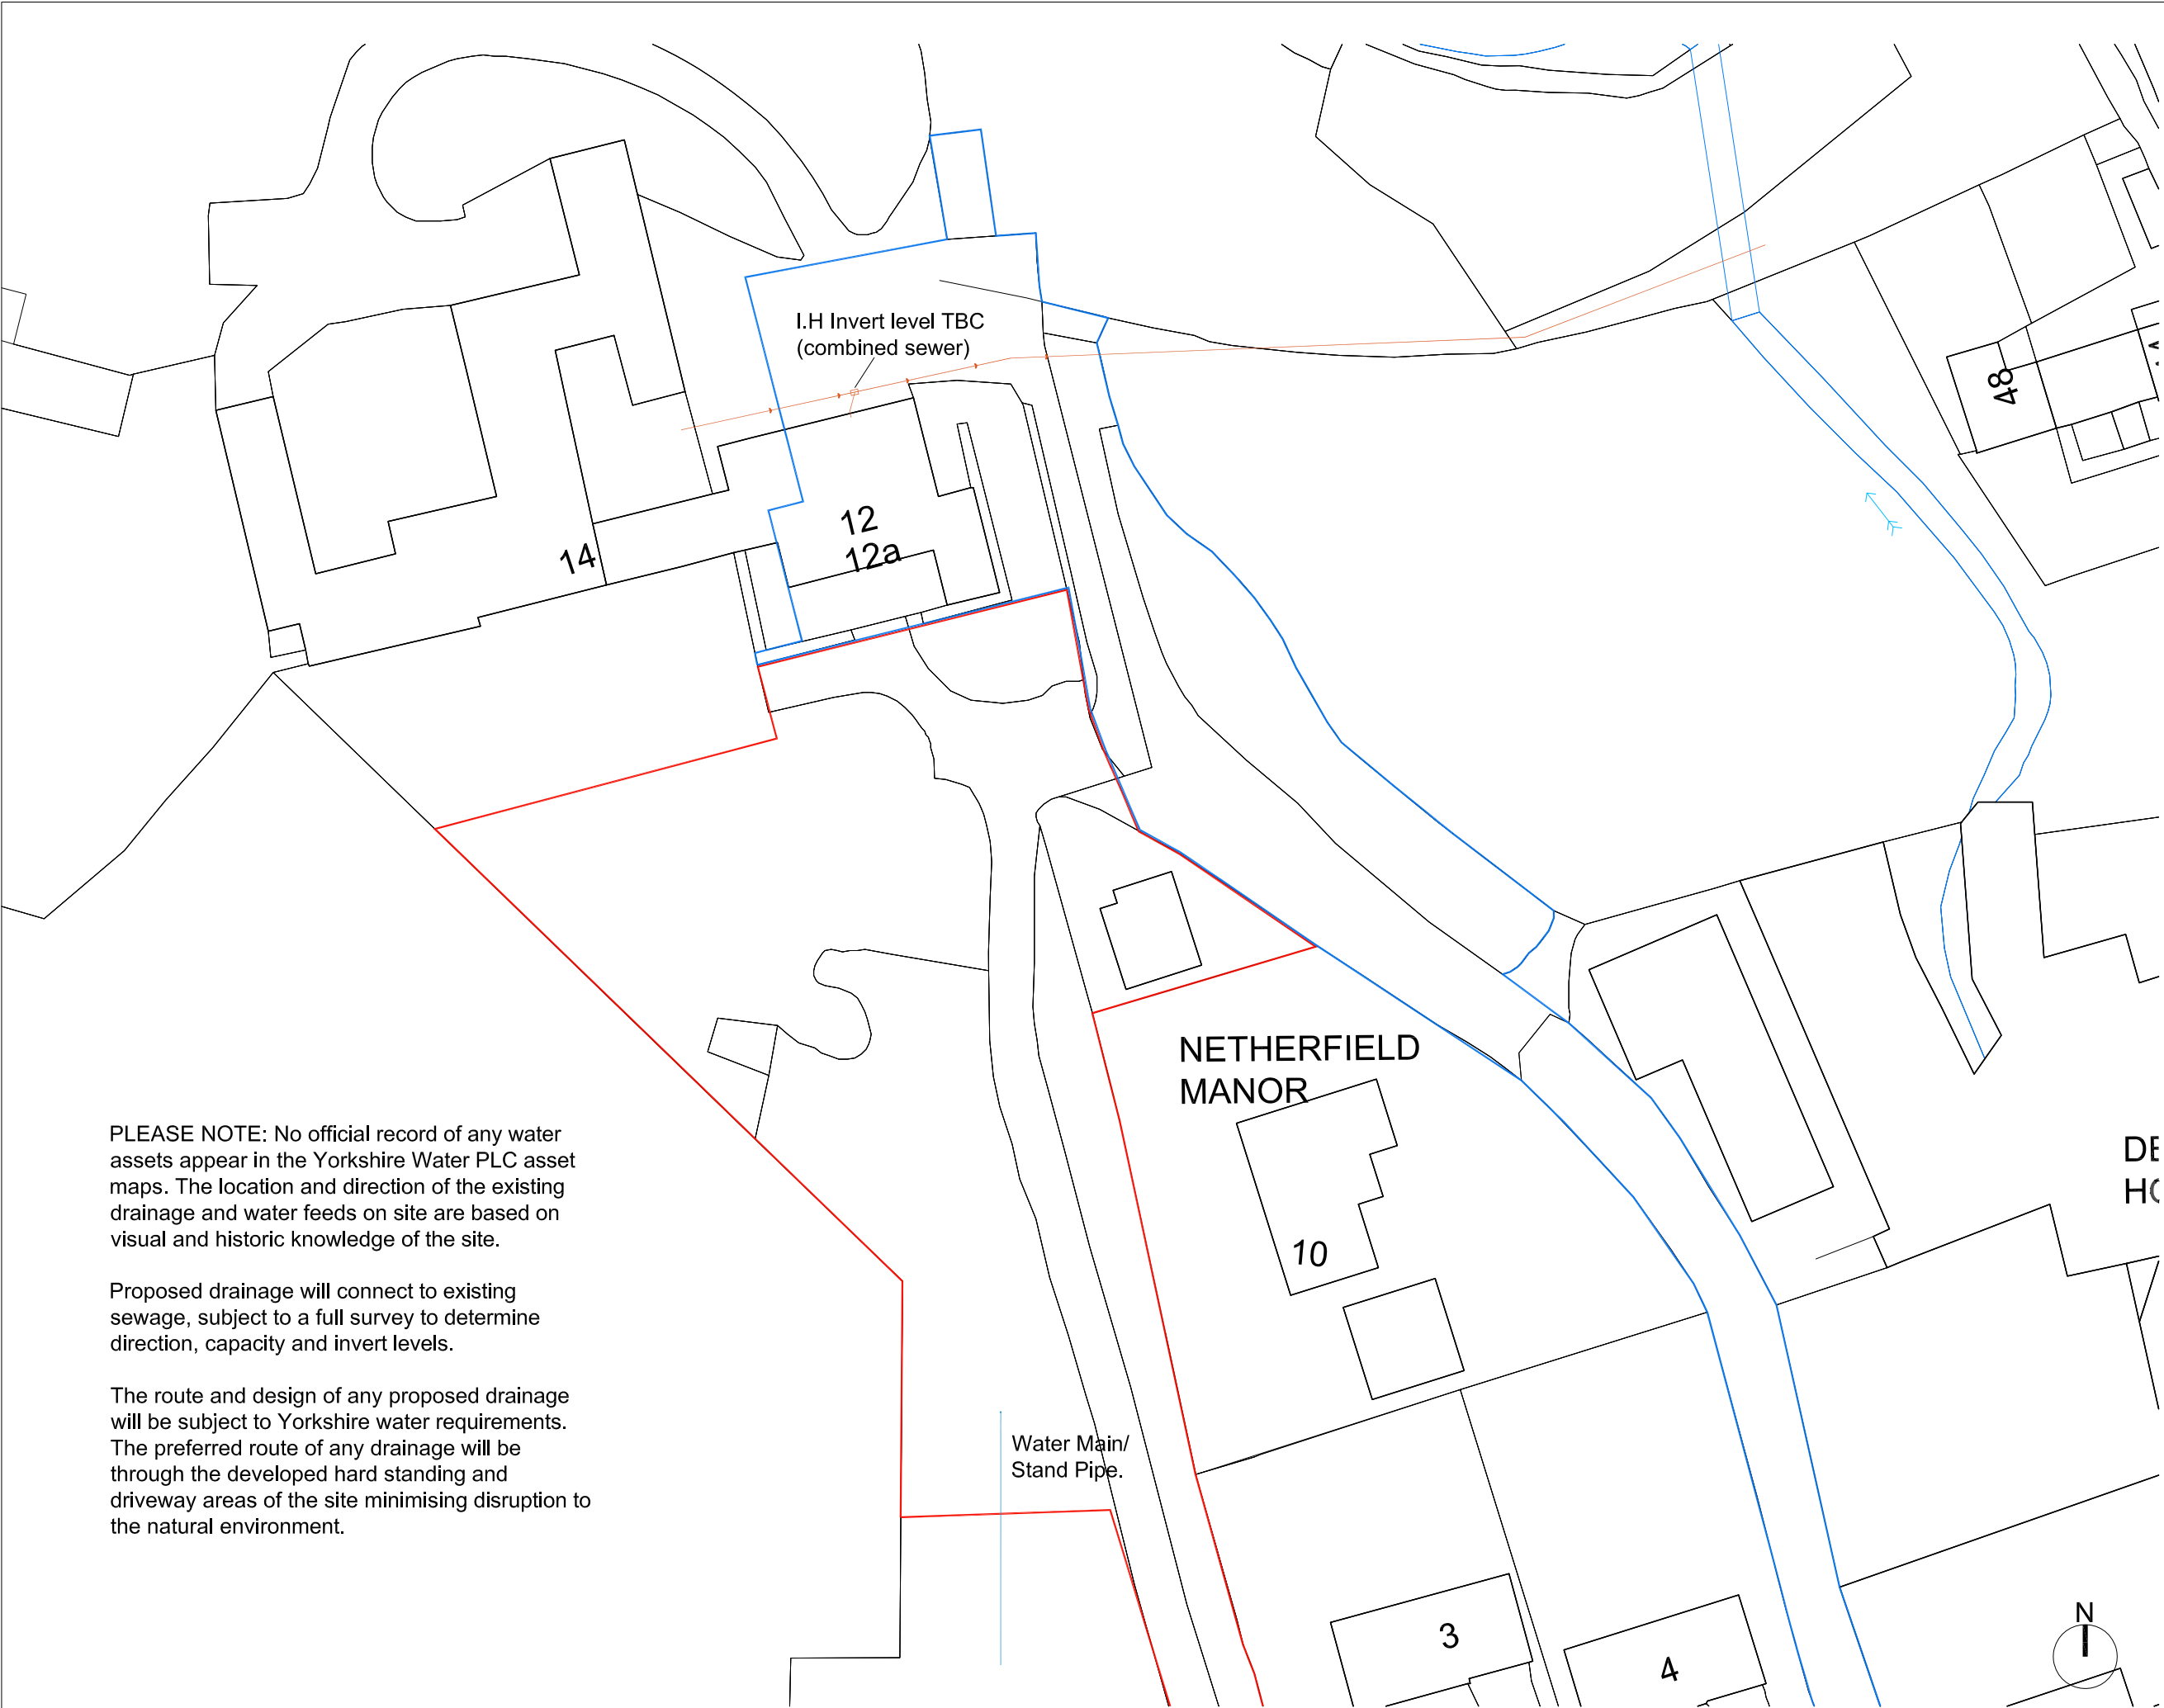

- notes
1. DO NOT SCALE FROM THIS DRAWING - USE FIGURED DIMENSIONS ONLY
 2. TO BE READ IN CONJUNCTION WITH ALL OTHER CONSULTANTS / SPECIALISTS DRAWINGS. REPORT ANY DISCREPANCIES BEFORE AFFECTED WORK COMMENCES
 3. ALL SETTING OUT DIMENSIONS TO BE CHECKED ON SITE BY CONTRACTOR BEFORE WORK COMMENCES

rev.	description
X	xx/xx/xx xx xx
xx	xx

PLEASE NOTE: No official record of any water assets appear in the Yorkshire Water PLC asset maps. The location and direction of the existing drainage and water feeds on site are based on visual and historic knowledge of the site.

Proposed drainage will connect to existing sewage, subject to a full survey to determine direction, capacity and invert levels.

The route and design of any proposed drainage will be subject to Yorkshire water requirements. The preferred route of any drainage will be through the developed hard standing and driveway areas of the site minimising disruption to the natural environment.

Water Main/
Stand Pipe.

NETHERFIELD
MANOR

DE
HC

client	Mr. & Mrs. R Napier
project	12 Riley Lane, Kirkburton
drawing title	Indicative Drainage Plan
drawing number	017009_103
revision	-
drawing status	Planning
scale	NTS @A3
date	10.02.2019
drawn by	-
checked by	-

SIMPLY
ARCHITECTURAL

71 Lascelles Hall Road, Lascelles Hall,
HUDDERSFIELD,
West Yorkshire,
HD5 0BE

t: 07899844497
e: info@simplyarchitectural.co.uk
www.simplyarchitectural.co.uk