



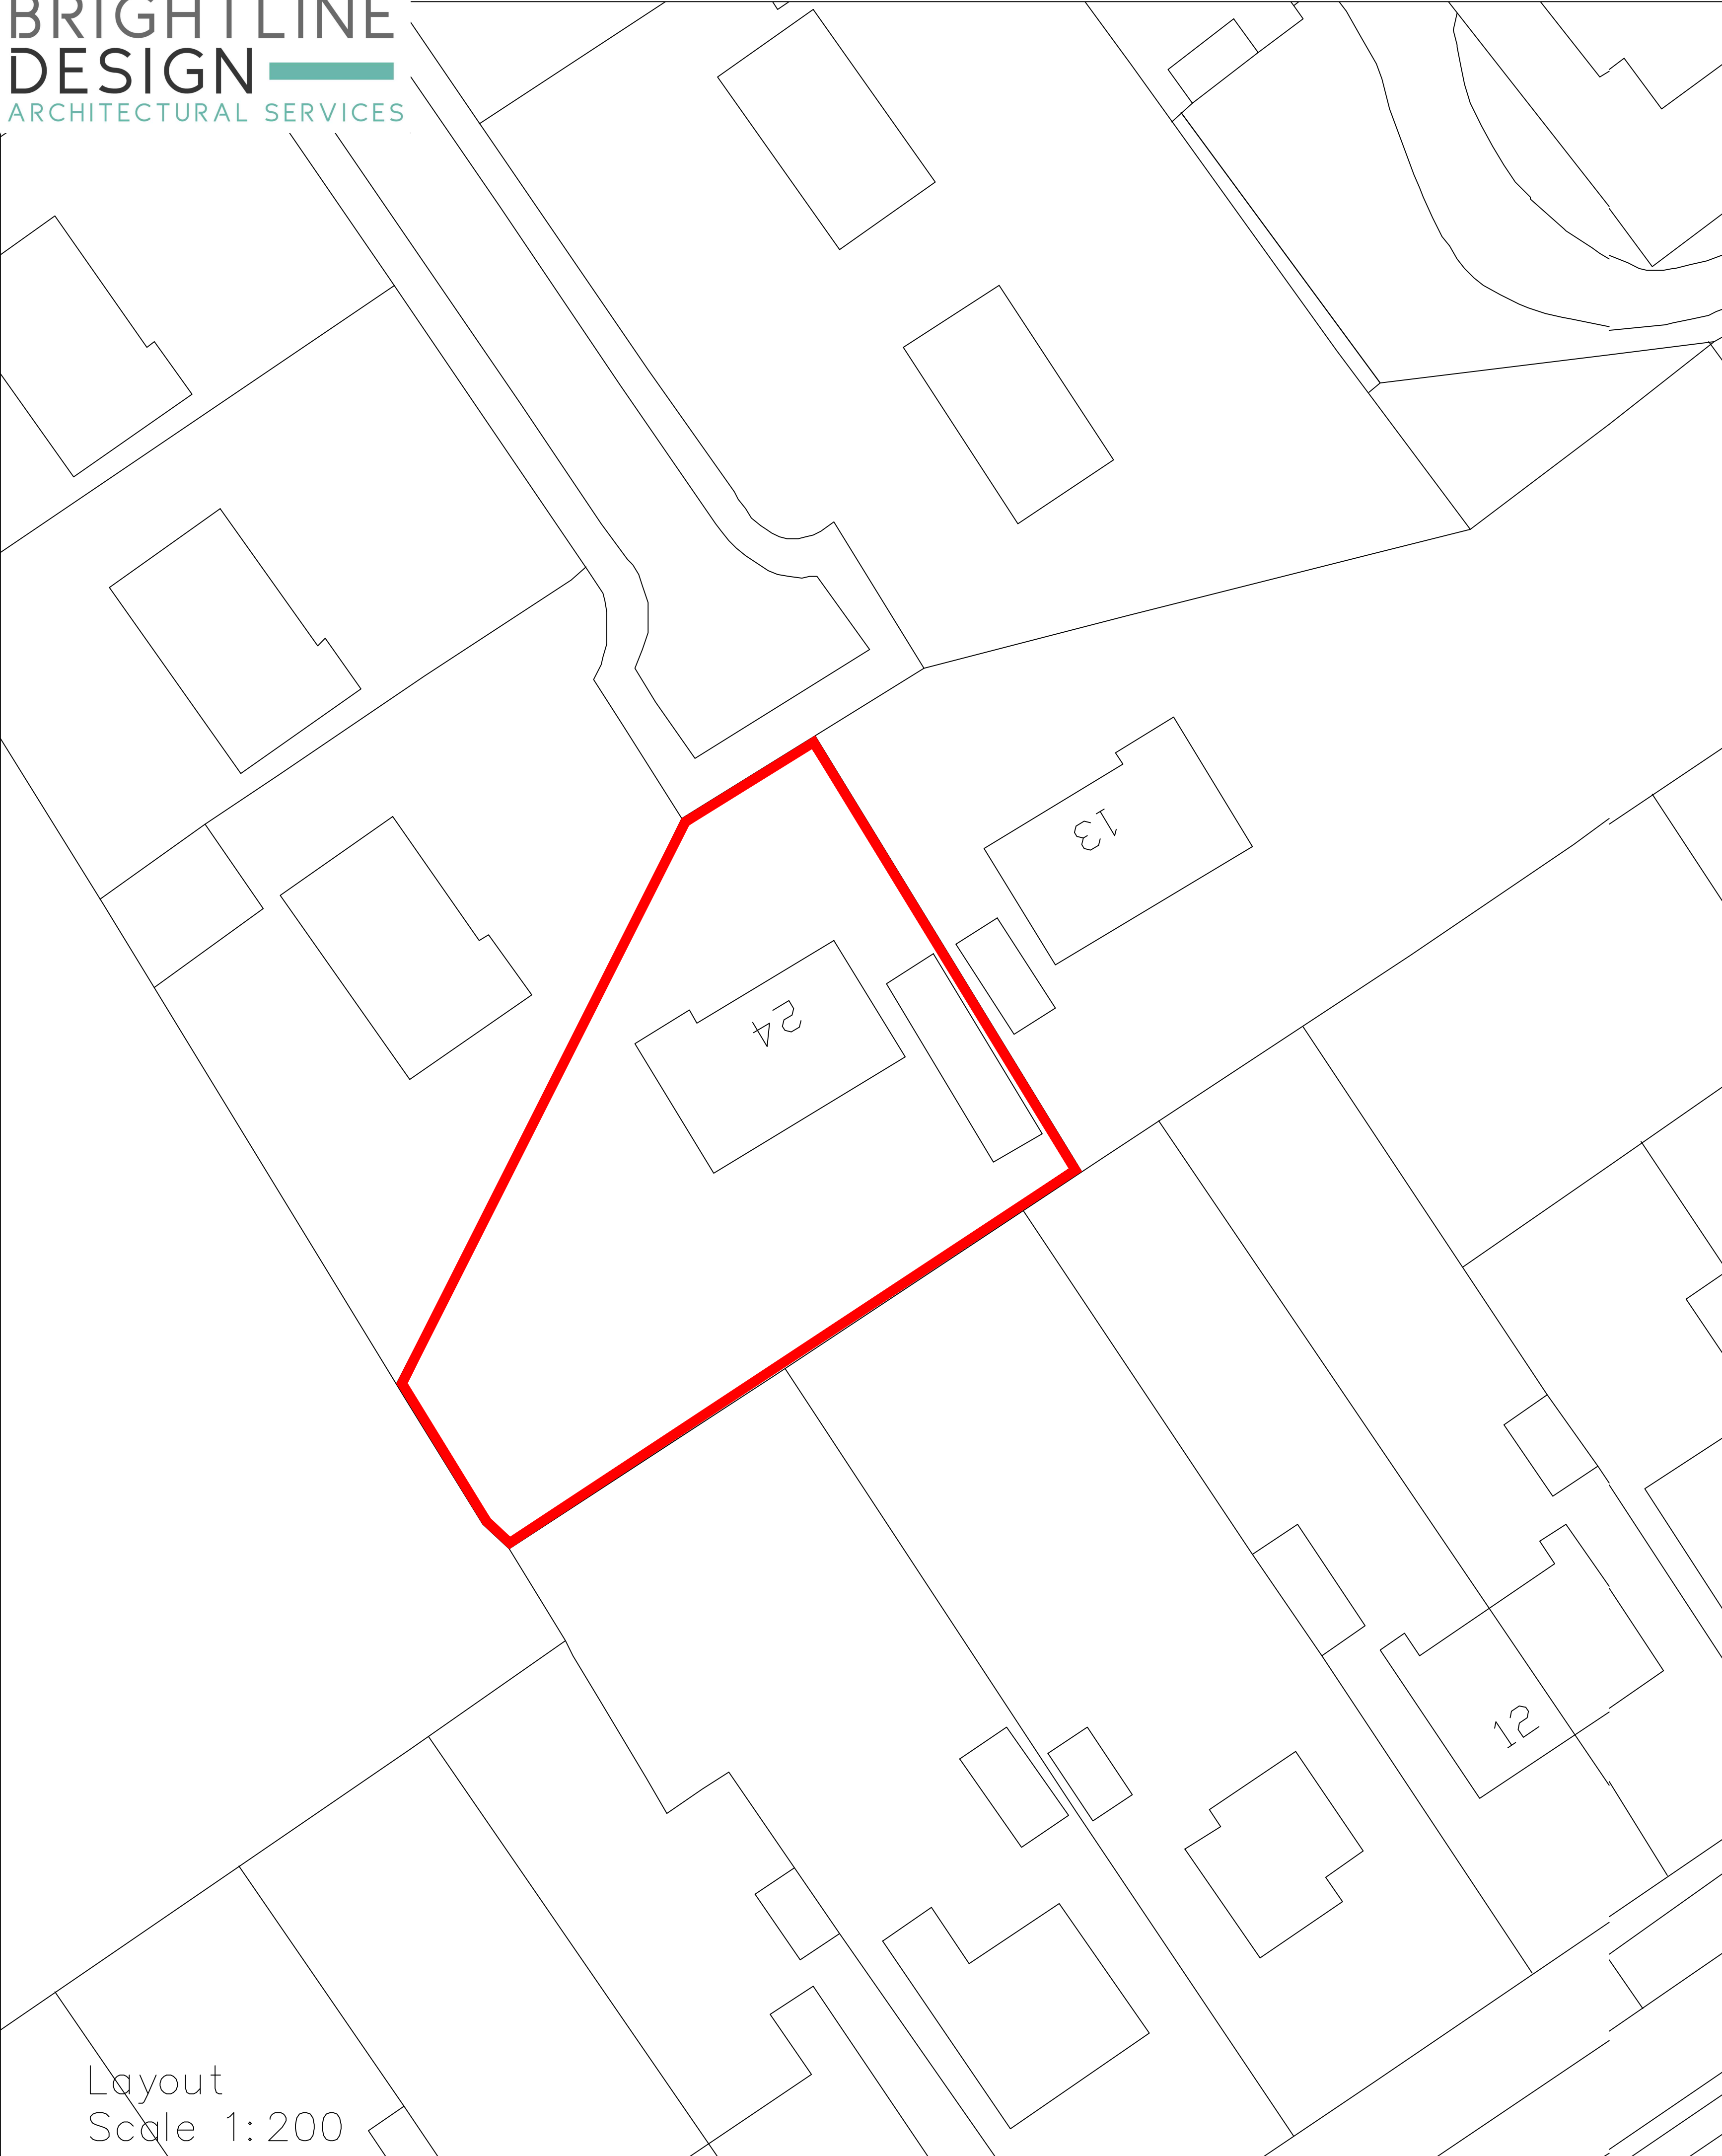

Layout
Scale 1:200

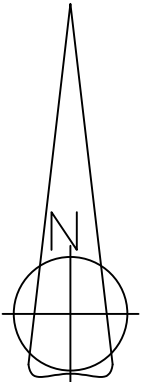

Location Plan
Scale 1:250



All drawings are to be read in conjunction with specification and all other drawings that relate to this house type.

All notes refer to all drawings of this house type.

Electrical layout is schematic – Completed installation to comply with L.E.E regs & all relevant codes of practices.

Electrical components ffl to comply with approved part M.

Do not scale from this drawing. [Brightline Design](#) to be notified of any discrepancies

Verify relevant dimensions on site before commencing work or preperation shop drawings. This Drawing is copyright.

Client
Mr K RAJA

Project
24 Drycough Avenue, Huddersfield
HD4 5JU

Drawing
Layout and Location Plan

Scale SEEDWG/@A1	Date NOV19	Drawn R.FOSTER
Drawing No. 19-053-03	Checked by J.WHIP	Revision -

