



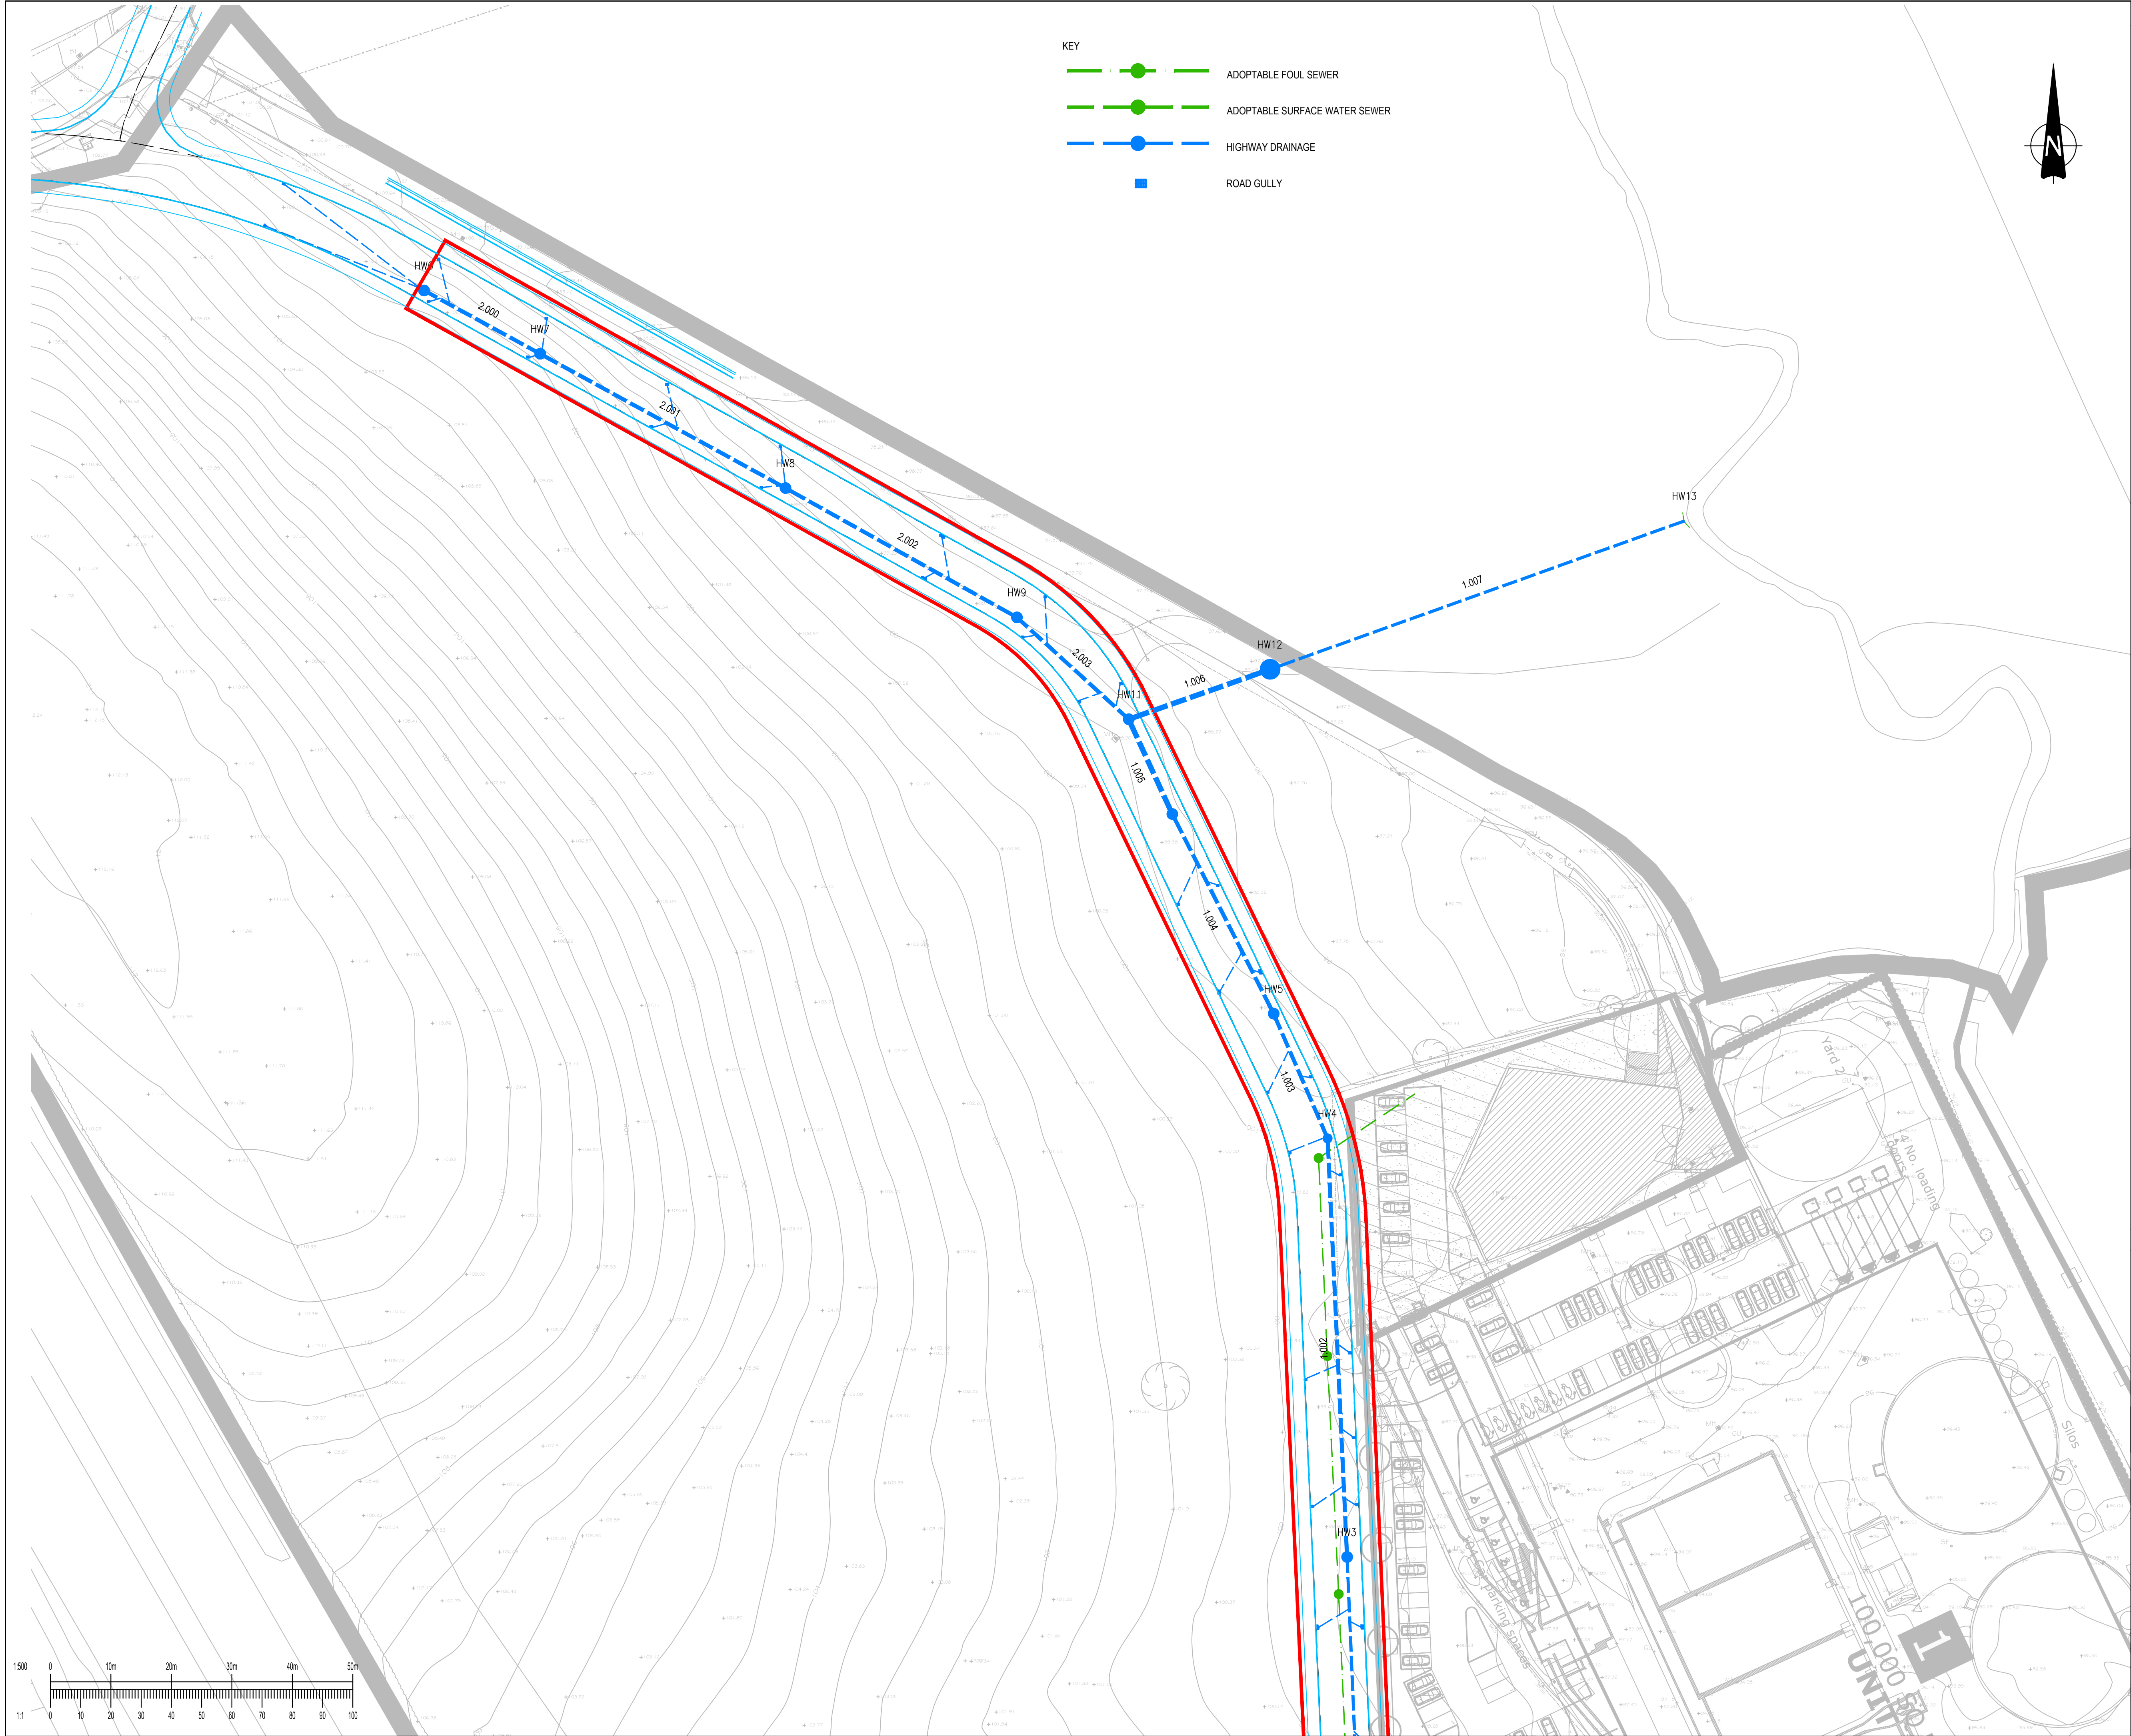

KEY

- ADOPTABLE FOUL SEWER
- ADOPTABLE SURFACE WATER SEWER
- HIGHWAY DRAINAGE
- ROAD GULLY

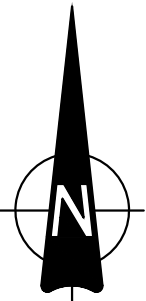

GENERAL NOTES:

- THIS DRAWING IS TO BE READ IN CONJUNCTION WITH ALL RELEVANT ARCHITECTS AND ENGINEERS DRAWINGS AND SPECIFICATIONS.
- DO NOT SCALE FROM THIS DRAWING. ANY OMISSIONS OR ERRORS ON DRAWINGS SHALL BE BROUGHT TO THE ENGINEERS ATTENTION IMMEDIATELY. ALL DIMENSIONS MUST BE CHECKED / VERIFIED ON SITE.
- ALL DIMENSIONS ARE IN MILLIMETRES UNLESS NOTED OTHERWISE.
- ALL LIGHTING COLUMNS, UTILITIES & COMMUNICATION LINES TO BE RELOCATED TO BACK OF PROPOSED FOOTWAY.
- CARRIAGEWAY AND FOOTWAY WORKS SUBJECT TO TECHNICAL APPROVAL BY CBMDC HIGHWAYS AND APPROPRIATE LEGAL AGREEMENTS.

P05	REVISED TO NEW ALIGNMENT, EXTENTS, AND YW ADOPTION EXTENTS	21/10/20	OT	NT
P04	REVISED TO SUIT S104 DRAWINGS	07/07/20	OT	OT
P03	REMOVED PLOT DETAIL	15/05/20	OT	OT
P02	REVISED TO NEW ROAD ALIGNMENT	17/04/20	OT	OT
P01	FIRST ISSUE	17/01/20	OT	OT
Rev:	Description:	Date:	By:	Chkd:



Rose Wharf Ground Floor, 78-80 East Street, Leeds, LS9 8EE
0113 274 8559
leeds@curtins.com
www.curtins.com

Civils & Structures • Transport Planning • Environmental • Infrastructure • Geotechnical • Conservation & Heritage • Principal Designer
Birmingham • Bristol • Cambridge • Cardiff • Douglas • Dublin • Edinburgh • Glasgow • Kentish • Leeds • Liverpool • London • Manchester • Nottingham

Status:ISSUED FOR INFORMATION

S2

Project:INTERCHANGE 26,
NORTH BIERLEY

Orig Title:S38 DRAINAGE LAYOUT
SHEET 1

Size:	A1	Date:	17/01/20	Drawn By:	OT	Designed By:	OT	Checked By:	OT
Scale:	1:500	Project No:	065646	Originator:	CUR	Volume:	ZZ	Level:	ZZ
								Type:	DR
								Role:	C
								Category / Number:	95501 - P05