


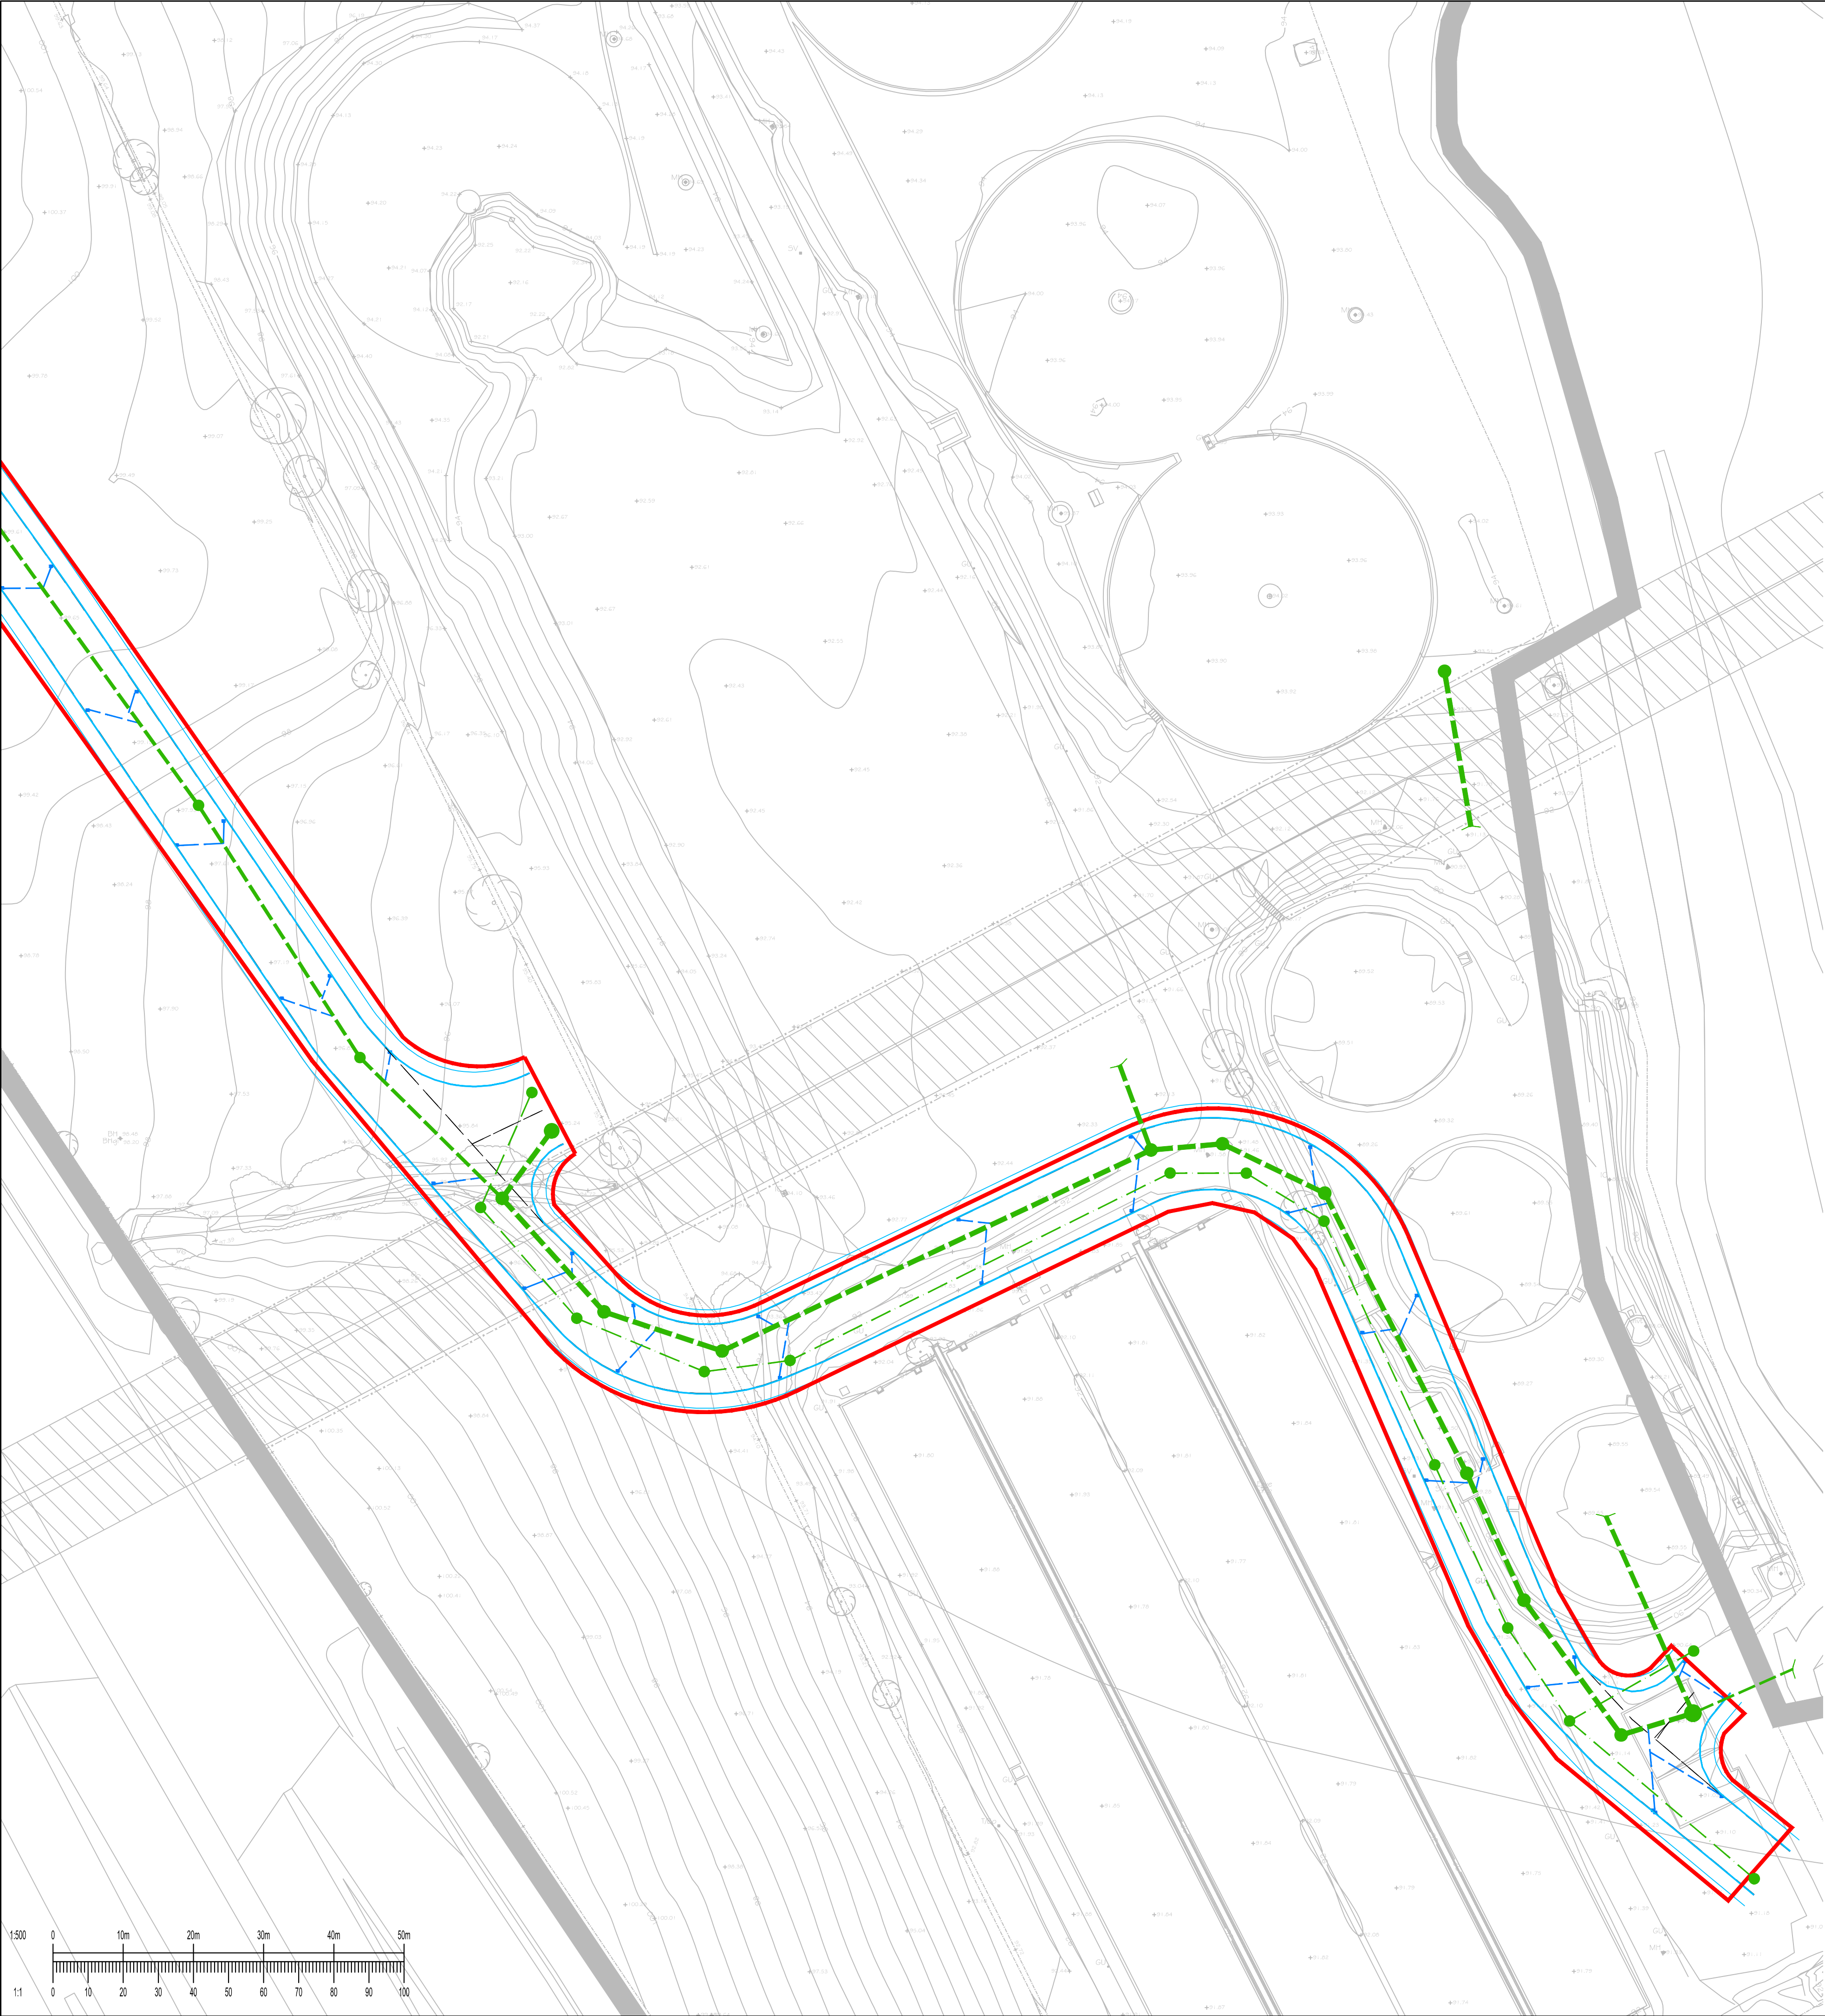


KEY

ADOPTABLE FOUL SEWER

ADOPTABLE SURFACE WATER SEWER

HIGHWAY DRAINAGE

ROAD GULLY

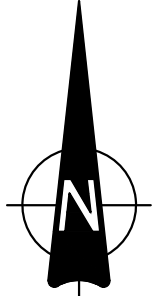

- GENERAL NOTES:
1. THIS DRAWING IS TO BE READ IN CONJUNCTION WITH ALL RELEVANT ARCHITECTS AND ENGINEERS DRAWINGS AND SPECIFICATIONS.
 2. DO NOT SCALE FROM THIS DRAWING. ANY OMISSIONS OR ERRORS ON DRAWINGS SHALL BE BROUGHT TO THE ENGINEERS ATTENTION IMMEDIATELY. ALL DIMENSIONS MUST BE CHECKED / VERIFIED ON SITE.
 3. ALL DIMENSIONS ARE IN MILLIMETRES UNLESS NOTED OTHERWISE.
 4. ALL LIGHTING COLUMNS, UTILITIES & COMMUNICATION LINES TO BE RELOCATED TO BACK OF PROPOSED FOOTWAY.
 5. CARRIAGEWAY AND FOOTWAY WORKS SUBJECT TO TECHNICAL APPROVAL BY CBMDC HIGHWAYS AND APPROPRIATE LEGAL AGREEMENTS.

P05	REVISED TO NEW ALIGNMENT, EXTENTS, AND YW ADOPTION EXTENTS	21/10/20	OT	NT
P04	REVISED TO SUIT S104 DRAWINGS	07/07/20	OT	OT
P03	REMOVED PLOT DETAIL	15/05/20	OT	OT
P02	REVISED TO NEW ROAD ALIGNMENT	17/04/20	OT	OT
P01	FIRST ISSUE	17/01/20	OT	OT
Rev:	Description:	Date:	By:	Chkd:

curtins

Rose Wharf Ground Floor, 78-80 East Street, Leeds, LS9 8EE

0113 274 8859

leeds@curtins.com

www.curtins.com

Civils & Structures • Transport Planning • Environmental • Infrastructure • Geotechnical • Conservation & Heritage • Principal Designer

Birmingham • Bristol • Cambridge • Cardiff • Douglas • Dublin • Edinburgh • Glasgow • Kentish • Leeds • Liverpool • London • Manchester • Nottingham

Status:

ISSUED FOR INFORMATION

S2

Project:

INTERCHANGE 26,
NORTH BIERLEY

Orig Title:

S38 DRAINAGE LAYOUT
SHEET 2

Size:	Date:	Drawn By:	Designed By:	Checked By:			
A1	17/01/20	OT	OT	OT			
Scale: 1:500							
Project No:	Originator:	Volume:	Level:	Type:	Role:	Category / Number:	Rev:
065646 - CUR - ZZ - ZZ - DR - C - 95502 - P05							

\\nas02\Projects\065646 FRA Addendum N Brierley WNTWQMS 4 Production\B Notes & Drawings_Col-CAC09591