


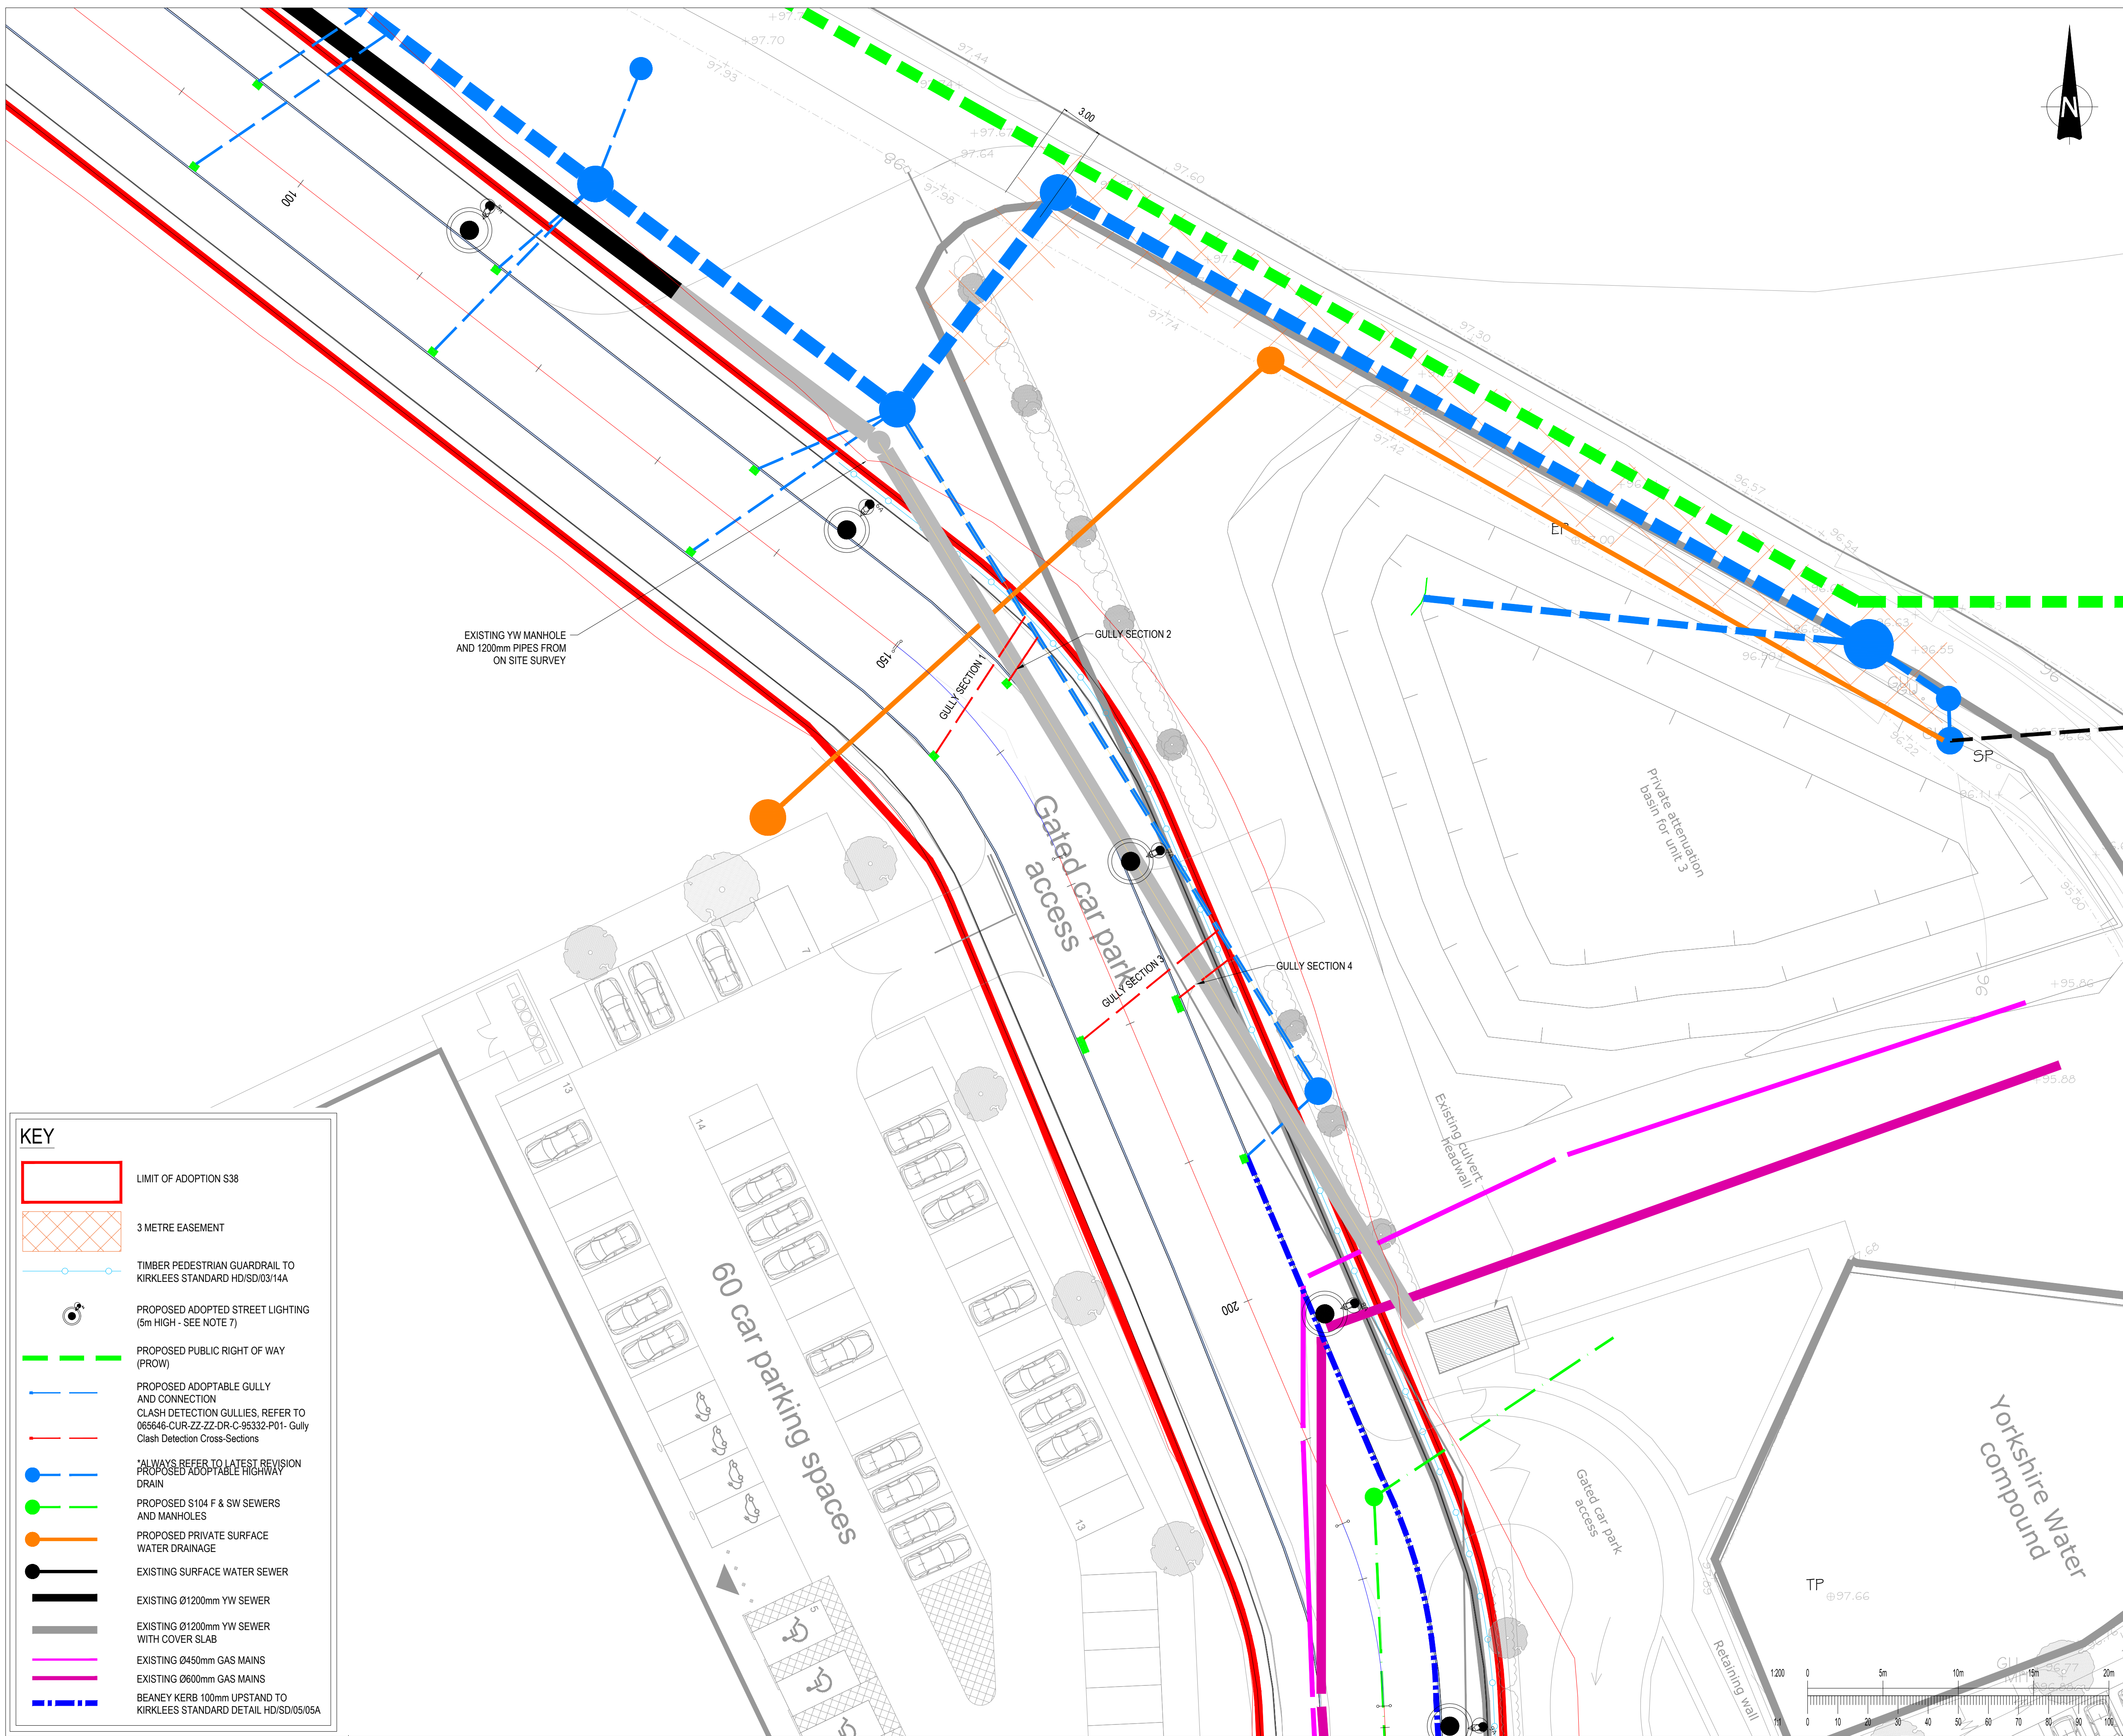

- ## GENERAL NOTES:
1. THIS DRAWING IS TO BE READ IN CONJUNCTION WITH ALL RELEVANT ARCHITECTS AND ENGINEERS DRAWINGS AND SPECIFICATIONS.
 2. DO NOT SCALE FROM THIS DRAWING, ANY OMISSIONS OR ERRORS ON DRAWINGS SHALL BE BROUGHT TO THE ENGINEERS ATTENTION IMMEDIATELY. ALL DIMENSIONS MUST BE CHECKED / VERIFIED ON SITE.
 3. ALL DIMENSIONS ARE IN MILLIMETRES UNLESS NOTED OTHERWISE.
 4. ALL LIGHTING COLUMNS, UTILITIES & COMMUNICATION LINES TO BE RELOCATED TO BACK OF PROPOSED FOOTWAY.
 5. CARRIAGEWAY AND FOOTWAY WORKS SUBJECT TO TECHNICAL APPROVAL BY CBMCD HIGHWAYS AND APPROPRIATE LEGAL AGREEMENTS.
 6. STREETLIGHT TYPES AND LOCATIONS TAKEN FROM KIRKLEES STREETLIGHTING DRAWING 6627 REV B

P04	UPDATED FOLLOWING INTERNAL S38 REVIEW	28/11/22	JC	JC
P03	LATEST KIRKLEES STREETLIGHTING LAYOUT ADDED	06/05/22	JC	ACS
P02	AMENDED FOLLOWING S38 REVIEW	06/01/22	JC	ACS
P01	FIRST ISSUE	14/03/22	JC	ACS
Rev:	Description:	Date:	By:	Chkd:

Rose Wharf Ground Floor, 78-80 East Street, Leeds, LS9 8EE

0113 274 8559

leeds@curtins.com

www.curtins.com

Civils & Structures • Transport Planning • Environmental • Infrastructure • Geotechnical • Conservation & Heritage • Principal Designer
Birmingham • Bristol • Cambridge • Cardiff • Douglas • Dublin • Edinburgh • Glasgow • Harlow • Leeds • Liverpool • London • Manchester • Nottingham

Status: **ISSUED FOR INFORMATION** **S2**

Project: **INTERCHANGE 26,
NORTH BIERLEY**

Drg Title: **SKETCH TO SHOW RELATIONSHIP
BETWEEN GULLY PIPES
AND COVER SLAB
SHEET 1**

Size:	Date:	Drawn By:	Designed By:	Checked By:			
A1	01/03/22	JC	JC	ACS			
Scale: 1:200							
Project No:	Originator:	Volume:	Level:	Type:	Role:	Category / Number:	Rev:

065646 - CUR - ZZ - ZZ - DR - C - 95331 - P04