




GULLY SECTION 1
(SCALE 1:50)

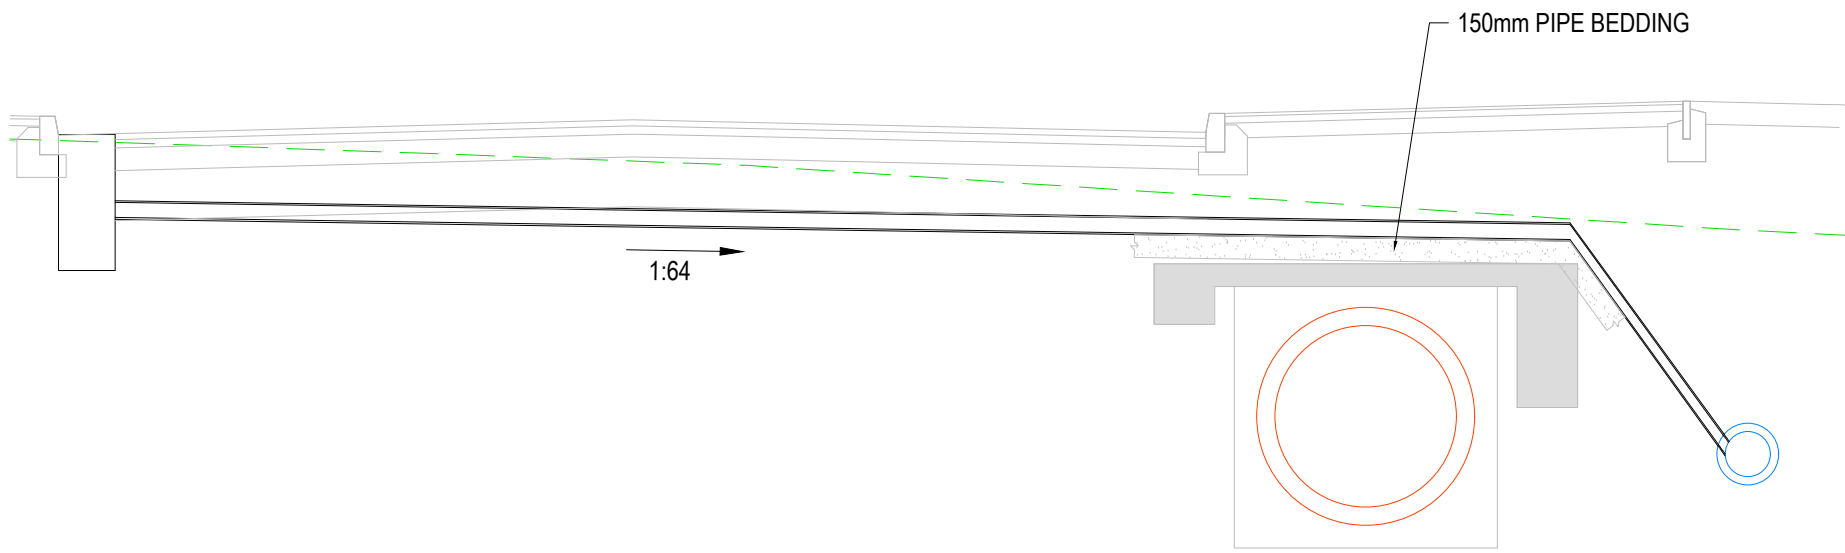


GULLY SECTION 2
(SCALE 1:50)

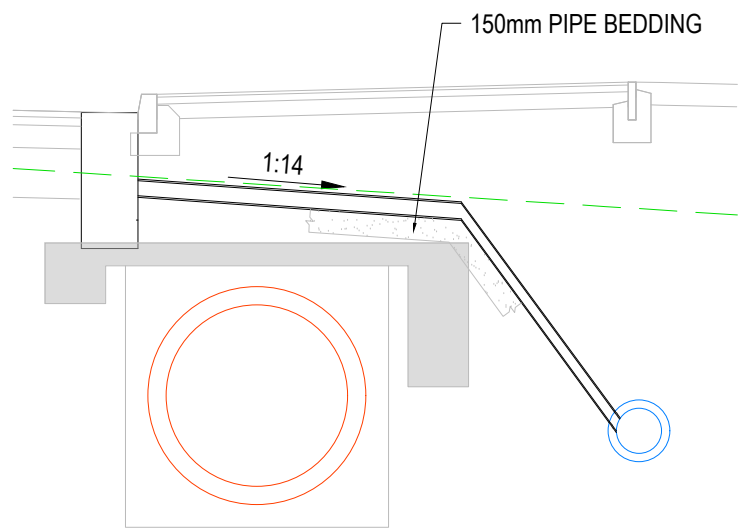

GULLY SECTION 3
(SCALE 1:50)

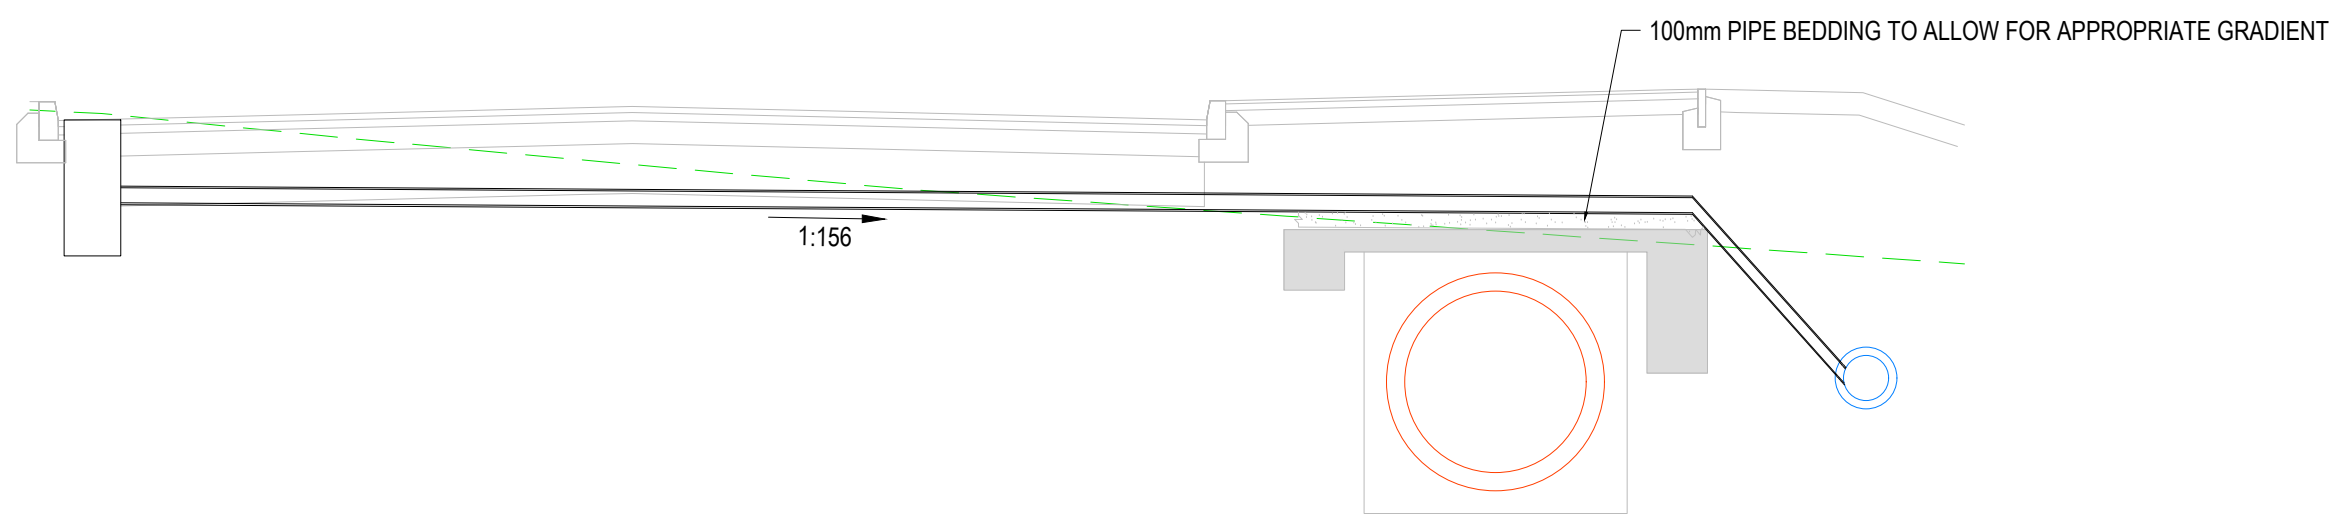

GULLY SECTION 4
(SCALE 1:20)

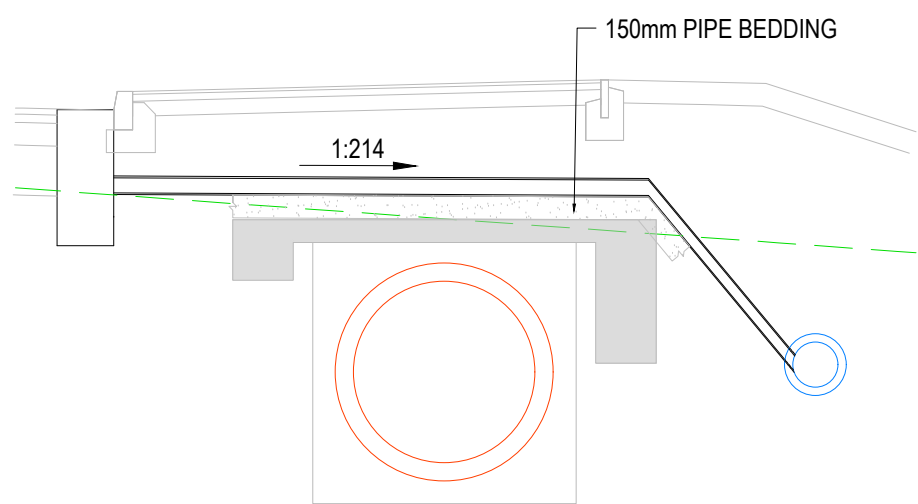

KEY

- PROPOSED ACCESS ROAD
- PROPOSED GULLY & CONNECTION
- EXISTING GROUND
- PROPOSED S38 DRAINAGE (REFER TO DRAINAGE LAYOUTS)
- EXISTING Ø1200mm YORKSHIRE WATER SEWER
- PROPOSED CONCRETE COVER SLAB

GENERAL NOTES:

- THIS DRAWING IS TO BE READ IN CONJUNCTION WITH ALL RELEVANT ARCHITECTS AND ENGINEERS DRAWINGS AND SPECIFICATIONS.
- DO NOT SCALE FROM THIS DRAWING. ANY OMISSIONS OR ERRORS ON DRAWINGS SHALL BE BROUGHT TO THE ENGINEERS ATTENTION IMMEDIATELY. ALL DIMENSIONS MUST BE CHECKED / VERIFIED ON SITE.
- ALL DIMENSIONS ARE IN MILLIMETRES UNLESS NOTED OTHERWISE.
- ALL LIGHTING COLUMNS, UTILITIES & COMMUNICATION LINES TO BE RELOCATED TO BACK OF PROPOSED FOOTWAY.
- CARRIAGEWAY AND FOOTWAY WORKS SUBJECT TO TECHNICAL APPROVAL BY CBMDC HIGHWAYS AND APPROPRIATE LEGAL AGREEMENTS.
- FOR GULLY SECTION LOCATIONS, PLEASE REFER TO 065646-CUR-ZZ-ZZ-DR-C-95331- Gully Clash Detection Layout

P04	UPDATED FOLLOWING INTERNAL S38 REVIEW	30/11/22	JC	JC
P03	SECTIONS AMENDED IN LINE WITH AIP. GRADIENTS AMENDED TO REFLECT PIPE	06/05/22	JC	ACS
P02	AMENDED TO SHOW PIPE BEDDING	25/04/22	JC	ACS
P01	FIRST ISSUE	01/03/22	JC	ACS
Rev:	Description:	Date:	By:	Chkd:



Rose Wharf Ground Floor, 78-80 East Street, Leeds, LS9 8EE
0113 274 8509
leeds@curtins.com
www.curtins.com

Civils & Structures • Transport Planning • Environmental • Infrastructure • Geotechnical • Conservation & Heritage • Principal Designer
Birmingham • Bristol • Cambridge • Cardiff • Douglas • Dublin • Edinburgh • Glasgow • Kentish • Leeds • Liverpool • London • Manchester • Nottingham

Status:	ISSUED FOR INFORMATION				S2
Project:	INTERCHANGE 26, NORTH BIERLEY				
Orig Title:	S38 SKETCH TO SHOW RELATIONSHIP BETWEEN GULLY PIPES AND COVER SLAB, SHEET 2				
Size:	A1	Date:	14/03/22	Drawn By:	JC
Scale:	1:50			Designed By:	JC
				Checked By:	ACS
Project No:	065646	Originator:	CUR	Volume:	ZZ
		Level:	ZZ	Type:	DR
		Role:	C	Category / Number:	95332
		Rev:	P04		

