




GENERAL NOTES:

1. THIS DRAWING IS TO BE READ IN CONJUNCTION WITH ALL RELEVANT ARCHITECTS AND ENGINEERS DRAWINGS AND SPECIFICATIONS.
2. DO NOT SCALE FROM THIS DRAWING. ANY OMISSIONS OR ERRORS ON DRAWINGS SHALL BE BROUGHT TO THE ENGINEERS ATTENTION IMMEDIATELY. ALL DIMENSIONS MUST BE CHECKED / VERIFIED ON SITE.
3. ALL DIMENSIONS ARE IN METRES UNLESS NOTED OTHERWISE.
4. ALL LIGHTING COLUMNS, UTILITIES & COMMUNICATION LINES TO BE RELOCATED TO BACK OF PROPOSED FOOTWAY.
5. CARRIAGEWAY AND FOOTWAY WORKS SUBJECT TO TECHNICAL APPROVAL BY CBMDC HIGHWAYS AND APPROPRIATE LEGAL AGREEMENTS.

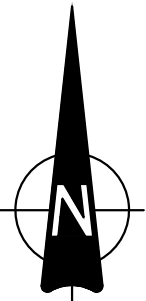

KEY

- RELOCATED S278 GULLY
REUSING EXITING CONNECTION
- S38 HIGHWAY DRAINAGE
- PROPOSED HIGHWAY BOUNDARY

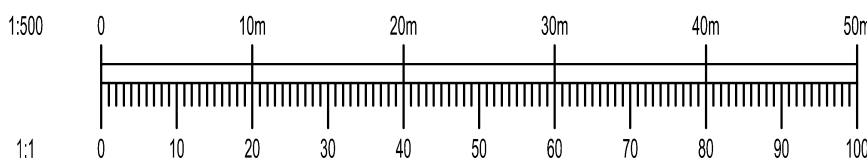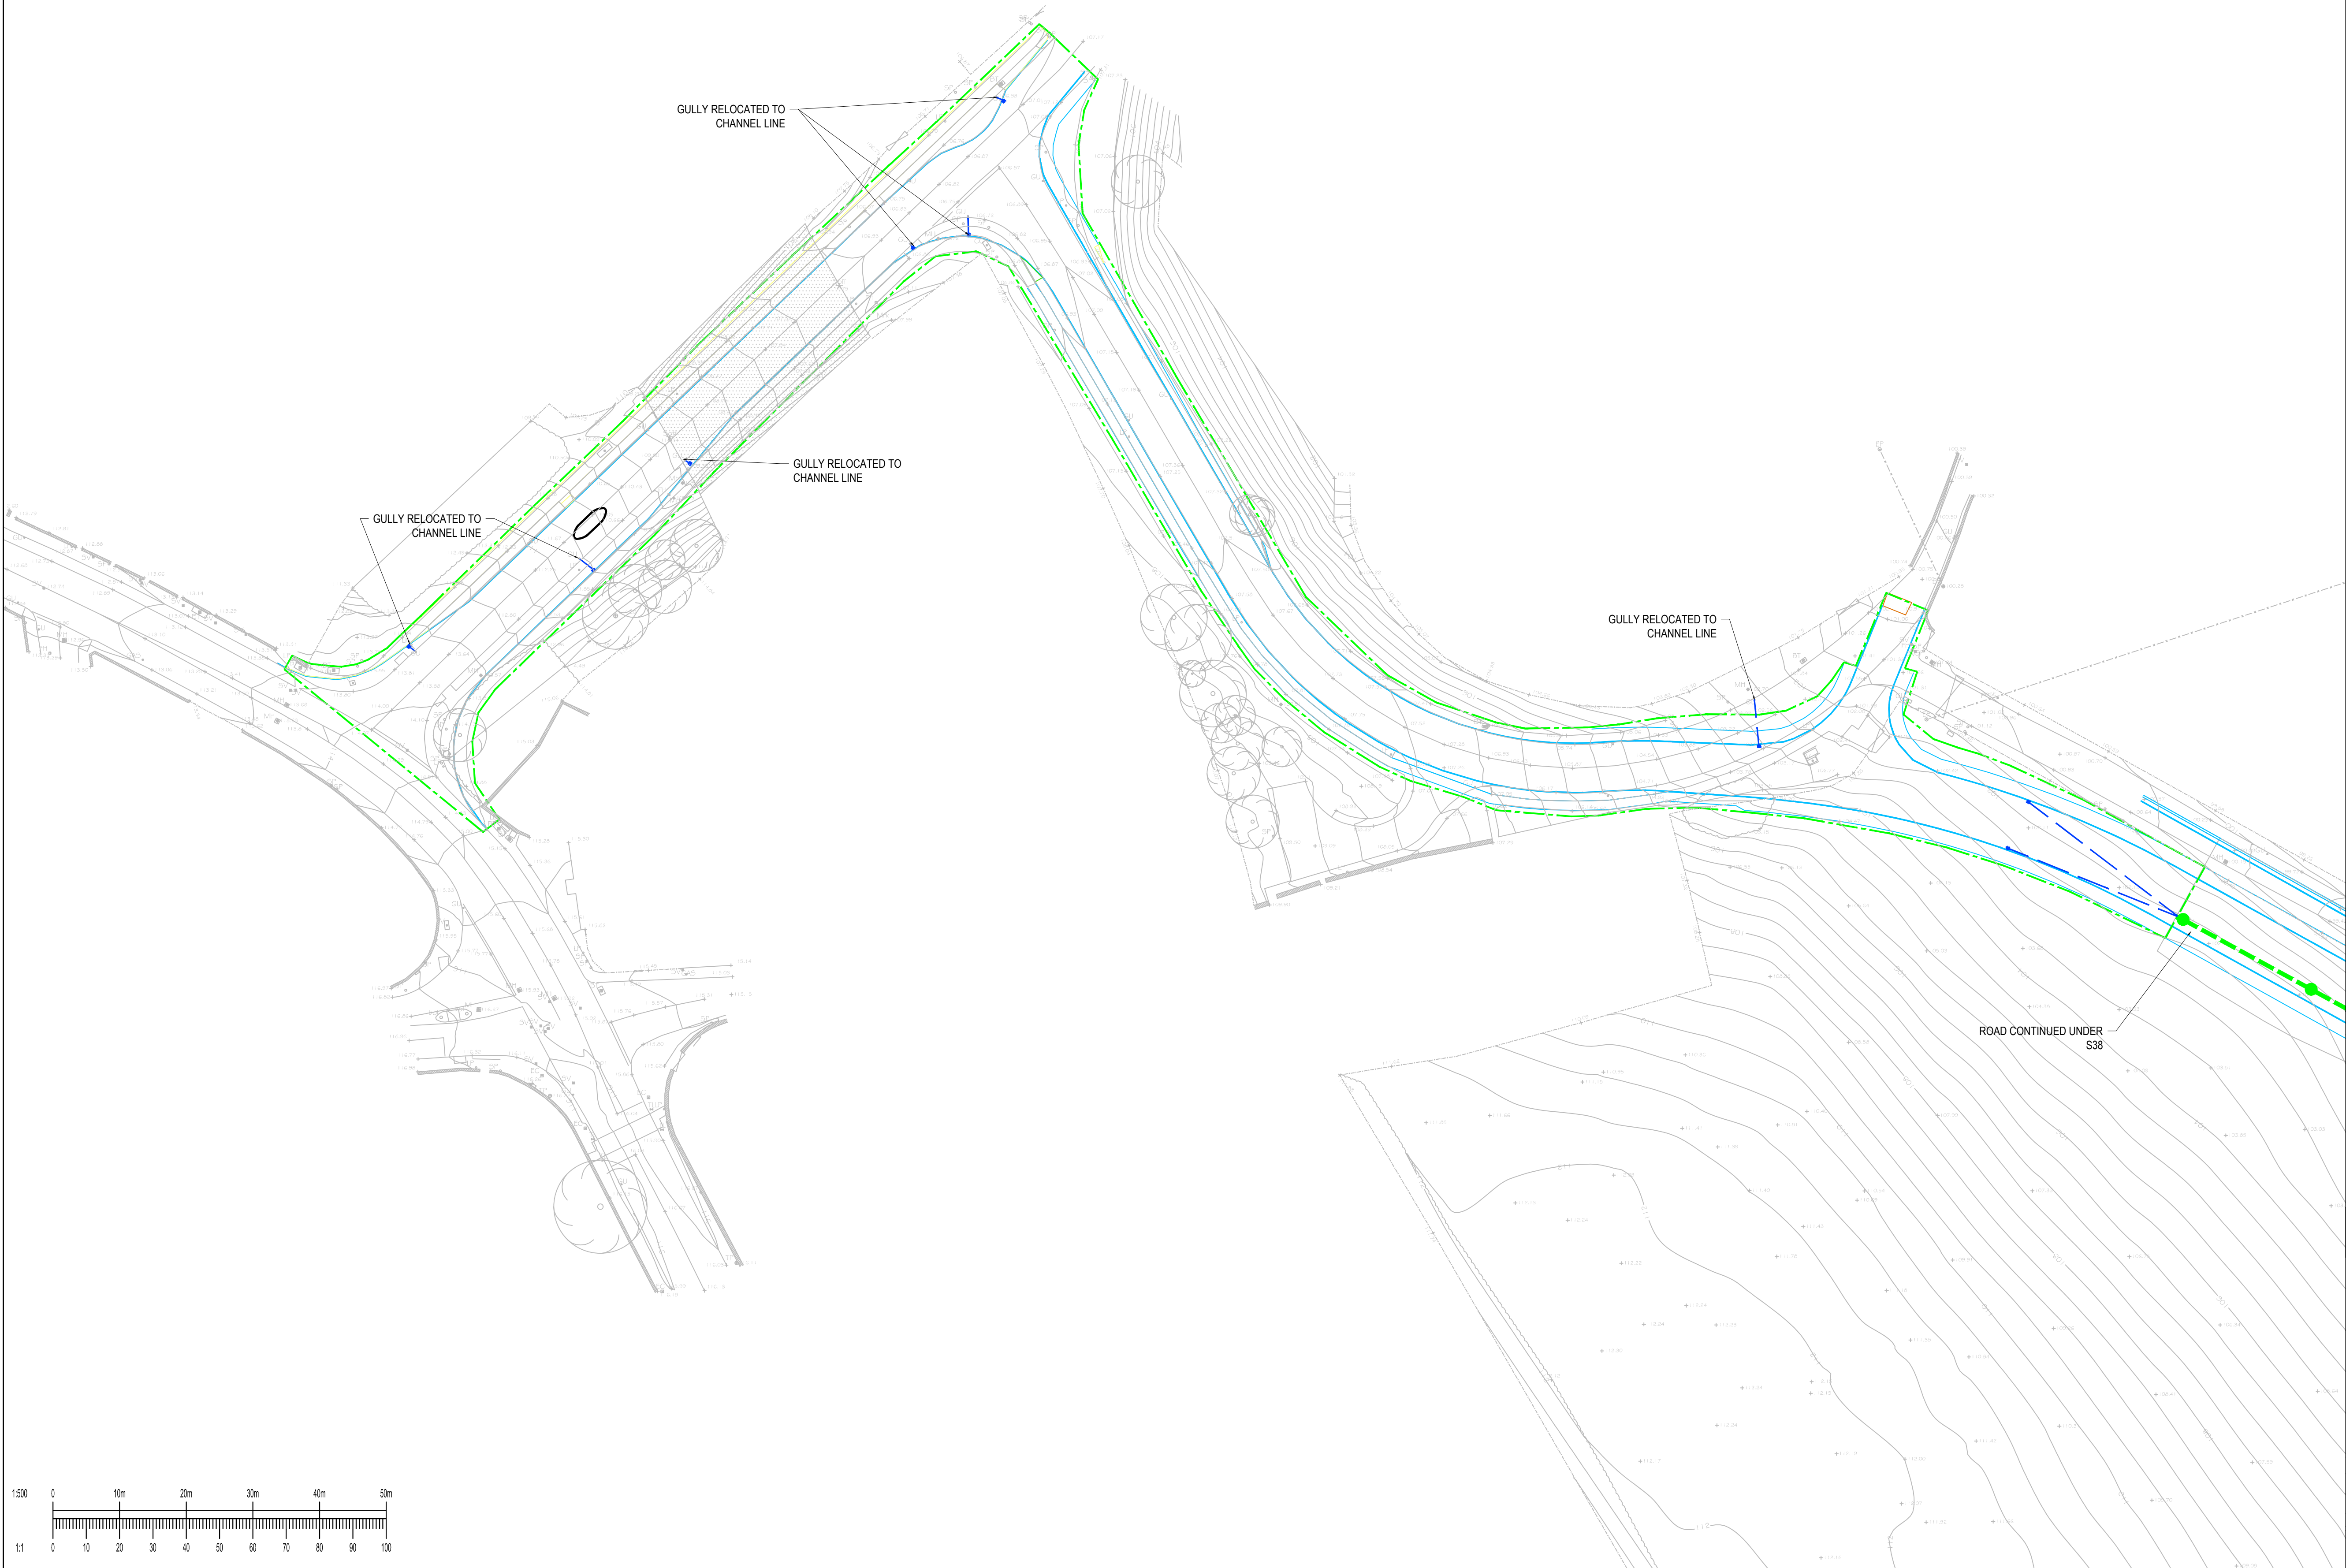

P01	FIRST ISSUE	23/10/20	OT	NT
Rev:	Description:	Date:	By:	Chkd:

Rose Wharf Ground Floor, 78-80 East Street, Leeds, LS9 8EE
0113 274 8559
leeds@curtins.com
www.curtins.com

Civils & Structures • Transport Planning • Environmental • Infrastructure • Geotechnical • Conservation & Heritage • Principal Designer
Birmingham • Bristol • Cambridge • Cardiff • Douglas • Dublin • Edinburgh • Glasgow • Kentish • Leeds • Liverpool • London • Manchester • Nottingham

Status:ISSUED FOR INFORMATION

S2

Project:INTERCHANGE 26,
NORTH BIERLEY

Orig Title:S278 WORKS
DRAINAGE LAYOUT

Size:		Date:	Drawn By:	Designed By:	Checked By:		
A1		23/10/20	OT	OT	NT		
Scale: 1:500							
Project No:	Originator:	Volume:	Level:	Type:	Role:	Category / Number:	Rev:
065646 - CUR - ZZ - ZZ - DR - C - 95051 - P01							