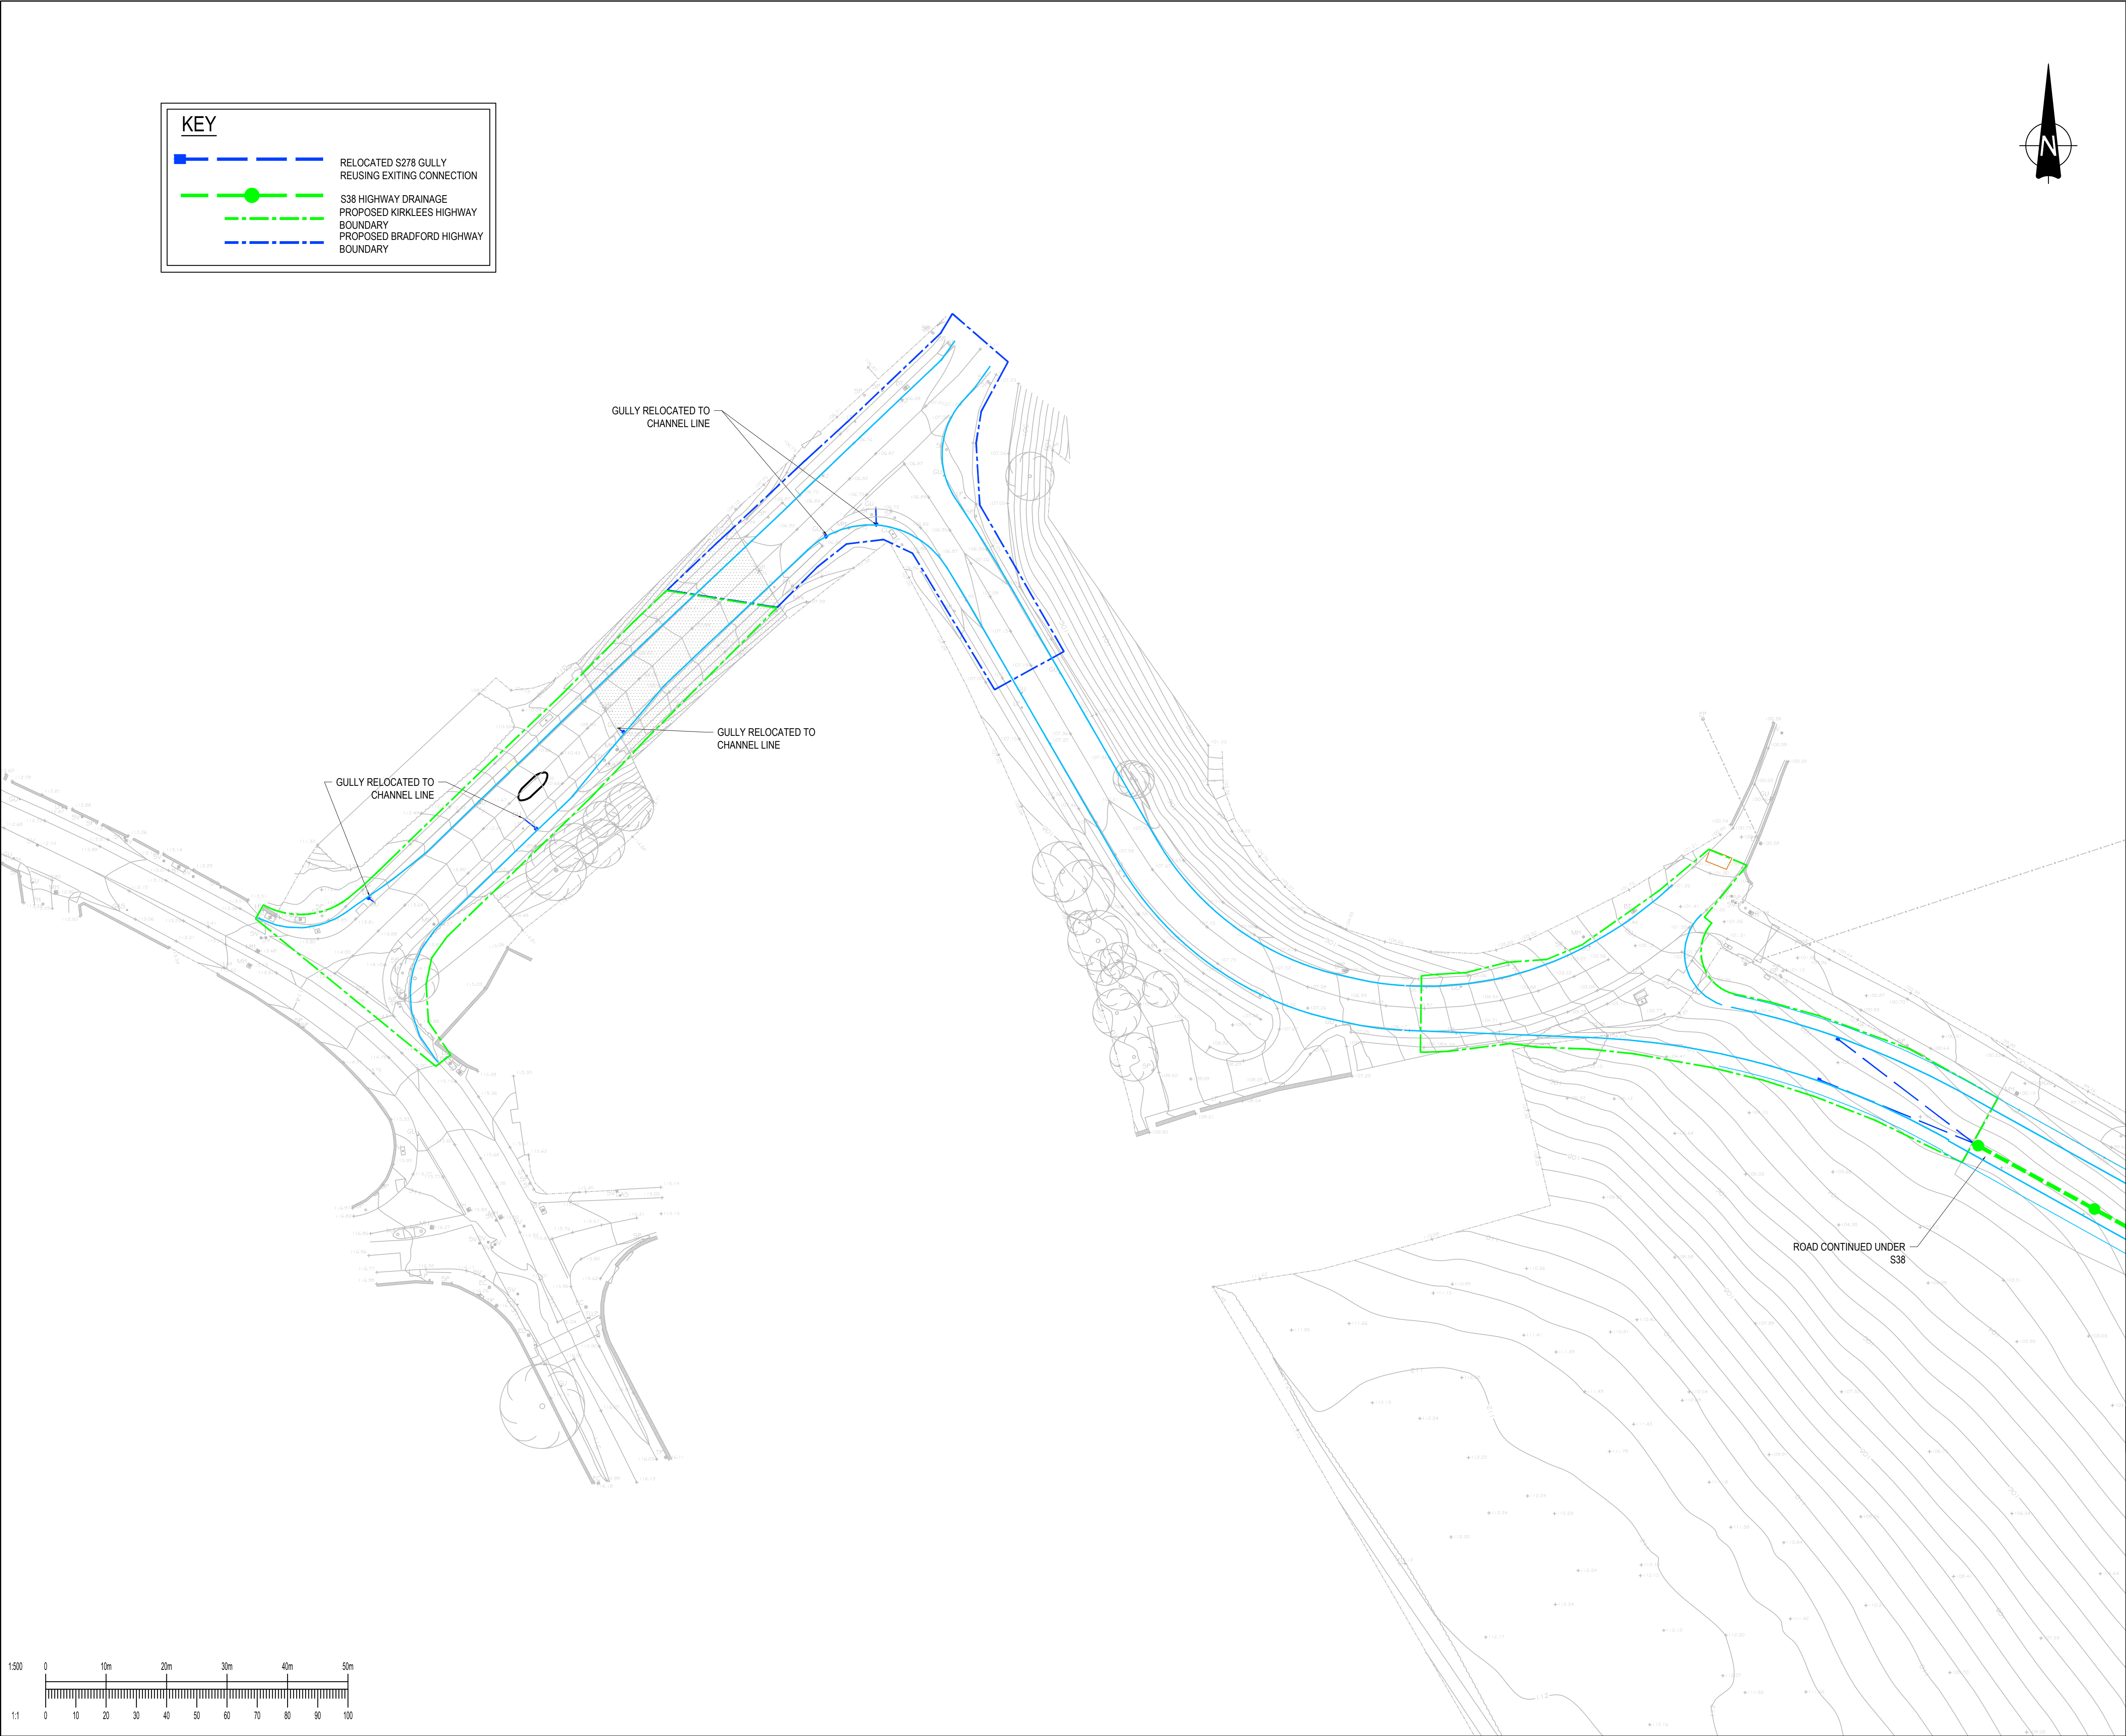


KEY

RELOCATED S278 GULLY
REUSING EXITING CONNECTION

S38 HIGHWAY DRAINAGE
PROPOSED KIRKLEES HIGHWAY
BOUNDARY
PROPOSED BRADFORD HIGHWAY
BOUNDARY

- GENERAL NOTES:
1.

THIS DRAWING IS TO BE READ IN CONJUNCTION WITH ALL RELEVANT ARCHITECTS AND ENGINEERS DRAWINGS AND SPECIFICATIONS.
2.

DO NOT SCALE FROM THIS DRAWING. ANY OMISSIONS OR ERRORS ON DRAWINGS SHALL BE BROUGHT TO THE ENGINEERS ATTENTION IMMEDIATELY. ALL DIMENSIONS MUST BE CHECKED / VERIFIED ON SITE.
3.

ALL DIMENSIONS ARE IN METRES UNLESS NOTED OTHERWISE.
4.

ALL LIGHTING COLUMNS, UTILITIES & COMMUNICATION LINES TO BE RELOCATED TO BACK OF PROPOSED FOOTWAY.
5.

CARRIAGEWAY AND FOOTWAY WORKS SUBJECT TO TECHNICAL APPROVAL BY CBMDC HIGHWAYS AND APPROPRIATE LEGAL AGREEMENTS.

P03	REVISED TO SUIT NEW JUNCTION ARRANGEMENTS	23/12/20	OT	OT
P02	SPLIT OWNERSHIP TO REPRESENT COUNCIL BOUNDARIES BASED ON DEFINITIVE MAPS. REMOVES AREA OF WORKS WITH NO CHANGE FROM EXISTING	02/11/20	OT	NT
P01	FIRST ISSUE	23/10/20	OT	NT
Rev:	Description:	Date:	By:	Chkd:

Curtins

Rose Wharf Ground Floor, 78-80 East Street, Leeds, LS9 8EE
0113 274 8559
leeds@curtins.com
www.curtins.com

Civils & Structures • Transport Planning • Environmental • Infrastructure • Geotechnical • Conservation & Heritage • Principal Designer
Birmingham • Bristol • Cambridge • Cardiff • Douglas • Dublin • Edinburgh • Glasgow • Kentish • Leeds • Liverpool • London • Manchester • Nottingham

Status:ISSUED FOR INFORMATION

Project:INTERCHANGE 26,
NORTH BIERLEY

Orig Title: S278 WORKS
DRAINAGE LAYOUT

Size: A1

Date: 23/10/20

Drawn By: OT

Designed By: OT

Checked By: NT

Scale: 1:500

Project No: 065646 - CUR - ZZ - ZZ - DR - C -

Originator: 95051

Volume: -

Level: P03

Type: -

Role: -

Category / Number: -

Rev: -

\\nas02\Projects\065646 FRA Addendum N Bierley WTW\QMS 4 Production\B Notes & Drawings_Col-C\CA09591