


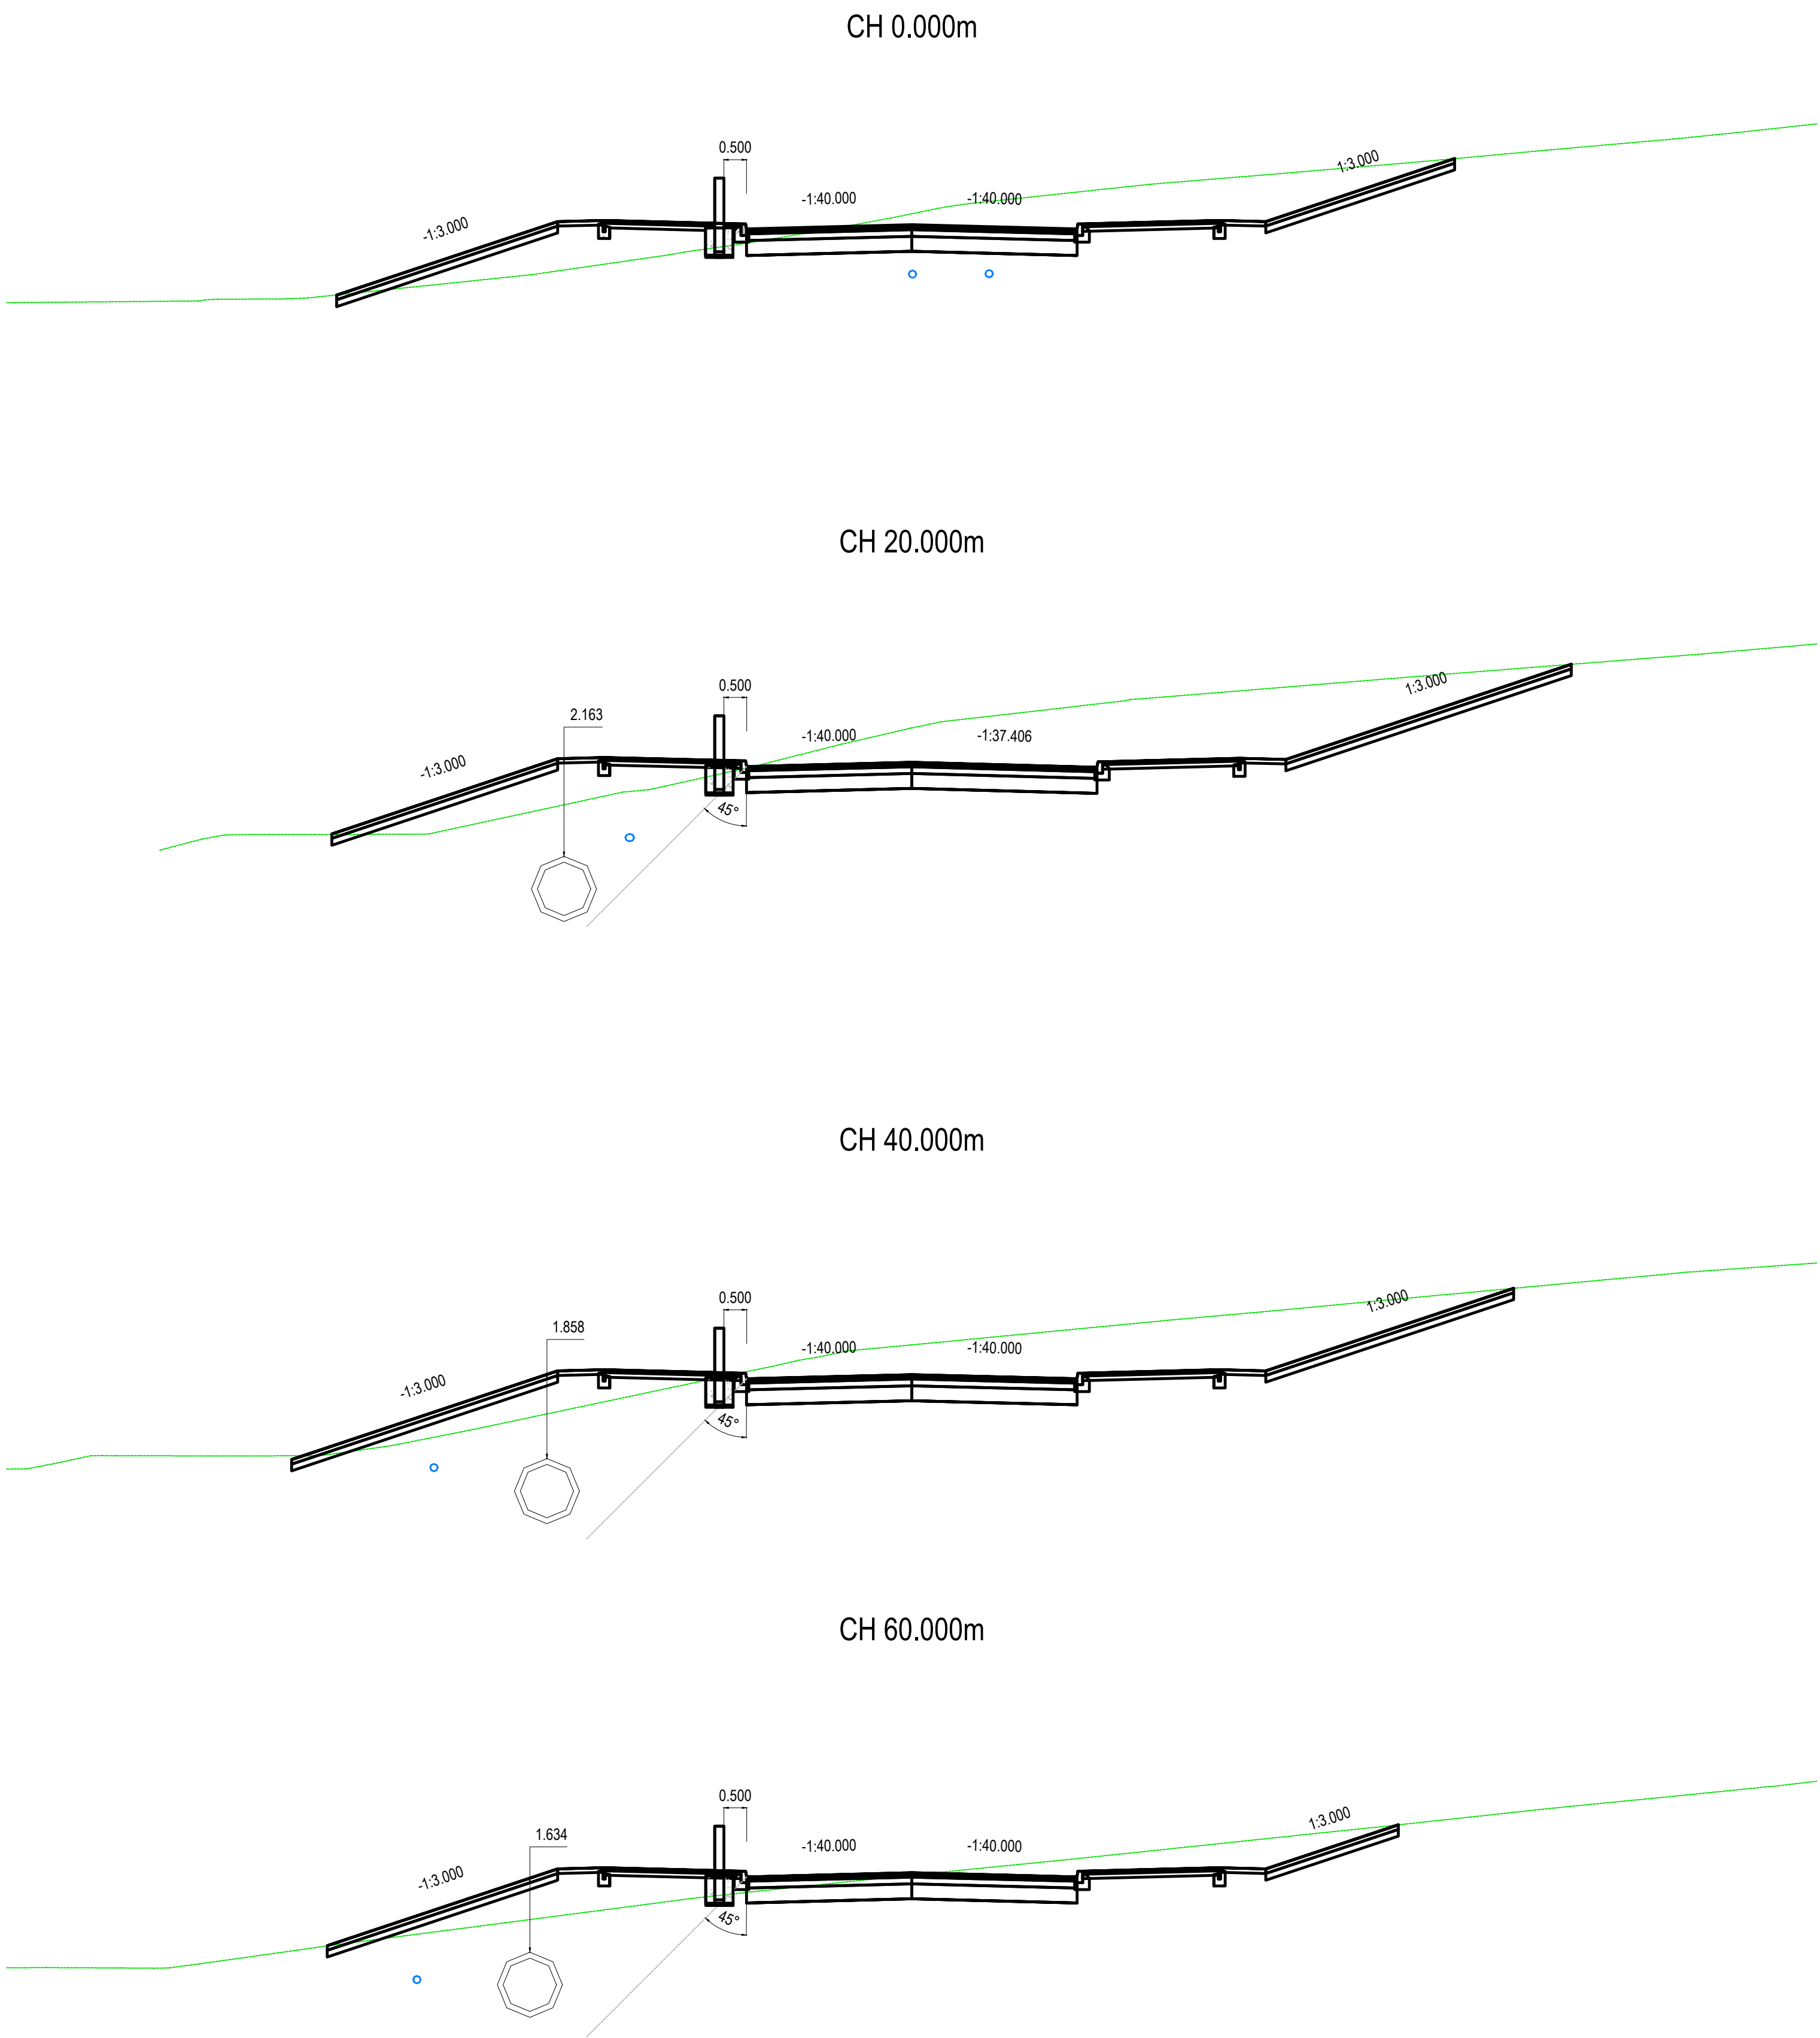

KEY

PROPOSED ACCESS ROAD

EXISTING GROUND

45° LOADING INFLUENCE LIMIT

PROPOSED S38 DRAINAGE
(REFER TO DRAINAGE LAYOUTS)

EXISTING Ø1200mm YORKSHIRE
WATER SEWER

GENERAL NOTES:

- THIS DRAWING IS TO BE READ IN CONJUNCTION WITH ALL RELEVANT ARCHITECTS AND ENGINEERS DRAWINGS AND SPECIFICATIONS.
- DO NOT SCALE FROM THIS DRAWING. ANY OMISSIONS OR ERRORS ON DRAWINGS SHALL BE BROUGHT TO THE ENGINEERS ATTENTION IMMEDIATELY. ALL DIMENSIONS MUST BE CHECKED / VERIFIED ON SITE.
- ALL DIMENSIONS ARE IN MILLIMETRES UNLESS NOTED OTHERWISE.
- ALL LIGHTING COLUMNS, UTILITIES & COMMUNICATION LINES TO BE RELOCATED TO BACK OF PROPOSED FOOTWAY.
- CARRIAGEWAY AND FOOTWAY WORKS SUBJECT TO TECHNICAL APPROVAL BY CBMDC HIGHWAYS AND APPROPRIATE LEGAL AGREEMENTS.

P01	FIRST ISSUE	11/11/21	JC	ACS
Rev:	Description:	Date:	By:	Chkd:

curtins

Rose Wharf Ground Floor, 78-80 East Street, Leeds, LS9 8EE
0113 274 8509
leeds@curtins.com
www.curtins.com

Civils & Structures • Transport Planning • Environmental • Infrastructure • Geotechnical • Conservation & Heritage • Principal Designer
Birmingham • Bristol • Cambridge • Cardiff • Douglas • Dublin • Edinburgh • Glasgow • Harlow • Leeds • Liverpool • London • Manchester • Nottingham

Status:

ISSUED FOR INFORMATION

S2

Project:

INTERCHANGE 26,
NORTH BIERLEY

Orig Title:

YORKSHIRE WATER CULVERT
CROSS-SECTIONS
SHEET 1

Size:	Date:	Drawn By:	Designed By:	Checked By:			
A1	11/11/21	JC	JC	ACS			
Scale:	1:400						
Project No:	Originator:	Volume:	Level:	Type:	Role:	Category / Number:	Rev:
065646	- CUR	- ZZ	- ZZ	- DR	- C	- 95322	- P01