
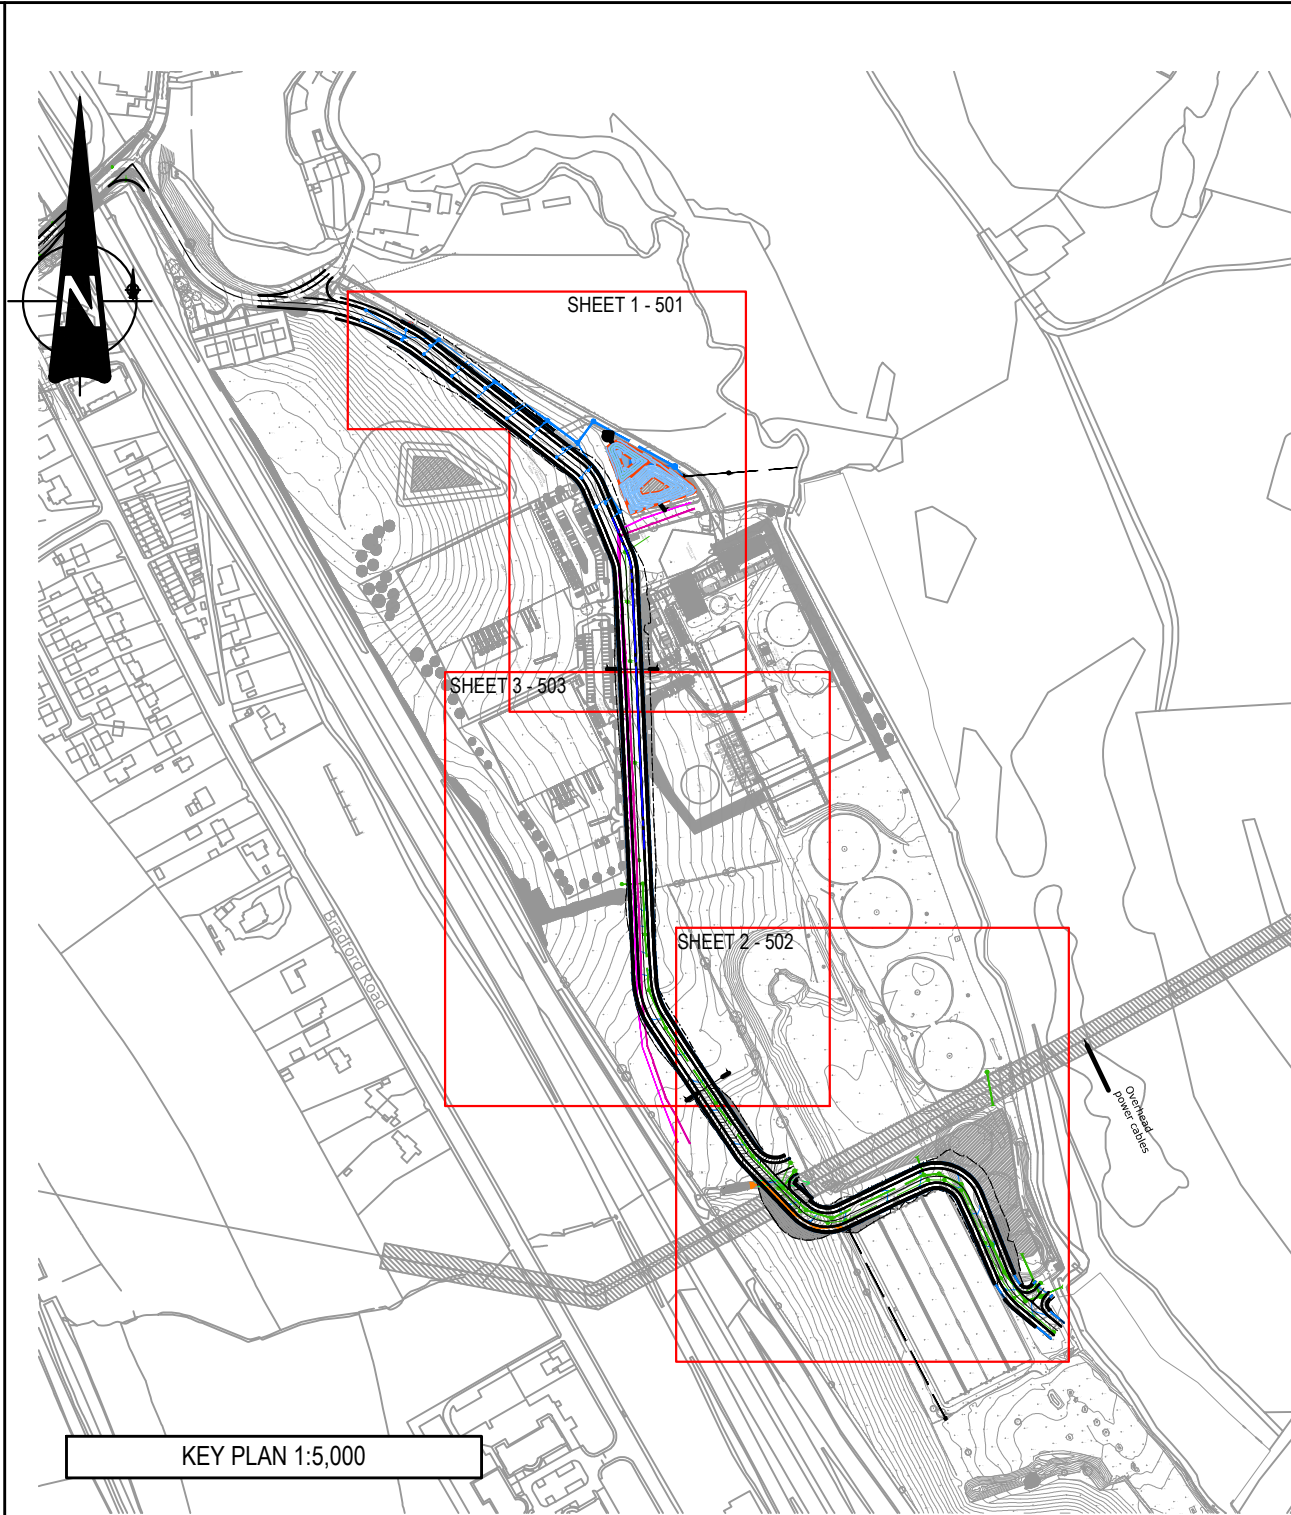


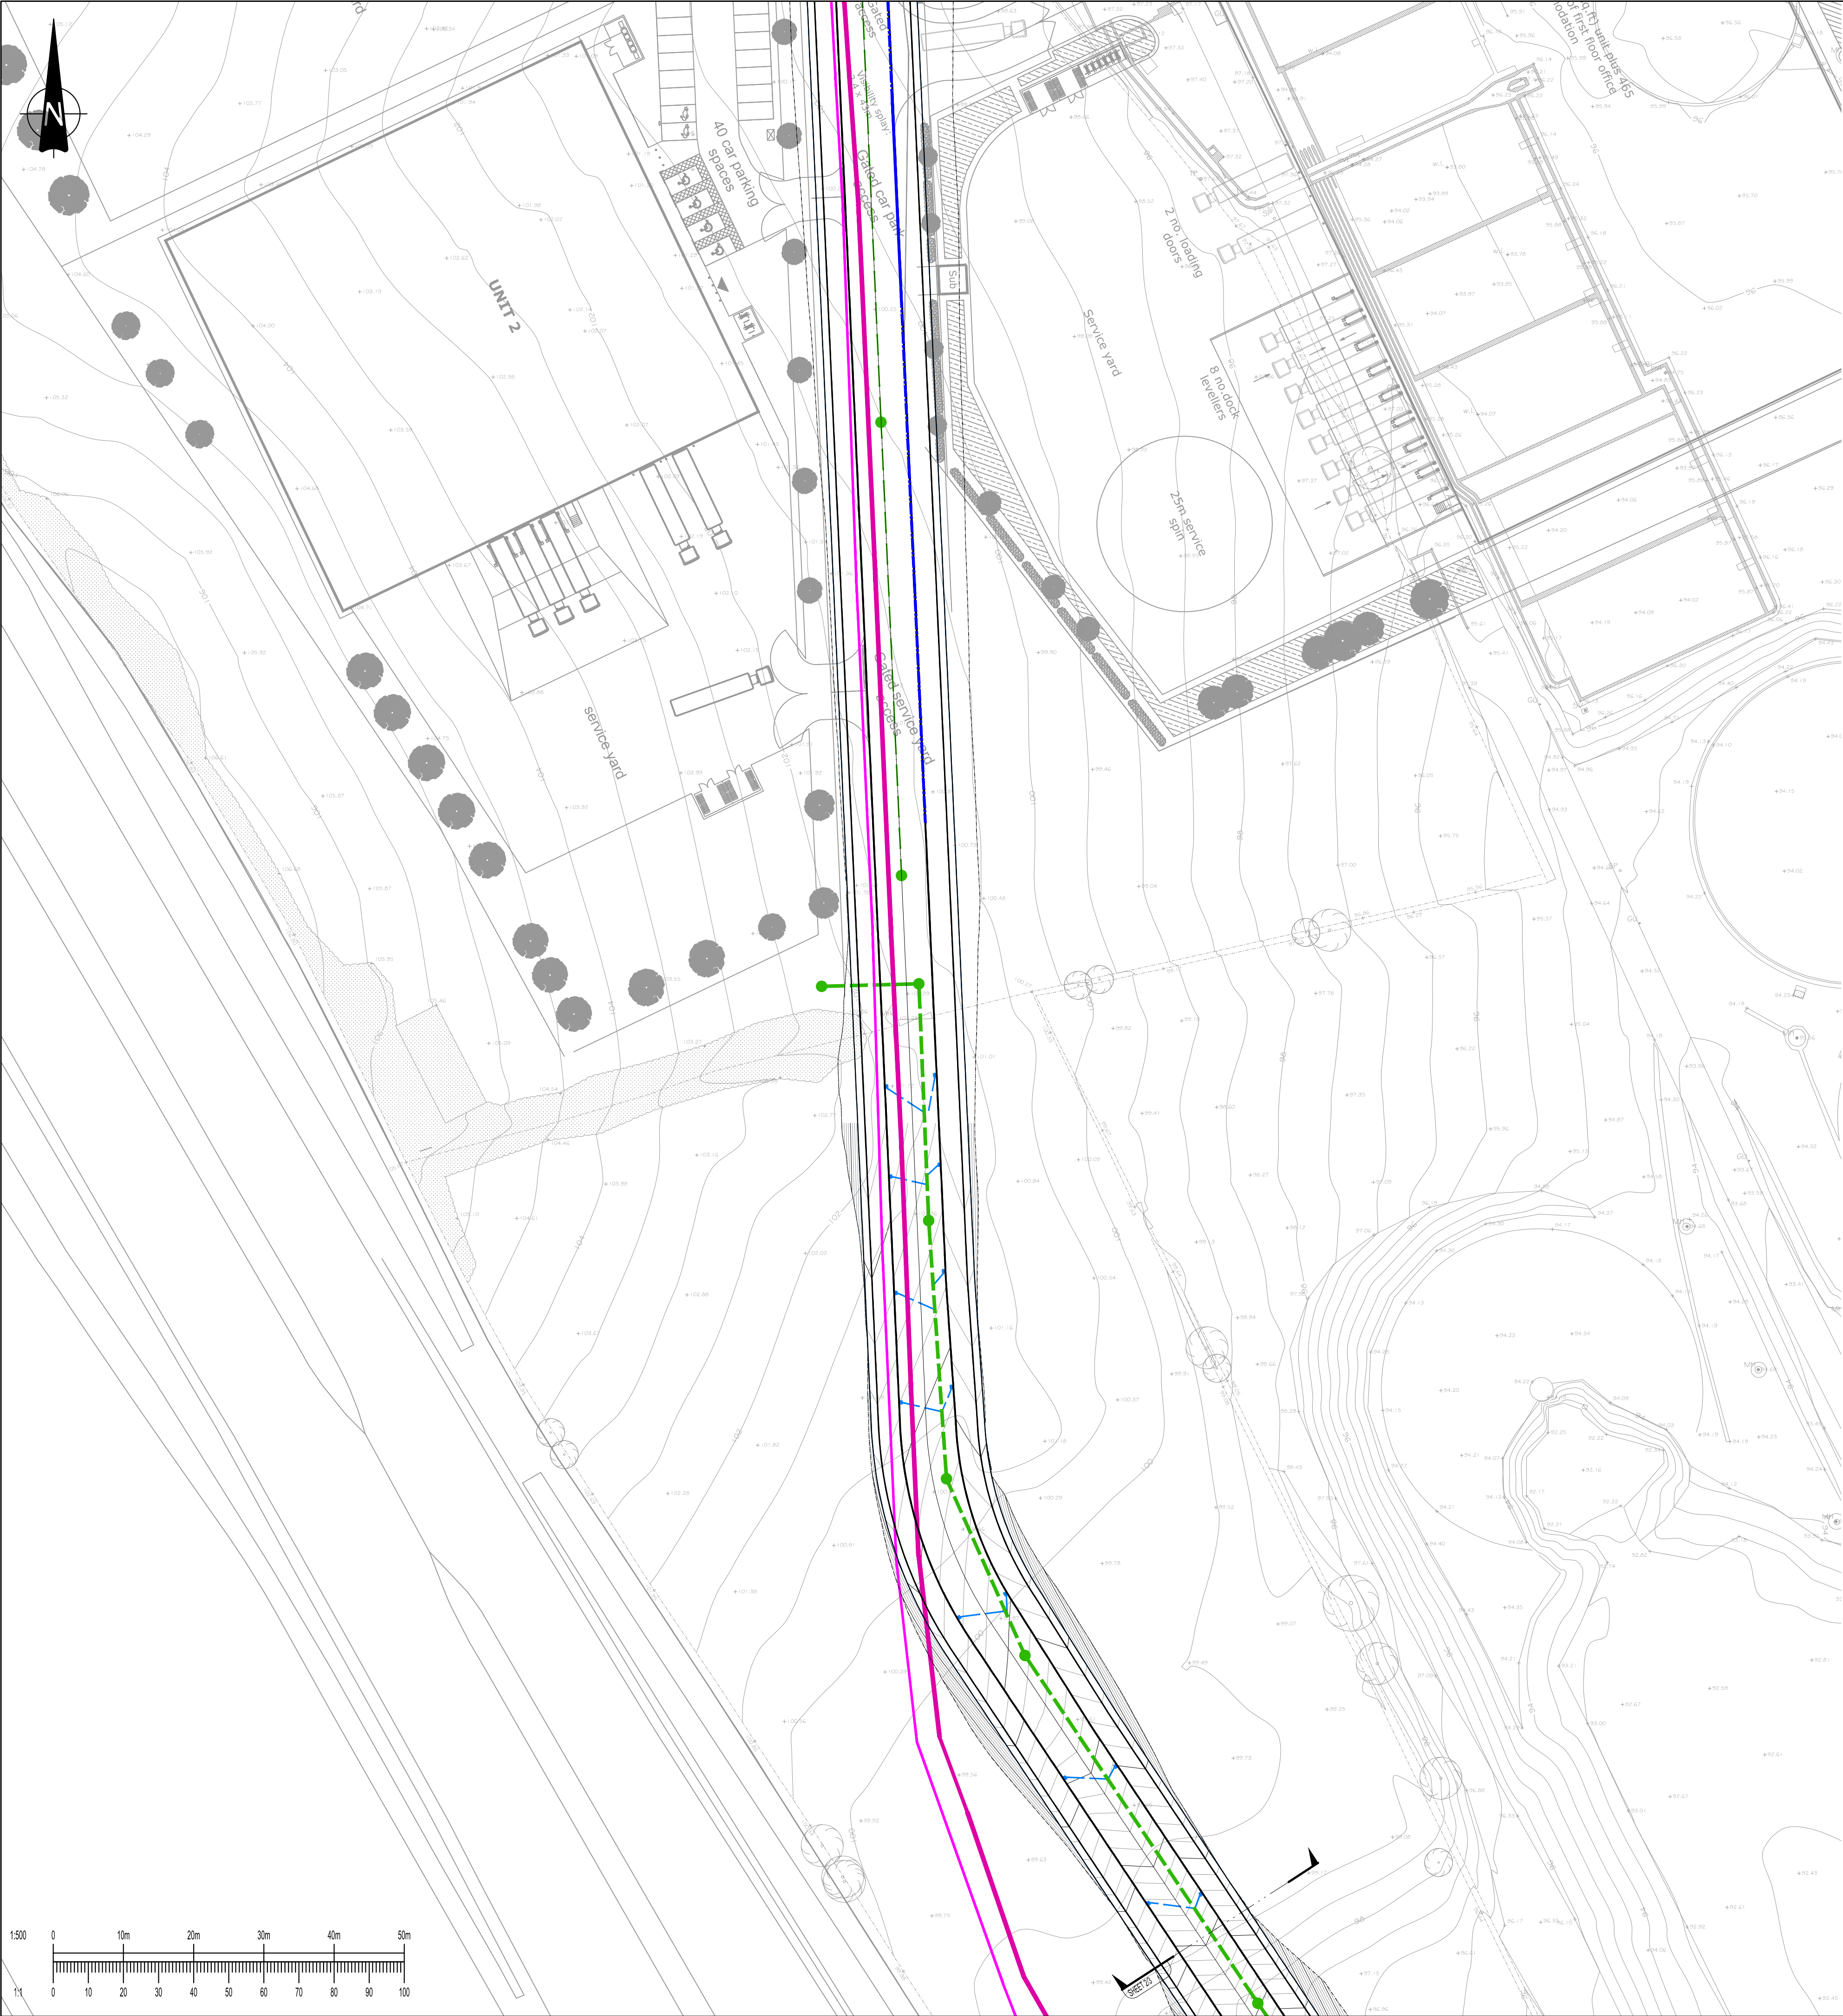

GENERAL NOTES:

- THIS DRAWING IS TO BE READ IN CONJUNCTION WITH ALL RELEVANT ARCHITECTS AND ENGINEERS DRAWINGS AND SPECIFICATIONS.
- DO NOT SCALE FROM THIS DRAWING. ANY OMISSIONS OR ERRORS ON DRAWINGS SHALL BE BROUGHT TO THE ENGINEERS ATTENTION IMMEDIATELY. ALL DIMENSIONS MUST BE CHECKED / VERIFIED ON SITE.
- ALL DIMENSIONS ARE IN MILLIMETRES UNLESS NOTED OTHERWISE.
- ALL LIGHTING COLUMNS, UTILITIES & COMMUNICATION LINES TO BE RELOCATED TO BACK OF PROPOSED FOOTWAY.
- CARRIAGEWAY AND FOOTWAY WORKS SUBJECT TO TECHNICAL APPROVAL BY CBMDC HIGHWAYS AND APPROPRIATE LEGAL AGREEMENTS.

KEY

- MARSHALLS "BEANY BLOCK" COMBINED KERB DRAINAGE ON 365mm BASE UNIT. (100mm UPSTAND)
- MARSHALLS "BEANY BLOCK" COMBINED KERB DRAINAGE ON 365mm BASE UNIT. (0mm UPSTAND)
- ADOPTABLE HIGHWAY SEWER (S38 AGREEMENT)
- ADOPTABLE SURFACE WATER SEWER (YW)
- ADOPTABLE FOUL WATER SEWER (YW)
- ROAD GULLY
- EXISTING GAS MAIN 600 / 450mm DIAMETER
- EXISTING SURFACE WATER SEWER
- EXISTING Ø450mm GAS MAINS
- EXISTING Ø600mm GAS MAINS

P07	HIGHWAY ALIGNMENT AMENDED	05/11/21	JDB	JC
P06	REVISED TO KIRKLEES COMMENTS	21/09/21	JDB	AS
P05	REVISED TO KIRKLEES COMMENTS	29/04/21	OT	OT
P04	REVISED TO SUIT S104 DRAWINGS	07/07/20	OT	OT
P03	REMOVED PLOT DETAIL	15/05/20	OT	OT
P02	REVISED TO NEW ROAD ALIGNMENT	17/04/20	OT	OT
P01	FIRST ISSUE	17/01/20	OT	OT
Rev:	Description:	Date:	By:	Chkd:



Rose Wharf Ground Floor, 78-80 East Street, Leeds, LS9 8EE
0113 274 8509
leeds@curtins.com
www.curtins.com

Civils & Structures • Transport Planning • Environmental • Infrastructure • Geotechnical • Conservation & Heritage • Principal Designer
Birmingham • Bristol • Cambridge • Cardiff • Douglas • Dublin • Edinburgh • Glasgow • Kentish • Leeds • Liverpool • London • Manchester • Nottingham

Status: ISSUED FOR INFORMATION **S2**

Project: INTERCHANGE 26,
NORTH BIERLEY

Orig Title: S38 DRAINAGE LAYOUT
SHEET 3

Size:	Date:	Drawn By:	Designed By:	Checked By:			
A1	17/01/20	OT	OT	AMB			
Scale: 1:500							
Project No:	Originator:	Volume:	Level:	Type:	Role:	Category / Number:	Rev:
065646 - CUR - ZZ - ZZ - DR - C - 95513 - P0							