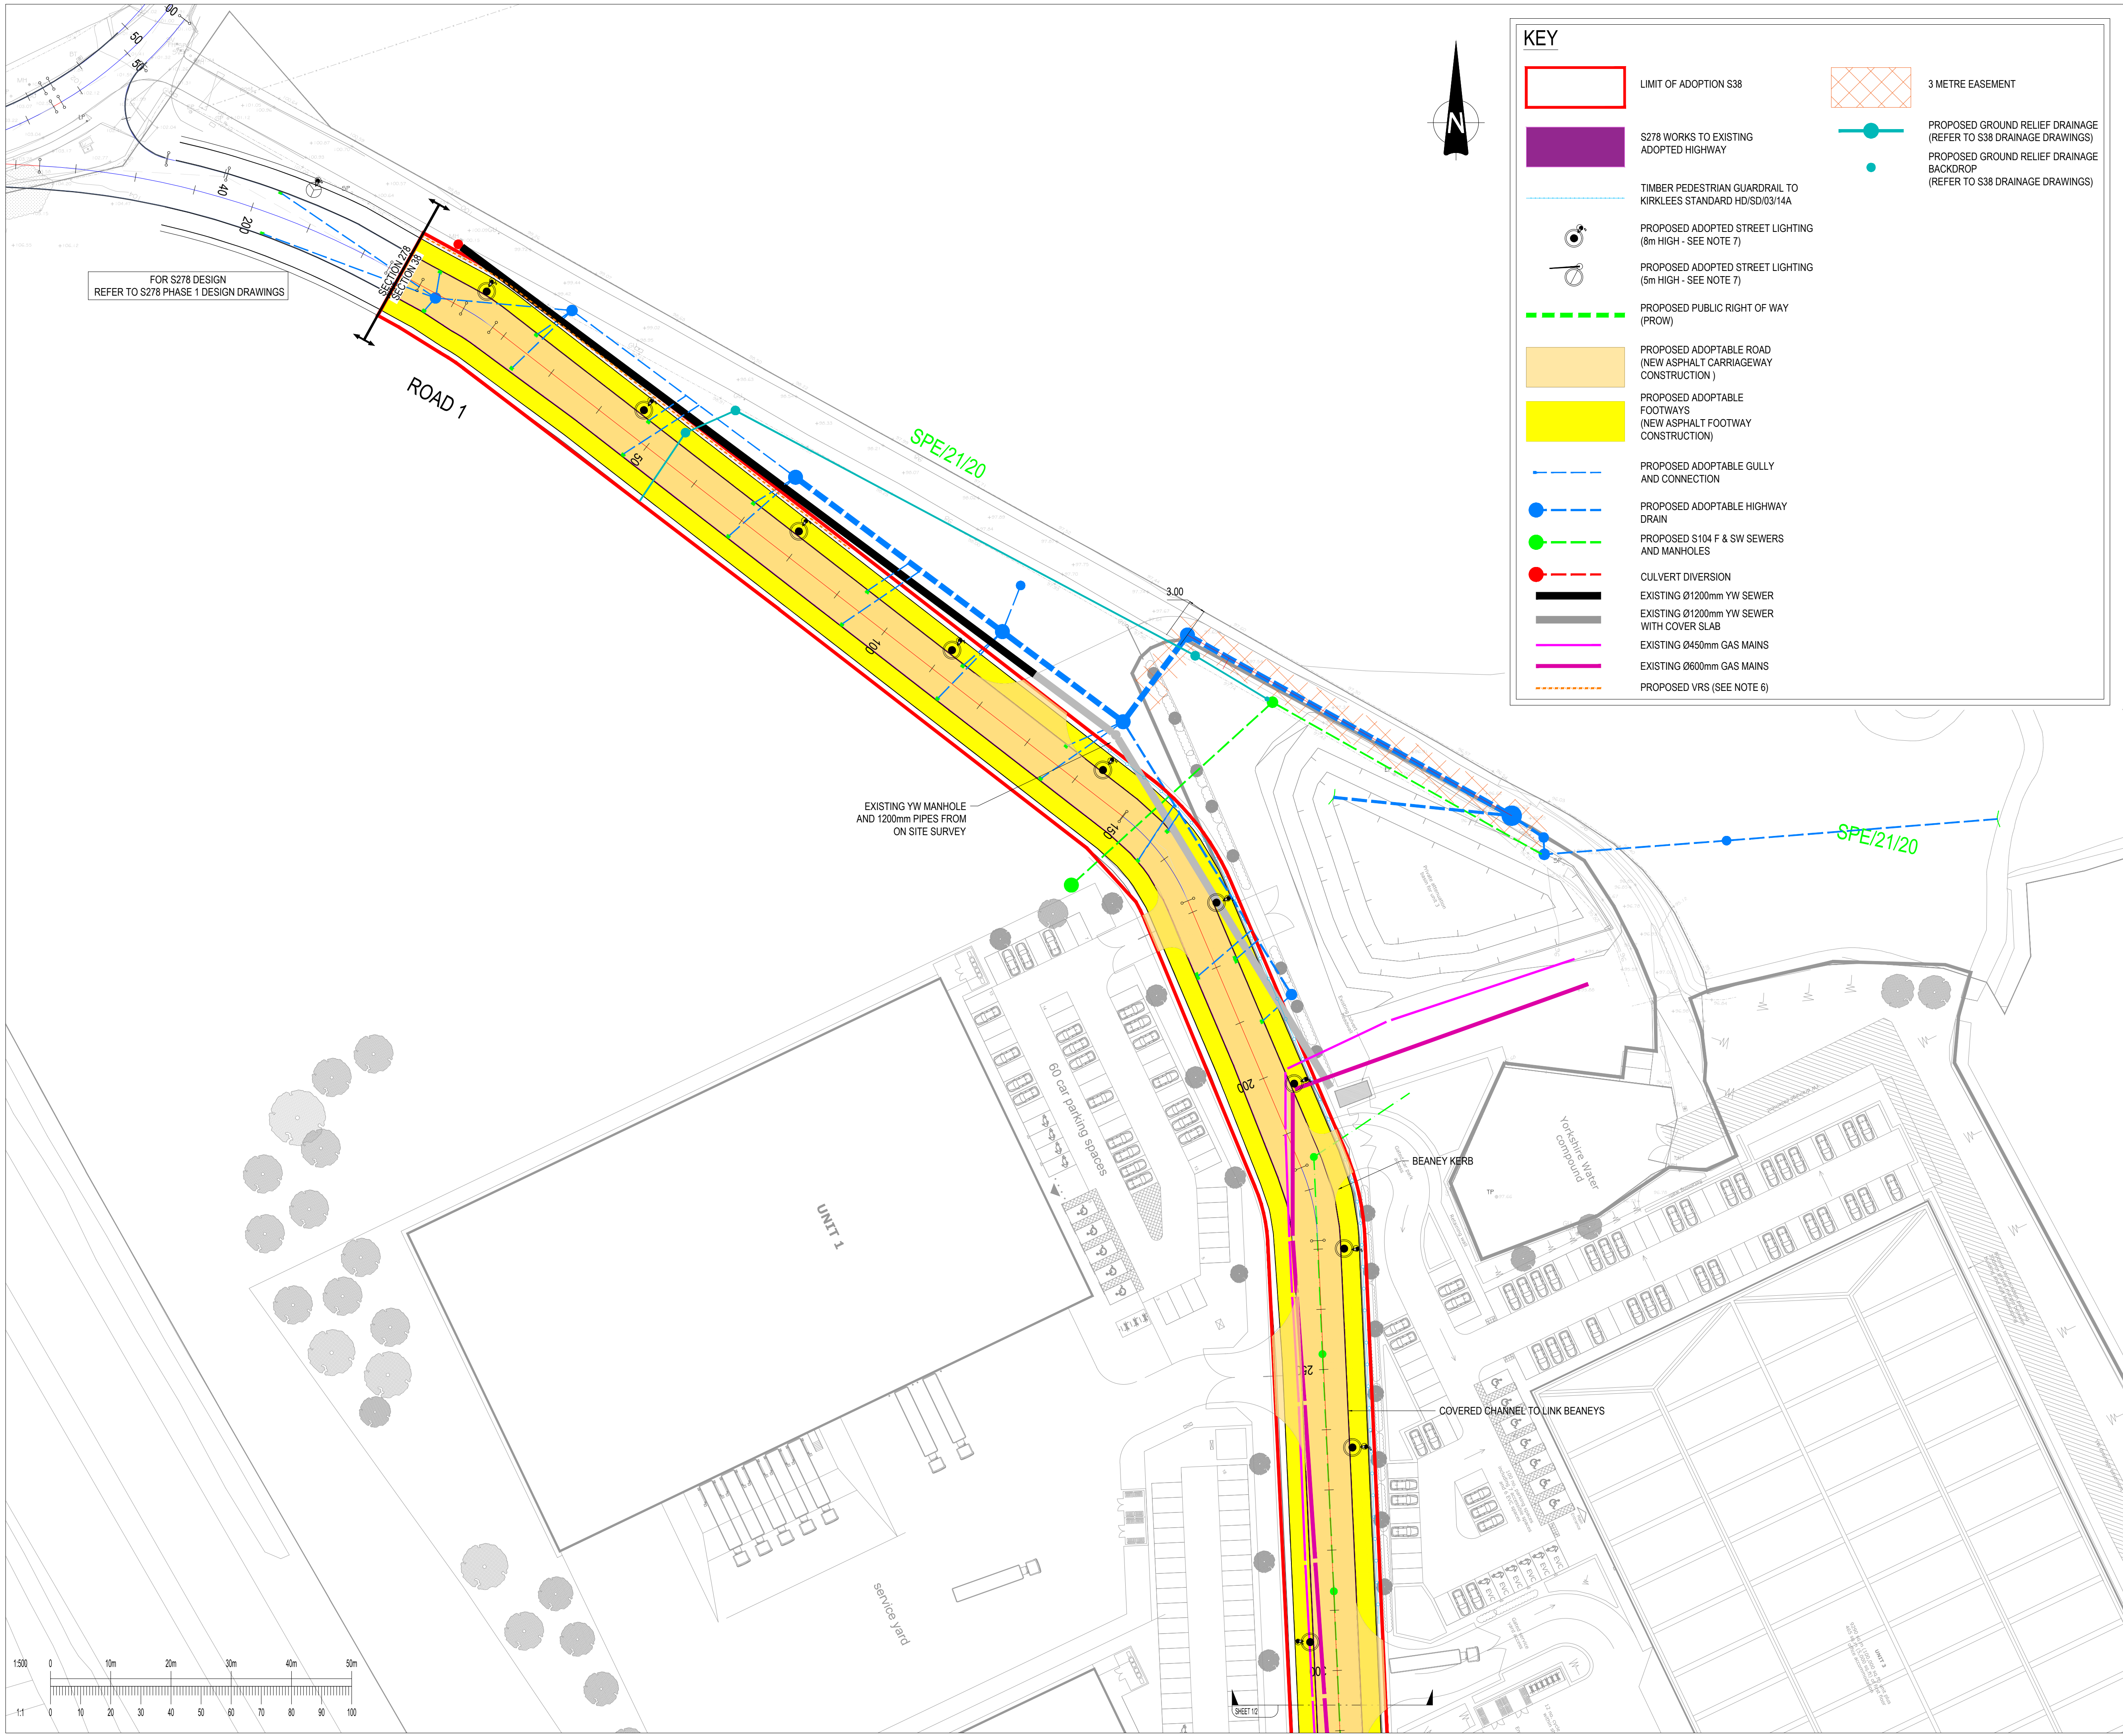


KEY

LIMIT OF ADOPTION S38

S278 WORKS TO EXISTING ADOPTED HIGHWAY

TIMBER PEDESTRIAN GUARDRAIL TO KIRKLEES STANDARD HD/SD/03/14A

PROPOSED ADOPTED STREET LIGHTING (8m HIGH - SEE NOTE 7)

PROPOSED ADOPTED STREET LIGHTING (5m HIGH - SEE NOTE 7)

PROPOSED PUBLIC RIGHT OF WAY (PROW)

PROPOSED ADOPTABLE ROAD (NEW ASPHALT CARRIAGEWAY CONSTRUCTION)

PROPOSED ADOPTABLE FOOTWAYS (NEW ASPHALT FOOTWAY CONSTRUCTION)

PROPOSED ADOPTABLE GULLY AND CONNECTION

PROPOSED ADOPTABLE HIGHWAY DRAIN

PROPOSED S104 F & SW SEWERS AND MANHOLES

CULVERT DIVERSION

EXISTING Ø1200mm YW SEWER

EXISTING Ø1200mm YW SEWER WITH COVER SLAB

EXISTING Ø450mm GAS MAINS

EXISTING Ø600mm GAS MAINS

PROPOSED VRS (SEE NOTE 6)

3 METRE EASEMENT

PROPOSED GROUND RELIEF DRAINAGE (REFER TO S38 DRAINAGE DRAWINGS)

PROPOSED GROUND RELIEF DRAINAGE BACKDROP (REFER TO S38 DRAINAGE DRAWINGS)

GENERAL NOTES:

- THIS DRAWING IS TO BE READ IN CONJUNCTION WITH ALL RELEVANT ARCHITECTS AND ENGINEERS DRAWINGS AND SPECIFICATIONS.
- DO NOT SCALE FROM THIS DRAWING. ANY OMISSIONS OR ERRORS ON DRAWINGS SHALL BE BROUGHT TO THE ENGINEERS ATTENTION IMMEDIATELY. ALL DIMENSIONS MUST BE CHECKED / VERIFIED ON SITE.
- ALL DIMENSIONS ARE IN MILLIMETRES UNLESS NOTED OTHERWISE.
- ALL LIGHTING COLUMNS, UTILITIES & COMMUNICATION LINES TO BE RELOCATED TO BACK OF PROPOSED FOOTWAY.
- CARRIAGEWAY AND FOOTWAY WORKS SUBJECT TO TECHNICAL APPROVAL BY CBMDC HIGHWAYS AND APPROPRIATE LEGAL AGREEMENTS.
- REFER TO S38 KERBING LAYOUTS FOR VRS DETAILS
- STREETLIGHT TYPES AND LOCATIONS TAKEN FROM KIRKLEES STREETLIGHTING DRAWING 6627 REV8

P15	UPDATED FOLLOWING INTERNAL S38 REVIEW	29/11/22	JC	JC
P14	VRS ADDED TO PLAN AND KEY. LATEST STREETLIGHTING PLAN ADDED	06/04/22	JC	ACS
P13	UPDATED FOLLOWING S38 REVIEW	08/03/22	JC	ACS
P12	SUPERSEDED ATTENUATION POND REMOVED FROM LAYOUT FOLLOWING GMI REQUEST SENT 07/12/21	15/12/21	JC	JC
P11	AMENDED FOLLOWING ROAD REALIGNMENT	08/11/21	JC	ACS
P10	AMENDED TO KIRKLESS COUNCIL COMMENTS RECEIVED 12/07/2021	18/08/21	JC	OT
P09	REVISED TO KIRKLEES COMMENTS DATED 14/05/21	11/06/21	OT	OT
P08	REVISED TO KIRKLEES COMMENTS DATED 12/02/21	29/04/21	EF	OT
P07	REVISED TO KIRKLEES COMMENTS DATED 14/12/20	20/01/21	OT	OT
P06	ENTRANCE ALIGNMENT AMENDED TO SUIT KIRKLEES REQUIREMENTS, EXTENTS OF S38 REDUCED TO AVOID MID CURVE ALIGNMENT START, ADDED RETAINING WALL TO MAINTAIN PROW WIDTH	21/10/20	OT	NT
P05	AMENDED UNIT 1 ENTRANCE TO SUIT NEW LAYOUT	07/07/20	OT	OT
P04	REMOVED PLOT DETAIL	15/05/20	OT	OT
P03	AMENDED TO SUIT KIRKLEES COMMENTS AND REVISED ALIGNMENT	17/04/20	OT	OT
P02	AMENDED COLOURS TO SUIT KIRKLEES REQUIREMENTS	17/01/20	OT	OT
P01	FIRST ISSUE	17/10/19	OT	AMB
Rev:	Description:	Date:	By:	Chkd:

Rose Wharf Ground Floor, 78-80 East Street, Leeds, LS9 8EE
0113 274 8509
leeds@curtins.com
www.curtins.com

Civils & Structures • Transport Planning • Environmental • Infrastructure • Geotechnical • Conservation & Heritage • Principal Designer
Birmingham • Bristol • Cambridge • Cardiff • Douglas • Dublin • Edinburgh • Glasgow • Kentish • Leeds • Liverpool • London • Manchester • Nottingham

Status:ISSUED FOR INFORMATION

Project:INTERCHANGE 26,
NORTH BIERLEY

Orig Title:S38 LAYOUT
SHEET 1

Size:	Date:	Drawn By:	Designed By:	Checked By:
A1	17/10/19	OT	OT	AMB

Scale: 1:500	Project No:	Originator:	Volume:	Level:	Type:	Role:	Category / Number:	Rev:
	065646	CUR	ZZ	ZZ	DR	C	95101	P15

\\nas02\Projects\065646 FRA Addendum N Bierley WTW\DWGS 4 Production\48 Notes & Drawings_Col-CAD\065646