



SITE LOCATION

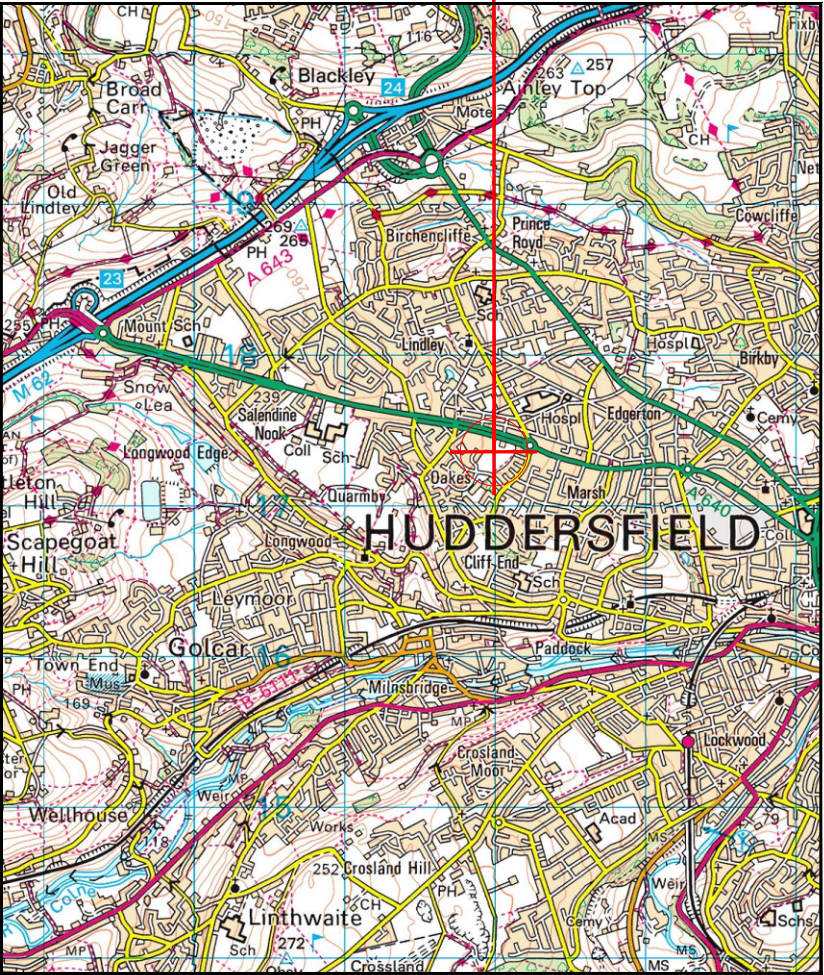

Reproduced by permission of Ordnance Survey on behalf of the Controller of Her Majesty's Stationery Office All rights reserved. © Crown Copyright licence no. 100022432

SITE AREA PLAN

 
Scale 1:50,000



SITE PHOTOGRAPH




SITE LOCATION

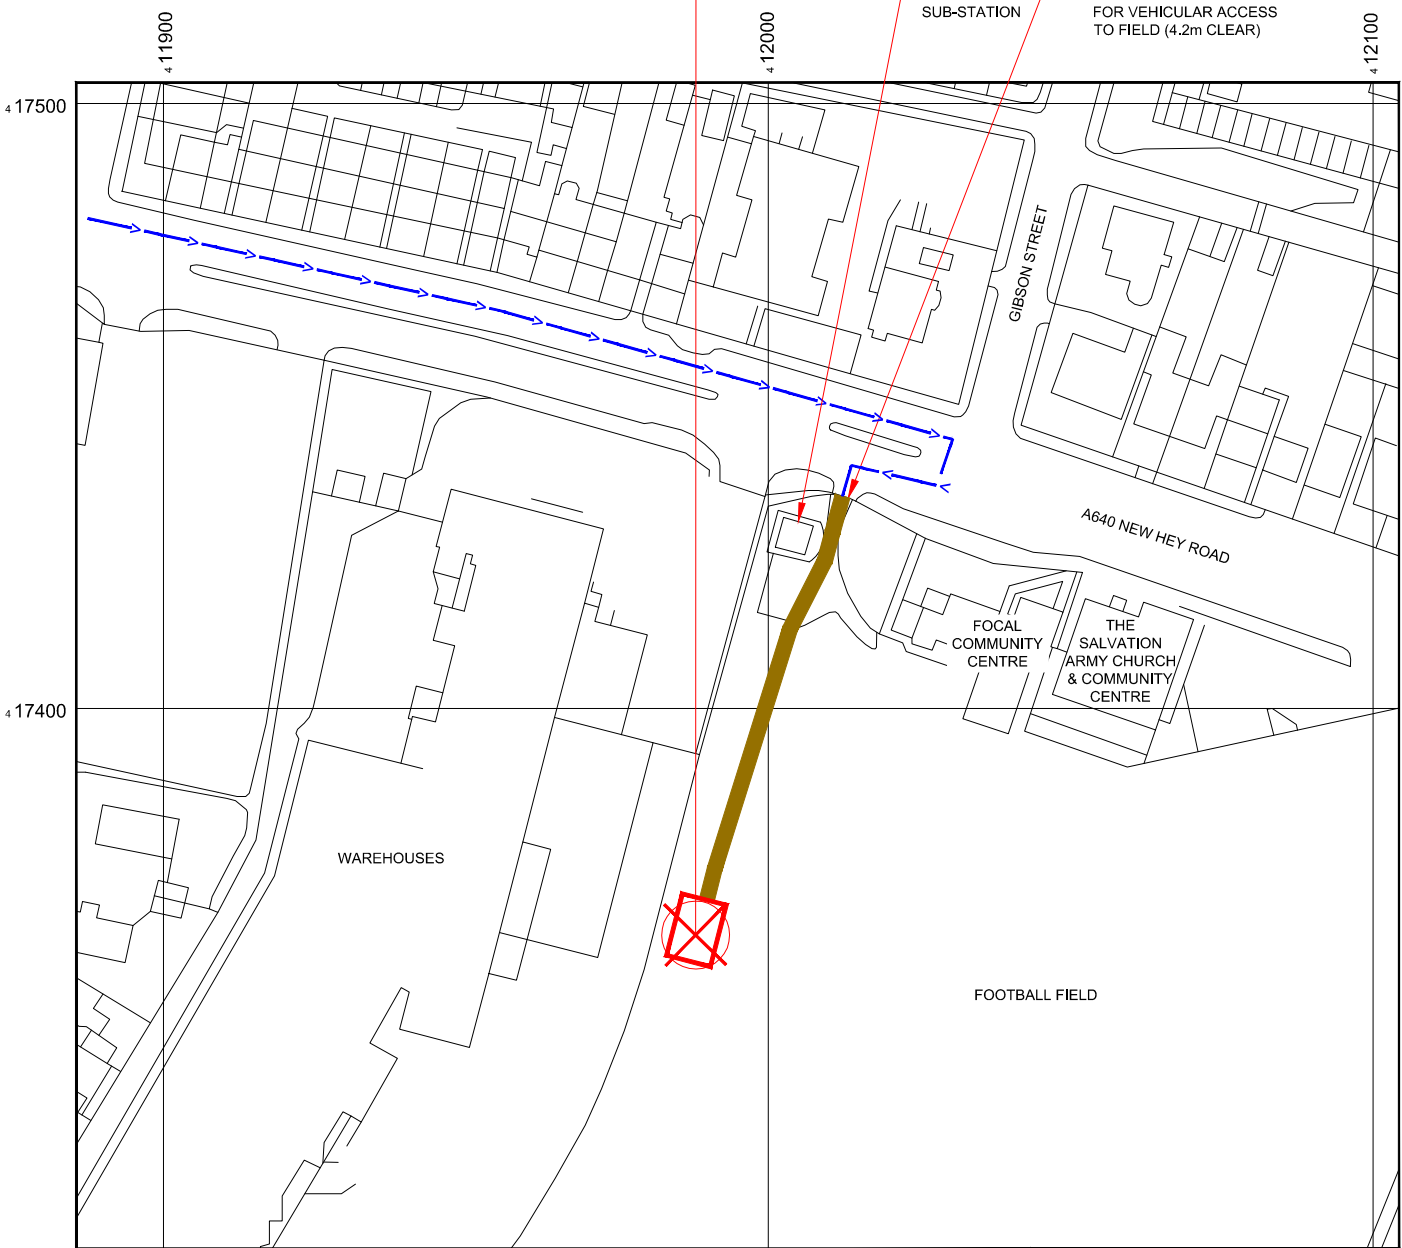

Reproduced by permission of Ordnance Survey on behalf of the Controller of Her Majesty's Stationery Office All rights reserved. © Crown Copyright licence no. 100022432

SITE LOCATION PLAN

 Scale 1:1250



GOOGLE MAPS QR CODE

GOOGLE MAP - <https://goo.gl/maps/8cLDsHQo5cN2BwJP7>

NOTES:

1. ALL DIMENSIONS IN MM UNLESS OTHERWISE NOTED.

From M62 junction 23 take the A640 towards Huddersfield. The field access barrier is on the right hand side after approx 2.5km.

Site Provider's Property Boundary:



Access Route To Site:



Access Route:



Master:	MBNL / EE / H3G:	Project:	NTQ	Purpose of Issue:	Construction	Issue:	B2
Date:	22/03/21	Revision / Upgrade Description: EE Antenna Line Configuration & Antenna schedule amended					
Drawn:	R.Perkins						
Checked:	A.Fanning						
Approved:	P.Convery						
Master:	MBNL / EE / H3G:	Project:	NTQ	Purpose of Issue:	Construction	Issue:	B1
Date:	09/03/21	Revision / Upgrade Description: Construction Issue					
Drawn:	R.Perkins						
Checked:	A.Fanning						
Approved:	P.Convery						
Master:	MBNL / EE / H3G:	Project:	NTQ	Purpose of Issue:	Planning	Issue:	B
Date:	22/02/21	Revision / Upgrade Description: Cabinets & Antenna lengths updated, H3 design added					
Drawn:	R.Perkins						
Checked:	A.Fanning						
Approved:	P.Convery						
Master:	MBNL / EE / H3G:	Project:	NTQ	Purpose of Issue:	Construction	Issue:	A1
Date:	17/11/20	Revision / Upgrade Description: Construction Issue					
Drawn:	R.Perkins						
Checked:	A.Fanning						
Approved:	P.Convery						
Master:	MBNL / EE / H3G:	Project:	NTQ	Purpose of Issue:	Planning	Issue:	A
Date:	28/10/20	Revision / Upgrade Description: First Issue					
Drawn:	J. BOOTE						
Checked:	J. STOCKDALE						
Approved:	J. STOCKDALE						



Hutchison 3G UK Limited
Star House, 20 Grenfell Road
Maudershead, SL8 1EH
Tel: 01628 765 000
Fax: 01628 765 001



Hatfield Business Park
Hatfield
Hertfordshire
AL10 9BW
Tel: 01707 315000
Fax: 01707 319001



Mobile Broadband Network Limited
Sixth Floor, Thames Tower, Station Road, Reading, RG1 1LX

Design Consultant & Principal Contractor:




WHP Telecoms
Unit 1 Maple Park,
Low Fields Avenue, Leeds
LS12 6HH

Tel: 01133023550
e-mail: info@whptelecoms.com



Site Name:	FOCAL COMMUNITY CENTRE		
Site ID:	1622519		
Address:	FOCAL COMMUNITY CENTRE, NEW HEY ROAD, HUDDERSFIELD, WEST YORKSHIRE, HD3 4DD		
Title:	002 SITE LOCATION PLAN		
Project:	NTQ		
Purpose of Issue:	CONSTRUCTION		
EE Cell ID:	78183	MBNL Cell ID:	KKS206
3UK Cell ID:	HD0192		
Master Drawing No:	1622519_KKS206_78183_HD0192_M005		
Issue:	B2		



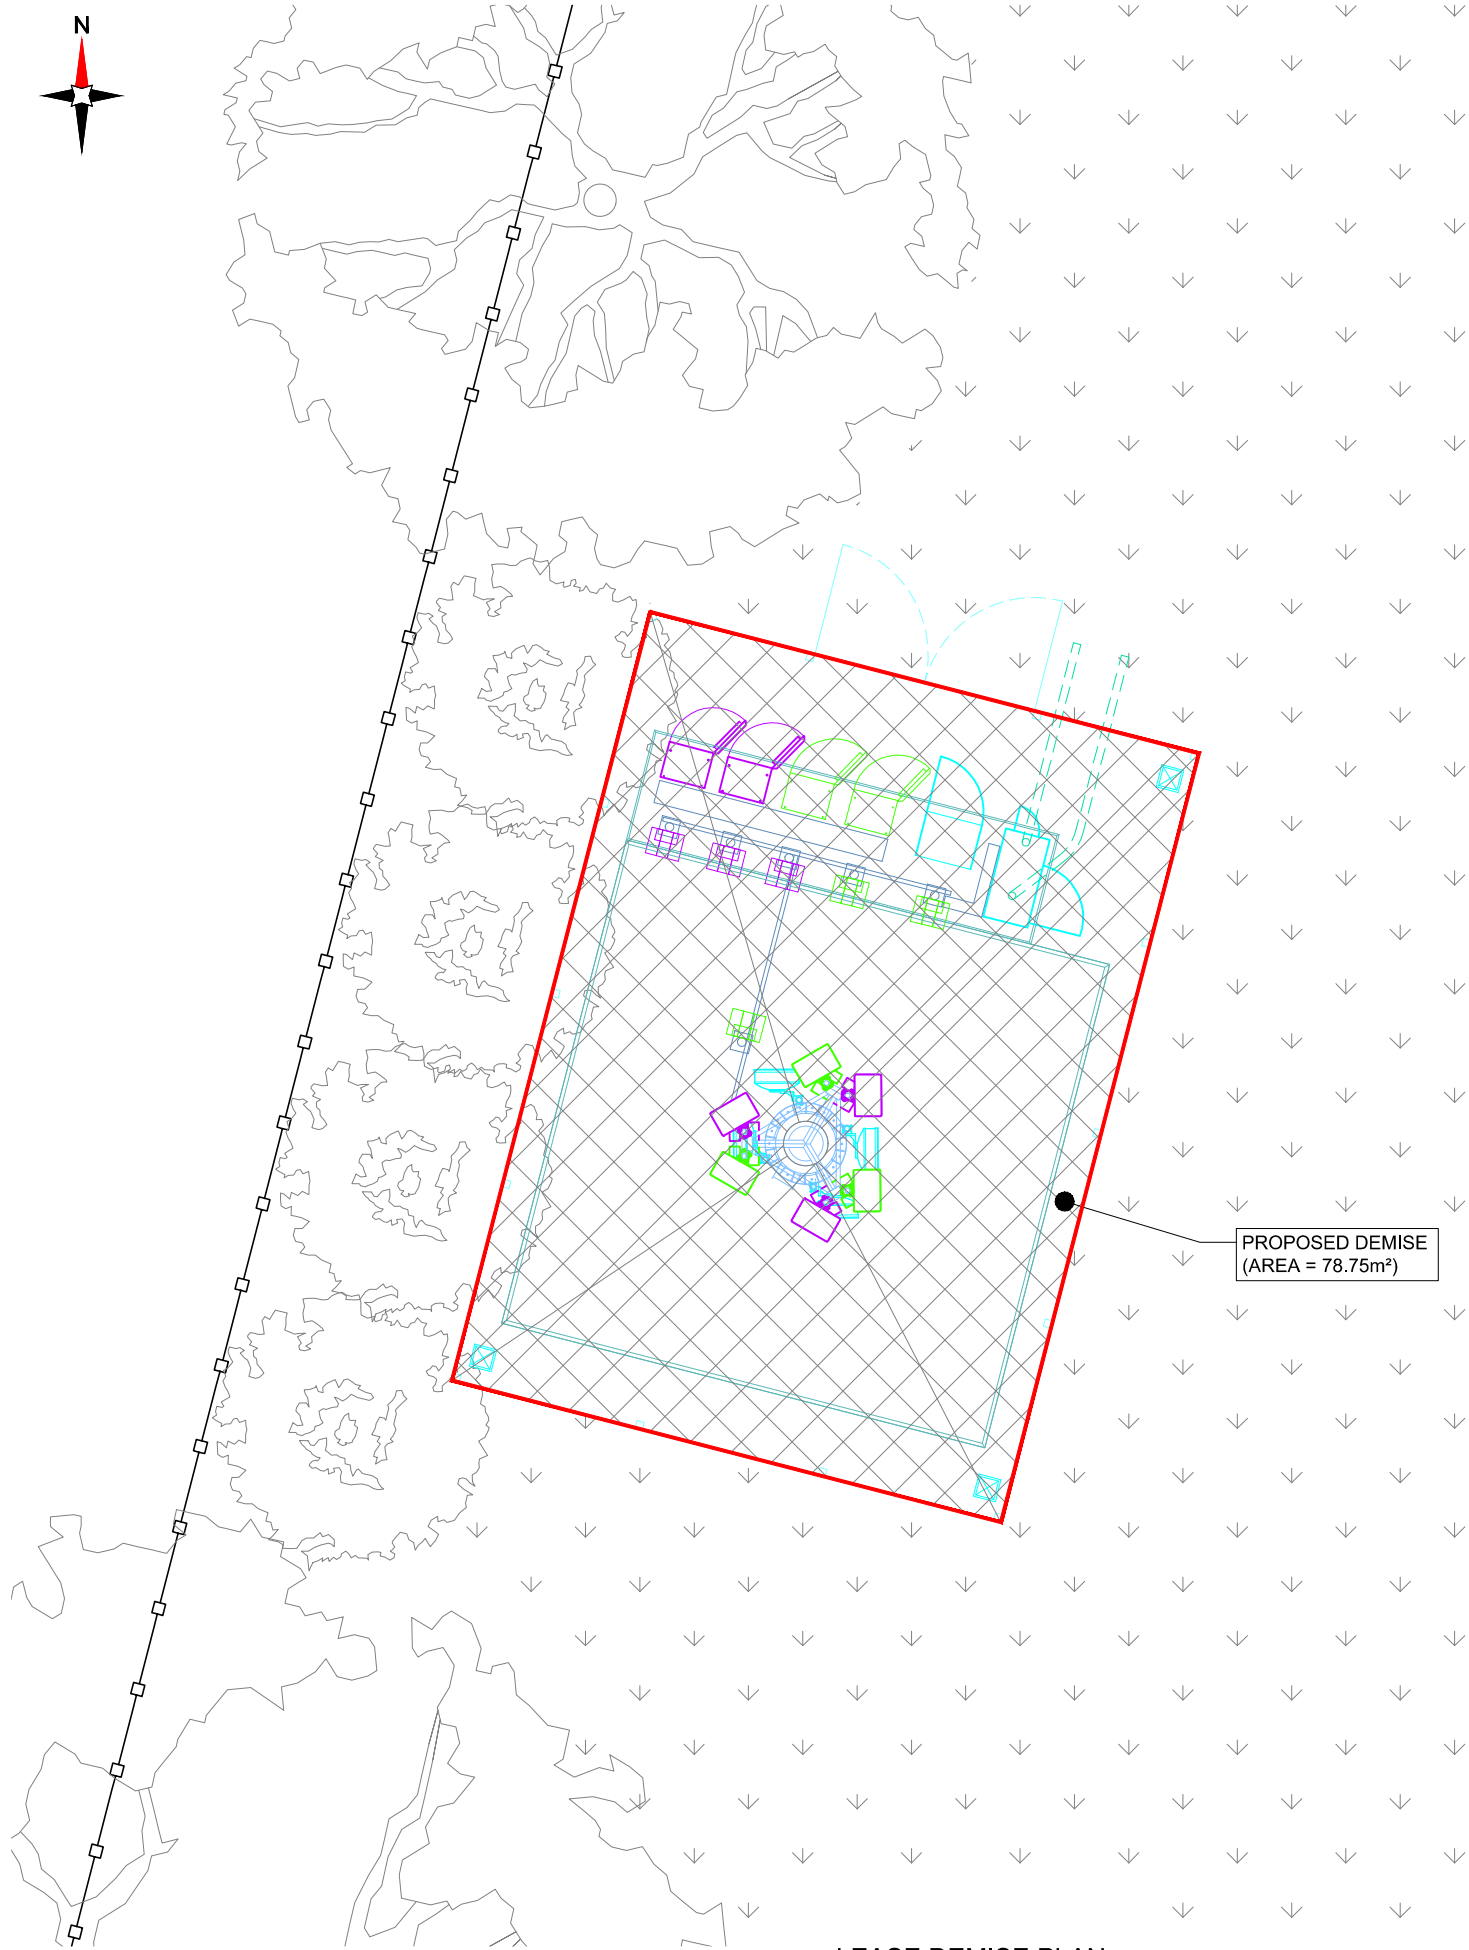

LEASE DEMISE PLAN

 Scale 1:100

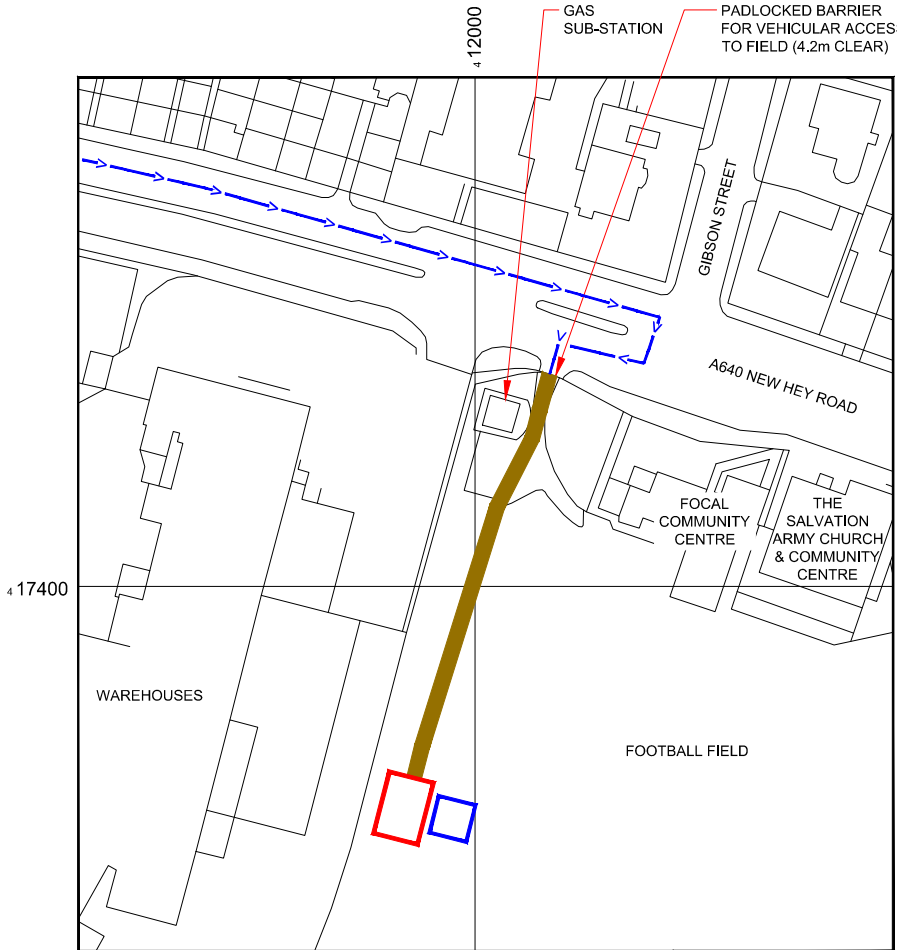


Reproduced by permission of Ordnance Survey on behalf of the Controller of Her Majesty's Stationery Office All rights reserved. © Crown Copyright licence no. 100022432

NGR E: 411990
N: 417365

SITE LOCATION PLAN

 Scale 1:1250



NEW CODE:		
Demise:	Outlined in Red	
Access Route:	Solid Brown	
Set Down Area:	Outlined in Blue	

Master:	MBNL / EE / H3G	Project:	NTQ	Purpose of Issue:	Construction	Issue:	B2
Date:	22/03/21	Revision / Upgrade Description:					
Drawn:	R.Perkins	EE Antenna Line Configuration & Antenna schedule amended					
Checked:	A.Fanning						
Approved:	P.Convery						
Master:	MBNL / EE / H3G	Project:	NTQ	Purpose of Issue:	Construction	Issue:	B1
Date:	09/03/21	Revision / Upgrade Description:					
Drawn:	R.Perkins	Construction Issue					
Checked:	A.Fanning						
Approved:	P.Convery						
Master:	MBNL / EE / H3G	Project:	NTQ	Purpose of Issue:	Planning	Issue:	B
Date:	22/02/21	Revision / Upgrade Description:					
Drawn:	R.Perkins	Cabinets & Antenna lengths updated, H3 design added					
Checked:	A.Fanning						
Approved:	P.Convery						
Master:	MBNL / EE / H3G	Project:	NTQ	Purpose of Issue:	Construction	Issue:	A1
Date:	17/11/20	Revision / Upgrade Description:					
Drawn:	R.Perkins	Construction Issue					
Checked:	A.Fanning						
Approved:	P.Convery						
Master:	MBNL / EE / H3G	Project:	NTQ	Purpose of Issue:	Planning	Issue:	A
Date:	28/10/20	Revision / Upgrade Description:					
Drawn:	J. BOOTE	First Issue					
Checked:	J. STOCKDALE						
Approved:	J. STOCKDALE						



Hutchison 3G UK Limited
Star House, 20 Grenfell Road
Maidenhead, SL6 1EH
Tel: 01628 765 000
Fax: 01628 765 001



Hatfield Business Park
Hatfield
Hertfordshire
AL10 9BW
Tel: 01707 315000
Fax: 01707 319001



Mobile Broadband Network Limited
Sixth Floor, Thames Tower, Station Road, Reading, RG1 1LX

Design Consultant & Principal Contractor:



WHP Telecoms
Unit 1 Maple Park,
Low Fields Avenue, Leeds
LS12 6HH

Tel: 01133023550
e-mail: info@whptelecoms.com

Site Name:
FOCAL COMMUNITY CENTRE

Site ID:
1622519

Address:
FOCAL COMMUNITY CENTRE,
NEW HEY ROAD,
HUDDERSFIELD,
WEST YORKSHIRE,
HD3 4DD


Title:
004 LEASE DEMISE & LOCATION PLAN

Project:
NTQ

Purpose of Issue:
CONSTRUCTION

EE Cell ID: 78183	MBNL Cell ID: KKS206	3UK Cell ID: HD0192
----------------------	-------------------------	------------------------

Master Drawing No: 1622519_KKS206_78183_HD0192_M005	Issue: B2
--	--------------

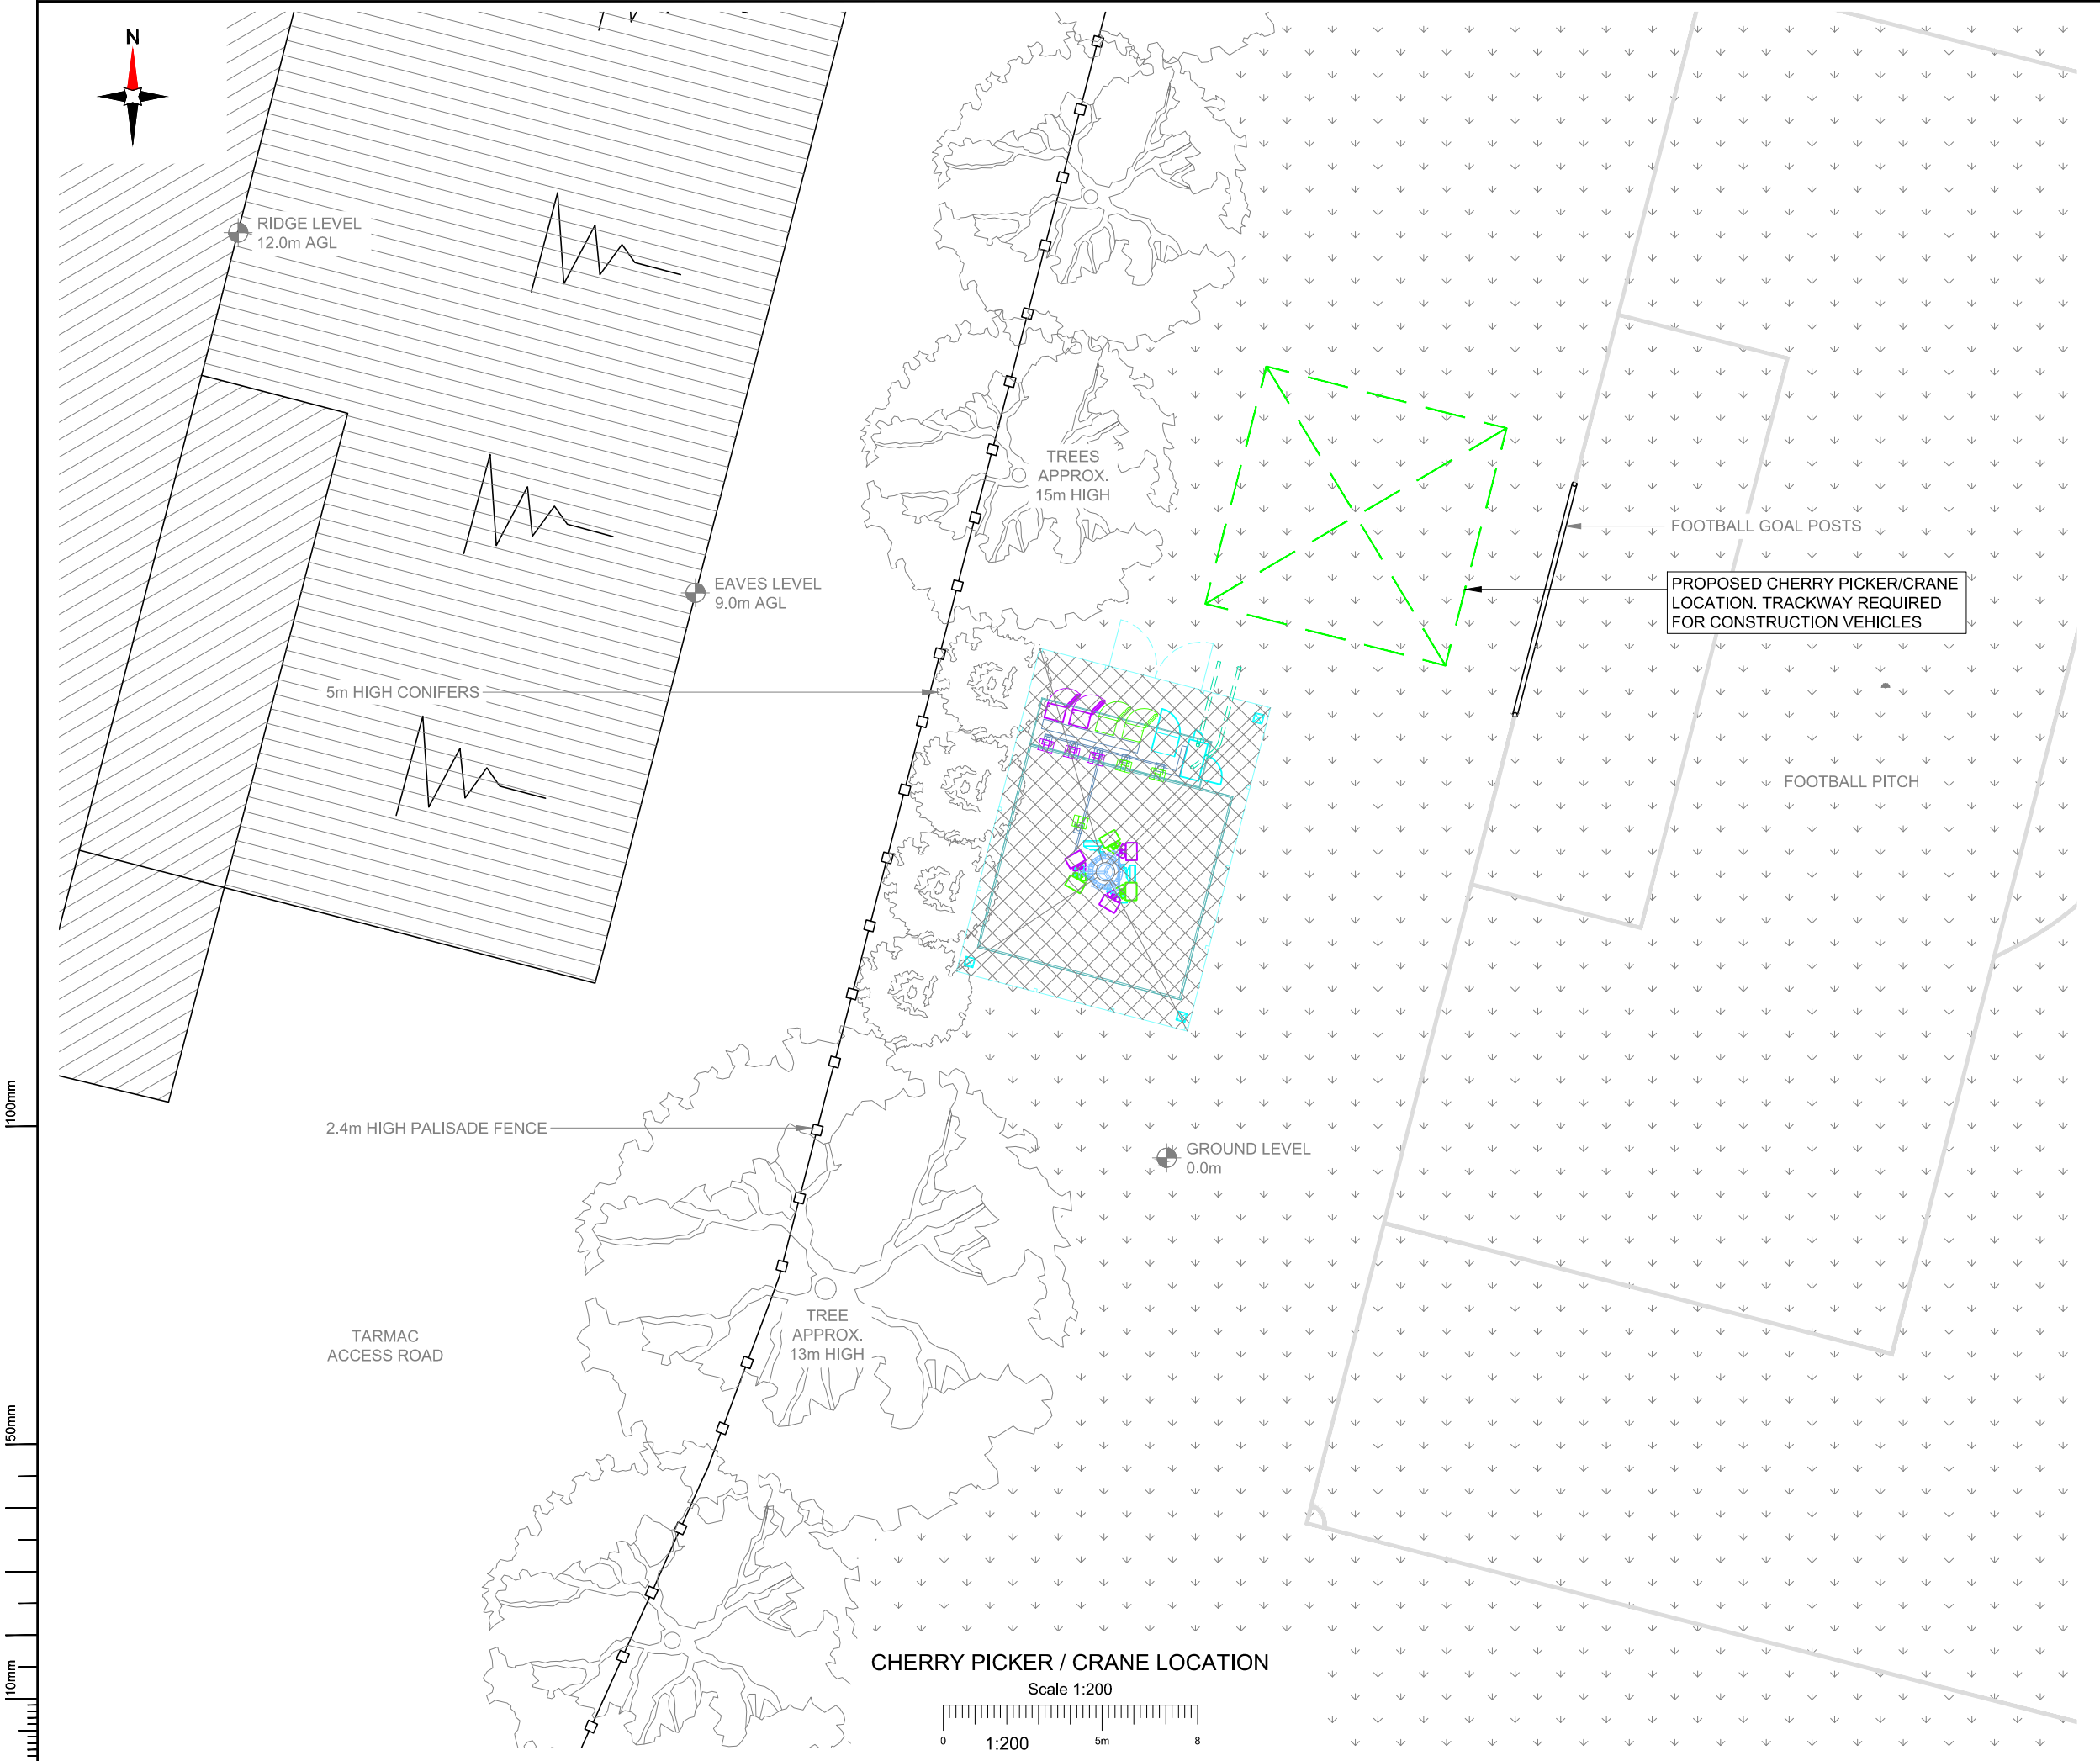

NOTES:

1. ALL DIMENSIONS IN MM UNLESS OTHERWISE NOTED.

PROPOSED CRANE OR CHERRY PICKER LOCATION:

Master:	MBNL / EE / H3G:	Project:	Purpose of Issue:	Issue:
M005	MBNL	NTQ	Construction	B2
Date:	22/03/21	Revision / Upgrade Description:		
Drawn:	R.Perkins	EE Antenna Line Configuration & Antenna schedule amended		
Checked:	A.Fanning			
Approved:	P.Convery			
Master:	MBNL / EE / H3G:	Project:	Purpose of Issue:	Issue:
M004	MBNL	NTQ	Construction	B1
Date:	09/03/21	Revision / Upgrade Description:		
Drawn:	R.Perkins	Construction Issue		
Checked:	A.Fanning			
Approved:	P.Convery			
Master:	MBNL / EE / H3G:	Project:	Purpose of Issue:	Issue:
M003	MBNL	NTQ	Planning	B
Date:	22/02/21	Revision / Upgrade Description:		
Drawn:	R.Perkins	Cabinets & Antenna lengths updated, H3 design added		
Checked:	A.Fanning			
Approved:	P.Convery			
Master:	MBNL / EE / H3G:	Project:	Purpose of Issue:	Issue:
M002	MBNL	NTQ	Construction	A1
Date:	17/11/20	Revision / Upgrade Description:		
Drawn:	R.Perkins	Construction Issue		
Checked:	A.Fanning			
Approved:	P.Convery			
Master:	MBNL / EE / H3G:	Project:	Purpose of Issue:	Issue:
M001	MBNL	NTQ	Planning	A
Date:	28/10/20	Revision / Upgrade Description:		
Drawn:	J. BOOTE	First Issue		
Checked:	J. STOCKDALE			
Approved:	J. STOCKDALE			

Hutchison 3G UK Limited
Star House, 20 Grenfell Road
Mordenhead, SLS 1EH
Tel: 01628 765 000
Fax: 01628 765 001

H3G Base Station Information line:
0845 6043000
Available: 9am-6pm Monday to Friday

Hatfield Business Park
Hatfield
Hertfordshire
AL10 9BW

Tel: 01707 315000
Fax: 01707 319001

Mobile Broadband Network Limited
Sixth Floor, Thames Tower, Station Road, Reading, RG1 1LX

Design Consultant & Principal Contractor:

WHP Telecoms
Unit 1 Maple Park,
Low Fields Avenue, Leeds
LS12 6HH

Tel: 01133023550
e-mail: info@whptelecoms.com

Site Name:
FOCAL COMMUNITY CENTRE

Site ID:
1622519

Address:
**FOCAL COMMUNITY CENTRE,
NEW HEY ROAD,
HUDDERSFIELD,
WEST YORKSHIRE,
HD3 4DD**

Title:
005 CHERRY PICKER & CRANE LOCATION

Project:
NTQ

Purpose of Issue:
CONSTRUCTION

EE Cell ID:	MBNL Cell ID:	3UK Cell ID:
78183	KKS206	HD0192

Master Drawing No:
1622519_KKS206_78183_HD0192_M005

Issue:
B2



NOTES:

1. ALL DIMENSIONS IN MM UNLESS OTHERWISE NOTED.

Master:	MBNL / EE / H3G:	Project:	Purpose of Issue:	Issue:
M005	MBNL	NTQ	Construction	B2
Date:	22/03/21	Revision / Upgrade Description:		
Drawn:	R.Perkins	EE Antenna Line Configuration & Antenna schedule amended		
Checked:	A.Fanning			
Approved:	P.Convery			
Master:	MBNL / EE / H3G:	Project:	Purpose of Issue:	Issue:
M004	MBNL	NTQ	Construction	B1
Date:	09/03/21	Revision / Upgrade Description:		
Drawn:	R.Perkins	Construction Issue		
Checked:	A.Fanning			
Approved:	P.Convery			
Master:	MBNL / EE / H3G:	Project:	Purpose of Issue:	Issue:
M003	MBNL	NTQ	Planning	B
Date:	22/02/21	Revision / Upgrade Description:		
Drawn:	R.Perkins	Cabinets & Antenna lengths updated, H3 design added		
Checked:	A.Fanning			
Approved:	P.Convery			
Master:	MBNL / EE / H3G:	Project:	Purpose of Issue:	Issue:
M002	MBNL	NTQ	Construction	A1
Date:	17/11/20	Revision / Upgrade Description:		
Drawn:	R.Perkins	Construction Issue		
Checked:	A.Fanning			
Approved:	P.Convery			
Master:	MBNL / EE / H3G:	Project:	Purpose of Issue:	Issue:
M001	MBNL	NTQ	Planning	A
Date:	28/10/20	Revision / Upgrade Description:		
Drawn:	J. BOOTE	First Issue		
Checked:	J. STOCKDALE			
Approved:	J. STOCKDALE			



Hutchison 3G UK Limited
Star House, 20 Grenfell Road
Maidenhead, SL6 1EH
Tel: 01628 765 000
Fax: 01628 765 001



H3G Base Station Information line
0845 6043000
Available 9am-6pm Monday to Friday



Hatfield Business Park
Hatfield
Hertfordshire
AL10 9BW

Tel: 01707 315000
Fax: 01707 319001



Mobile Broadband Network Limited
Sixth Floor, Thames Tower, Station Road, Reading, RG1 1LX

Design Consultant & Principal Contractor:



WHP Telecoms
Unit 1 Maple Park,
Low Fields Avenue, Leeds
LS12 6HH

Tel: 01133023550
e-mail: info@whptelecoms.com

Site Name:

FOCAL COMMUNITY CENTRE

Site ID:

1622519

Address:

FOCAL COMMUNITY CENTRE,
NEW HEY ROAD,
HUDDERSFIELD,
WEST YORKSHIRE,
HD3 4DD

Title:

100 EXISTING SITE PLAN

Project:

NTQ

Purpose of Issue:

CONSTRUCTION


EE Cell ID:	MBNL Cell ID:	3UK Cell ID:
78183	KKS206	HD0192

Master Drawing No:	Issue:
1622519_KKS206_78183_HD0192_M005	B2

100mm


50mm

10mm

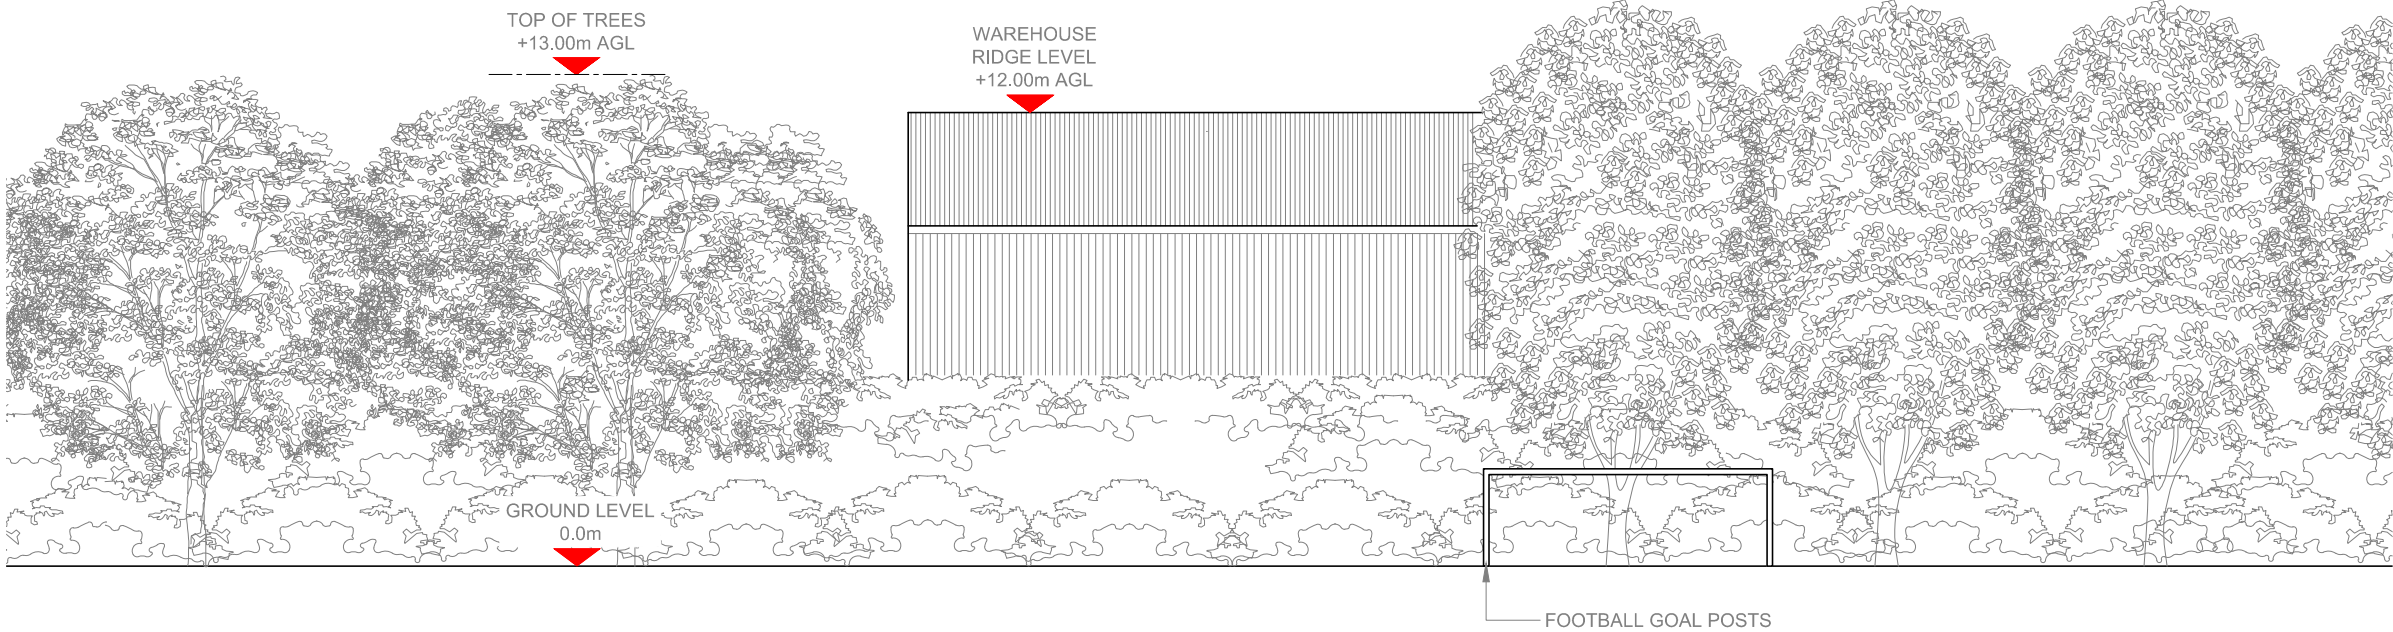

EXISTING ELEVATION A

 Scale 1:200



NOTES:

1. ALL DIMENSIONS IN MM UNLESS OTHERWISE NOTED.

Master:	MBNL / EE / H3G:	Project:	Purpose of Issue:	Issue:
M005	MBNL	NTQ	Construction	B2
Date:	22/03/21	Revision / Upgrade Description:		
Drawn:	R.Perkins	EE Antenna Line Configuration & Antenna schedule amended		
Checked:	A.Fanning			
Approved:	P.Convery			
Master:	MBNL / EE / H3G:	Project:	Purpose of Issue:	Issue:
M004	MBNL	NTQ	Construction	B1
Date:	09/03/21	Revision / Upgrade Description:		
Drawn:	R.Perkins	Construction Issue		
Checked:	A.Fanning			
Approved:	P.Convery			
Master:	MBNL / EE / H3G:	Project:	Purpose of Issue:	Issue:
M003	MBNL	NTQ	Planning	B
Date:	22/02/21	Revision / Upgrade Description:		
Drawn:	R.Perkins	Cabinets & Antenna lengths updated, H3 design added		
Checked:	A.Fanning			
Approved:	P.Convery			
Master:	MBNL / EE / H3G:	Project:	Purpose of Issue:	Issue:
M002	MBNL	NTQ	Construction	A1
Date:	17/11/20	Revision / Upgrade Description:		
Drawn:	R.Perkins	Construction Issue		
Checked:	A.Fanning			
Approved:	P.Convery			
Master:	MBNL / EE / H3G:	Project:	Purpose of Issue:	Issue:
M001	MBNL	NTQ	Planning	A
Date:	28/10/20	Revision / Upgrade Description:		
Drawn:	J. BOOTE	First Issue		
Checked:	J. STOCKDALE			
Approved:	J. STOCKDALE			



Hutchison 3G UK Limited
Star House, 20 Grenfell Road
Maidenhead, SL6 1EH
Tel: 01628 765 000
Fax: 01628 765 001



Hatfield Business Park
Hatfield
Hertfordshire
AL10 9BW
Tel: 01707 315000
Fax: 01707 319001



Mobile Broadband Network Limited
Sixth Floor, Thames Tower, Station Road, Reading, RG1 1LX

Design Consultant & Principal Contractor:



WHP Telecoms
Unit 1 Maple Park,
Low Fields Avenue, Leeds
LS12 6HH
Tel: 01133023550
e-mail: info@whptelecoms.com

Site Name:

FOCAL COMMUNITY CENTRE

Site ID:

1622519

Address:

FOCAL COMMUNITY CENTRE,
NEW HEY ROAD,
HUDDERSFIELD,
WEST YORKSHIRE,
HD3 4DD

Title:

150 EXISTING ELEVATION A


Project:

NTQ

Purpose of Issue:

CONSTRUCTION

EE Cell ID:	MBNL Cell ID:	3UK Cell ID:
78183	KKS206	HD0192
Master Drawing No:		Issue:
1622519_KKS206_78183_HD0192_M005		B2

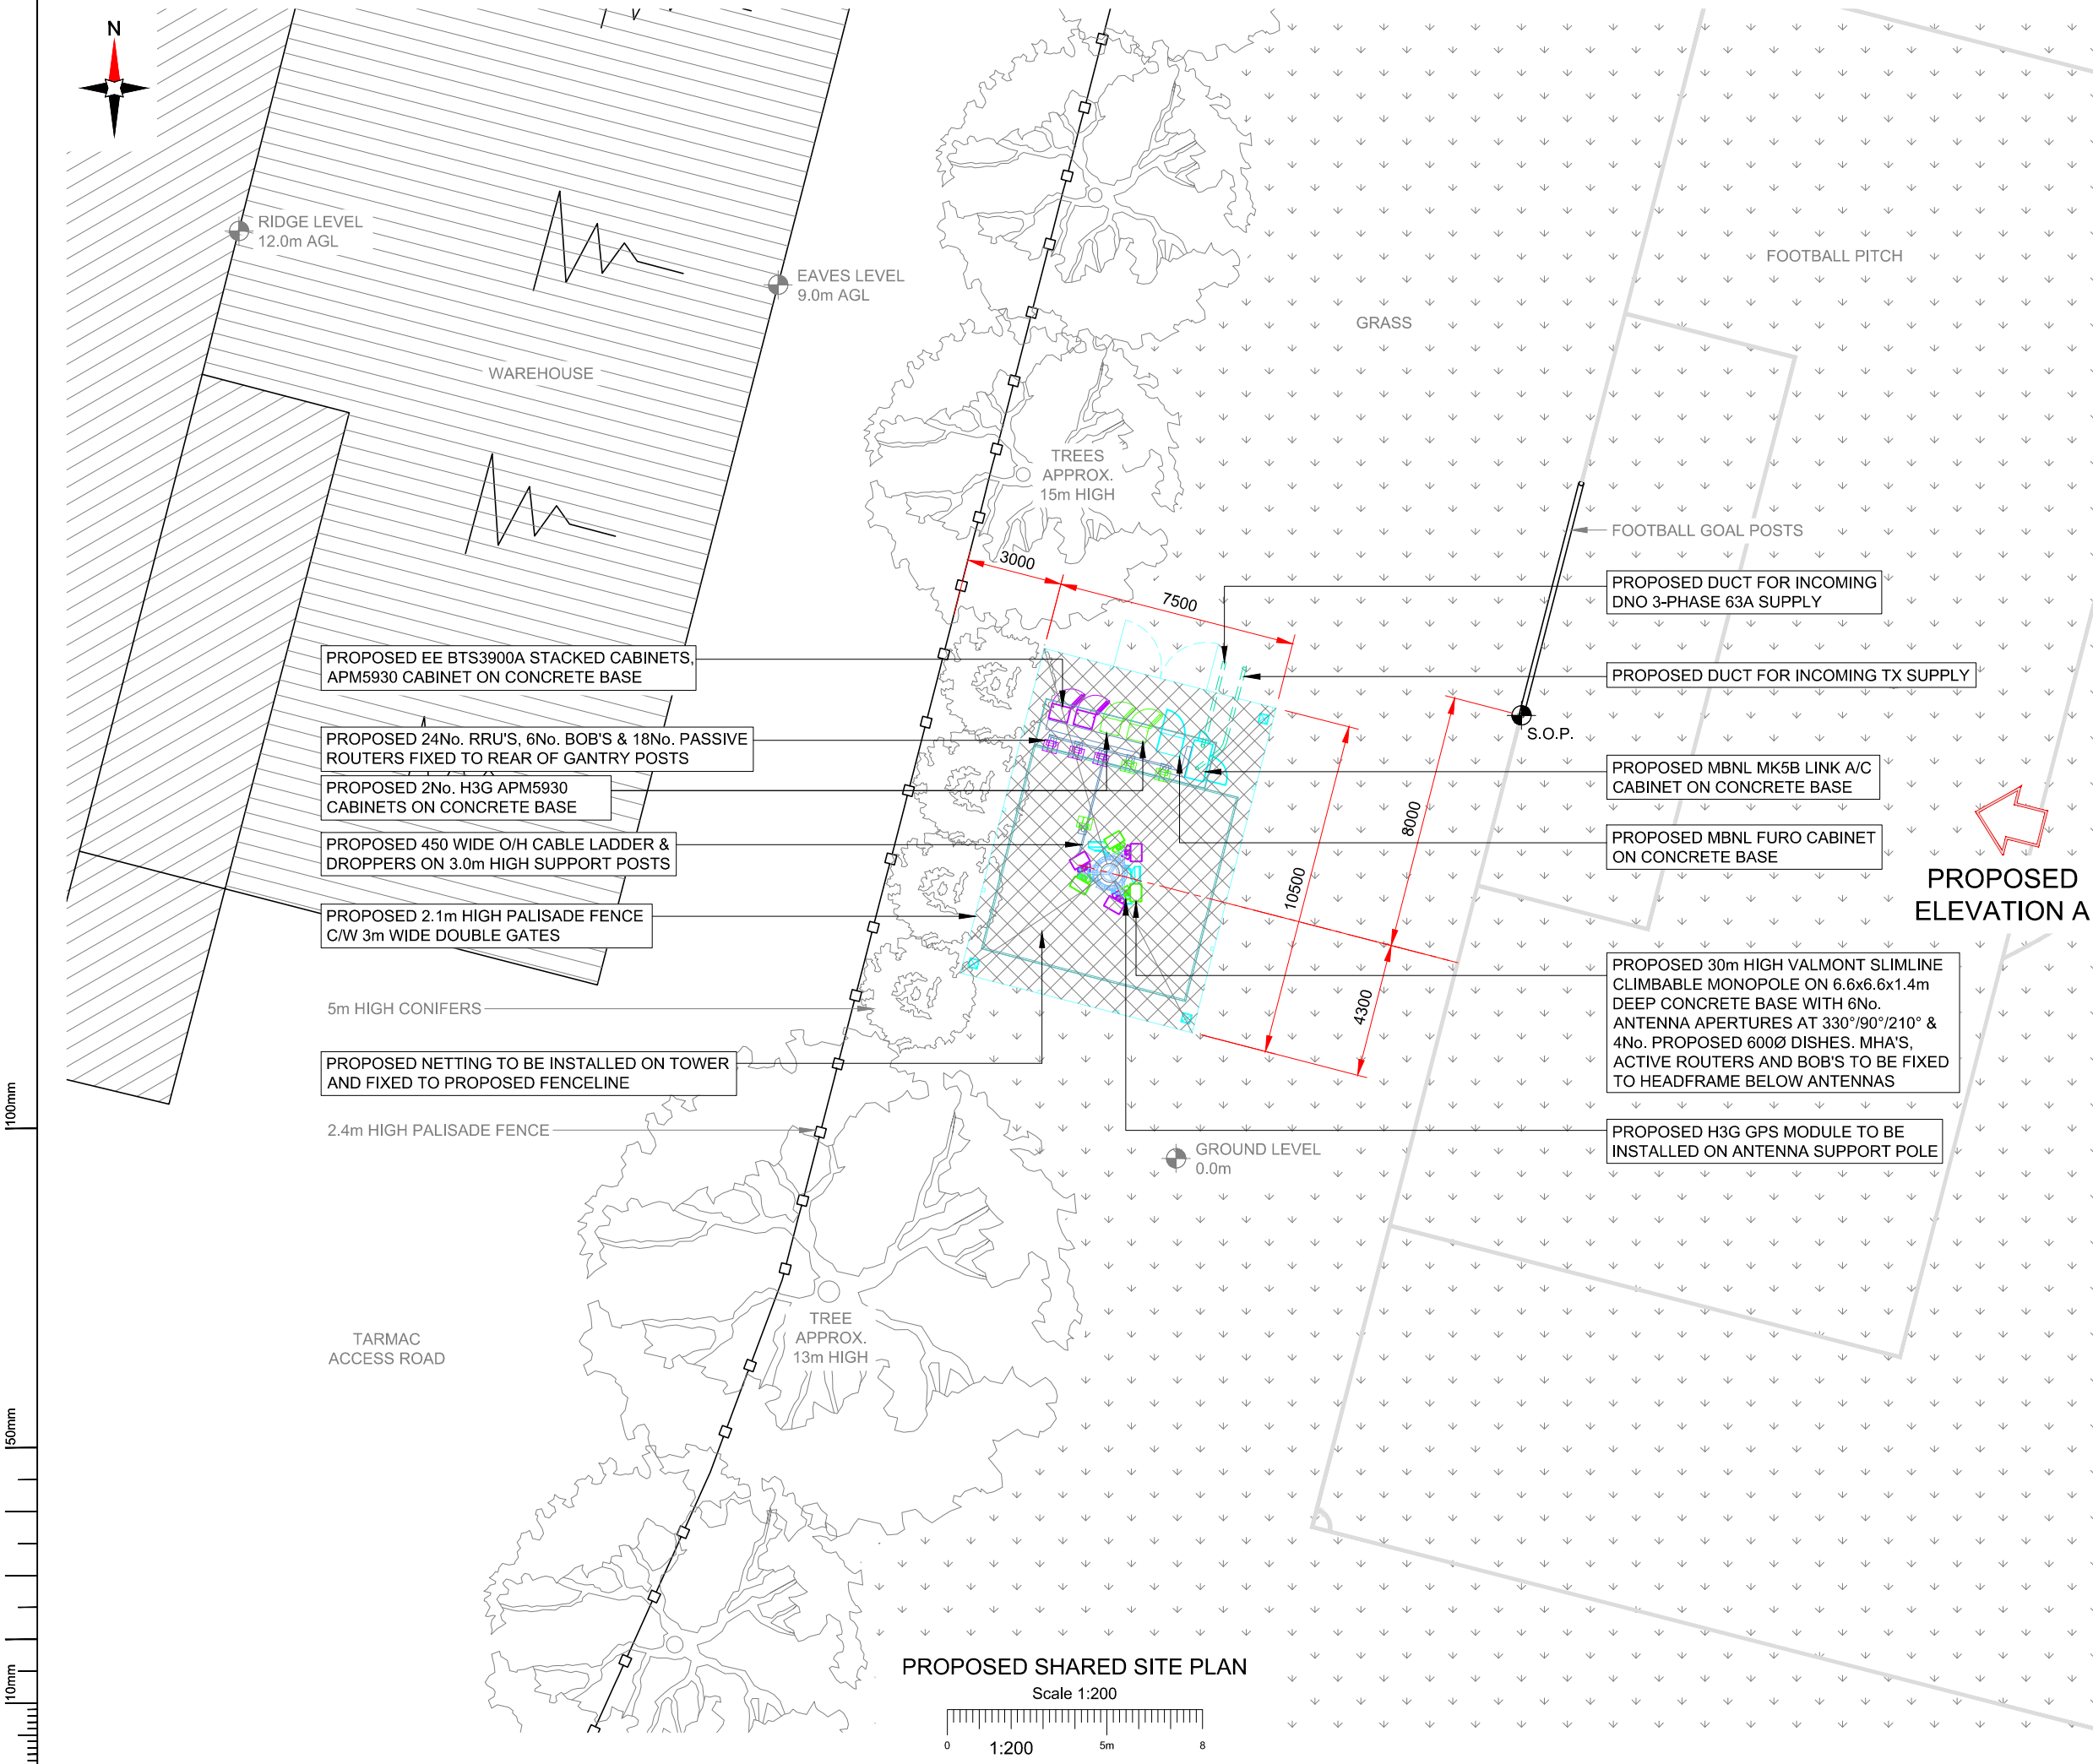

NOTES:

1. ALL DIMENSIONS IN MM UNLESS OTHERWISE NOTED.

SHARED CONFIGURATION SITE	
RF CONFIG	H3b

Master: M005	MBNL / EE / H3G	Project: NTQ	Purpose of Issue: Construction	Issue: B2
Date: 22/03/21	Revision / Upgrade Description: EE Antenna Line Configuration & Antenna schedule amended			
Drawn: R.Perkins				
Checked: A.Fanning				
Approved: P.Convery				
Master: M004	MBNL	Project: NTQ	Purpose of Issue: Construction	Issue: B1
Date: 09/03/21	Revision / Upgrade Description: Construction Issue			
Drawn: R.Perkins				
Checked: A.Fanning				
Approved: P.Convery				
Master: M003	MBNL	Project: NTQ	Purpose of Issue: Planning	Issue: B
Date: 22/02/21	Revision / Upgrade Description: Cabinets & Antenna lengths updated, H3 design added			
Drawn: R.Perkins				
Checked: A.Fanning				
Approved: P.Convery				
Master: M002	MBNL	Project: NTQ	Purpose of Issue: Construction	Issue: A1
Date: 17/11/20	Revision / Upgrade Description: Construction Issue			
Drawn: R.Perkins				
Checked: A.Fanning				
Approved: P.Convery				
Master: M001	MBNL	Project: NTQ	Purpose of Issue: Planning	Issue: A
Date: 28/10/20	Revision / Upgrade Description: First Issue			
Drawn: J. BOOTE				
Checked: J. STOCKDALE				
Approved: J. STOCKDALE				

Hutchison 3G UK Limited
Star House, 20 Grenfell Road
Maudershead, SL6 1EH
Tel: 01628 765 000
Fax: 01628 765 001

Hatfield Business Park
Hatfield
Hertfordshire
AL10 9BW
Tel: 01707 315000
Fax: 01707 319001

Mobile Broadband Network Limited
Sixth Floor, Thames Tower, Station Road, Reading, RG1 1LX

Design Consultant & Principal Contractor:

WHP Telecoms
Unit 1 Maple Park,
Low Fields Avenue, Leeds
LS12 6HH
Tel: 01133023550
e-mail: info@whptelecoms.com

Site Name:

FOCAL COMMUNITY CENTRE

Site ID:

1622519

Address:

**FOCAL COMMUNITY CENTRE,
NEW HEY ROAD,
HUDDERSFIELD,
WEST YORKSHIRE,
HD3 4DD**

Title:

200 PROPOSED SHARED SITE PLAN

Project:

NTQ

Purpose of Issue:

CONSTRUCTION

EE Cell ID:	MBNL Cell ID:	3UK Cell ID:
78183	KKS206	HD0192

Master Drawing No:

1622519_KKS206_78183_HD0192_M005


Issue:

B2

100mm

50mm

10mm

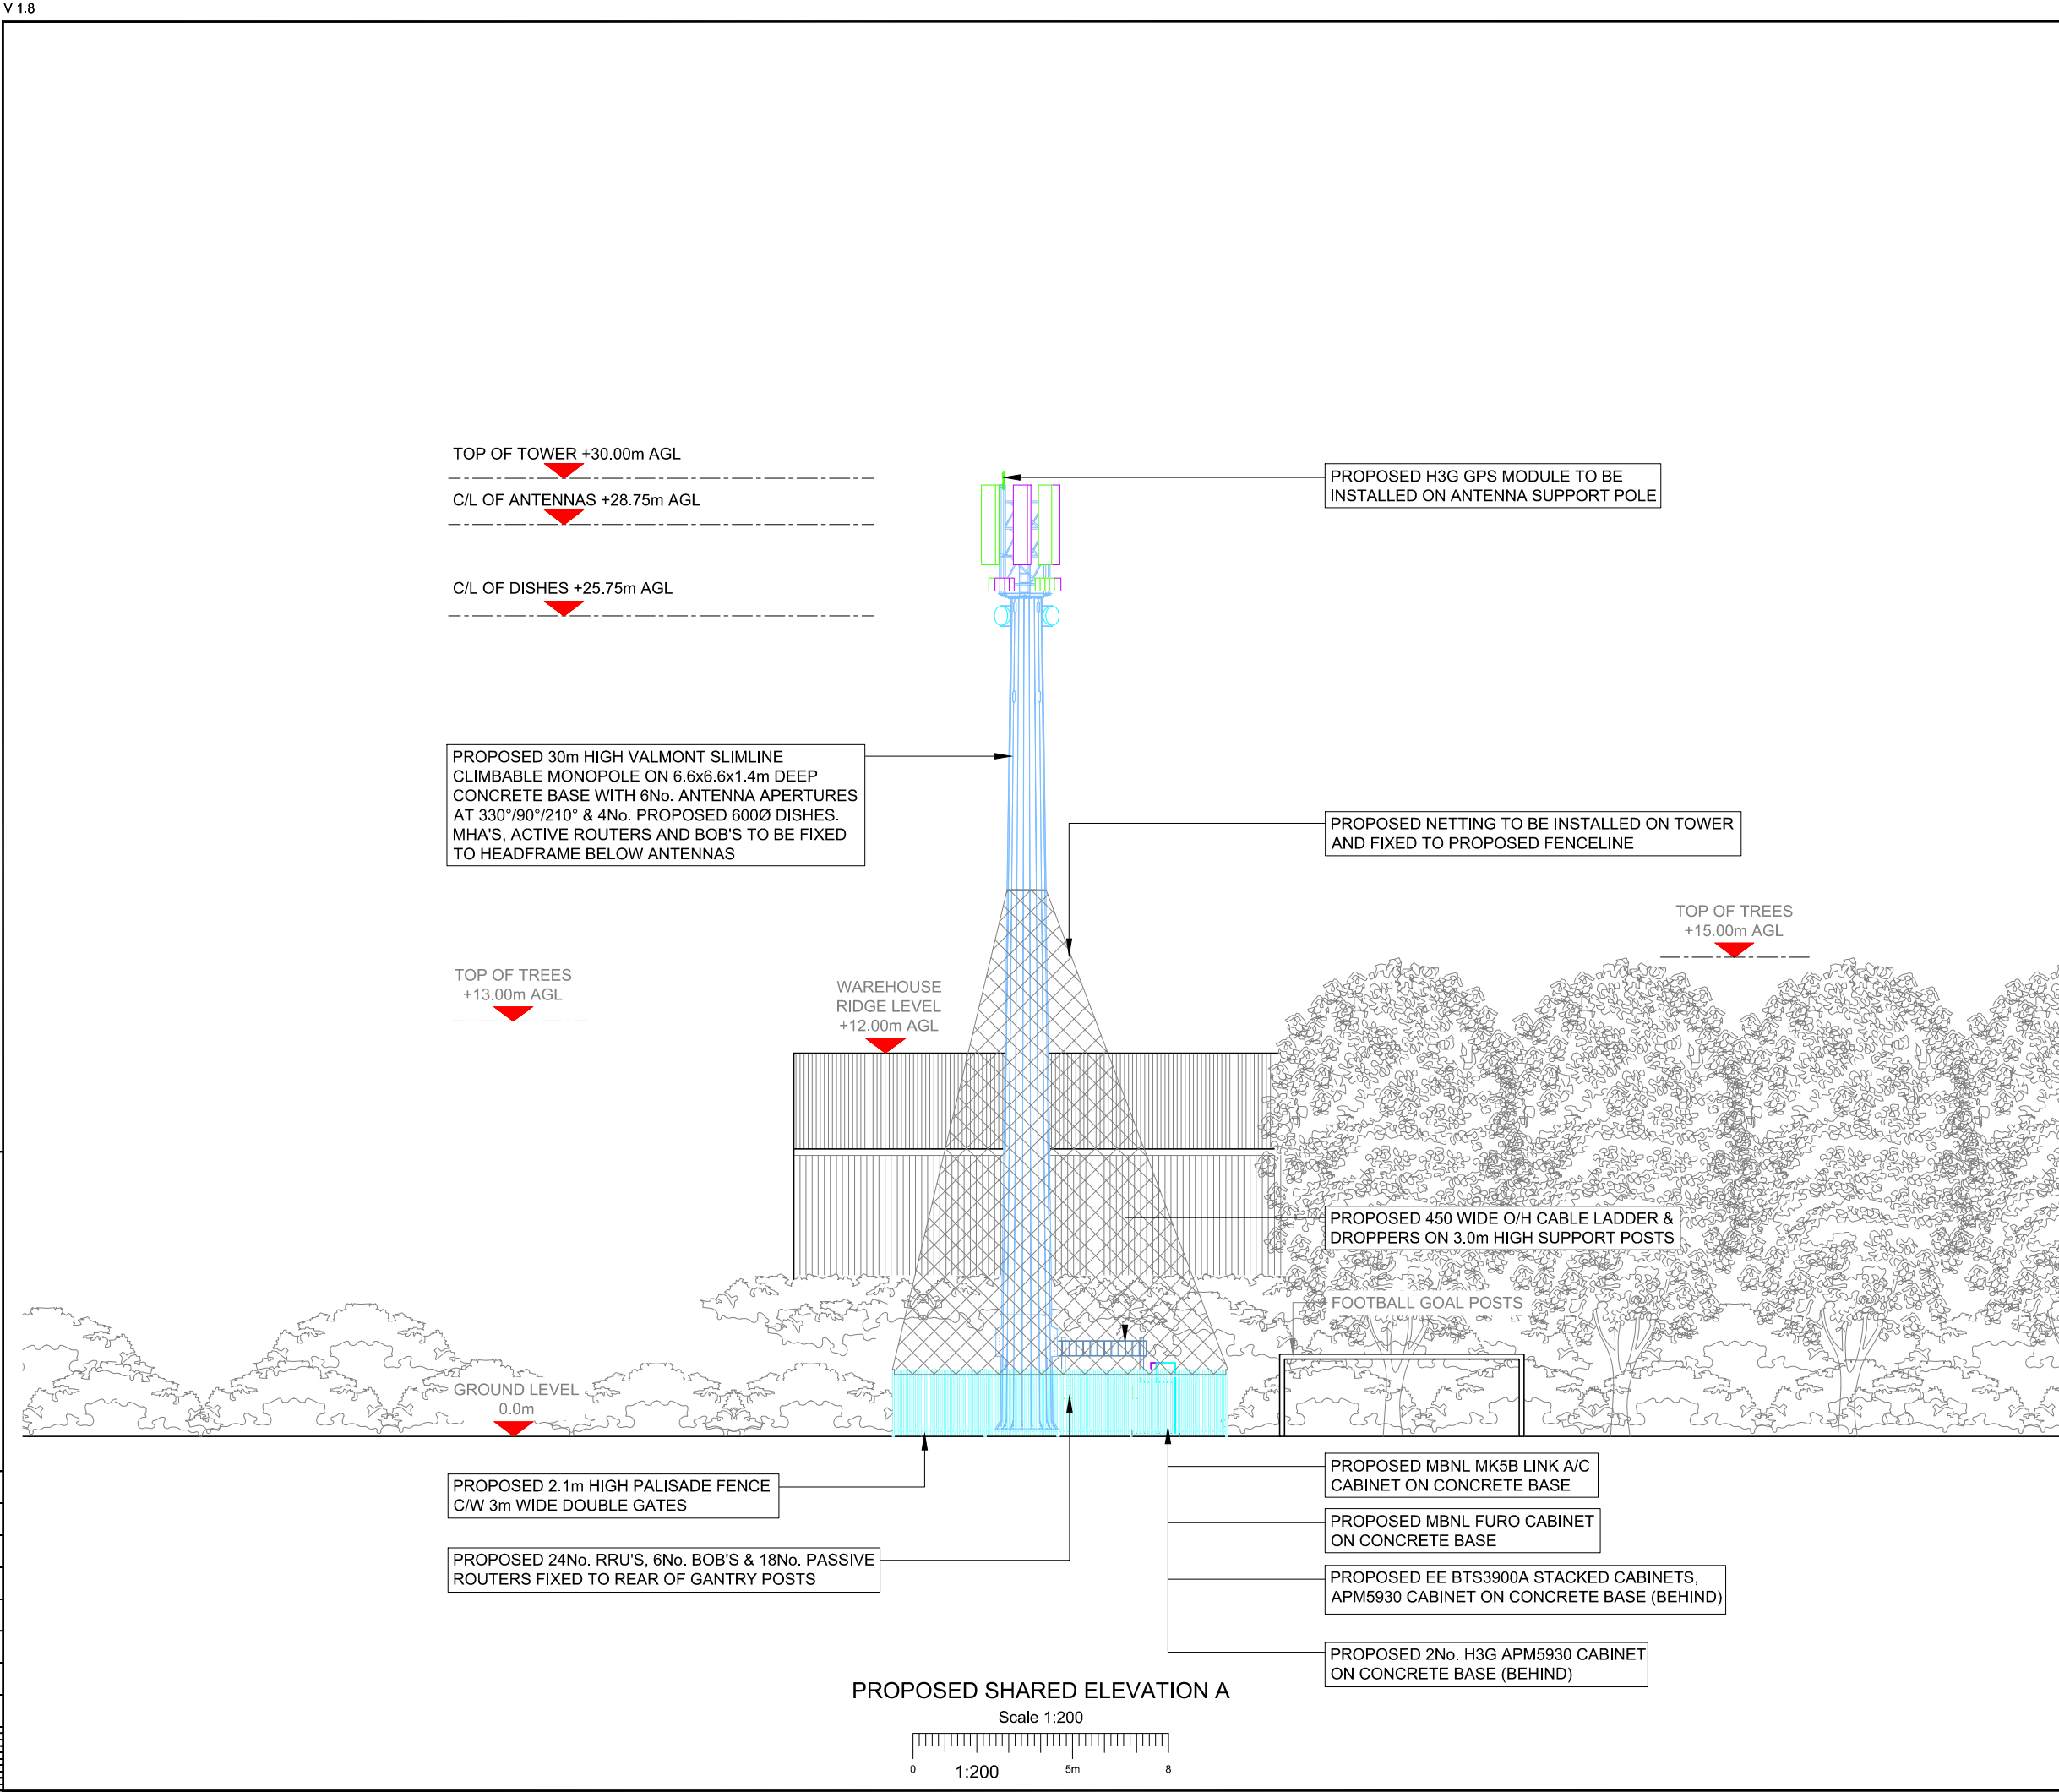

NOTES:

1. ALL DIMENSIONS IN MM UNLESS OTHERWISE NOTED.

SHARED CONFIGURATION SITE

RF CONFIG

H3b

Master:	MBNL / EE / H3G	Project:	NTQ	Purpose of Issue:	Issue:
M005	MBNL	NTQ	Construction	B2	
Date:	22/03/21	Revision / Upgrade Description:			
Drawn:	R.Perkins	EE Antenna Line Configuration & Antenna schedule amended			
Checked:	A.Fanning				
Approved:	P.Convery				
Master:	MBNL / EE / H3G	Project:	NTQ	Purpose of Issue:	Issue:
M004	MBNL	NTQ	Construction	B1	
Date:	09/03/21	Revision / Upgrade Description:			
Drawn:	R.Perkins	Construction Issue			
Checked:	A.Fanning				
Approved:	P.Convery				
Master:	MBNL / EE / H3G	Project:	NTQ	Purpose of Issue:	Issue:
M003	MBNL	NTQ	Planning	B	
Date:	22/02/21	Revision / Upgrade Description:			
Drawn:	R.Perkins	Cabinets & Antenna lengths updated, H3 design added			
Checked:	A.Fanning				
Approved:	P.Convery				
Master:	MBNL / EE / H3G	Project:	NTQ	Purpose of Issue:	Issue:
M002	MBNL	NTQ	Construction	A1	
Date:	17/11/20	Revision / Upgrade Description:			
Drawn:	R.Perkins	Construction Issue			
Checked:	A.Fanning				
Approved:	P.Convery				
Master:	MBNL / EE / H3G	Project:	NTQ	Purpose of Issue:	Issue:
M001	MBNL	NTQ	Planning	A	
Date:	28/10/20	Revision / Upgrade Description:			
Drawn:	J. BOOTE	First Issue			
Checked:	J. STOCKDALE				
Approved:	J. STOCKDALE				



Hutchison 3G UK Limited
Star House, 20 Grenfell Road
Maidenhead, SL6 1EH
Tel: 01628 765 000
Fax: 01628 765 001



Hatfield Business Park
Hatfield
Hertfordshire
AL10 9BW
Tel: 01707 315000
Fax: 01707 319001



Mobile Broadband Network Limited
Sixth Floor, Thames Tower, Station Road, Reading, RG1 1LX

Design Consultant & Principal Contractor:



WHP Telecoms

Unit 1 Maple Park,
Low Fields Avenue, Leeds
LS12 6HH

Tel: 01133023550
e-mail: info@whptelecoms.com

Site Name:

FOCAL COMMUNITY CENTRE

Site ID:

1622519

Address:

FOCAL COMMUNITY CENTRE,
NEW HEY ROAD,
HUDDERSFIELD,
WEST YORKSHIRE,
HD3 4DD

Title:

250 PROPOSED SHARED ELEVATION A

Project:

NTQ

Purpose of Issue:

CONSTRUCTION

EE Cell ID:

78183

MBNL Cell ID:

KKS206

3UK Cell ID:

HD0192

Master Drawing No:

1622519_KKS206_78183_HD0192_M005

Issue:

B2

Max Configuration Antenna Aperture Schedule & RF Equipment Capacity																	
Antenna Aperture ID	Antenna Aperture Size (Length x Width x Depth)	Aperture Height C/L	Aperture Max Weight (kg)	Proposed Bearing	Tech:	Operator: Shared/ EE/H3G	Antenna Aperture Coordinates		RRU No. Max Size & Weight L=500mm W=400mm D=150mm Weight=25kg	MHA No. Max Size & Weight L=300mm W=300mm D=150mm Weight=10kg	Main Feeder			BOB Max Size & Weight (300x300x250mm & 5kg)		Active Router No. Max Size & Weight (370x260x150mm & 10kg)	Passive Router No. Max Size & Weight (350x220x150mm & 10kg)
							Eastings	Northings			Size	Length	No.	No. Top	No. Bottom		
A1	2500x550x350mm	28.75m	100kg	330°	2G/3G/4G/5G	EE	-	-	1	3	LDF7-50	35.0m	6	1	1	2	3
A2	2500x550x350mm	28.75m	100kg	330°	2G/3G/4G/5G	H3G	-	-	1	3	LDF7-50	35.0m	6	1	1	2	3
B1	2500x550x350mm	28.75m	100kg	90°	2G/3G/4G/5G	EE	-	-	1	3	LDF7-50	35.0m	6	1	1	2	3
B2	2500x550x350mm	28.75m	100kg	90°	2G/3G/4G/5G	H3G	-	-	1	3	LDF7-50	35.0m	6	1	1	2	3
C1	2500x550x350mm	28.75m	100kg	210°	2G/3G/4G/5G	EE	-	-	1	3	LDF7-50	35.0m	6	1	1	2	3
C2	2500x550x350mm	28.75m	100kg	210°	2G/3G/4G/5G	H3G	-	-	1	3	LDF7-50	35.0m	6	1	1	2	3

2° MECHANICAL UPLIFT REQUIRED

Passive Infrastructure Equipment Capacity		
A	B	C
H3b	H3b	H3b

STATUS KEY:

Installed: Existing
Retain: Existing and to remain
Relocate: Existing and to be relocated
Remove: Existing to be removed from site
Proposed: New on site

Master: M005	MBNL / EE / H3G: MBNL	Project: NTQ	Purpose of Issue: Construction	Issue: B2
Date: 22/03/21	Revision / Upgrade Description: EE Antenna Line Configuration & Antenna schedule amended			
Drawn: R.Perkins				
Checked: A.Fanning				
Approved: P.Convery				
Master: M004	MBNL / EE / H3G: MBNL	Project: NTQ	Purpose of Issue: Construction	Issue: B1
Date: 09/03/21	Revision / Upgrade Description: Construction Issue			
Drawn: R.Perkins				
Checked: A.Fanning				
Approved: P.Convery				
Master: M003	MBNL / EE / H3G: MBNL	Project: NTQ	Purpose of Issue: Planning	Issue: B
Date: 22/02/21	Revision / Upgrade Description: Cabinets & Antenna lengths updated, H3 design added			
Drawn: R.Perkins				
Checked: A.Fanning				
Approved: P.Convery				
Master: M002	MBNL / EE / H3G: MBNL	Project: NTQ	Purpose of Issue: Construction	Issue: A1
Date: 17/11/20	Revision / Upgrade Description: Construction Issue			
Drawn: R.Perkins				
Checked: A.Fanning				
Approved: P.Convery				
Master: M001	MBNL / EE / H3G: MBNL	Project: NTQ	Purpose of Issue: Planning	Issue: A
Date: 28/10/20	Revision / Upgrade Description: First Issue			
Drawn: J. BOOTE				
Checked: J. STOCKDALE				
Approved: J. STOCKDALE				



Hutchison 3G UK Limited
Star House, 20 Grenfell Road
Mauderhead, SL8 1EH
Tel: 01628 765 000
Fax: 01628 765 001



Hatfield Business Park
Hatfield
Hertfordshire
AL10 9BW
Tel: 01707 315000
Fax: 01707 319001



Mobile Broadband Network Limited
Sixth Floor, Thames Tower, Station Road, Reading, RG1 1LX

Design Consultant & Principal Contractor:



WHP Telecoms
Unit 1 Maple Park,
Low Fields Avenue, Leeds
LS12 6HH
Tel: 01133023550
e-mail: info@whptelecoms.com

Site Name: FOCAL COMMUNITY CENTRE

Site ID: 1622519

Address: FOCAL COMMUNITY CENTRE,
NEW HEY ROAD,
HUDDERSFIELD,
WEST YORKSHIRE,
HD3 4DD

Title: 304 MAX CONFIGURATION ANTENNA
SCHEDULE & LINE CONFIGURATION

Project: NTQ

Purpose of Issue: CONSTRUCTION

EE Cell ID: 78183	MBNL Cell ID: KKS206	3UK Cell ID: HD0192
-------------------	----------------------	---------------------

Master Drawing No: 1622519_KKS206_78183_HD0192_M005	Issue: B2
---	-----------

Support Structure Schedule										
Structure ID	Status	Equipment Description / Type	Structure Manufacturer	Height AGL (m)	Colour (RAL Colour)	Headframe Details	Foundation / Support Grillage / Host Structure Details	Support Bolt Details	MBNL Ref:	Comments
ST1	Proposed	SLIMLINE MONOPOLE	VALMONT	30m	GALVANISED	-	6.6m x 6.6m x 1.4m RC base	-	-	TO BE INSTALLED ON A NEW CONCRETE BASE

Equipment Schedule

Equipment ID	Quantity	Status	Equipment Description / Type	Equipment Manufacturer	Dimensions (W x D x H)	Weight (kg)	Colour (RAL Colour)	Material	Location	Power	Power cable length (m)	MBNL Ref:	Comments
CAB1	1	PROPOSED	MK5B LINK AC	-	1200x600x1600	-	GREY	STEEL	OUTDOOR	-	-	-	ON NEW CONCRETE BASE
CAB2	1	PROPOSED	EE/H3G - FURO	NOKIA	750x500x2100	-	GREY	STEEL	OUTDOOR	-	-	-	ON NEW CONCRETE BASE
CAB3	1	PROPOSED	EE - APM5930	HUAWEI	600x480x1000	-	GREY	STEEL	OUTDOOR	-	-	-	ON NEW CONCRETE BASE
CAB4	1	PROPOSED	EE - BTS3900A	HUAWEI	600x480x1400	-	GREY	STEEL	OUTDOOR	-	-	-	ON NEW CONCRETE BASE
CAB5	1	PROPOSED	H3G - APM5930	HUAWEI	600x480x1000	-	GREY	STEEL	OUTDOOR	-	-	-	ON NEW CONCRETE BASE
CAB6	1	PROPOSED	H3G - APM5930	HUAWEI	600x480x1000	-	GREY	STEEL	OUTDOOR	-	-	-	ON NEW CONCRETE BASE
-	6	Proposed	RRU 5507	-	-	-	RAL 7035	-	Support Pole	-	-	-	EE - 1800/2100
-	3	Proposed	RRU 5304	-	-	-	RAL 7035	-	Support Pole	-	-	-	EE - 2600
-	3	Proposed	MHA E15R02P11	-	-	-	RAL 7035	-	Support Pole	-	-	-	EE - 800
-	3	Proposed	RD0725-H4-11	-	-	-	RAL 7035	-	Support Pole	-	-	-	EE - 800 & 1800/2100
-	3	Proposed	RD0759-H4-09	-	-	-	RAL 7035	-	Support Pole	-	-	-	EE - 800 & 1800/2100
-	3	Proposed	Mk1 BOB's	-	-	-	RAL 7035	-	Support Pole	-	-	-	EE - 1800/2100, 2600
-	3	Proposed	Mk2 BOB's	-	-	-	RAL 7035	-	Support Pole	-	-	-	EE - 1800/2100, 2600
-	3	Proposed	RD0448V12	-	-	-	RAL 7035	-	Support Pole	-	-	-	EE - 1800/2100
-	3	Proposed	RD0665-H4-01	-	-	-	RAL 7035	-	Support Pole	-	-	-	EE - 1800/2100
-	3	Proposed	MHA E14R00P42	-	-	-	RAL 7035	-	Support Pole	-	-	-	H3G - 800
-	6	Proposed	RRU 5301	-	0.40 x 0.30 x 0.17	-	RAL 7035	-	Support Pole	-	-	-	H3G - 800 & 1400
-	3	Proposed	RRU 5501	-	0.48 x 0.35 x 0.14	-	RAL 7035	-	Support Pole	-	-	-	H3G - 1800/2100
-	3	Proposed	RD0448-H412	-	-	-	RAL 7035	-	Support Pole	-	-	-	H3G -2100
-	6	Proposed	ACOMT2A09v06	-	-	-	RAL 7035	-	Support Pole	-	-	-	H3G - 800, 1400 & 1800/2100
-	6	Proposed	ATADU2022v06	-	-	-	RAL 7035	-	Support Pole	-	-	-	H3G - 800, 1400 & 1800/2100
-	6	Proposed	DC BOB	-	-	-	RAL 7035	-	Support Pole	-	-	-	H3G - 800, 1400 & 1800/2100
-	6	Proposed	Fibre BOB	-	-	-	RAL 7035	-	Support Pole	-	-	-	H3G - 800, 1400 & 1800/2100
-	1	Proposed	GPS module	-	-	-	RAL 7035	-	Support Pole	-	-	-	H3G GPS

POWER SCHEDULE

Supply Status	Type	Supplier	Supply Type	Location	Comments
PROPOSED	DNO	TBC	3 Phase 100A	MK5B LINK/AC CABINET	-

STATUS KEY:

Installed:

Existing

Retain:

Existing and to remain

Relocate:

Existing and to be relocated

Remove:

Existing to be removed from site

Proposed:

New on site

LOCATION KEY:

Outdoor:

Located outside

Indoor:

Located within an equipment cabin or equipment room

Internal:

located inside a cabinet or item of equipment

Master: M005

MBNL / EE / H3G: MBNL

Project: NTQ

Purpose of Issue: Construction

Issue: B2

Date: 22/03/21

Drawn: R.Perkins

Checked: A.Fanning

Approved: P.Convery

Revision / Upgrade Description: EE Antenna Line Configuration & Antenna schedule amended

Master: M004

MBNL / EE / H3G: MBNL

Project: NTQ

Purpose of Issue: Construction

Issue: B1

Date: 09/03/21

Drawn: R.Perkins

Checked: A.Fanning

Approved: P.Convery

Revision / Upgrade Description: Construction Issue

Master: M003

MBNL / EE / H3G: MBNL

Project: NTQ

Purpose of Issue: Planning

Issue: B

Date: 22/02/21

Drawn: R.Perkins

Checked: A.Fanning

Approved: P.Convery

Revision / Upgrade Description: Cabinets & Antenna lengths updated, H3 design added

Master: M002

MBNL / EE / H3G: MBNL

Project: NTQ

Purpose of Issue: Construction

Issue: A1

Date: 17/11/20

Drawn: R.Perkins

Checked: A.Fanning

Approved: P.Convery

Revision / Upgrade Description: Construction Issue

Master: M001

MBNL / EE / H3G: MBNL

Project: NTQ

Purpose of Issue: Planning

Issue: A

Date: 28/10/20

Drawn: J. BOOTE

Checked: J. STOCKDALE

Approved: J. STOCKDALE

Revision / Upgrade Description: First Issue



Hutchison 3G UK Limited

Star House, 20 Grenfell Road

Muskerhead, SL6 1EH

Tel: 01628 765 000

Fax: 01628 765 001

H3G Base Station Information line:

0845 6043000

Available: 9am-6pm Monday to Friday



Hatfield Business Park

Hatfield

Hertfordshire

AL10 9BW

Tel: 01707 315000

Fax: 01707 319001



Mobile Broadband Network Limited

Sixth Floor, Thames Tower, Station Road, Reading, RG1 1LX

Design Consultant & Principal Contractor:



WHP Telecoms

Unit 1 Maple Park,

Low Fields Avenue, Leeds

LS12 6HH

Tel: 01133023550

e-mail: info@whptelecoms.com

Site Name:

FOCAL COMMUNITY CENTRE

Site ID:

1622519

Address:

FOCAL COMMUNITY CENTRE,
NEW HEY ROAD,
HUDDERSFIELD,
WEST YORKSHIRE,
HD3 4DD

Title:

305 EQUIPMENT SCHEDULE & SUPPORT STRUCTURE DETAILS

Project:

NTQ

Purpose of Issue:

CONSTRUCTION

EE Cell ID:

78183

MBNL Cell ID:

KKS206

3UK Cell ID:

HD0192

Master Drawing No:

1622519_KKS206_78183_HD0192_M005

Issue:

B2

100mm

150mm

10mm

10