




Key


- 1500mm LED integrated Ip20 cool light fitting c/w polycarbonate lens
- Light Switch
- Bulkhead light fitting
- Maintained 3hr emergency exit light
- Non maintained 3hr emergency light
- 13 amp twin switched socket outlet
- 2kw wall mounted convector heater (Lot 20)
- Distribution mains Board
- 1000mm wide door
- 30 minute fire check door
- door closer
- panic bar
- vision panel
- Rainwater down pipe

Walls - BS04C39 Plastisol
 Fascias - BS04C39 Plastiol
 Plinth - BS04C39 Plastisol
 Windows - White UPVC with matching upvc liners
 External Doors (Steel) - White
 Rainwater Goods - White UPVC Square
 Internal Linings (walls) - Cream Vinyl Faced Plasterboard
 Internal Linings (ceilings) - White Vinyl Faced Plasterboard
 Wall Sockets - White
 Flooring - Solid Vinyl sheet c/w welded seams


1100w x 1000h upvc double glazed
 (A rated windows) c/w restrictor
 stays and trickle ventilation

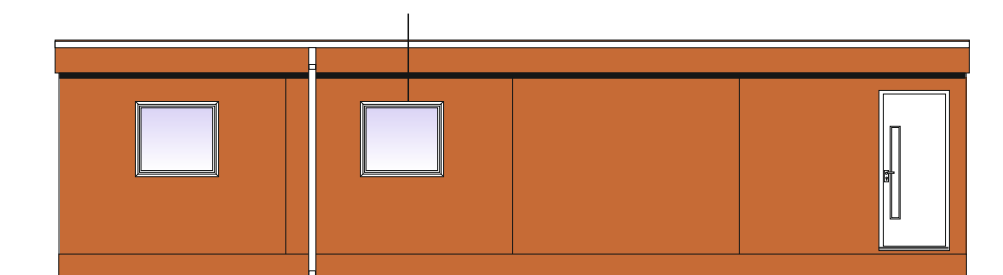


Front Elevation

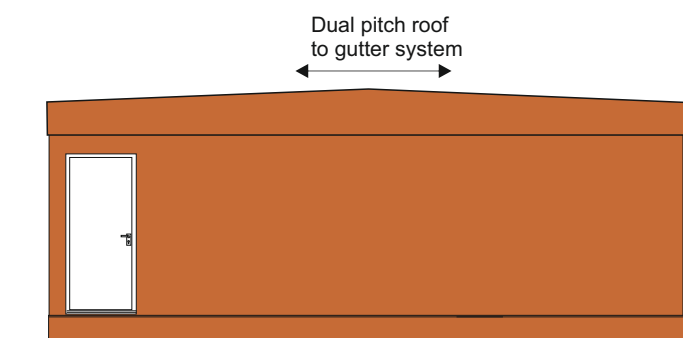


Side Elevation

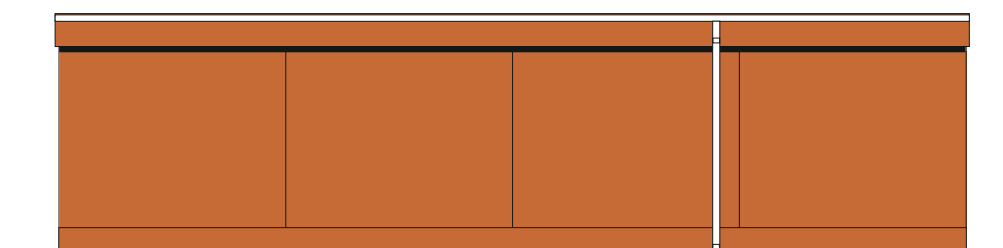

Rear Elevation

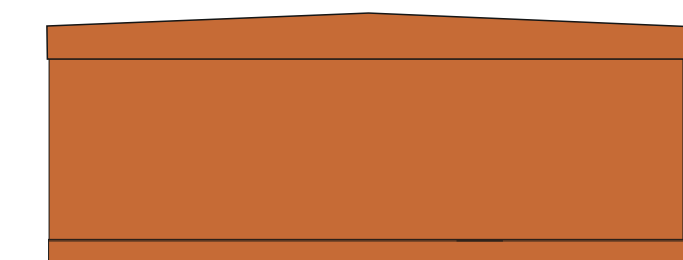

Side Elevation

 Revision	Date	Comments
A	24.2.21	Elevations Added
 actiform group <i>tailored modular building solutions</i> Actacom Limited Actiform Hire Limited Queens Buildings, Lowlands Road, Mirfield West Yorkshire WF14 8LX. Tel 01924 498557 Fax 01924 499092		Client NHS Scheme Dewsbury Hospital
Drawing Title 4 Bay Modular		
Dwg No.	6498-1	Drawn cjf Checked
Date	22.2.21	Scale 1:100
Status	For Approval	Paper Size A3