 




- △ single socket
- △ twin socket
- TV
- ⊙ shaver socket    ⊞ shower switch
- ⊞ cooker outlet
- ⊞ consumer unit
- ⊙ light switch
- △ RJ45 data outlet
- ⊙ Downlight luminaire
- ⊞ Wall mounted luminaire
- ⊙ LED downlight
- ⊙ LED spotlight
- ⊙ Automatic
- ⊙ Smoke detector
- ES Electric shower
- TR Towel rail
- WT Above worktop level
- HL High level
- LL Low level
- EH Electric storage heater
- ⊞ Radiator
- EHB Electric heater blower
- ⊙ boiler
- ⊙ water waste

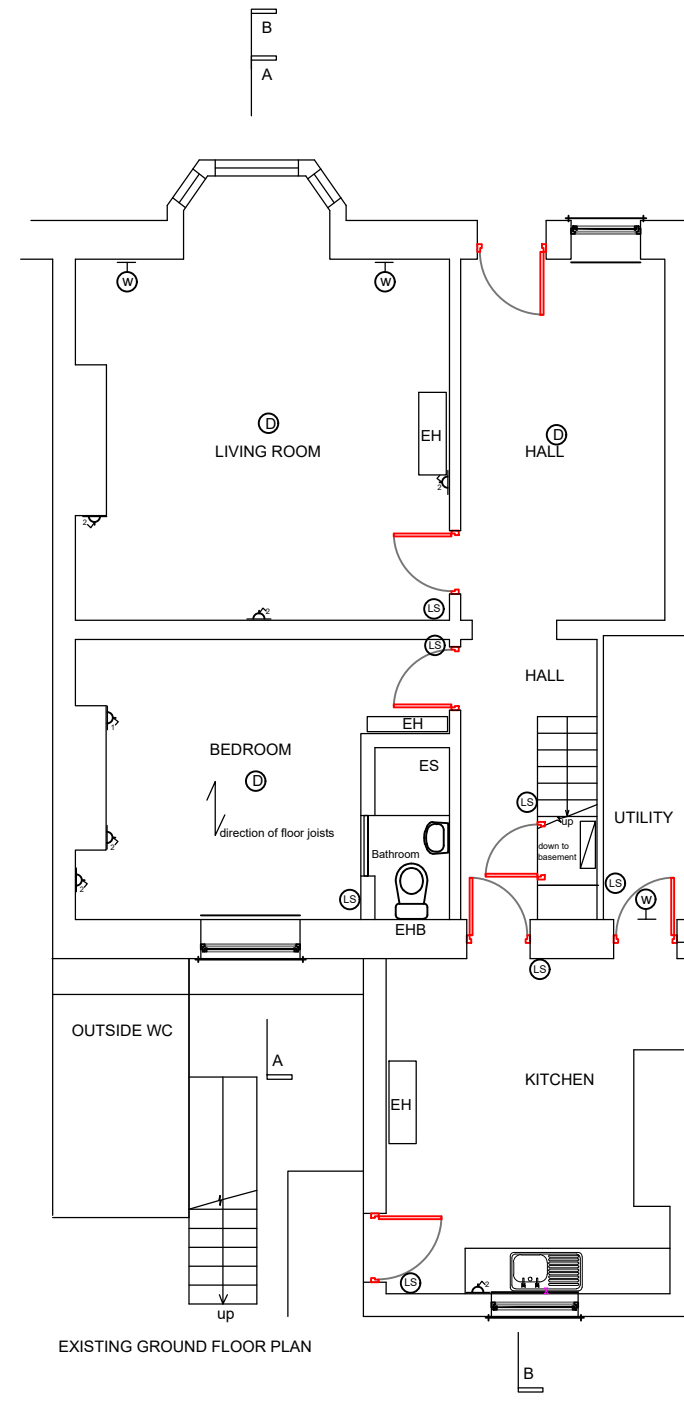

Rev.	Description	Date	By
Project			
161 TRINITY STREET HUDDERSFIELD HD1 4DZ			
Drawing			
EXISTING BASEMENT GROUND FLOOR PLANS			
Last Update		Last Plotted	
CAD File 20 College Rd Wakefield.dwg copyright Ascough & Associates			
Drawn	JAM	Traced AUTOCAD	Checked
Scale	1:100@A3	Date	4.7.21

Drawing No. 349/1

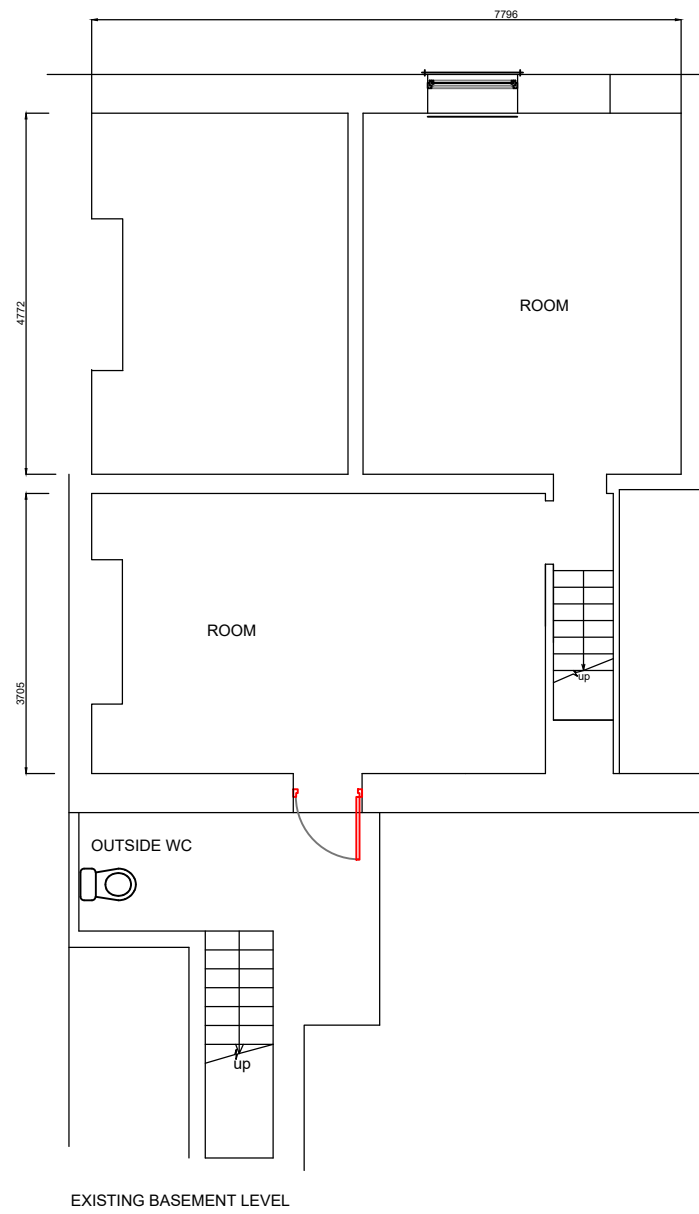