

 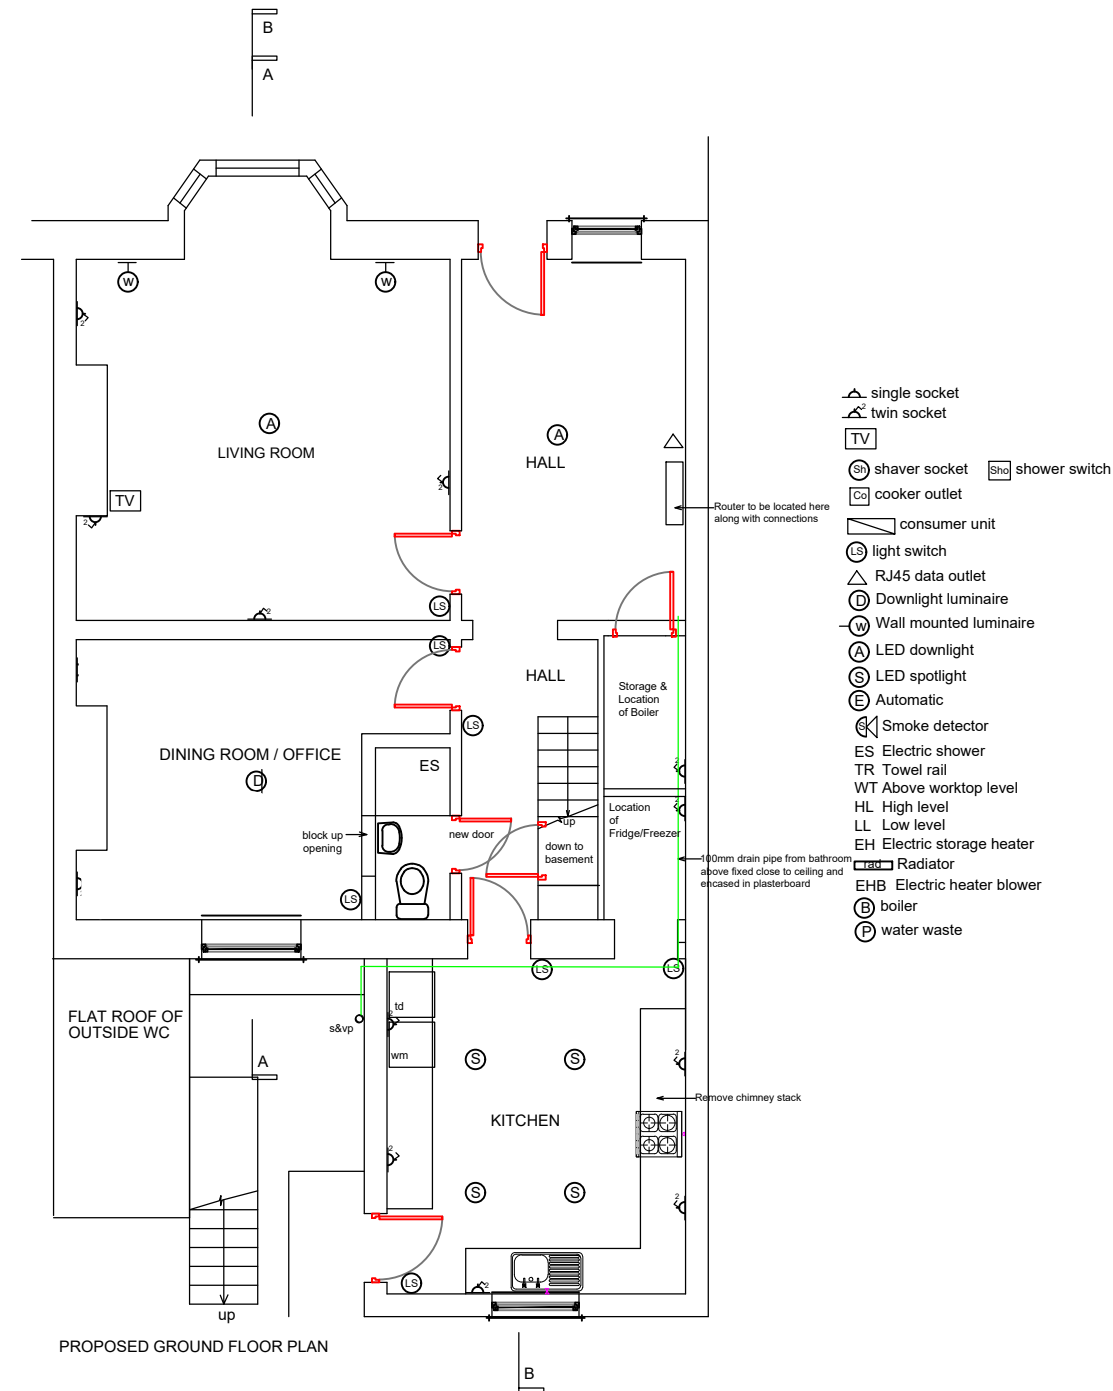


- △ single socket
- △ twin socket
- TV
- Ⓜ shaver socket Ⓜ shower switch
- Ⓜ cooker outlet
- consumer unit
- Ⓛ light switch
- △ RJ45 data outlet
- Ⓛ Downlight luminaire
- Ⓜ Wall mounted luminaire
- Ⓛ LED downlight
- Ⓛ LED spotlight
- Ⓛ Automatic
- Ⓛ Smoke detector
- ES Electric shower
- TR Towel rail
- WT Above worktop level
- HL High level
- LL Low level
- EH Electric storage heater
- Ⓛ Radiator
- EHB Electric heater blower
- Ⓛ boiler
- Ⓛ water waste

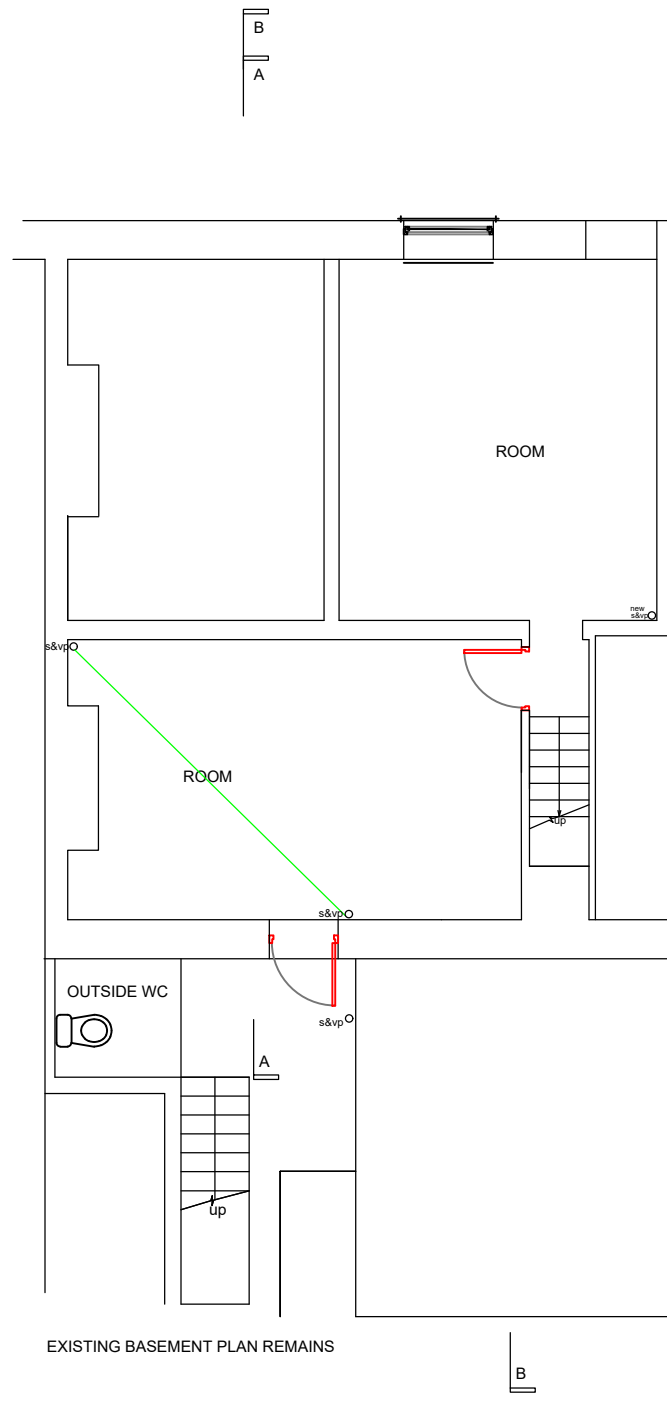

- △ single socket
- △ twin socket
- TV
- Ⓜ shaver socket Ⓜ shower switch
- Ⓜ cooker outlet
- consumer unit
- Ⓛ light switch
- △ RJ45 data outlet
- Ⓛ Downlight luminaire
- Ⓜ Wall mounted luminaire
- Ⓛ LED downlight
- Ⓛ LED spotlight
- Ⓛ Automatic
- Ⓛ Smoke detector
- ES Electric shower
- TR Towel rail
- WT Above worktop level
- HL High level
- LL Low level
- EH Electric storage heater
- Ⓛ Radiator
- EHB Electric heater blower
- Ⓛ boiler
- Ⓛ water waste



Rev.	Description	Date	By
Project			
161 TRINITY STREET HUDDERSFIELD HD1 4DZ			
Drawing			
EXISTING BASEMENT AND PROPOSED GROUND FLOOR PLANS			
Last Update .		Last Plotted .	
CAD File 20 College Rd Wakefield.dwg copyright Ascough & Associates			
Drawn JAM	Traced AUTOCAD	Checked	
Scale 1:100@A3		Date 27.9.2021	
Drawing No. 349/5A			

Drawing No. **349/5A**

