


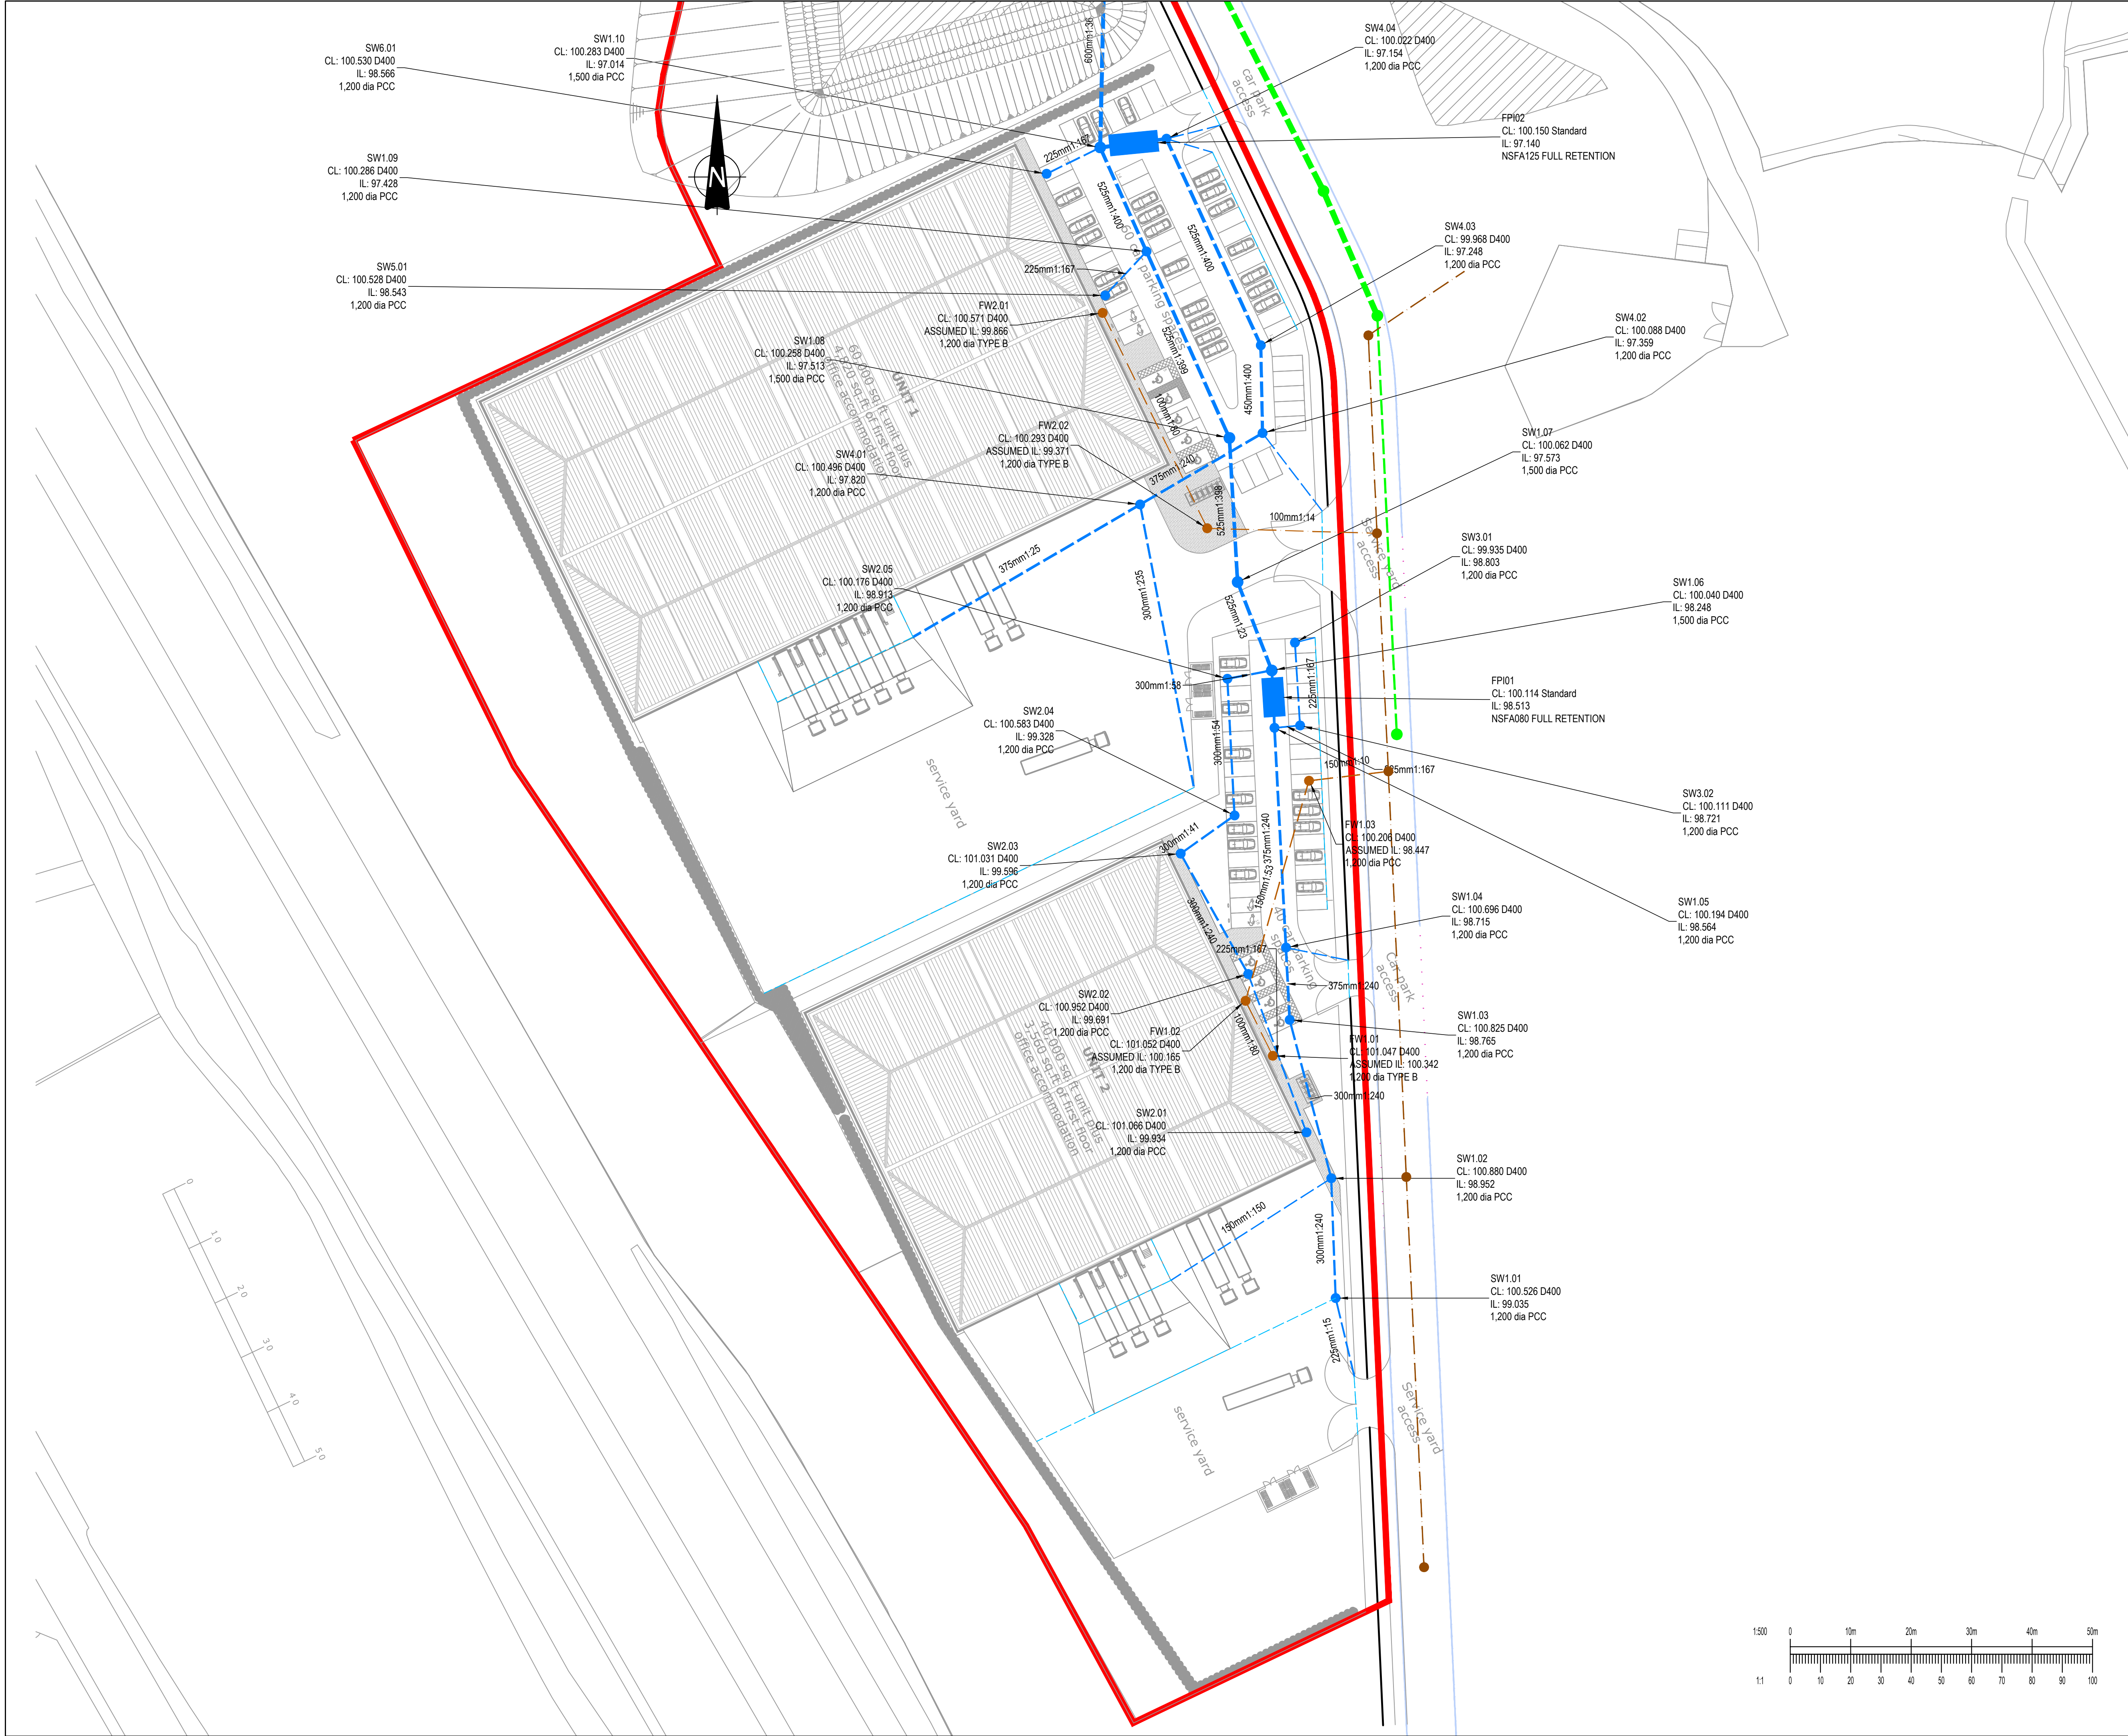

GENERAL NOTES:

- GENERAL NOTES:
- THIS DRAWING IS TO BE READ IN CONJUNCTION WITH ALL RELEVANT ARCHITECTS AND ENGINEERS DRAWINGS AND SPECIFICATIONS.
 - DESIGN BASED ON TOPOGRAPHICAL SURVEY AND CCTV SURVEY INFORMATION AVAILABLE AT THE TIME OF DESIGN.
 - ALL EXISTING SEWERS, CONNECTIONS, PIPE SIZES AND INVERT LEVELS TO BE CONFIRMED BY CONTRACTOR PRIOR TO COMMENCEMENT OF WORKS TO ENSURE CONNECTIVITY. ANY VARIANCE FROM THE INFORMATION SHOWN SHOULD BE REPORTED TO THE ENGINEER FOR REVIEW.
 - DO NOT SCALE THIS DRAWING. ANY AMBIGUITIES, OMISSIONS AND ERRORS ON DRAWINGS SHALL BE BROUGHT TO THE ENGINEERS ATTENTION IMMEDIATELY. ALL DIMENSIONS MUST BE CHECKED / VERIFIED ON SITE.
 - ALL DIMENSIONS ARE IN METRES AND LEVELS IN METRES ABOVE ORDNANCE DATUM UNLESS OTHERWISE NOTED.
 - WHERE EXISTING DRAINAGE IS BEING USED, ALLOWANCES SHOULD BE MADE TO REMEDIATE THIS DRAINAGE IN LINE WITH AVAILABLE CCTV SURVEY INFORMATION. IF NO SURVEY IS AVAILABLE, IT IS ADVISED TO OBTAIN ONE PRIOR TO COMMENCEMENT OF WORKS.
 - ALL EXISTING SERVICES TO BE LOCATED PRIOR TO COMMENCEMENT OF ANY DRAINAGE WORKS, AND WHERE NECESSARY PROTECTION OR DIVERSIONS TO BE UNDERTAKEN TO AVOID CONFLICT WITH THE PROPOSED WORK.
 - ALL RAINWATER AND FOUL POP UPS LOCATIONS AND SIZES INDICATIVE ONLY AND TO BE CONFIRMED BY THE ARCHITECT AND M&E ENGINEER.
 - COVER LEVELS, GULLY POSITIONS, AND BUILDINGS LOCATION ARE APPROXIMATE AND SHALL BE CONFIRMED BY ARCHITECT/ LANDSCAPE ARCHITECT.
 - ALL PIPE DIAMETERS GIVEN ARE NOMINAL INTERNAL PIPE DIAMETERS. THESE ARE TO BE CONFIRMED ONCE A DETAILED CAPACITY CHECK HAS BEEN UNDERTAKEN AT A LATER DESIGN STAGE.
 - OUTFALL CONNECTION(S) SUBJECT TO AGREEMENT WITH THE APPROVING AUTHORITY.

- KEY
- PROPOSED PRIVATE FOUL WATER DRAIN
 - PROPOSED PRIVATE SURFACE WATER DRAIN
 - PROPOSED LINEAR DRAIN
 - PROPOSED HIGHWAY SEWER
 - PROPOSED FOUL WATER SEWER
 - PROPOSED BYPASS INTERCEPTOR

P01	FIRST ISSUE	23.04.21	EF	OT
Rev:	Description:	Date:	By:	Chkd:



Rose Wharf Ground Floor, 78-80 East Street, Leeds, LS9 8EE
0113 274 8559
leeds@curtins.com
www.curtins.com

Civils & Structures • Transport Planning • Environmental • Infrastructure • Geotechnical • Conservation & Heritage • Principal Designer
Birmingham • Bristol • Cambridge • Cardiff • Douglas • Dublin • Edinburgh • Glasgow • Kentish • Leeds • Liverpool • London • Manchester • Nottingham

Status:	SUITABLE FOR INFORMATION	S2
---------	--------------------------	----

Project:	INTERCHANGE 26
----------	----------------

Orig Title:	UNIT 1&2 DRAINAGE LAYOUT SHEET 2
-------------	--

Size:	Date:	Drawn By:	Designed By:	Checked By:
A1	23/04/21	EF	EF	OT
Scale:	1:500			
Project No:	Originator:	Volume:	Level:	Type:
078796 - CUR - ZZ	- ZZ	- DR	- C	- 92002 - P01