



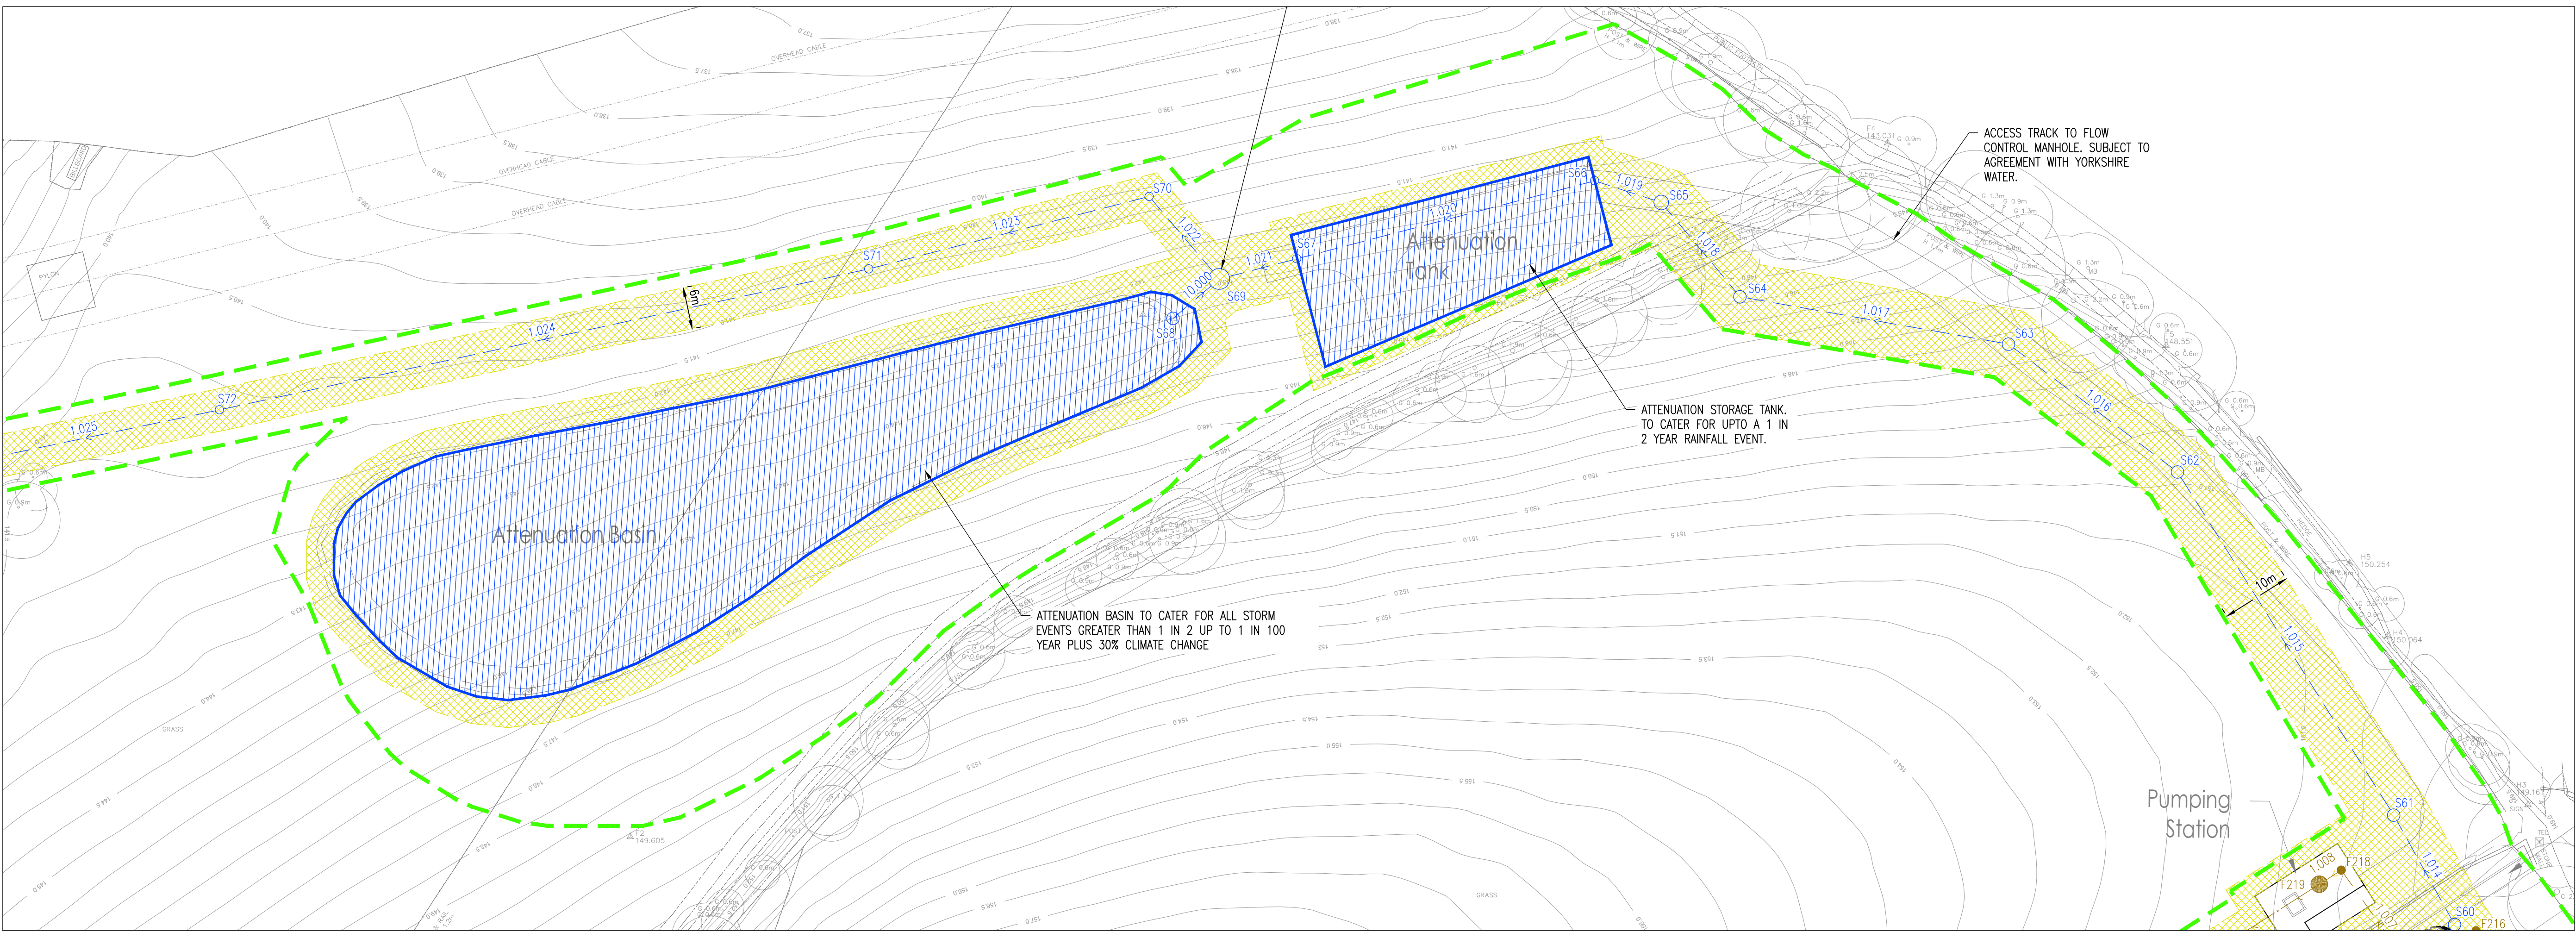

DO NOT SCALE

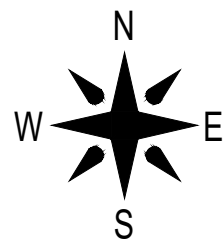

NOTES

- THIS DRAWING IS BASE UPON REDROW HOMES INDICATIVE SITE LAYOUT DRAWING REF BVF-16-02-03 - PROPOSED SITE LAYOUT AND TOPOGRAPHICAL SURVEY PROVIDED BY THE VENDOR.

KEY

- DEVELOPMENT BOUNDARY
- EXISTING COMBINED WATER DRAIN
- EXISTING WATER COURSE
- PROPOSED SURFACE WATER DRAIN
- PROPOSED PUBLIC FOUL WATER DRAIN
- PROPOSED PUBLIC FOUL WATER R
- PROPOSED DRAINAGE EASEMENT

F	25.03.2021	MML	Updated to new layout	MML
E	09.12.2020	JN	Updated to new layout	SA
D	02.07.2021	MML	Note correction in relation to attenuation basin	MML
C	28.04.2021	MML	Access track position amended	MML
B	28.04.2021	MML	Revision to attenuation position	MML
A	19.04.2021	MML	Revision to attenuation position	MML
REV	DATE	BY	DESCRIPTION	APPROVED

REDROW

Redrow House, Brunel Road, Wakefield 41 Industrial Estate, WF2 0XG
Tel: +44 (0)1924 822 566
www.redrow.co.uk

MARKETING NAME			
BRADLEY VILLA FARM HUDDERSFIELD			
PROJECT			
TITLE			
PROPOSED DRAINAGE LAYOUT SHEET 2			
SCALE @ A1	DESIGN DRAWN	APPROVED	DATE
1:500	MML	KL	MARCH 2021
PROJECT No	Drawing No	REV	
4607	4607-16-06-902	F	
© Redrow plc or its group companies. All rights reserved.			