


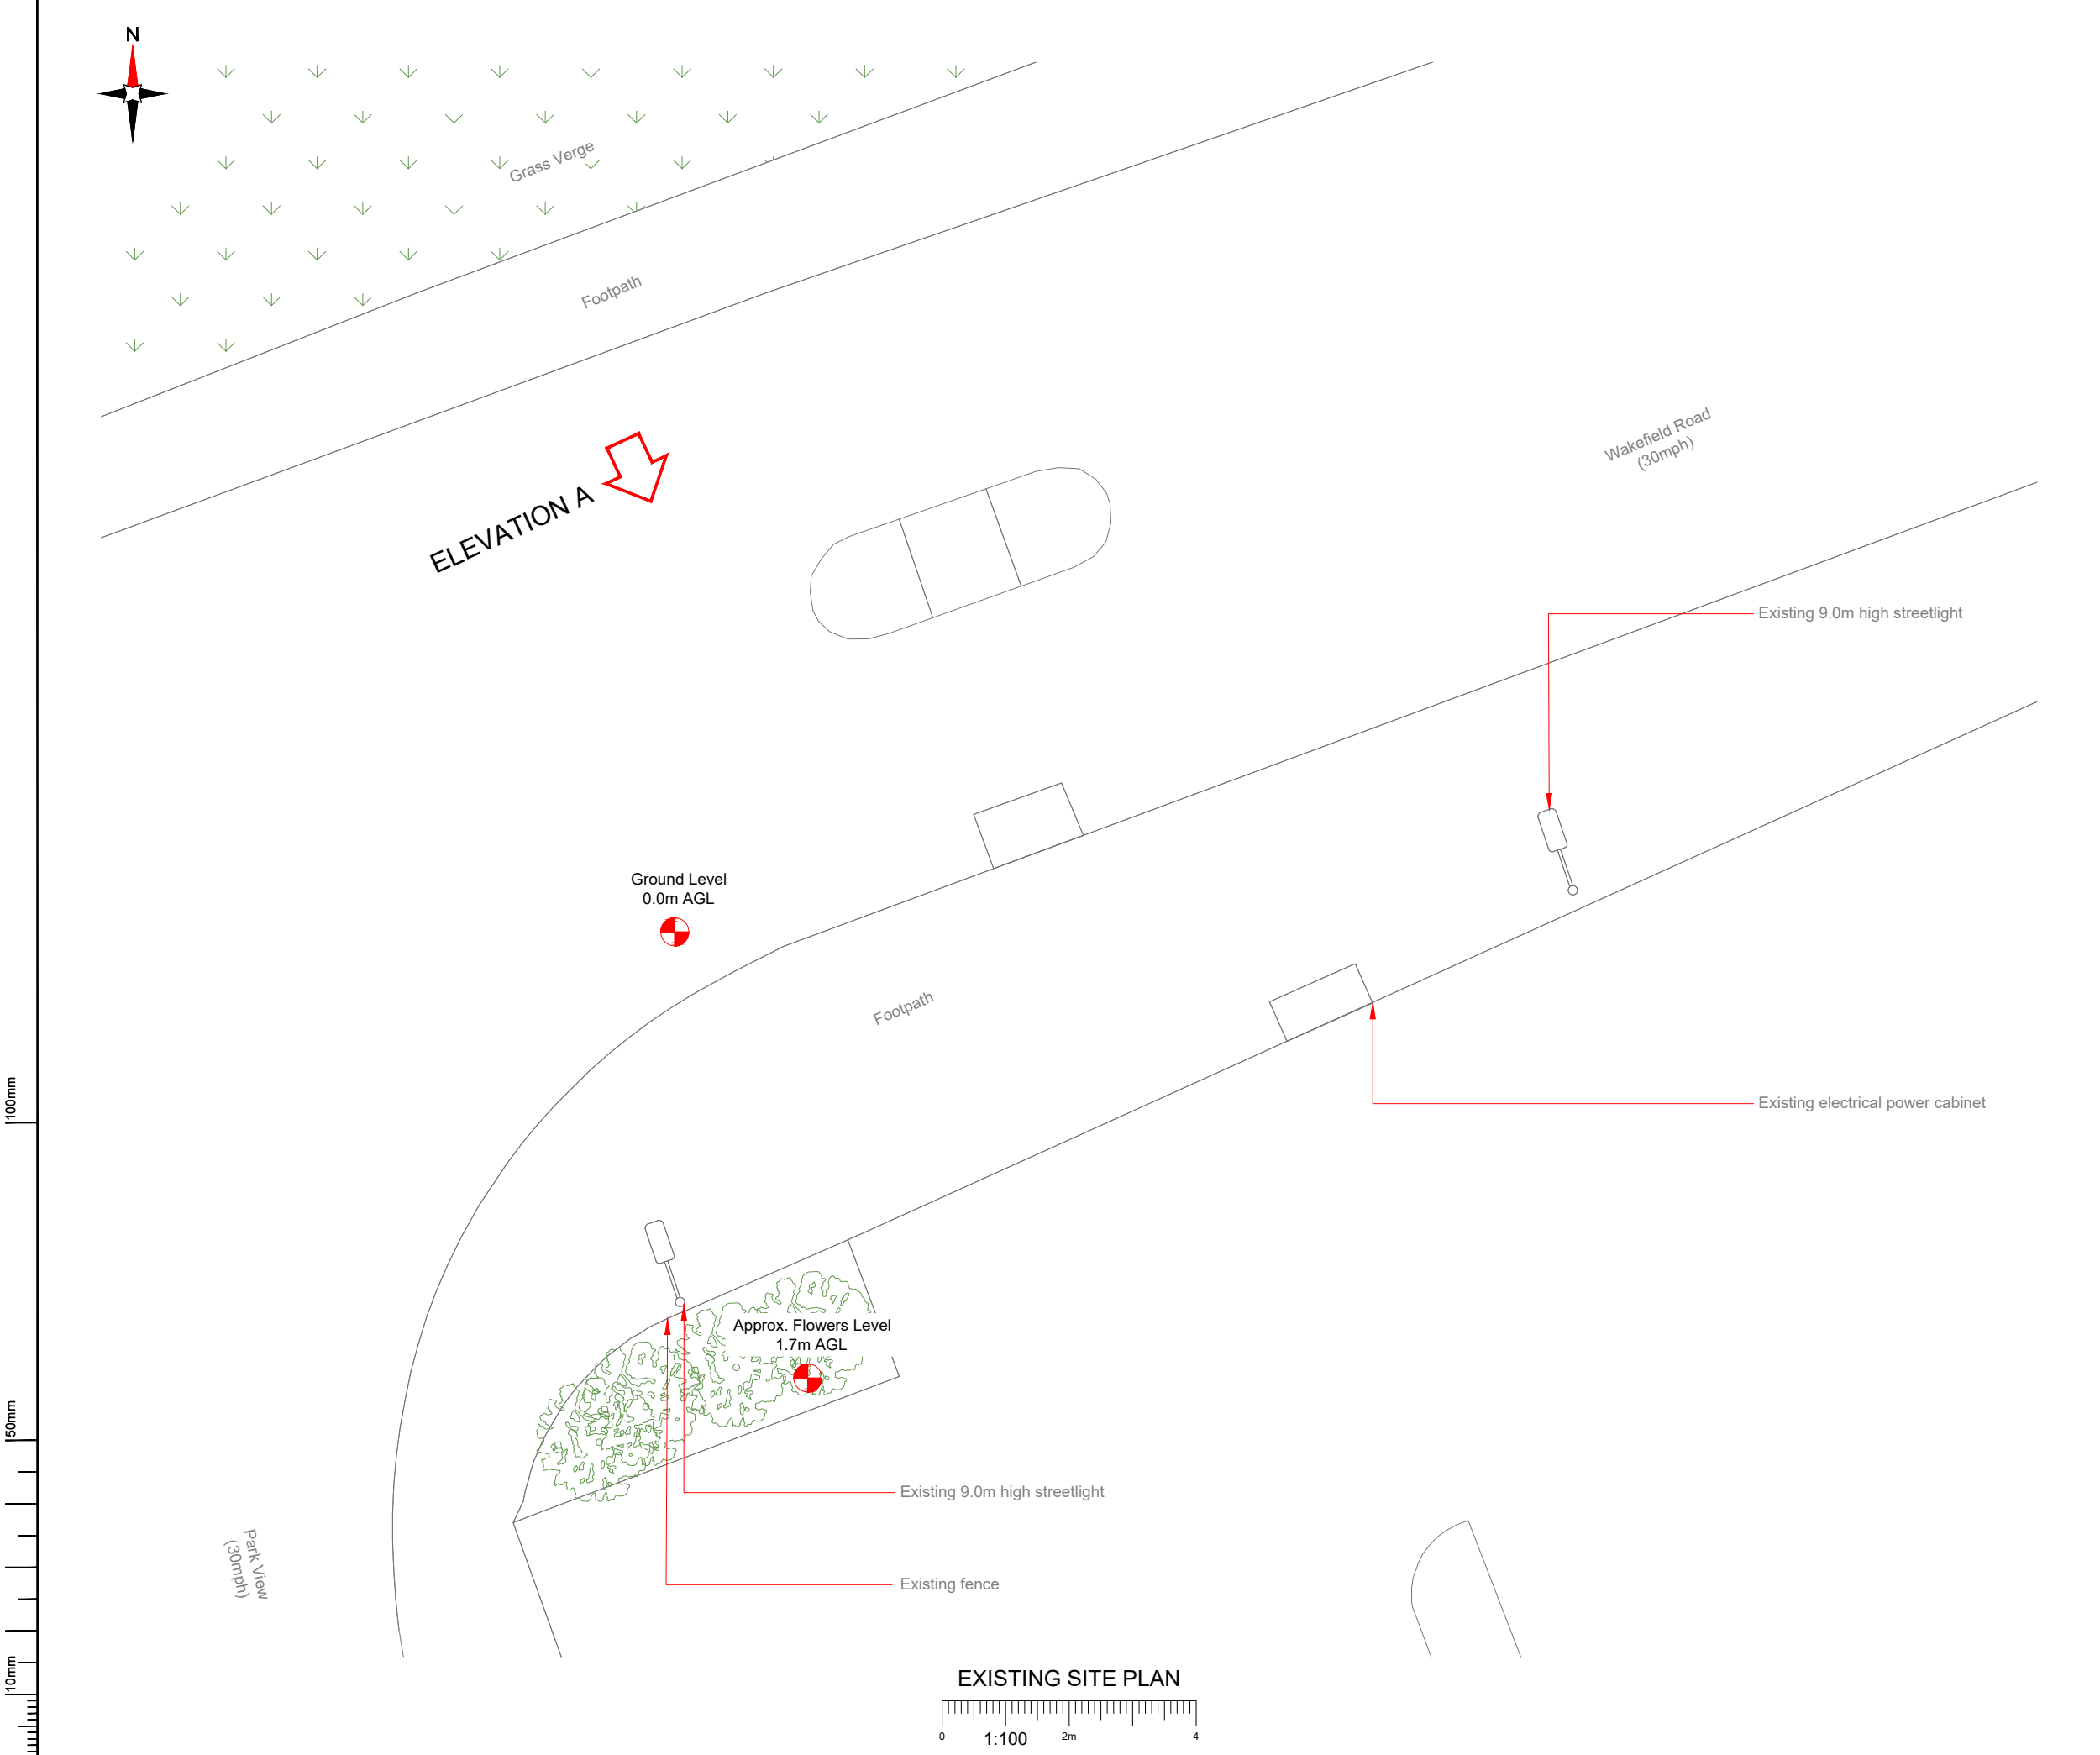

NOTES:

1. ALL DIMENSIONS IN MM UNLESS OTHERWISE NOTED.

Master:	MBNL / EE:	Project:	Purpose of Issue:	Issue:
M001	MBNL	5G UNILATERAL	Planning	A
Date:	XX/XX/XXXX	Revision / Upgrade Description:		
Drawn:	CDN	First Issue - Site nomination dated: TBC		
Checked:	DH			
Approved:	SD			
CK Hutchison Networks (UK) Limited Great Brighams Mead, Vastern Road, Reading, Berkshire, England, RG1 8DJ Design Consultant & Principal Contractor:  WHP Telecoms Unit 1 Maple Park, Low Fields Avenue, Leeds LS12 6HH Tel: 01133023550 e-mail: info@whptelecoms.com				
Site Name:		SW AT WAKEFIELD ROAD		
Site ID:		KKS17526		
Address:		WAKEFIELD ROAD, EARLSHEATON, DEWSBURY, KIRKLEES, WEST YORKSHIRE, WF12 8AH		
Title:		100 EXISTING SITE PLAN		
Project:		5G UNILATERAL		
Purpose of Issue:		PLANNING		
EE Cell ID:	MBNL Cell ID:	Cell ID:		
N/A	N/A	N/A		
Master Drawing No:				Issue:
KKS17526_M001				A