 


SITE LOCATION




Reproduced by permission of Ordnance Survey on behalf of the Controller of Her Majesty's Stationary Office
All rights reserved. © Crown Copyright licence no. 100022432

SITE AREA PLAN




SITE PHOTOGRAPH

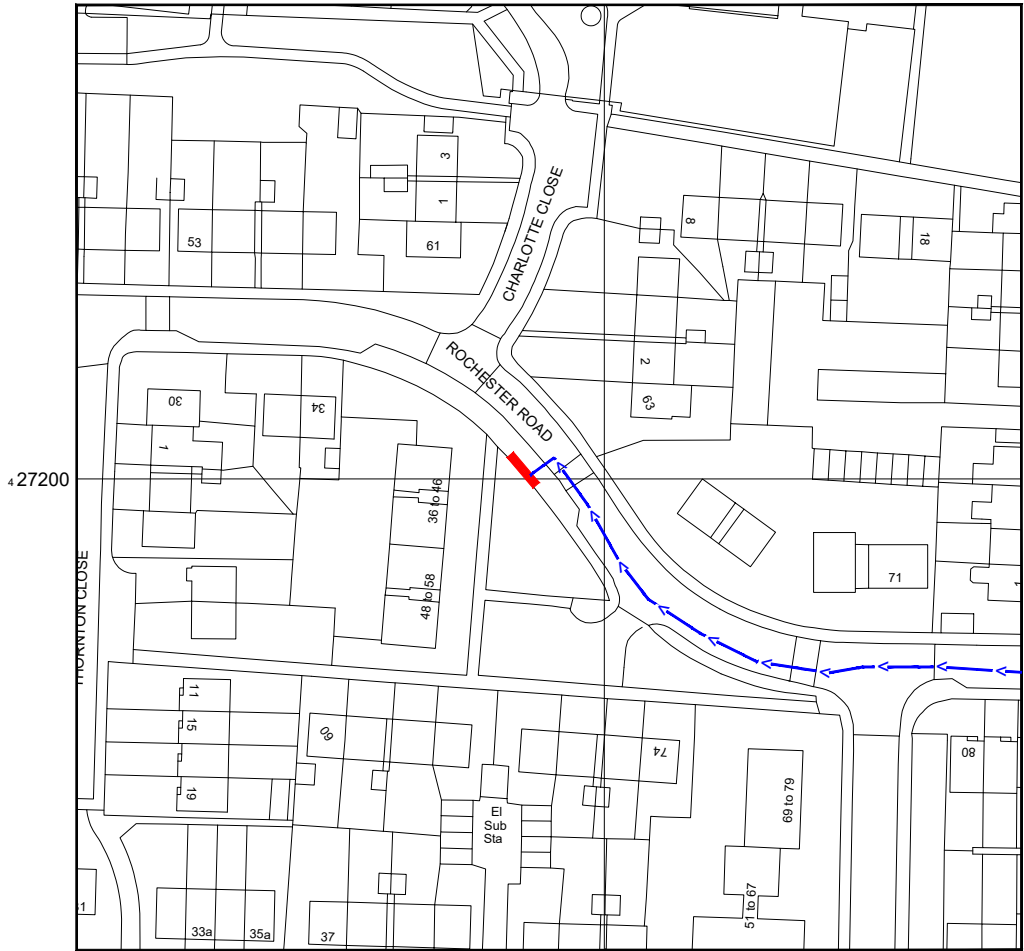

Reproduced by permission of Ordnance Survey on behalf of the Controller of Her Majesty's Stationary Office
All rights reserved. © Crown Copyright licence no. 100062043

NGR E: 422588 N: 427202

 SITE LOCATION PLAN



GOOGLE MAPS QR CODE

GOOGLE MAPS - <https://goo.gl/maps/ibdDknSpNxegHFNG7>

GOOGLE STREETVIEW - <https://goo.gl/maps/XQnJRfoLKiv3h7nn8>

NOTES:

1. ALL DIMENSIONS IN MM UNLESS OTHERWISE NOTED.
- DIRECTIONS TO SITE:
Head northwest on M62. At junction 27, Use the left 2 lanes to merge onto Gelderd Rd/A62 toward Batley. Use the left 2 lanes to turn slightly left to stay on Gelderd Rd/A62. At the roundabout, take the 2nd exit and stay on Gelderd Rd/A62. Turn right onto Dark Ln. Turn left onto Lowood Ln. Turn right onto Rochester Rd. Follow Rochester Rd and site location is on the left hand side.



Master:	MBNL / EE:	Project:	Purpose of Issue:	Issue:
M002	MBNL	5G UNILATERAL	Planning	B
Date:	10/05/2021	Revision / Upgrade Description:		
Drawn:	CDN	Pole height reduced to 15 m		
Checked:	DH			
Approved:	SD			
Master:	MBNL / EE:	Project:	Purpose of Issue:	Issue:
M001	MBNL	5G UNILATERAL	Planning	A
Date:	10/05/2021	Revision / Upgrade Description:		
Drawn:	CDN	First Issue - Site nomination dated: TBC		
Checked:	DH			
Approved:	SD			

CK Hutchison Networks (UK) Limited

Great Brighams Mead,
Vastern Road, Reading,
Berkshire, England,
RG1 8DJ


Design Consultant & Principal Contractor:



WHP Telecoms
Unit 1 Maple Park,
Low Fields Avenue, Leeds
LS12 6HH

Tel: 01133023550
e-mail: info@whptelecoms.com

Site Name:	ROCHESTER ROAD STREETWORKS		
Site ID:	KKS17095		
Address:	ROCHESTER ROAD, OAKWELL INDUSTRIAL PARK, BIRSTALL, KIRKLEES, WEST YORKSHIRE, YORKSHIRE AND THE HUMBER, ENGLAND, WF17 9BU		
Title:	002 SITE LOCATION PLAN		
Project:	5G UNILATERAL		
Purpose of Issue:	PLANNING		
EE Cell ID:	N/A	MBNL Cell ID:	N/A
Cell ID:	N/A		Issue:
Master Drawing No:	KKS17095_M002		B

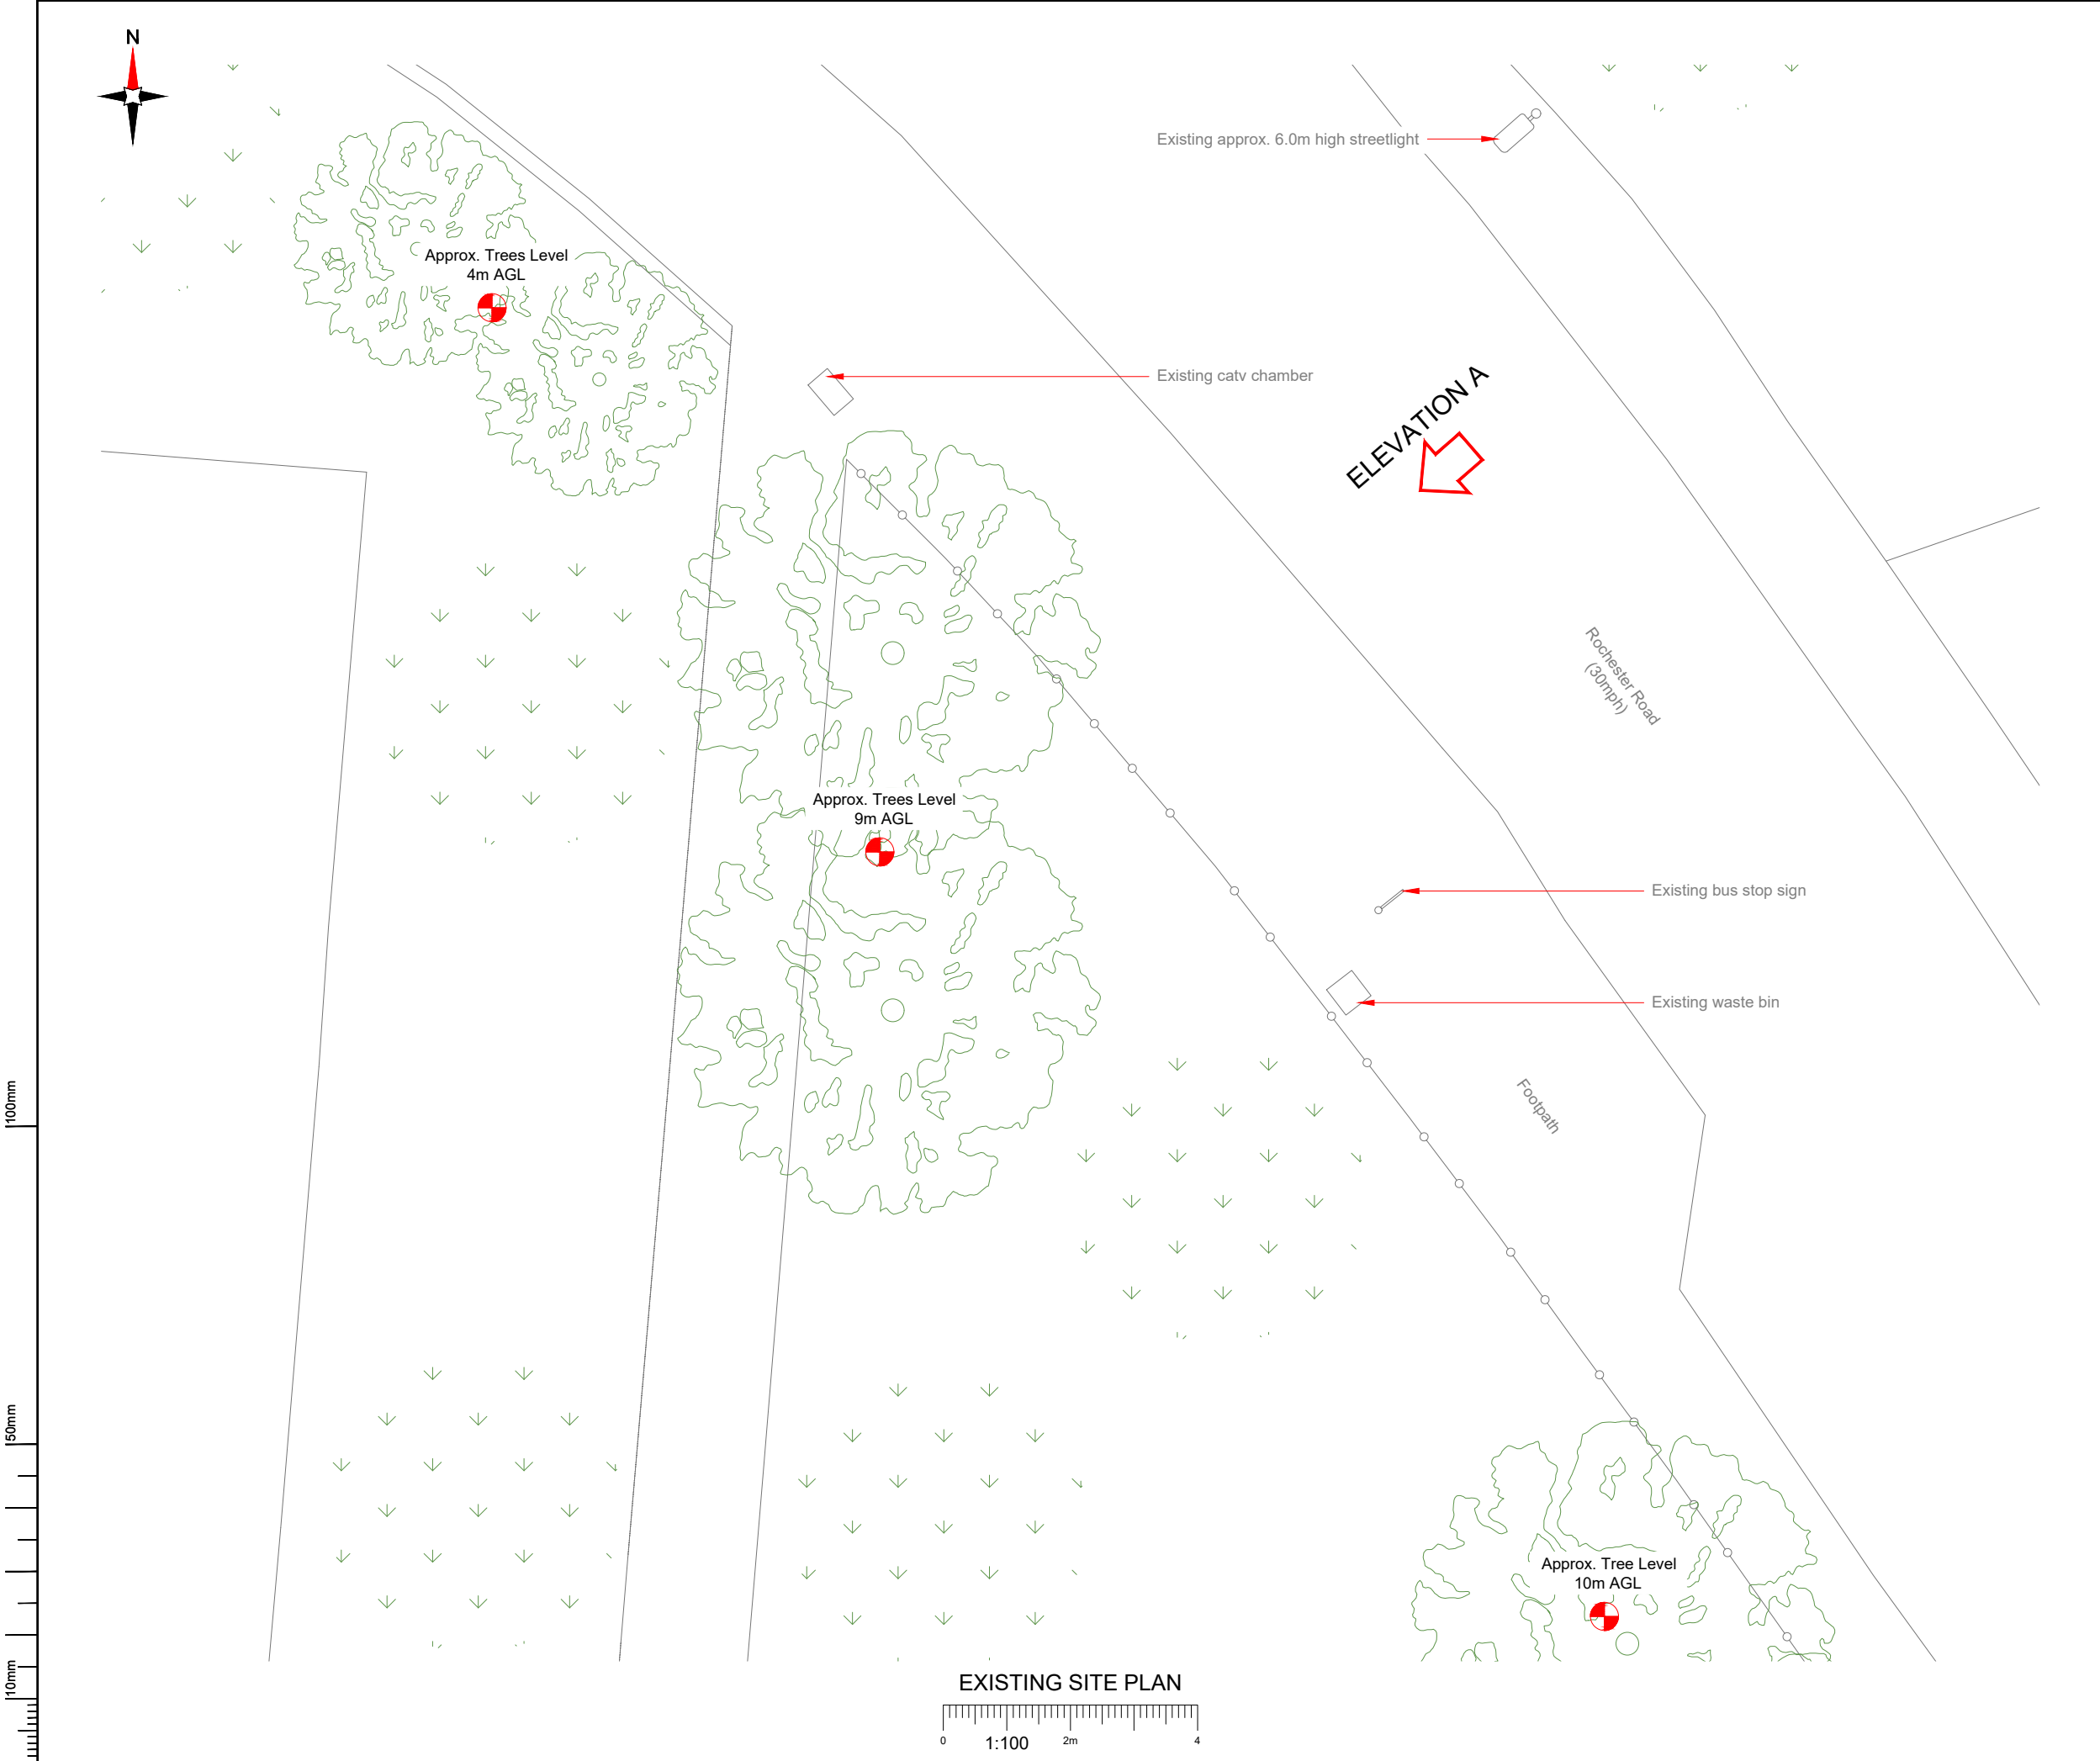

NOTES:

1. ALL DIMENSIONS IN MM UNLESS OTHERWISE NOTED.

Master:	MBNL / EE:	Project:	Purpose of Issue:	Issue:
M002	MBNL	5G UNILATERAL	Planning	B
Date:	10/05/2021	Revision / Upgrade Description:		
Drawn:	CDN	Pole height reduced to 15 m		
Checked:	DH			
Approved:	SD			
Master:	MBNL / EE:	Project:	Purpose of Issue:	Issue:
M001	MBNL	5G UNILATERAL	Planning	A
Date:	10/05/2021	Revision / Upgrade Description:		
Drawn:	CDN	First Issue - Site nomination dated: TBC		
Checked:	DH			
Approved:	SD			

CK Hutchison Networks (UK) Limited

Great Brighams Mead,
Vastern Road, Reading,
Berkshire, England,
RG1 8DJ

Design Consultant & Principal Contractor:



WHP Telecoms
Unit 1 Maple Park,
Low Fields Avenue, Leeds
LS12 6HH

Tel: 01133023550
e-mail: info@whptelecoms.com

Site Name:

ROCHESTER ROAD STREETWORKS

Site ID:

KKS17095

Address:

ROCHESTER ROAD, OAKWELL
INDUSTRIAL PARK, BIRSTALL, KIRKLEES,
WEST YORKSHIRE, YORKSHIRE AND THE
HUMBER, ENGLAND, WF17 9BU

Title:

100 EXISTING SITE PLAN

Project:

5G UNILATERAL

Purpose of Issue:

PLANNING

EE Cell ID:	MBNL Cell ID:	Cell ID:
N/A	N/A	N/A

Master Drawing No:

KKS17095_M002

Issue:

B

 
100mm

50mm

10mm



EXISTING ELEVATION A



- NOTES:
1. ALL DIMENSIONS IN MM UNLESS OTHERWISE NOTED.

Master:	MBNL / EE:	Project:	Purpose of Issue:	Issue:
M002	MBNL	5G UNILATERAL	Planning	B
Date:	10/05/2021	Revision / Upgrade Description:		
Drawn:	CDN	Pole height reduced to 15 m		
Checked:	DH			
Approved:	SD			
Master:	MBNL / EE:	Project:	Purpose of Issue:	Issue:
M001	MBNL	5G UNILATERAL	Planning	A
Date:	10/05/2021	Revision / Upgrade Description:		
Drawn:	CDN	First Issue - Site nomination dated: TBC		
Checked:	DH			
Approved:	SD			

CK Hutchison
Networks (UK)
Limited

Great Brighams Mead,
Vastern Road, Reading,
Berkshire, England,
RG1 8DJ

Design Consultant & Principal Contractor:



WHP Telecoms
Unit 1 Maple Park,
Low Fields Avenue, Leeds
LS12 6HH

Tel: 01133023550
e-mail: info@whptelecoms.com

Site Name:
ROCHESTER ROAD STREETWORKS

Site ID:
KKS17095

Address:
ROCHESTER ROAD, OAKWELL
INDUSTRIAL PARK, BIRSTALL, KIRKLEES,
WEST YORKSHIRE, YORKSHIRE AND THE
HUMBER, ENGLAND, WF17 9BU


Title:
150 EXISTING ELEVATION A

Project:
5G UNILATERAL


Purpose of Issue:
PLANNING

EE Cell ID: N/A	MBNL Cell ID: N/A	Cell ID: N/A
--------------------	----------------------	-----------------

Master Drawing No: KKS17095_M002	Issue: B
-------------------------------------	-------------

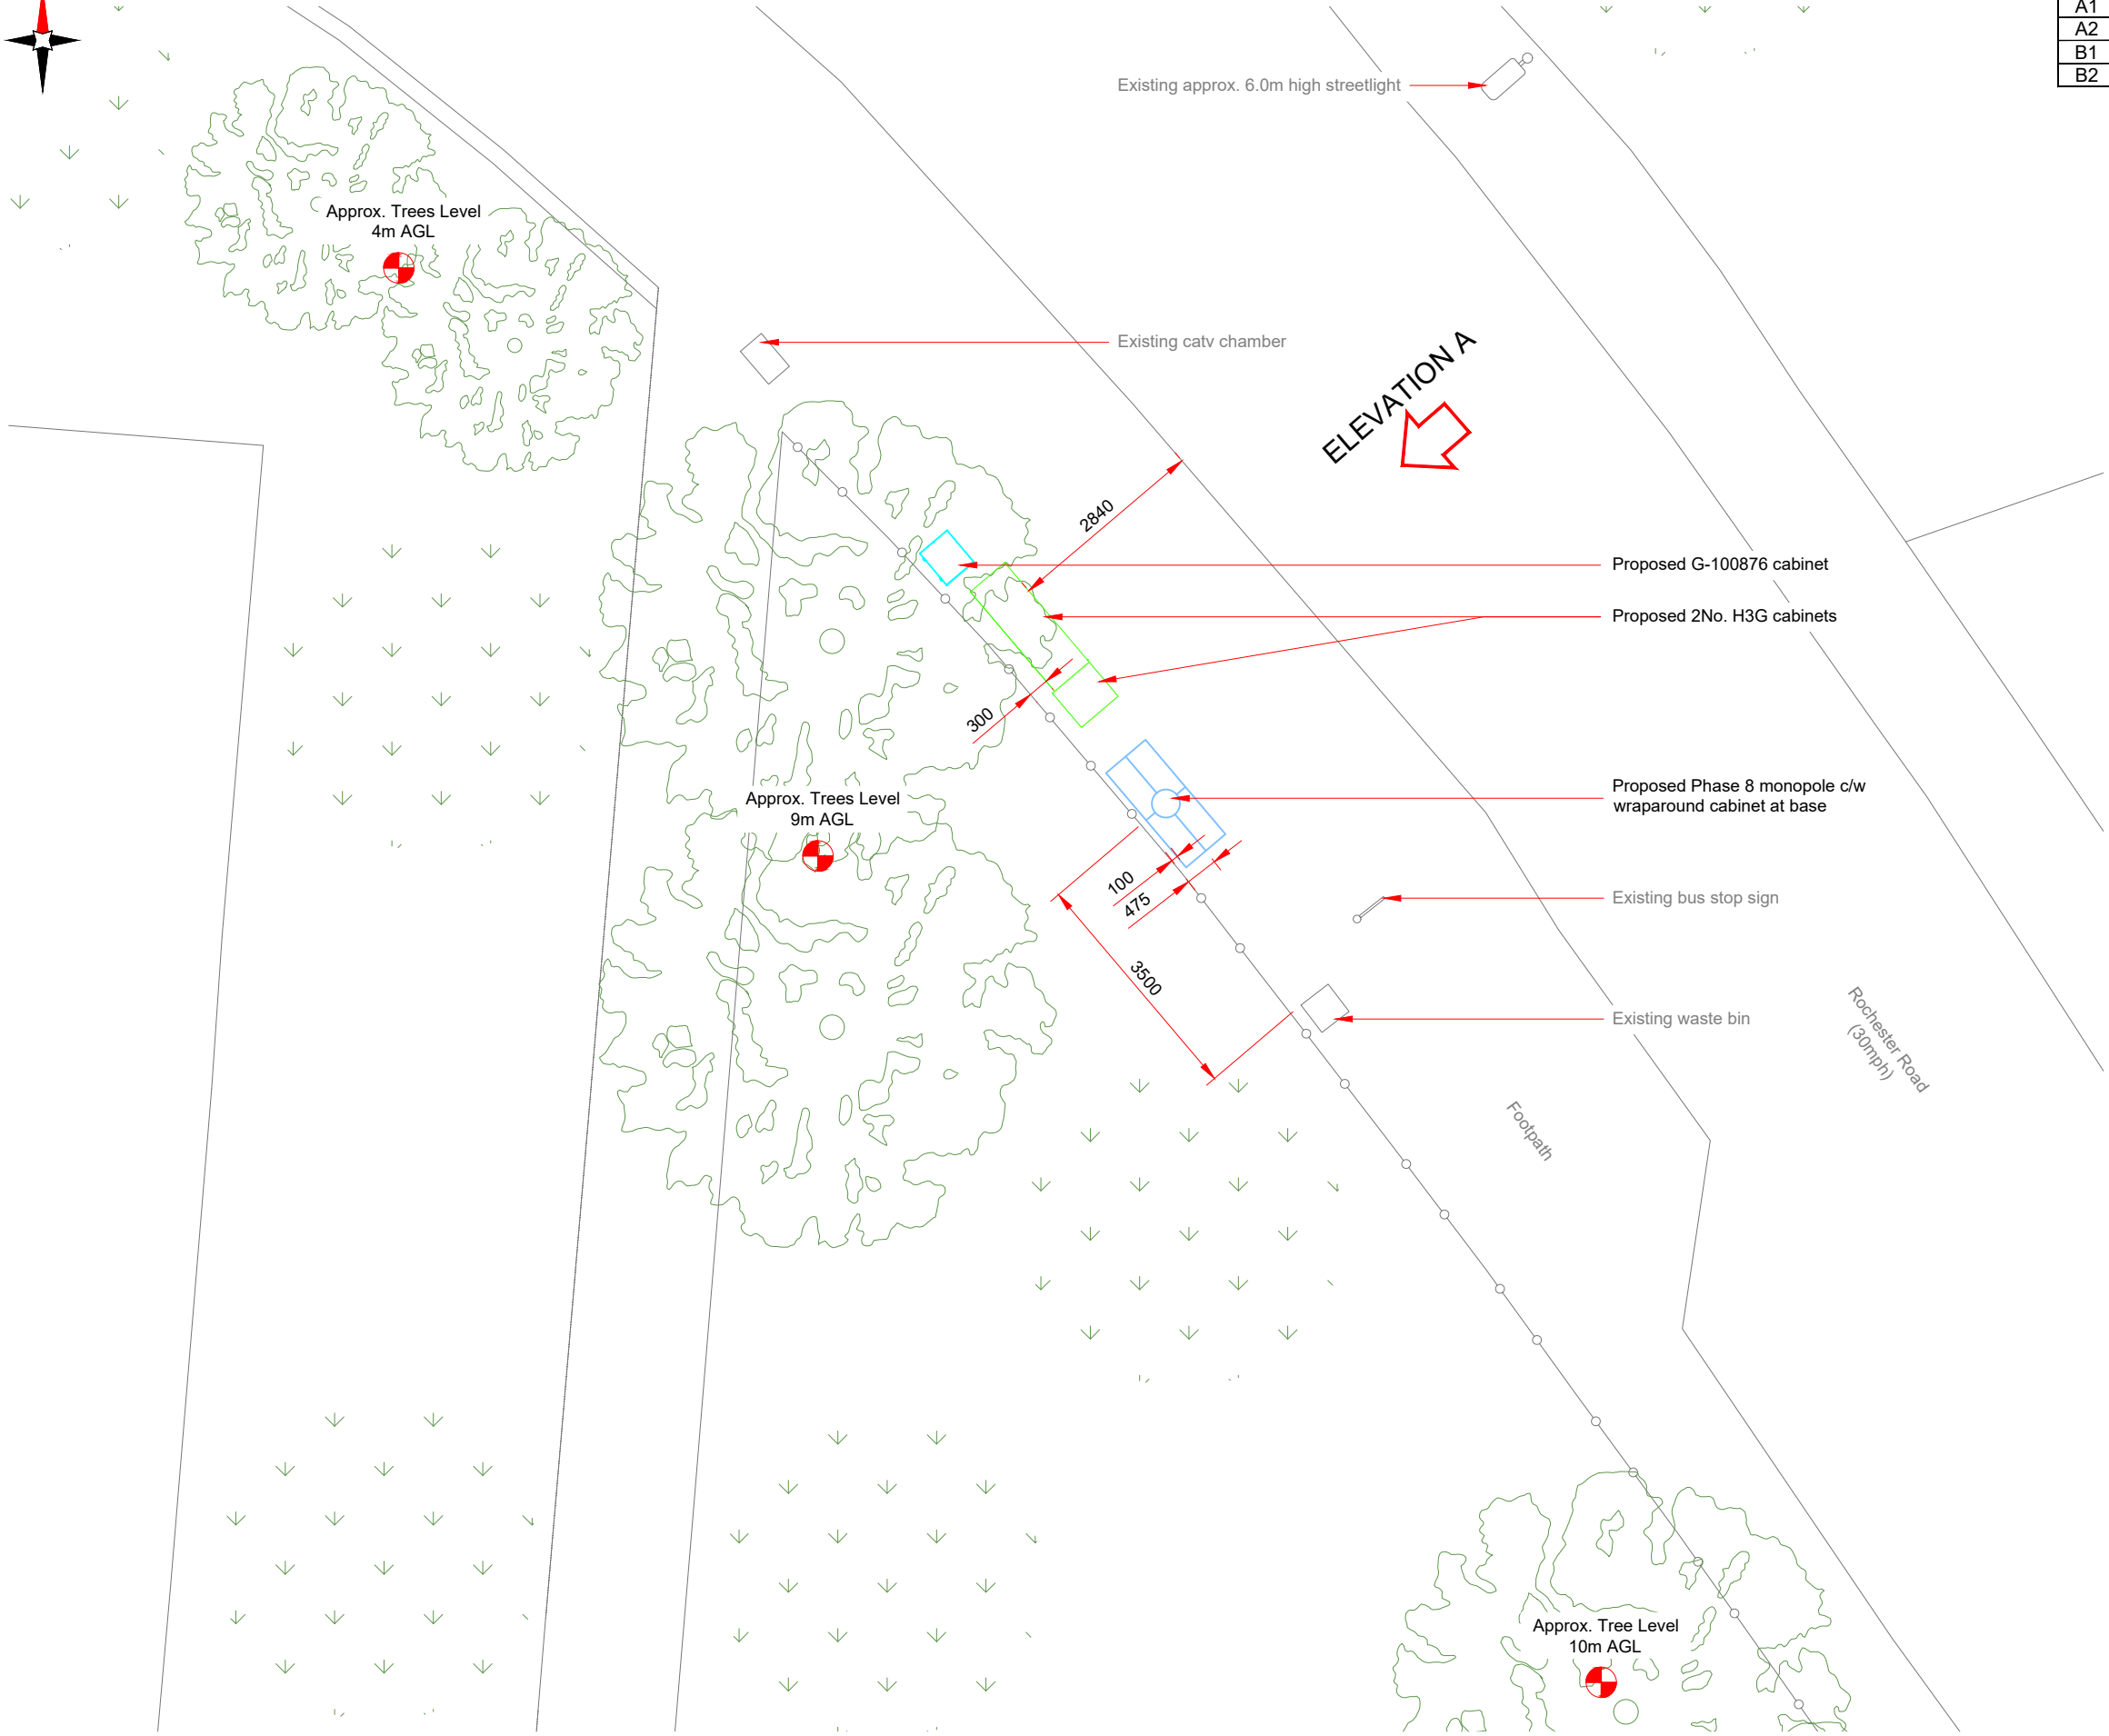

PROPOSED SITE PLAN

 

Antenna Aperture ID	Proposed 4G/5G Bearing
A1	60°
A2	60°
B1	180°
B2	180°

NOTES:
1. ALL DIMENSIONS IN MM UNLESS OTHERWISE NOTED.

Master:	MBNL / EE:	Project:	Purpose of Issue:	Issue:
M002	MBNL	5G UNILATERAL	Planning	B
Date:	10/05/2021	Revision / Upgrade Description:		
Drawn:	CDN	Pole height reduced to 15 m		
Checked:	DH			
Approved:	SD			
Master:	MBNL / EE:	Project:	Purpose of Issue:	Issue:
M001	MBNL	5G UNILATERAL	Planning	A
Date:	10/05/2021	Revision / Upgrade Description:		
Drawn:	CDN	First Issue - Site nomination dated: TBC		
Checked:	DH			
Approved:	SD			

CK Hutchison Networks (UK) Limited

Great Brighams Mead,
Vastern Road, Reading,
Berkshire, England,
RG1 8DJ

Design Consultant & Principal Contractor:



WHP Telecoms

Unit 1 Maple Park,
Low Fields Avenue, Leeds
LS12 6HH

Tel: 01133023550
e-mail: info@whptelecoms.com

Site Name:
ROCHESTER ROAD STREETWORKS

Site ID:
KKS17095

Address:
ROCHESTER ROAD, OAKWELL
INDUSTRIAL PARK, BIRSTALL, KIRKLEES,
WEST YORKSHIRE, YORKSHIRE AND THE
HUMBER, ENGLAND, WF17 9BU

Title:
210 PROPOSED SITE PLAN

Project:
5G UNILATERAL

Purpose of Issue:
PLANNING


EE Cell ID:	MBNL Cell ID:	Cell ID:
N/A	N/A	N/A

Master Drawing No:	Issue:
KKS17095_M002	B

Antenna Aperture ID	Proposed 4G/5G Bearing
A1	60°
A2	60°
B1	180°
B2	180°

NOTES:

1. ALL DIMENSIONS IN MM UNLESS OTHERWISE NOTED.

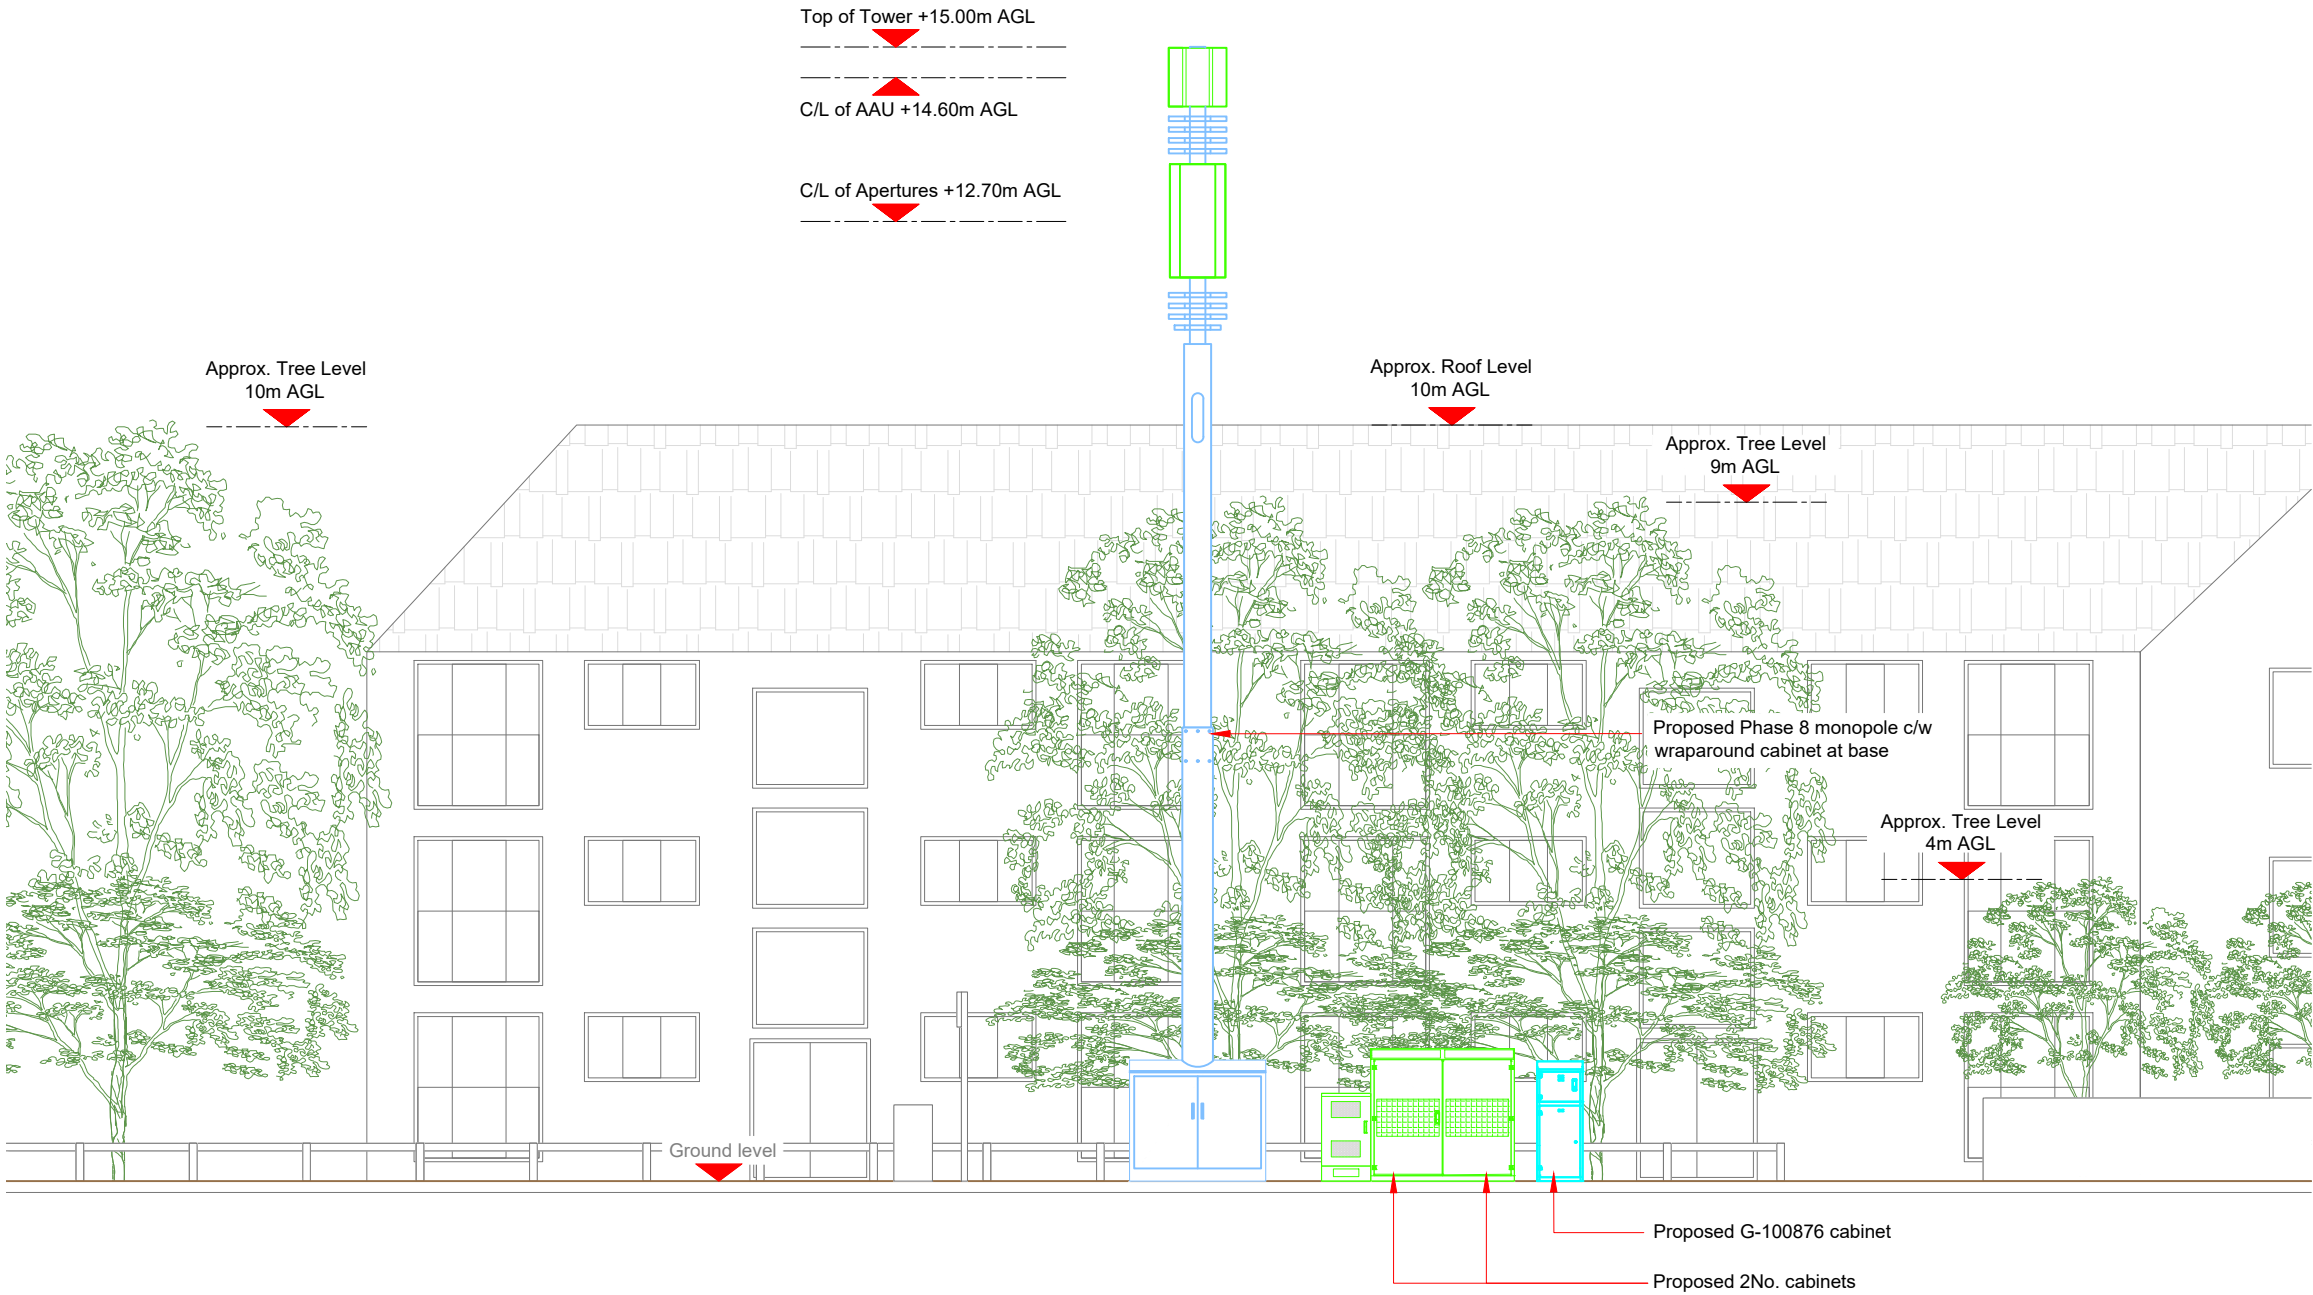

Master:	MBNL / EE:	Project:	Purpose of Issue:	Issue:
M002	MBNL	5G UNILATERAL	Planning	B
Date:	10/05/2021	Revision / Upgrade Description:		
Drawn:	CDN	Pole height reduced to 15 m		
Checked:	DH			
Approved:	SD			
Master:	MBNL / EE:	Project:	Purpose of Issue:	Issue:
M001	MBNL	5G UNILATERAL	Planning	A
Date:	10/05/2021	Revision / Upgrade Description:		
Drawn:	CDN	First Issue - Site nomination dated: TBC		
Checked:	DH			
Approved:	SD			

**CK Hutchison
Networks (UK)
Limited**

Great Brighams Mead,
Vastern Road, Reading,
Berkshire, England,
RG1 8DJ

Design Consultant & Principal Contractor:



WHP Telecoms

Unit 1 Maple Park,
Low Fields Avenue, Leeds
LS12 6HH

Tel: 01133023550
e-mail: info@whptelecoms.com

Site Name:
ROCHESTER ROAD STREETWORKS

Site ID:
KKS17095

Address:
**ROCHESTER ROAD, OAKWELL
INDUSTRIAL PARK, BIRSTALL, KIRKLEES,
WEST YORKSHIRE, YORKSHIRE AND THE
HUMBER, ENGLAND, WF17 9BU**

Title:
260 PROPOSED ELEVATION

Project:
5G UNILATERAL

Purpose of Issue:
PLANNING

EE Cell ID:	MBNL Cell ID:	Cell ID:
N/A	N/A	N/A

Master Drawing No:	Issue:
KKS17095_M002	B