


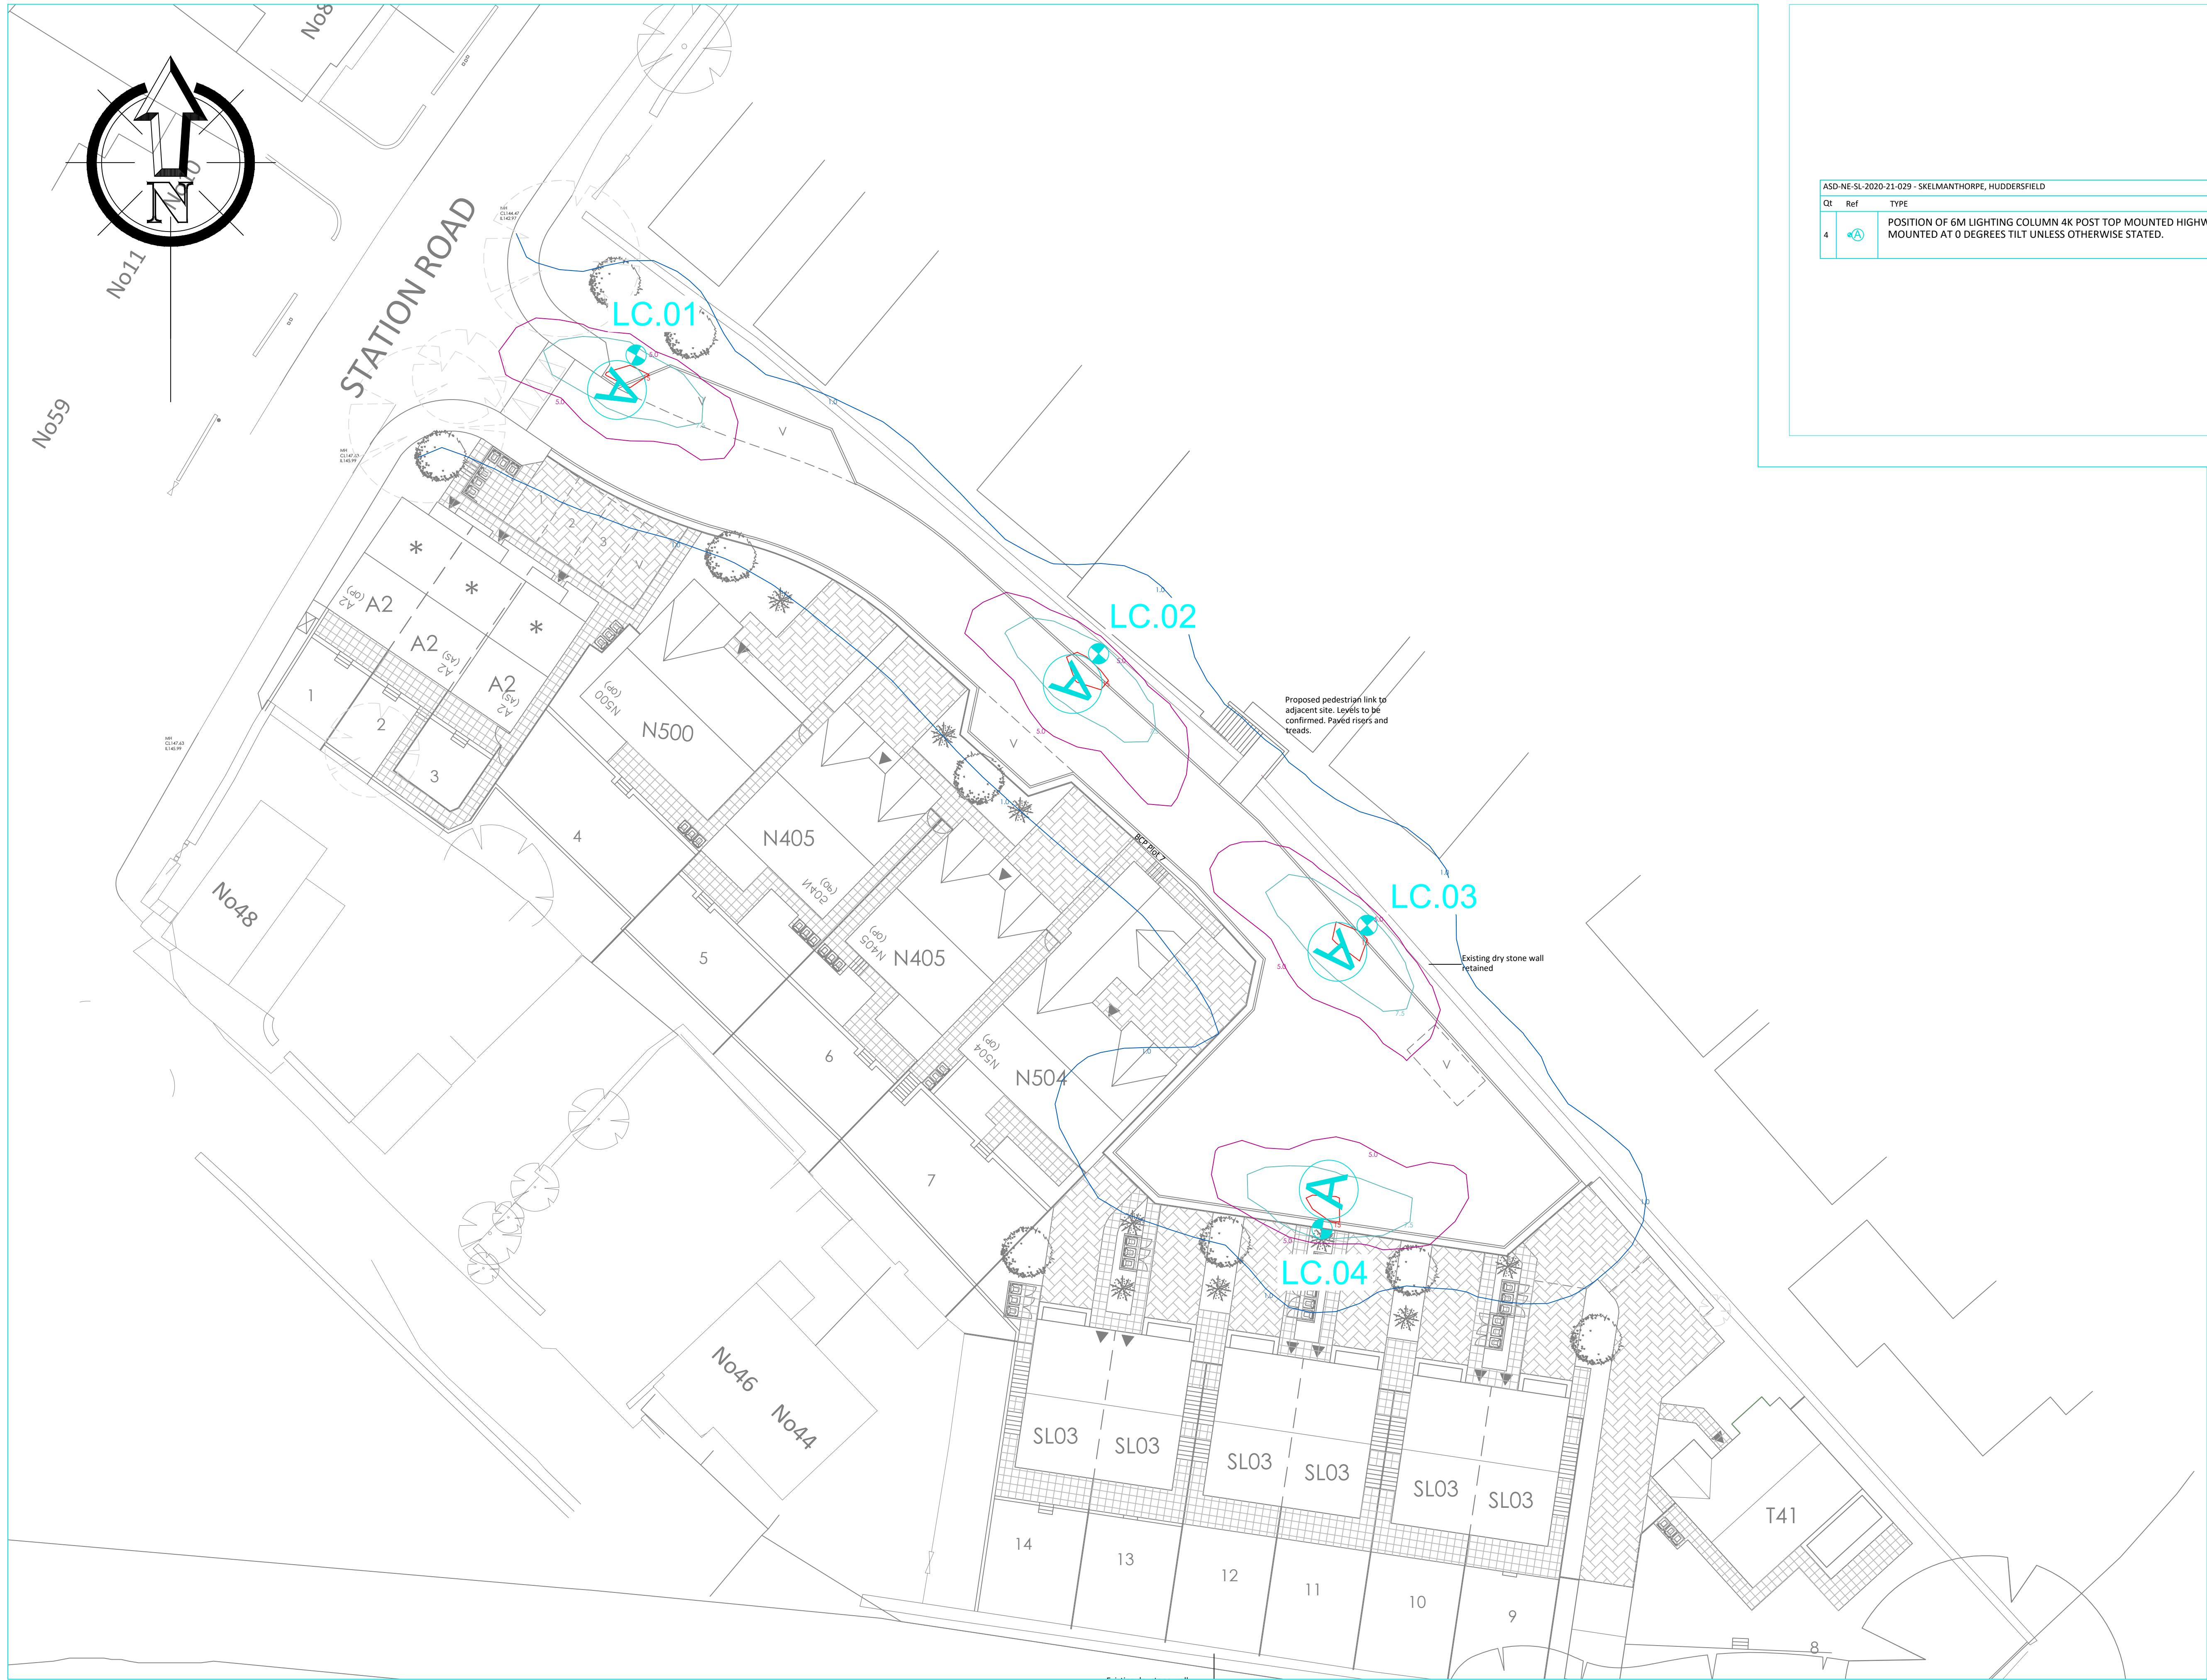

ASD-NE-SL-2020-21-029 - SKELMANTHORPE, HUDDERSFIELD		
Qt	Ref	TYPE
4		POSITION OF 6M LIGHTING COLUMN 4K POST TOP MOUNTED HIGHWAY DIAMOND 12 LED 500mA M1 LENS MOUNTED AT 0 DEGREES TILT UNLESS OTHERWISE STATED.

THE LIGHTING DESIGN HAS BEEN PREPARED IN ACCORDANCE WITH BS5489_2015 TO PROVIDE INDICATIVE COLUMN POSITIONS. FOR TRANSPARENCY AND THE AVOIDANCE OF DOUBT DRAWING no. ASD-NE-SL-2020-21-029 IS NOT TO BE USED AS A CONSTRUCTION DRAWING. A SITE SURVEY HAS NOT BEEN CARRIED OUT IN ACCORDANCE WITH CDM 2015 AND HEA GUIDELINES. THEREFORE THE RESPONSIBILITIES OF ELIMINATING AND REDUCING RISK WILL NEED TO MITIGATED BY A COMPETENT PRINCIPLE DESIGNER.

REV	DESCRIPTION	DATE	BY
ASD LIGHTING PLC MANGHAM ROAD BARBOT HALL INDUSTRIAL ESTATE ROTHERHAM S61 4RJ			
TITLE STREET LIGHTING LAYOUT STATION ROAD HOUSING DEVELOPMENT SKELMANTHORPE			
CUSTOMER NEWETT HOMES			
SCALE 1:200		DATE 04/03/21	
		DRAWN BJS	
		CHECKED MDE	
PAPER SIZE A1		APPROVED NF	
DRAWING NUMBER ASD-NE-SL-2020-21-029		REVISION R0	