


NOTES:

1. THIS DRAWING SHALL BE READ IN CONJUNCTION WITH THE M&E SERVICES STRATEGY, ARCHITECTS DRAWINGS AND ALL RELATED PROJECT DOCUMENTATION.
2. THE ELECTRICAL INSTALLATION SHALL BE IN INSTALLED ACCORDANCE WITH THE 18TH EDITION OF IEE WIRING REGULATIONS BS7671 (REQUIREMENTS FOR ELECTRICAL INSTALLATIONS).
3. THE CONTRACTOR SHALL SUPPLY AND INSTALL A COMPLETE AND COORDINATED EXTERNAL SECURITY / CCTV SYSTEM AS TYPICALLY DEPICTED ON THIS DRAWING.
4. THIS DRAWING DOES NOT DEPICT THE EXISTING INGROUND SITE SERVICES AROUND THE SITE.
5. CCTV TO BE IP BASED & OPERATE OVER ICT WIRING.
6. NVR DEVICE TO BE LOCATED IN SERVER ROOM C/W CONTROLS, SCREEN & ARCHIVING STATION.
7. A NACOSS / NSI ACCREDITED SPECIALIST SECURITY SPECIALIST SHALL BE APPOINTED TO COMPLETE THE FINAL CONSTRUCTION STAGE DRAWINGS.
8. CAMERAS TO BE MEGAPIXEL HD TYPE & RECORD AT 25FPS.
9. NVR TO BE SIZED TO RECORD FOR A PERIOD OF 31 DAYS.
10. THIS DRAWING IS PROVIDED TO ILLUSTRATE DESIGN INTENT ONLY AND IS SUBJECT TO DETAILED DESIGN. NO FINAL QUANTITIES, LENGTHS OR SIZES SHALL BE TAKEN FROM THIS DRAWING.

LEGEND

-  BUILDING MOUNTED DOME CCTV CAMERA
-  COLUMN MOUNTED DOME CCTV CAMERA.

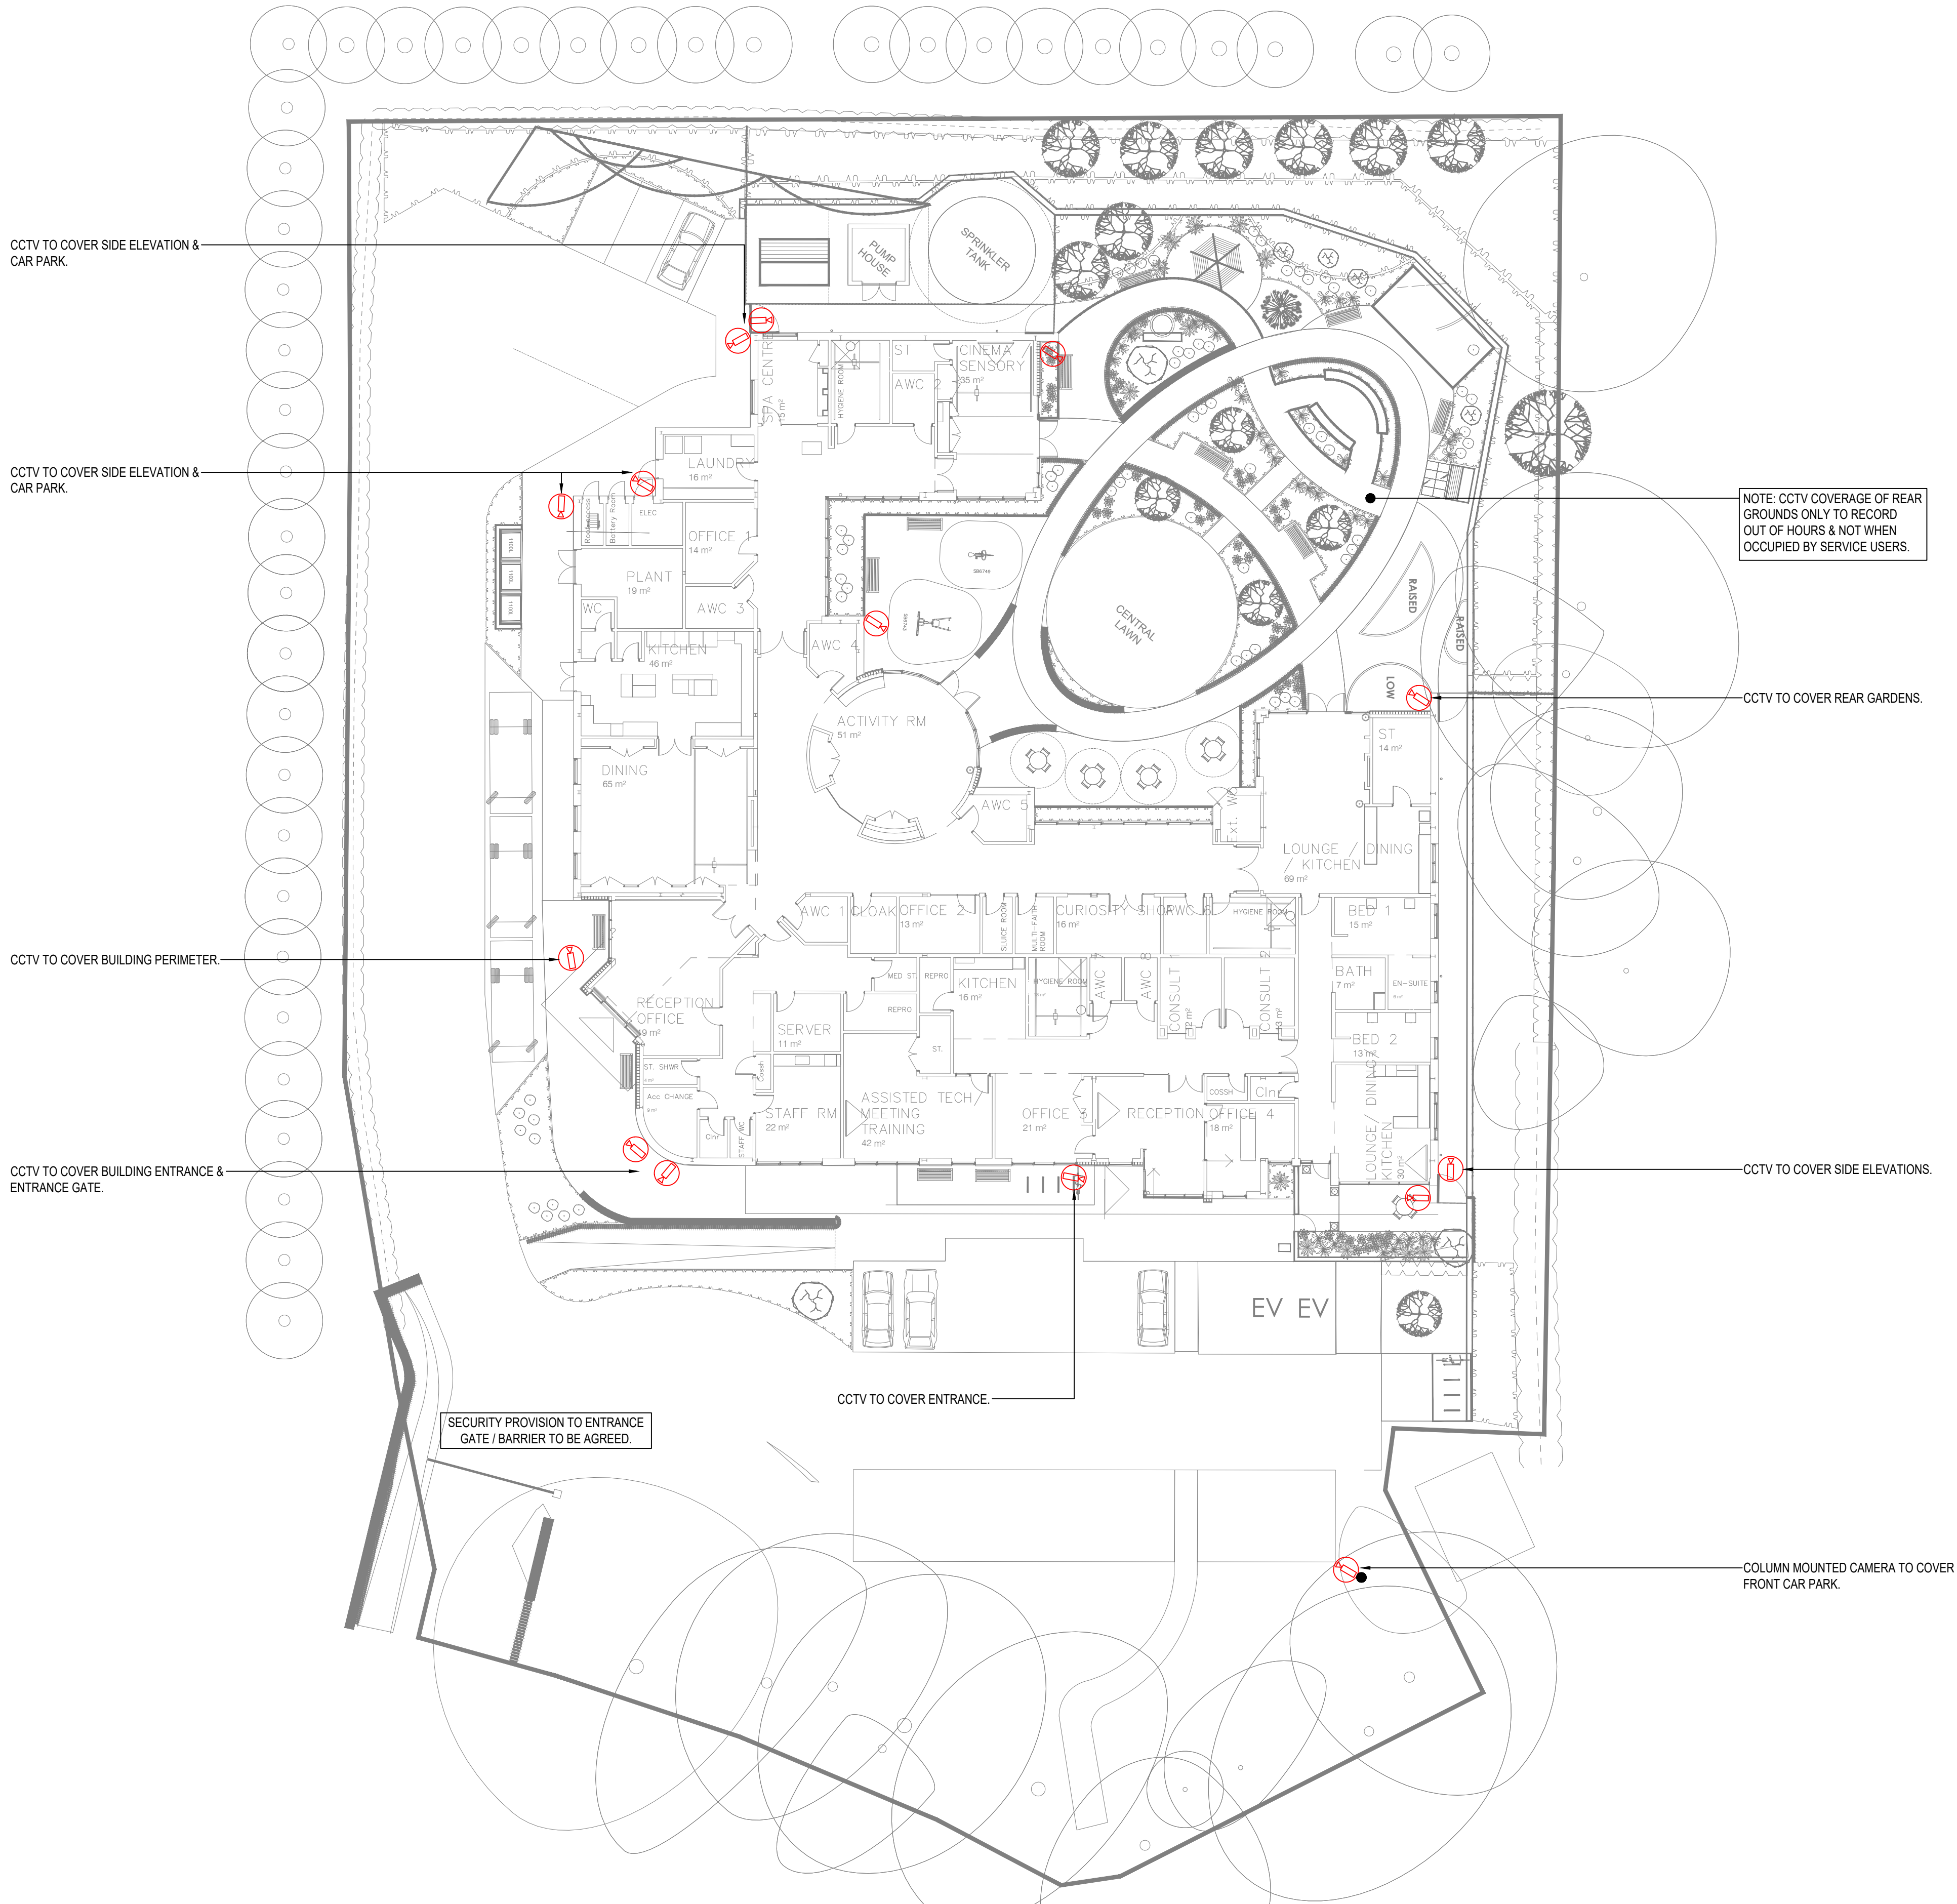

SECURITY PROVISION TO ENTRANCE
GATE / BARRIER TO BE AGREED.

P1	PRELIMINARY ISSUE	12.07.21	JJ	MK
REV	DESCRIPTION	DATE	DRAWN	APPROVED

PRELIMINARY



PROJECT
KIRKLEES DEMENTIA FACILITY
KNOWL PARK

DRAWING TITLE
ELECTRICAL SERVICES
PROPOSED EXTERNAL SECURITY LAYOUT

ENGINEERING SERVICES DESIGN LIMITED

MECHANICAL & ELECTRICAL
CONSULTING ENGINEERS

No. 3, BROOKLANDS PLACE
BROOKLANDS ROAD
SALE, M33 3SD.

TEL: 0161-694-4560
EMAIL: ENQUIRIES@ESD.LTD.CO.UK
WEB: WWW.ESD.LTD.CO.UK



DRAWN	JJ	DATE	22.02.21
CHECKED	MK	DATE	22.02.21
APPROVED	PH	DATE	22.02.21
SCALE 1:200@A1			
DRAWING NO.	KPH-ESD-ZZ-00-DR-E-6900		REV P1