



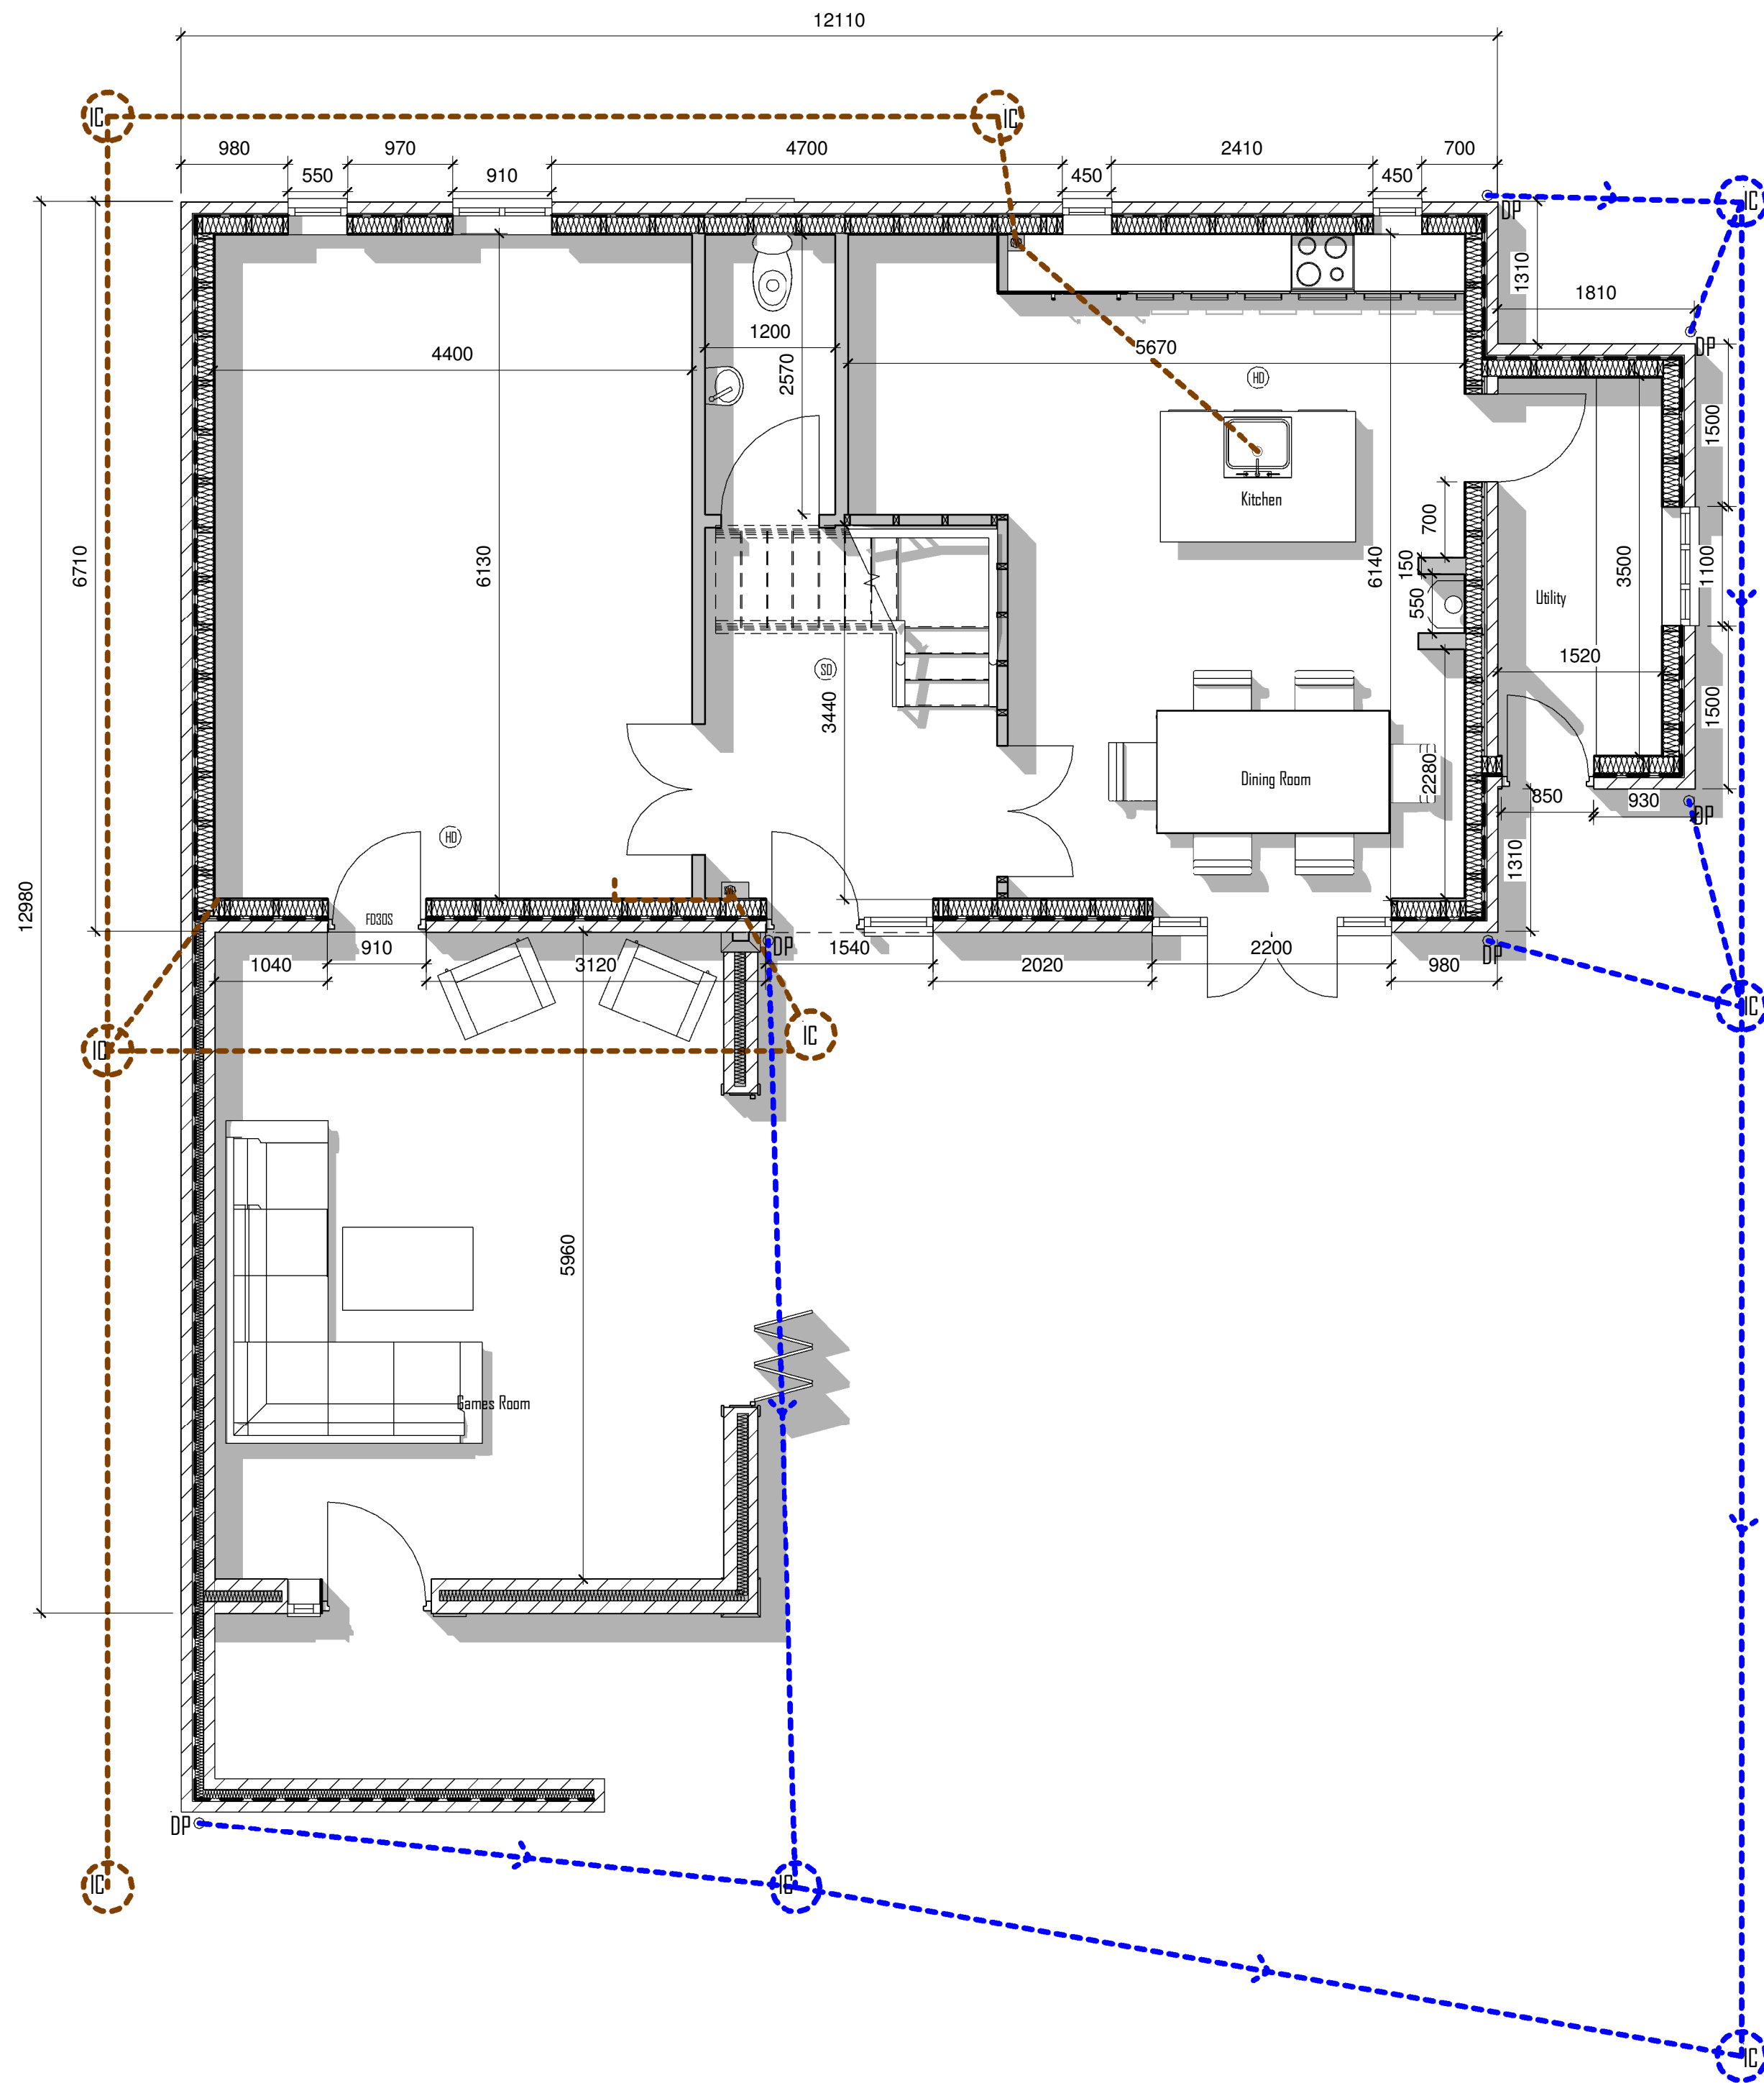

2050_02_RevA_BWSection_Plot 1_A1_20

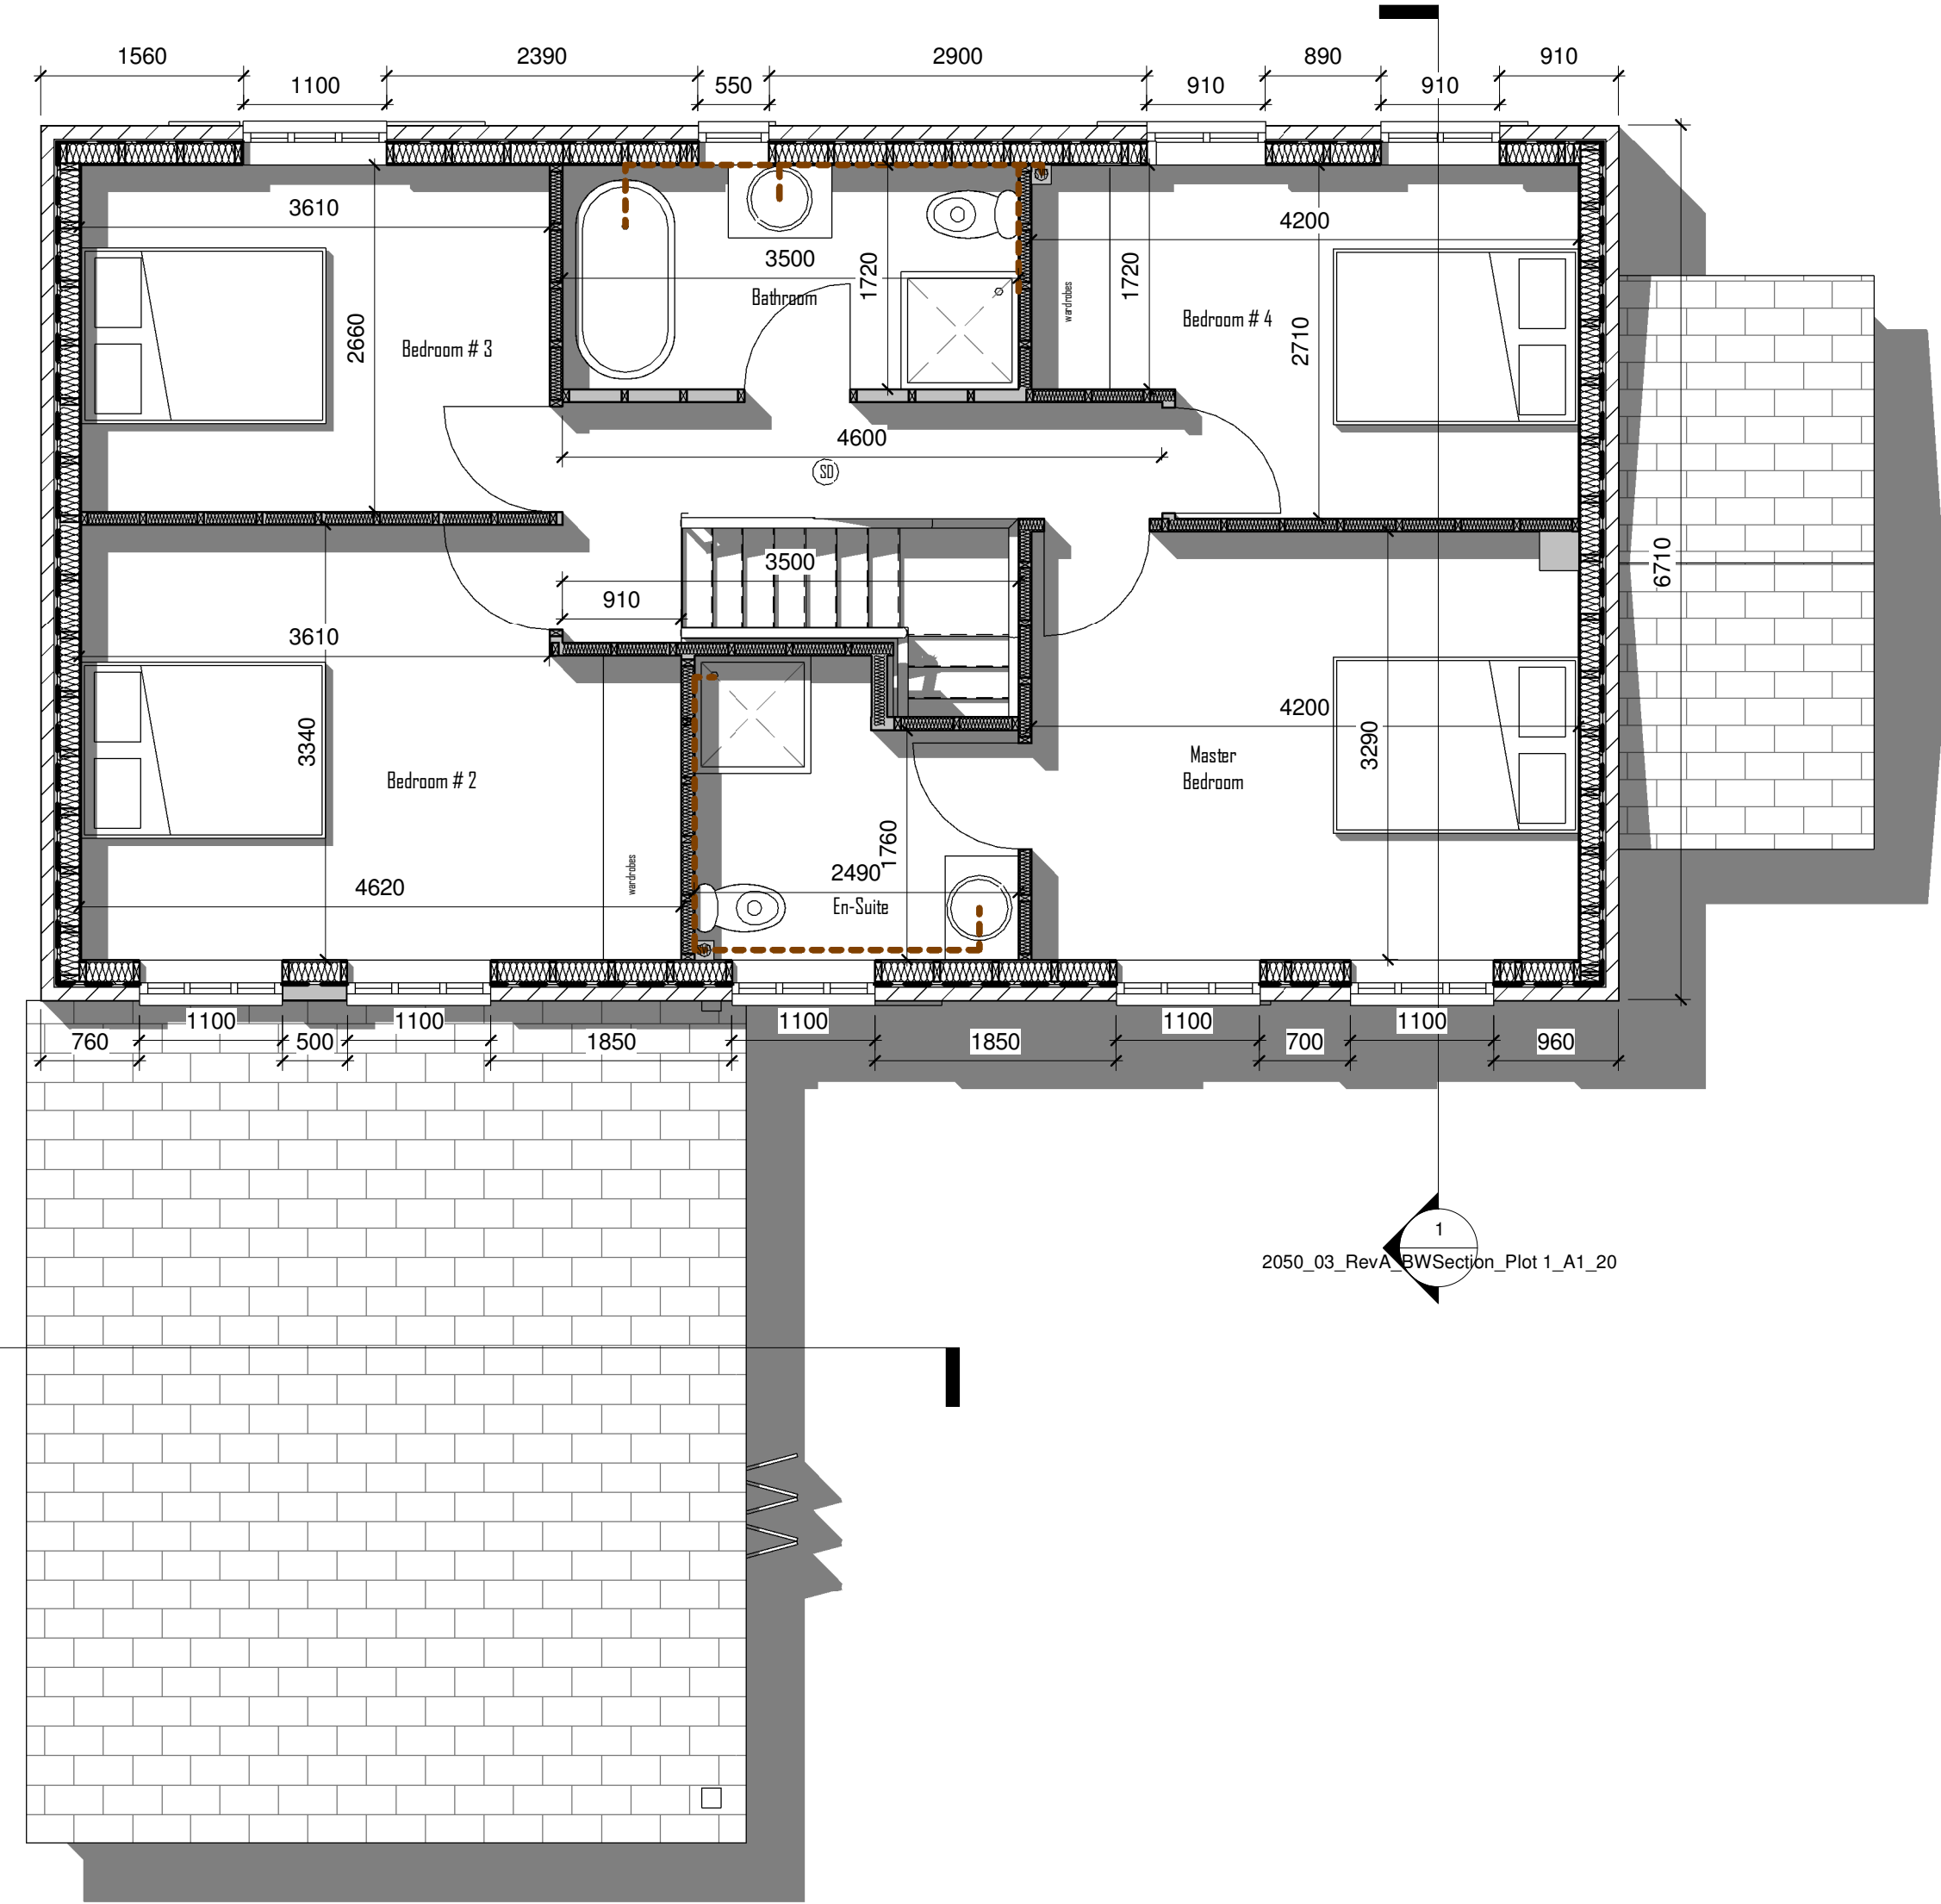

2050_03_RevA_BWSection_Plot 1_A1_20

Key	
Gutter Downpipe	DP
Smoke Detector	SD
Inspection Chamber	IC
Foul Drainage	---
Surface Drainage	---
Soil Vent Pipe	SVP
Heat Detector	HD

RevA (28/10/2020):
Amendments Following Building
Control Comments



Client Mr Steven Newton
Job Poplar Farm
Greenfield Road
Dorchester, DT2 0PA

Drawing Title
Floor Plans Builders Works

Sheet Size/Scale 1:50 R/A
Drawn By Samuel Thompson
Date 28/10/2020
Drawing Status Building Control
Drawing No. 2050_04_RevA_BWPlans_Plot 2_M_20