
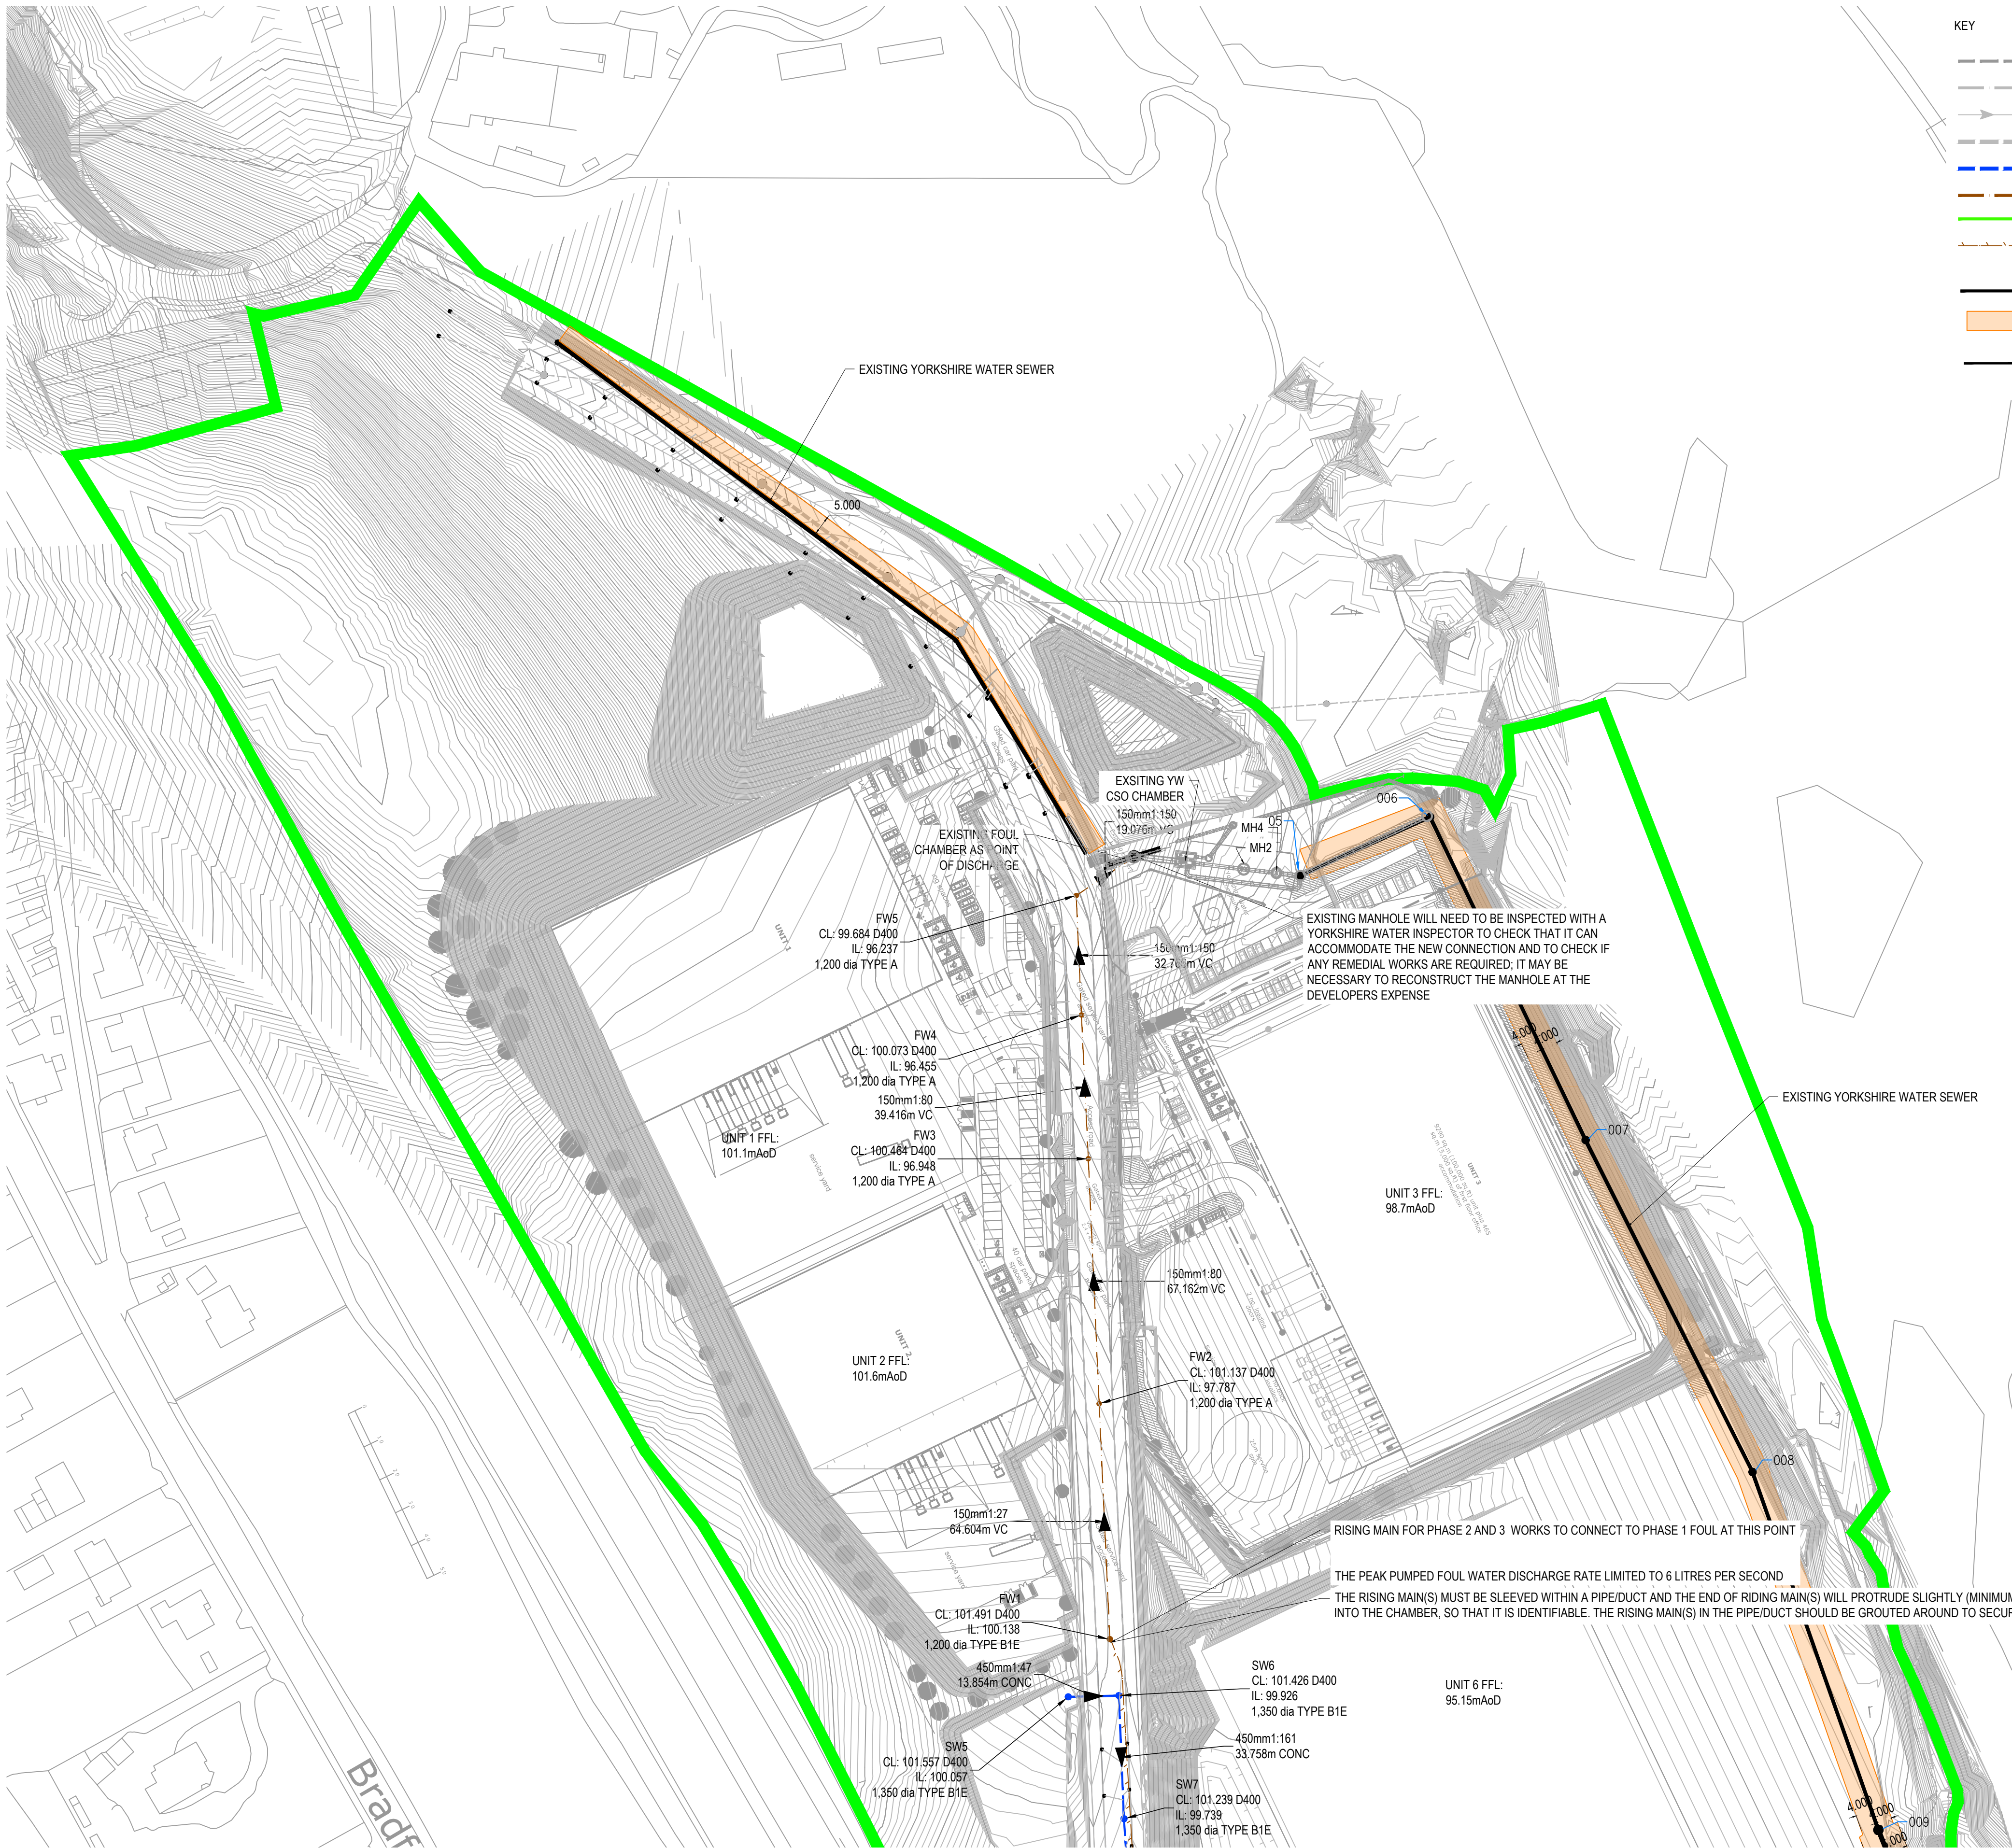


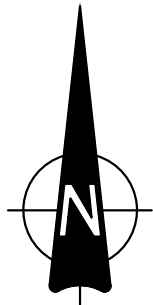

- KEY
- PROPOSED PRIVATE SURFACE WATER DRAIN
 - PROPOSED PRIVATE FOUL WATER DRAIN
 - EXISTING FOUL WATER SEWER
 - PROPOSED HIGHWAY SEWER
 - PROPOSED ADOPTABLE SURFACE WATER SEWER
 - PROPOSED ADOPTABLE FOUL WATER SEWER
 - SITE OWNERSHIP BOUNDARY
 - PROPOSED ADOPTABLE FOUL WATER RISING MAIN
 - EXISTING YORKSHIRE WATER SEWER
 - EXISTING YORKSHIRE WATER SEWER EASEMENT
 - PROPOSED WATERCOURSE DIVERSION (PRIVATE)

GENERAL NOTES:

- YORKSHIRE WATER NOTES
- ALL ADOPTABLE SEWER WORKS AND MATERIAL TO BE IN ACCORDANCE WITH 'CODE FOR ADOPTION', THE RELEVANT BRITISH/EUROPEAN AND YORKSHIRE WATERS' STANDARDS/REQUIREMENTS/ADDENDUM TO THE MECHANICAL AND ELECTRICAL SPECIFICATION AND KITEMARKED
 - MANHOLE COVERS SHALL MUST HAVE A CLEAR OPENING OF 600mm AND SHALL BE CLASS D400 TO BS EN 124 WITH 150mm DEEP FRAMES IN HIGHWAYS.
 - FILLED GROUND MUST BE FILLED AND CONSOLIDATED UNDER THE SUPERVISION AND TO THE SATISFACTION OF YORKSHIRE WATER BEFORE ANY SEWER WORKS ARE CARRIED OUT.
 - YORKSHIRE WATER IS NOT OBLIGED TO ACCEPT FILTER DRAIN/LAND DRAINAGE RUN-OFF INTO THE PUBLIC SEWER NETWORK OR ADOPTABLE DRAINAGE SYSTEM (DIRECTLY OR IN-DIRECTLY). AN ALTERNATIVE METHOD OF DISPOSAL OF THE LAND DRAINAGE RUN-OFF WILL THEREFORE BE REQUIRED AND YOU WILL HAVE TO UNISE WITH THE LOCAL AUTHORITY. LAND DRAINAGE SECTION WITH REGARDS TO THE DISPOSAL OF FILTER DRAIN/LAND DRAIN RUN-OFF.
 - COVER SLABS MUST CARRY THE BSI KITEMARK OR WILL BE REJECTED BY YORKSHIRE WATER INSPECTOR. WHERE THE CLEAR OPENING OF THE KITEMARKED PRODUCT IS DIFFERENT TO THAT OF THE COVER AND FRAME, A LOAD BEARING SLAB SHOULD BE FITTED ABOVE THE COVER SLAB TO BRING THE SIZE DOWN TO 600x600mm, FOR THE YORKSHIRE WATER SPECIFIED COVER SIZE. PLEASE REFER TO CONCRETE PIPE SYSTEMS ASSOCIATION (CPSA), 'TECHNICAL BULLETIN' ISSUED AUTUMN 2004 FOR KITEMARKED COVER SLAB OPENING SIZES.
 - SULPHATE RESISTANT CEMENT (C20-DC2) AND PRECAST CONCRETE PRODUCTS MUST BE USED OR A LABORATORY REPORT PROVIDED PROVING THAT SUCH PRECAUTIONS ARE NOT NECESSARY.
 - THE ADOPTABLE SEWERS SHOULD BE A MINIMUM OF 1m AND MANHOLES 0.5m FROM KERB FACES AND SERVICE MARGINS.
 - SEWERS MUST HAVE 5 METRES CLEARANCE FROM TREES AND HEDGES (PLEASE ALSO REFER TO FIGURE 2.3 ON PAGE 33 IN 'SEWERS FOR ADOPTION' 6TH EDITION FOR RESTRICTIONS ON TREE PLANTING ADJACENT TO SEWERS)
 - SEWERS TO BE LAID IN CLASS 'S' BEDDING (150mm GRANULAR BED AND SURROUND), WHERE DEPTH OF COVER TO TOP OF THE SEWER IS LESS THAN 1.2m IN HIGHWAYS AND VERGES (OR LESS THAN 900mm IN NON-VEHICULAR ACCESS AREAS) THEN A CONCRETE SLAB SHOULD BE PROVIDED ABOVE GRANULAR BED AND SURROUND.
 - BEDDING AND BACKFILL TO CONFORM TO THE REQUIREMENT OF THE WATER INDUSTRY SPECIFICATION 4-08-02 (TABLE A2)
 - THE CHAMBER SIZE OF MANHOLES WITH MORE THAN ONE CONNECTION IN THEM MAY NEED TO BE INCREASED AN INCREMENT TO ACCOMMODATE THE CONNECTIONS AND BENDS.
 - YORKSHIRE WATER POLICY IS NOT TO ACCEPT TYPE 'C' BRICK MANHOLES AND 1050mm DIA MANHOLE RINGS. INSTEAD IT IS PREFERRED THAT YOU USE A TYPE 'B' MANHOLE WITH 1200mm DIA OR 1500mm DIA RINGS, WITH OPENING SITED OVER THE CHANNEL WHERE DEPTH OF COVER TO PIPE SOFFIT IS 1 - 1.5m.
 - SEWERS MUST HAVE 5 METRES CLEARANCE FROM TREES AND HEDGES OR WIDTH OF CANOPY A MATURE HEIGHT
 - THERE SHOULD BE ENOUGH CLEARANCE TO ACCOMMODATE THE BEDDING FOR BOTH PIPE, APPROX 300mm; IF CROSSOVER IS NEAR THE ROCKER THEN THE CLEARANCE MAY BE INCREASED.
 - ADOPTABLE PLASTIC SEWER PIPES TO BE BSI KITEMARKED (CERTIFIED TO WIS 4-35-01 AND BS / EN13476). ADOPTABLE PLASTIC SEWER PIPES TO BE LAID IN MAXIMUM 3 METRE LENGTHS UNLESS THERE IS A SPECIFIC OPERATIONAL NEED TO LAY LONGER LENGTHS. PLASTIC CHANNEL SECTIONS IN MANHOLES ARE NOT ACCEPTABLE AND YORKSHIRE WATER WOULD PREFER CLAYWARE CHANNEL IN MANHOLES. WE HAVE FOUND THAT PLASTIC CHANNELS ARE DIFFICULT TO SET IN CONCRETE BECAUSE THEY FLOAT AND A SATISFACTORY FINISH CANNOT BE OBTAINED ON THE BENCHING.
 - THE MINIMUM CRUSHING STRENGTH FOR CLAY PIPES SHOULD BE AS FOLLOWS: 100mm DIA 40KN/m, 150mm DIA 40KN/m, 225mm DIA 45 KN/m AND 300mm DIA 72KN/m. THE MINIMUM CRUSHING STRENGTH FOR CONCRETE PIPES SHOULD BE - (CLASS 120 TO EN 1916/BS5911-1 2002); PLASTIC PIPES SHOULD CONFORM TO WIS 4-35-01 AND BS EN13476.
 - WHERE A B125 COVER AND FRAME HAS BEEN APPROVED, THIS MUST NOT BE COATED IN PLASTIC AND MUST HAVE LIFTING EYES SUITABLY SIZED TO ACCOMMODATE STANDARD LIFTING KEYS. SCREW DOWN COVERS ARE NOT ACCEPTABLE.

P05	REVISED TO YW COMMENTS	14/03/22	EF	ACS
P04	REVISED TO SUIT YW COMMENTS	26/01/22	EF	ACS
P03	REVISED TO SUIT HIGHWAYS REQUIREMENTS	13/03/21	OT	OT
P02	REVISED TO SUIT HIGHWAYS UPDATES	23/10/21	OT	OT
P01	FIRST ISSUE	13/03/21	OT	NT
Rev:	Description:	Date:	By:	Chkd:



Rose Wharf Ground Floor, 78-80 East Street, Leeds, LS9 8EE
0113 274 8559
leeds@curtins.com
www.curtins.com

Civils & Structures • Transport Planning • Environmental • Infrastructure • Geotechnical • Conservation & Heritage • Principal Designer
Birmingham • Bristol • Cambridge • Cardiff • Douglas • Dublin • Edinburgh • Glasgow • Kentish • Leeds • Liverpool • London • Manchester • Nottingham

Status: **SUITABLE FOR INFORMATION** **S2**

Project: **INTERCHANGE 26**

Orig Title: **S104 DRAINAGE LAYOUT NORTH**

Size:	Date:	Drawn By:	Designed By:	Checked By:
A1	13/03/21	OT	OT	OT
Scale:	1:1000			

Project No:	Originator:	Volume:	Level:	Type:	Role:	Category / Number:	Rev:
065646 - CUR - 00 - ZZ - DR - C -						92501 - P05	