


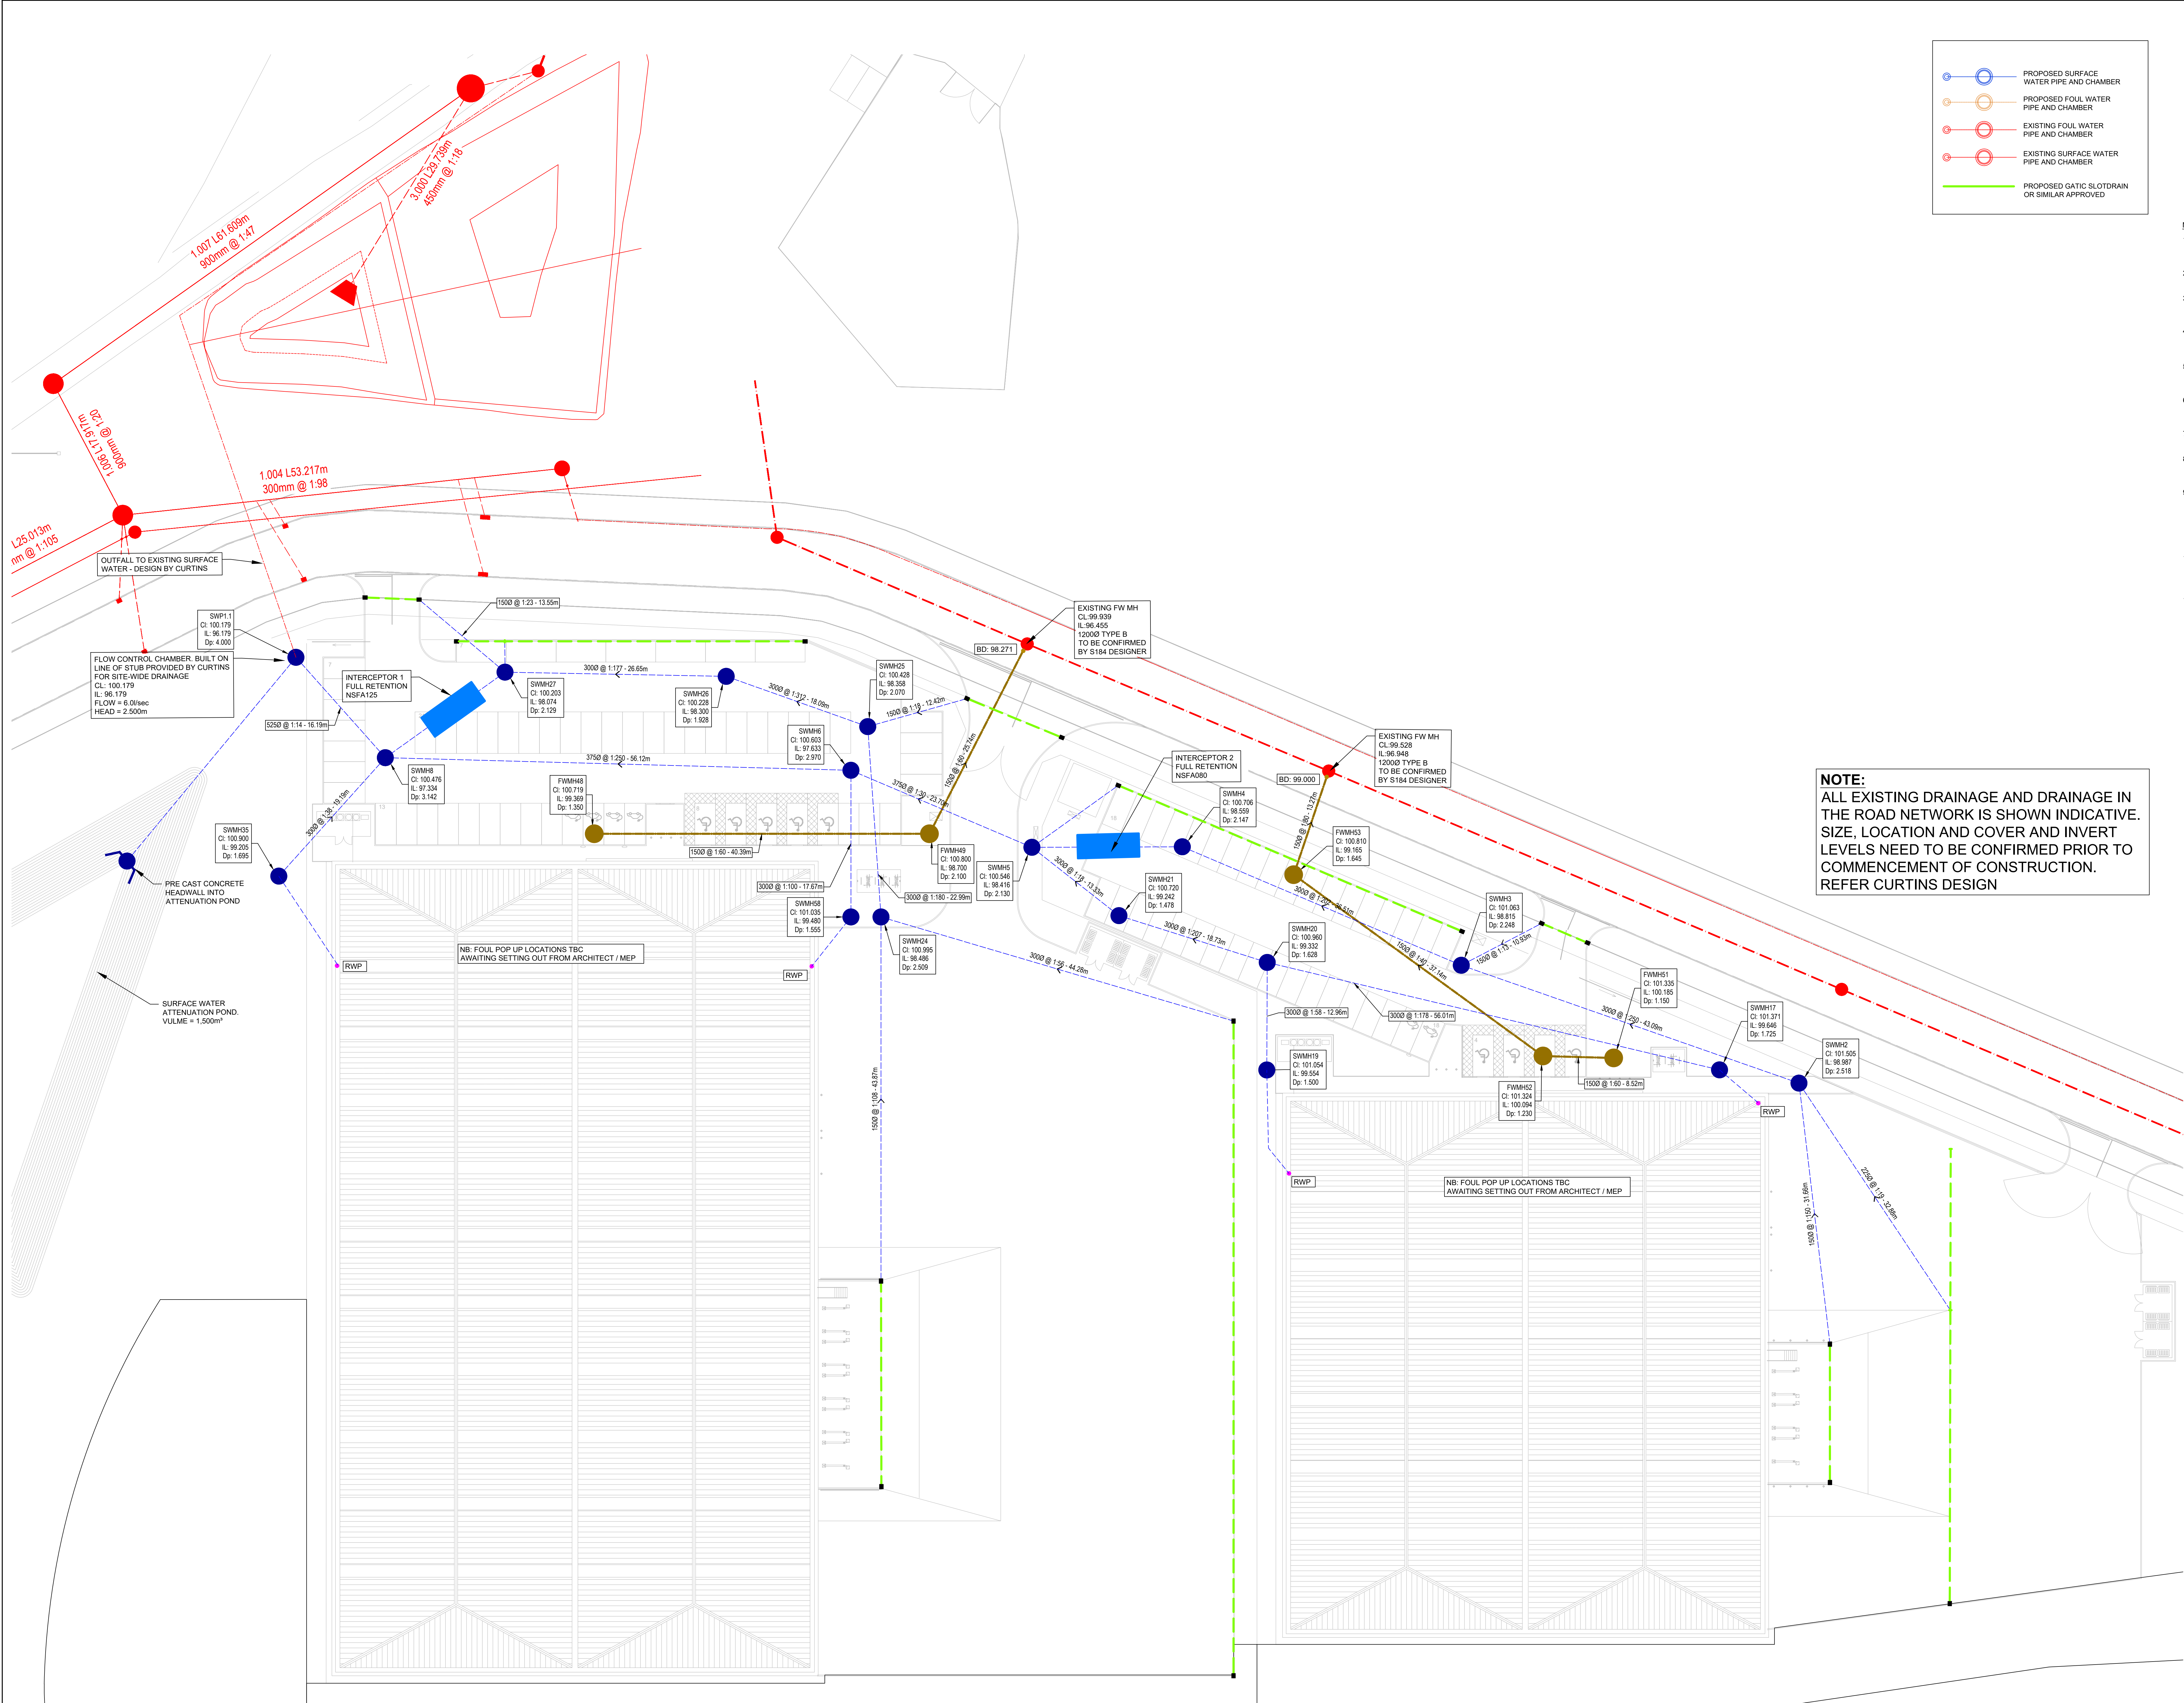


DESIGNER RISK INFORMATION
IN ADDITION TO THE HAZARDS/RISKS NORMALLY ASSOCIATED WITH THE TYPES OF WORK DETAILED ON THIS DRAWING, NOTE THE FOLLOWING:-
CONSTRUCTION:
MAINTENANCE/CLEANING:
DECOMMISSIONING/DEMOLITION:
IT IS ASSUMED THAT ALL WORKS WILL BE CARRIED OUT BY A COMPETENT CONTRACTOR WORKING, WHERE APPROPRIATE, TO AN APPROVED METHOD STATEMENT.

- MUM DRAINAGE NOTES
- REFER TO MUM CONSULTING ENGINEERS DRAWING No. L004-MUM-00-00-DR-C-5240 FOR ALL STANDARD DRAINAGE DETAILS.
 - ALL VITRIFIED CLAY PIPES AND FITTINGS TO BE IN ACCORDANCE WITH BS EN205 & BS 65.
 - ALL CIRCULAR CONCRETE PIPES IN TRENCHES AND FITTINGS TO BE IN ACCORDANCE WITH BS EN1916 & BS 5911 AND BE STRENGTH CLASS 120.
 - ALL STRUCTURED WALL PLASTIC PIPES AND FITTINGS TO BE IN ACCORDANCE WITH WIS 4-35-01. MAXIMUM LENGTH OF PIPE FOR LAYING IS 3m.
 - PIPES AND FITTINGS ARE TO BE INSTALLED IN ACCORDANCE WITH MANUFACTURERS RECOMMENDATIONS.
 - ALL CONNECTIONS TO GULLIES & DRAINAGE CHANNELS TO BE 1500 UNLESS NOTED OTHERWISE.
 - ALL CONNECTIONS FROM DRAINAGE CHANNELS TO BE TRAPPED AND RODABLE.
 - COVER LEVELS INDICATED IN MANHOLE SCHEDULES ARE APPROXIMATE AND SHOULD BE CHECKED AGAINST ARCHITECTS DRAWINGS.
 - WHERE THE COVER TO PIPES IS LESS THAN 1200mm IN TRAFFICKED AREAS & 900mm IN OTHER AREAS, THEN CONCRETE PROTECTION IS TO BE PROVIDED. NB UNTIL FINAL SURFACE IS CONSTRUCTED, HEAVY TRAFFIC IS NOT TO BE ALLOWED OVER PIPE TRENCHES WITHOUT SPECIFIC PROTECTION MEASURES IN PLACE.
 - SOFT SPOTS IN THE BOTTOM OF TRENCHES SHALL BE REMOVED AND BACKFILLED WITH TYPE 1 SUB-MATERIAL, PIPE BEDDING MATERIAL OR LEAN MIX CONCRETE.
 - ALL CONCRETE WORK IS TO BE IN ACCORDANCE WITH MUM CONSULTING ENGINEERS NBS-SECTION E.
 - JUST PRIOR TO PRACTICAL COMPLETION OF THE PROJECT A CCTV SURVEY OF THE COMPLETE PIPE NETWORK SHALL BE CARRIED OUT, WITH A COPY BEING SENT TO THE ENGINEER.

NOTE:
ALL EXISTING DRAINAGE AND DRAINAGE IN THE ROAD NETWORK IS SHOWN INDICATIVE. SIZE, LOCATION AND COVER AND INVERT LEVELS NEED TO BE CONFIRMED PRIOR TO COMMENCEMENT OF CONSTRUCTION. REFER CURTINS DESIGN

03	17.03.22	AMENDED TO SUIT COMMENTS / SYNCHONIS	JE	TM
02	06.03.22	AMENDED TO SUIT CURTINS OUTFALL	JE	TM
01	06.03.22	CONSTRUCTION ISSUE	JE	TM
00	04.03.22	FIRST ISSUE	JE	TM
Rev/	Date	Amendment		

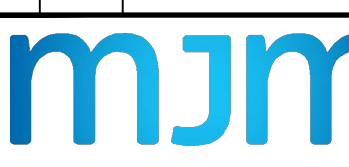

Consulting
Engineers^{ltd}

Southgate House, 35 Southgate, Wakefield WF1 3TL
T: 01924 811 000 mjm.co.uk

Project:
**INTERCHANGE 26 CLECKHEATON
PHASE 2**

Client:
GMI CONSTRUCTION

Drawing Title:
PROPOSED DRAINAGE LAYOUT

JE	TM	TM	
MIMC Ref: 7891	Scale: 1:250	Sheet Size: A0	
Revision Status: C03	Suitability Status: A	Date: FEB '22	
Sustainability Description: FOR CONSTRUCTION			

Drawing Reference:
Project - Originator - Zone - Level - File Type - Discipline - Number
L004-MJM-XX-XX-DR-D-5220

© THIS DRAWING DATA NOT BE COPIED WITHOUT PRIOR WRITTEN PERMISSION