



LEGEND		CC	CONCRETE COVER	FWS	FOUL WATER SEWER	LP	LAMP POST	ST	STOP TAP
AV	AIR VALVE	CM	CABLE MARKER	G	GULLY	MC	METAL COVER <td>SV</td> <td>STOP VALVE</td>	SV	STOP VALVE
B	BOLLARD	CP	CATCH PIT	GV	GAS VALVE	MH	MANHOLE	SWS	SURFACE WATER SEWER
BH	BOREHOLE	CTV	CABLE TV LC	HV	HIGH VOLTAGE	MV	MEDIUM VOLTAGE	TL	TRAFFIC LIGHTS
BS	BUS STOP	DP	DOWN PIPE	IC	INSPECTION COVER	P	POST / POLE	TP	TELEGRAPH POLE
BT	BRITISH TELECOM	ECP	ELEC. CABLE PIT	JB	JUNCTION BOX	RE	RODDING EYE	TH	THRESHOLD
		EP	ELEC. POLE/PYLON	KW	KERB WEIR	RS	ROAD SIGN	VP	VENT PIPE
		ER	EARTH ROD	LB	LITTER BIN	S	STAY	WM	WATER METER
		FH	FIRE HYDRANT	LH	LAMP HOLE	SC	STOP COCK	WO	WASH OUT

Copyright exist on the designs and information shown on this drawing. No part of this drawing can be reproduced without written confirmation of Heppenstalls. This drawing should only be used for the purpose was issued for and should not be used for construction unless it is marked for construction. Heppenstalls must be notified should any discrepancies be found.


Revision

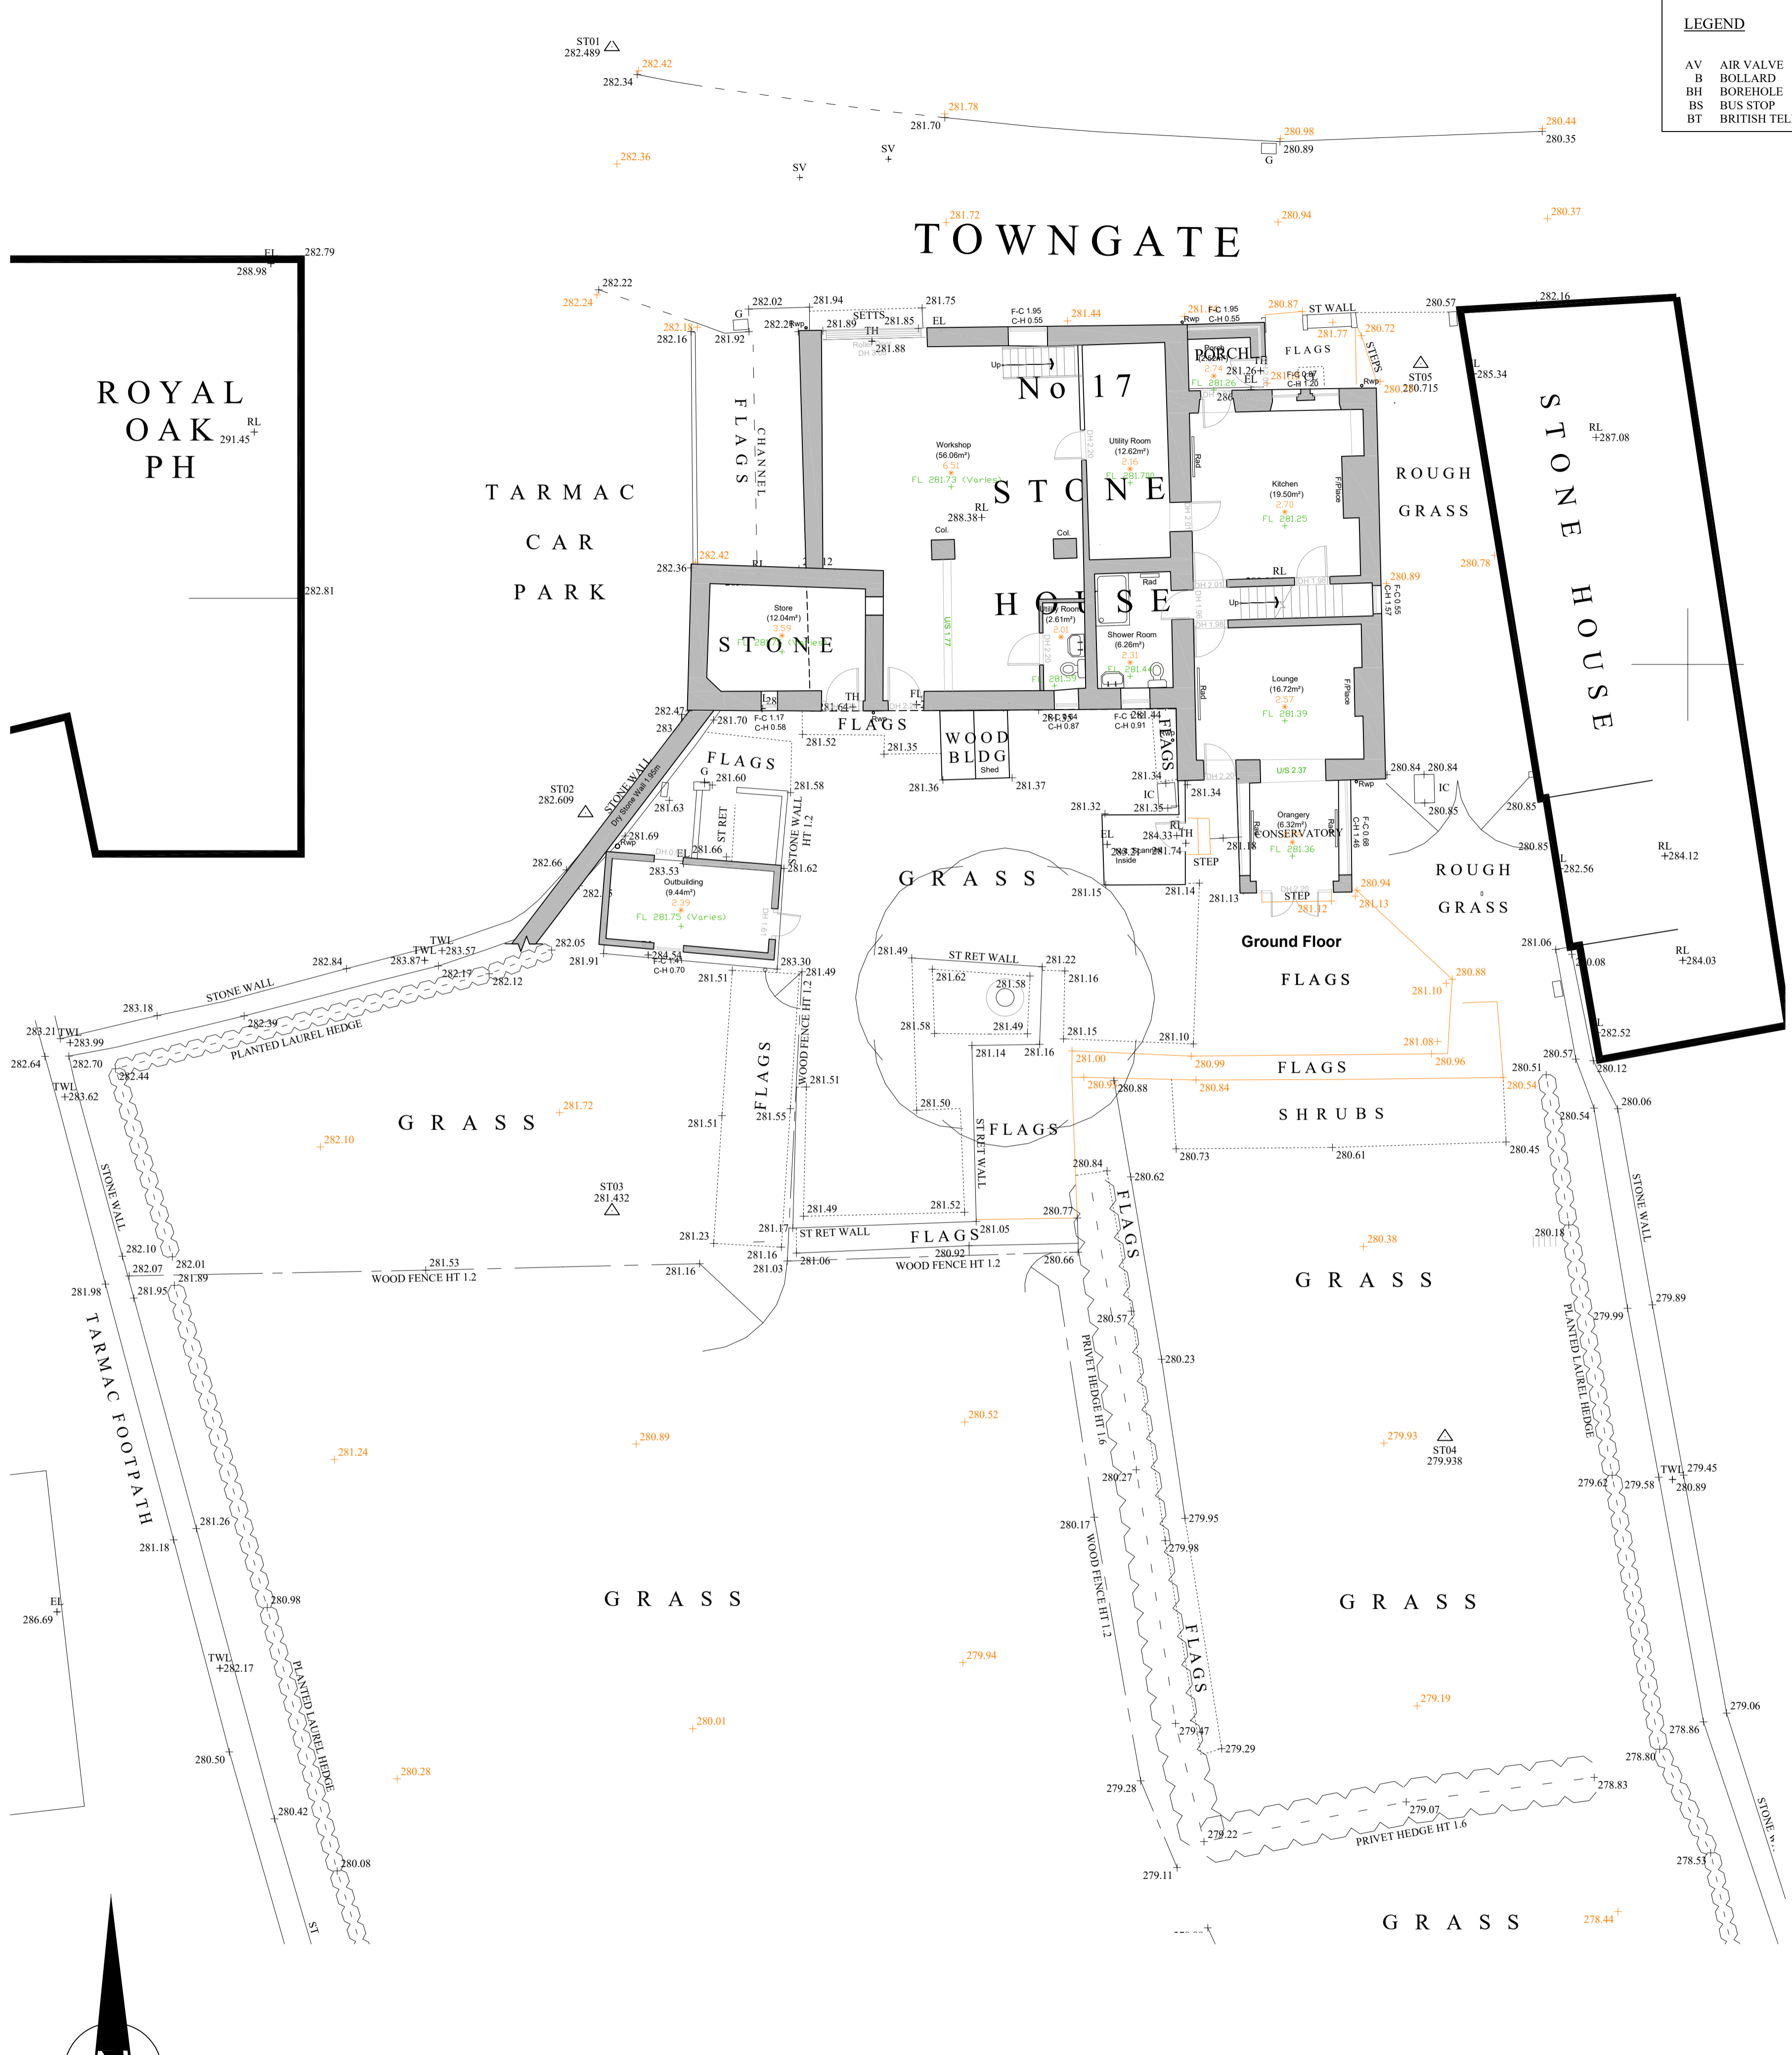


First Floor

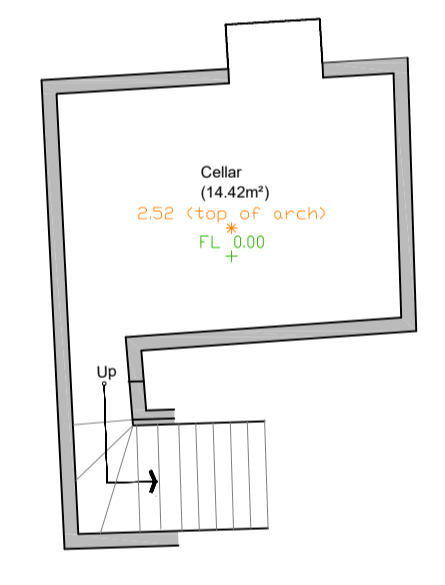


Basement Floor

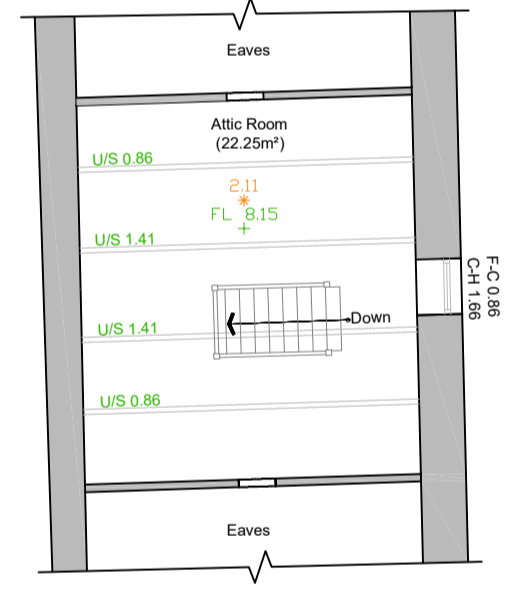

Second Floor

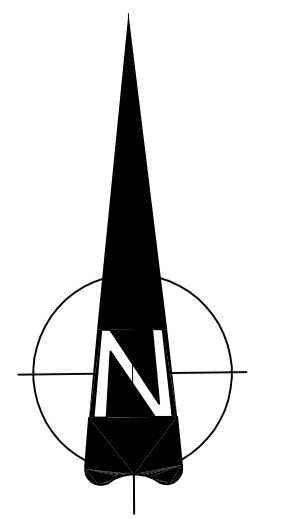

Existing Layout

 

Based on Architectural and Heritage Scanning drawing no.21-XX-001 and Ellam Land Surveys drawing no.8405_2D/1

Client
Mr & Mrs T.Fleming
Project
17 Towngate, Uppershong

Drawing
Existing Site Plan

Number
4416-01-04
Date
06/2022
Scale @ A1
As Marked

HEPPENSTALLS
Chartered Architects & Surveyors

Architecture
Surveying
Planning
Project Management
RIBA RICS
Allisons buildings, 135 Armitage Road Milsbridge,
Huddersfield, HD3 4JY tel 01484 658411
projects@heppenstalls.net www.heppenstalls.net

Planning Application