

THIS DRAWING IS TO BE READ IN CONJUNCTION WITH ALL RELEVANT SPECIFICATIONS AND DRAWINGS ISSUED. FOR DISCREPANCIES OR OMISSIONS CONTACT MOBILE CAD SURVEYING SOLUTIONS LTD PRIOR TO WORK COMMENCING. THE CONTRACTOR IS TO CHECK AND VERIFY ALL BUILDING AND SITE DIMENSIONS AND LEVELS BEFORE WORK COMMENCES.


© COPYRIGHT MOBILE CAD SURVEYING SOLUTIONS LTD 2022

DO NOT SCALE THIS DRAWING - CHECK ALL DIMENSIONS ON SITE

Note:
Areas drawn indicatively noted and indicated by grey dashed line as line below



LEVEL DATUM & ORIENTATION



LEVELS & DRAWING ORIENTATION CO-ORDINATED TO WORLD CO-ORDINATES USING GPS EQUIPMENT (SPECTRA S90). PERMANENT STATIONS LOCATED IN POSITIONS INDICATED ON PLAN AS FOLLOWS:


STN ABA2	E-414390.582	N-416896.974	HT - 87.200m
STN ABA1	E-414377.246	N-416927.042	HT - 88.550m
STN ABA3	E-414394.153	N-416926.966	HT - 87.900m
STN SG3	E-414385.254	N-416948.279	HT - 88.919m

ABBREVIATIONS & LEGEND:

LEVELS & HEIGHTS	SERVICES	DRAINAGE	TYPICAL DRAWING SYMBOLS
CL - COVER LEVEL	BT - BRITISH TELECOMS	DC - DRAINAGE CHANNEL	SPOT LEVEL
IL - INVERT LEVEL	CATV - CABLE TELEVISION	G - GILLY	SPOT HEIGHT
L - LEVEL	ER - EARTHING ROD	IC - INSPECTION CHAMBER	STN 01
HT - HEIGHT	ES - ELECTRICAL SUPPLY	IC - INSPECTION CHAMBER	STN 02
STN - SURVEY STATION	FH - FIRE HYDRANT	RE - ROODING EYE	STN 03
BM - BEAM	GAS - GAS SUPPLY	RWP - RAIN WATER PIPE	STN 04
CE - CEILING	PO - POST OFFICE TELEPHONE	U - UNABLE TO LIFT	STN 05
J - JOISTS	SV - STOP VALVE	S&V - SOL & VENT PIPE	STN 06
RA - RAFTERS	TSSU - TRAFFIC LIGHT SIGNALS	ST - STOP TAP	STN 07
E - EAVES		WM - WATER METER	STN 08
F - FENCE			STN 09
UIS - UNDERSIDE OF			STN 10
RL - ROOF LINE			STN 11
FR - FLAT ROOF			STN 12
HL - HIP LINE			STN 13
VL - VALLEY LINE			STN 14
PW - PARAPET WALL			STN 15
SL - SLAB			STN 16
SF - SOFFIT			STN 17
T - TREE			STN 18
THR - THRESHOLD			STN 19
To - TOP OF			STN 20
W - WALL			STN 21
HH - HEAD HEIGHT			STN 22
OH - OPENING HEIGHT			STN 23
SH - SILL HEIGHT			STN 24
			STN 25
			STN 26
			STN 27
			STN 100

SITE PLAN
1:500 Scale

REV	DATE	AMENDMENTS
B	26.09.2022	STATIONS REINSTATED
A	21.09.2022	DRAWING LAYWALK AND REVIEW



PROJECT: MEASURED BUILDING SURVEY
ADDRESS: ST. GEORGES HOTEL, HUDDERSFIELD, HD1 1JA

DWG NO.: 3518 - 01
DWG TITLE: SITE PLAN
DWG DATE: JULY 2022
DWG SIZE: SCALE AS SHOWN @ A1

DRAWN: MW CHECKED: JH 856 B

www.mobcad.co.uk | 01977 525 076


THIS DRAWING IS TO BE READ IN CONJUNCTION WITH ALL RELEVANT SPECIFICATIONS AND DRAWINGS ISSUED. FOR DISCREPANCIES OR OMISSIONS CONTACT MOBILE CAD SURVEYING SOLUTIONS LTD PRIOR TO WORK COMMENCING. THE CONTRACTOR IS TO CHECK AND VERIFY ALL BUILDING AND SITE DIMENSIONS AND LEVELS BEFORE WORK COMMENCES.

© COPYRIGHT MOBILE CAD SURVEYING SOLUTIONS LTD 2022

DO NOT SCALE THIS DRAWING - CHECK ALL DIMENSIONS ON SITE

Note:
Areas drawn indicatively noted and indicated by grey dashed line as line below

LEVEL DATUM & ORIENTATION

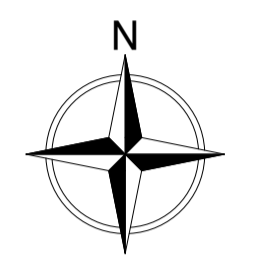

LEVELS & DRAWING ORIENTATION CO-ORDINATED TO WORLD CO-ORDINATES USING GPS EQUIPMENT (SPECTRA S90). PERMANENT STATIONS LOCATED IN POSITIONS INDICATED ON PLAN AS FOLLOWS:


STN ABA2	E-414390.582	N-416896.974	HT - 87.200m
STN ABA1	E-414377.246	N-416927.042	HT - 88.555m
STN ABA3	E-414394.153	N-416926.966	HT - 87.920m
STN SG3	E-414385.254	N-416948.279	HT - 88.919m

ABBREVIATIONS & LEGEND:

LEVELS & HEIGHTS	SERVICES	TOPOGRAPHICAL SYMBOLS
CL - COVER LEVEL	BT - BRITISH TELECOMS	OVERHEAD ELECTRICAL
IL - INVERT LEVEL	CATV - CABLE TELEVISION	OVERHEAD TELEPHONE
L - LEVEL	ER - EARTHING ROD	FENCE LINE
HT - HEIGHT	ES - ELECTRICAL SUPPLY	VEGETATION OUTLINE
STN - SURVEY STATION	FH - FIRE HYDRANT	SINGLE GATE
BM - BEAM	GAS - GAS SUPPLY	DOUBLE GATE
CE - CEILING	PO - POST OFFICE TELEPHONE	TREE
J - JOISTS	SV - STOP VALVE	CONTOURS
RA - RAFTERS	TSSU - TRAFFIC LIGHT SIGNALS	SLOPING DIRECTION LINE
E - EAVES		
F - FENCE		
UIS - UNDERSIDE OF	DC - DRAINAGE CHANNEL	
RL - ROOF LINE	G - GILLY	
FR - FLAT ROOF	IC - INSPECTION CHAMBER	
HL - HIP LINE	MH - MANHOLE	
VL - VALLEY LINE	RE - ROOFING EYE	
FW - PARAPET WALL	RWP - RAIN WATER PIPE	
SL - SLAB	U/L - UNABLE TO LIFT	
SF - SOFFIT	S&V - SOIL & VENT PIPE	
T - TREE	ST - STOP TAP	
THR - THRESHOLD	WM - WATER METER	
To - TOP OF		
W - WALL		
HH - HEAD HEIGHT		
OH - OPENING HEIGHT		
SH - SILL HEIGHT		
GENERAL NOTES		
AB - ADVERTISING BOARD		
AC - AIR CONDITIONING UNIT		
AHU - AIR HANDLING UNIT		
AP - INTRUDER ALARM PANEL		
B - BOLLARD		
BA - BARRIER		
BE - BENCH		
BS - BUS STOP		
BLR - BOILER		
BVO - BOWING OUT		
CAM - CEILING ACCESS HATCH		
CH - CHIMNEY		
CPD - CUPBOARD		
DB - DOG WASTE BIN		
DW - DWAF WALL		
DK - DROP KERB		
EDB - ELECTRICAL DISTRIBUTION BOARD		
EG - EXTRACT GRILLE		
EM - ELECTRIC METER		
FB - FUSE BOX		
FP - FIREPLACE		
FU - FLUE		
FAP - FIRE ALARM PANEL		
GR - GRASS		
GU - GUARDING		
GM - GAS METER		
HWC - HOT WATER CYLINDER		
LB - LITTER BIN		
LP - LAMP POST		
PC - PELICAN CROSSING		
PS - PAVING SLABS		
PL - PAVEMENT LIGHT		
PLT - PLANTING		
PB - POST BOX		
RS - RAILING		
RS - ROAD SIGN		
RFL - ROOF LIGHT		
SB - SPEED BUMP		
SG - SIGNAGE		
SN - STREET NAME SIGN		
SWR - SHOWER		
SHY - SHELVEING		
TB - TELEPHONE BOX		
TL - TRAFFIC LIGHT		
TM - TICKET MACHINE		
TP - TELEGRAPH POLE		
VE - VEGETATION		
WA - WATER		
WD - WARDROBE		
WH - WATER HEATER		
ZC - ZEBRA CROSSING		



THIRD FLOOR PLAN
1:200 Scale

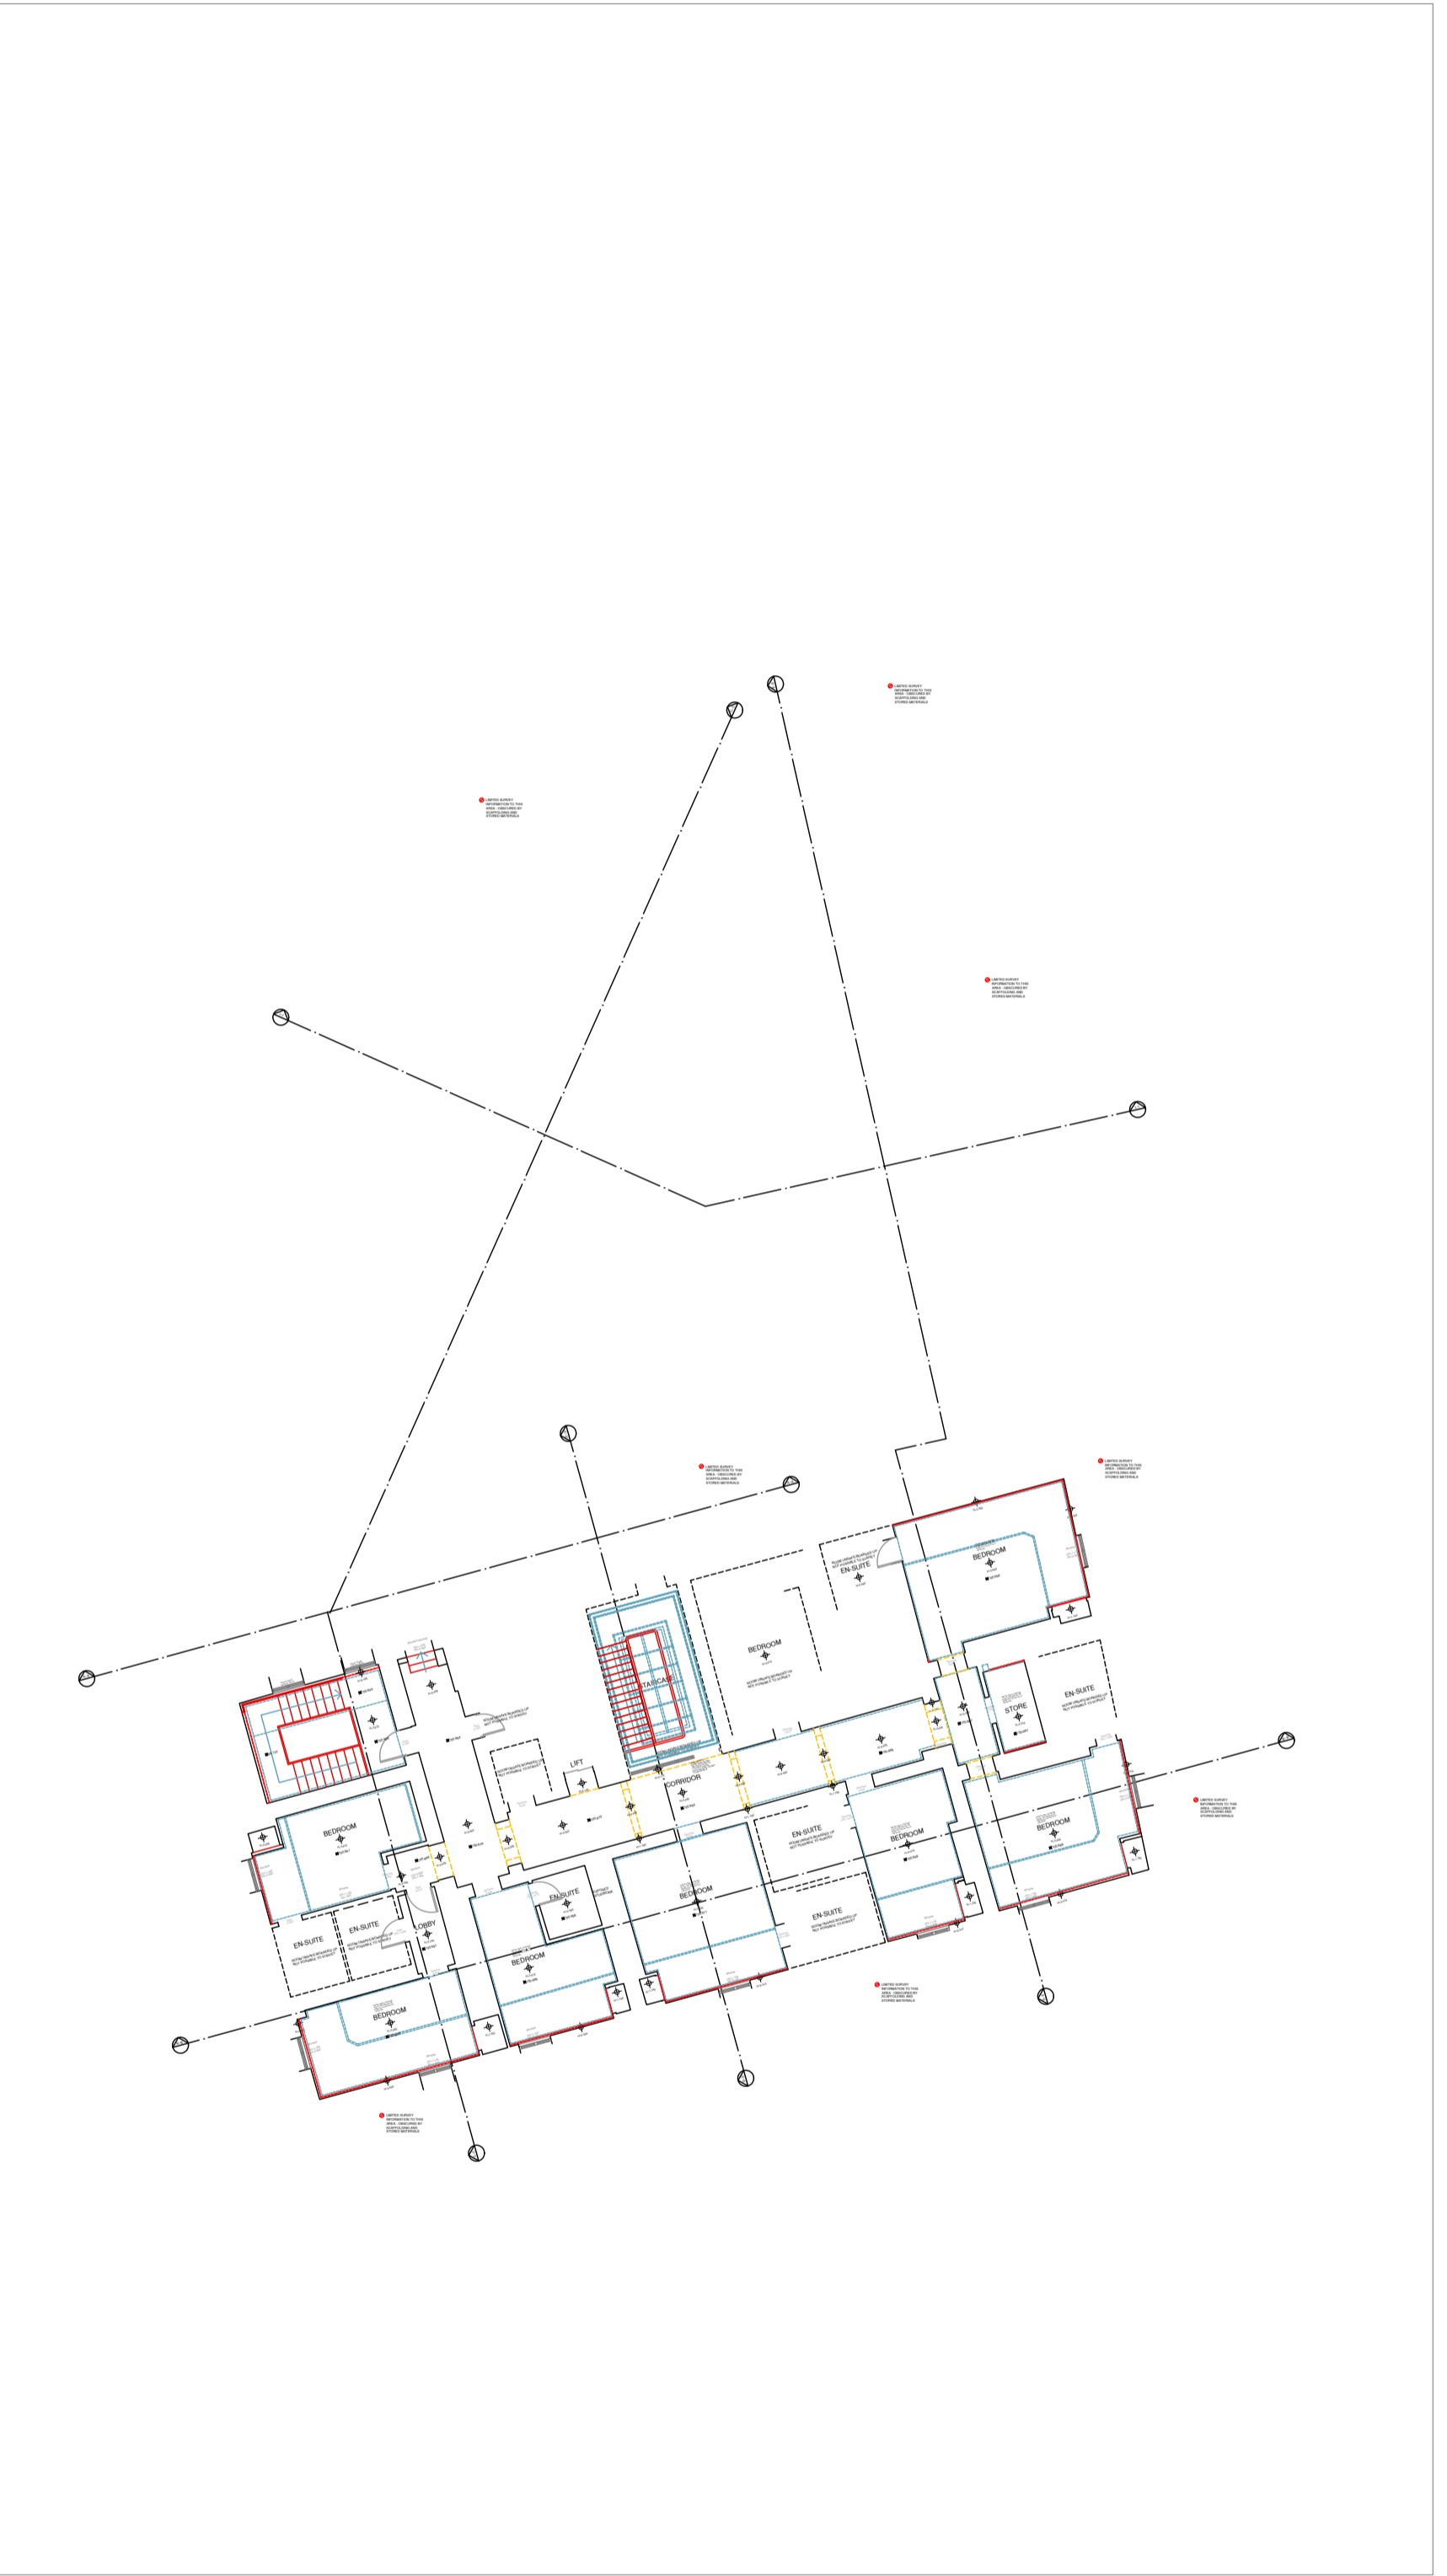

FOURTH FLOOR PLAN
1:200 Scale

REV	DATE	AMENDMENTS
A	21.09	DRAWING LAYWALK AND REVIEW

MOBILE CAD Surveying Solutions

PROJECT: MEASURED BUILDING SURVEY
ADDRESS: ST. GEORGES HOTEL, HUDDERSFIELD, HD1 1JA

DIWG NO.: 3518 - 04
DIWG TITLE: THIRD AND FOURTH FLOOR PLANS
DIWG DATE: JULY 2022
DIWG SIZE: SCALE AS SHOWN @ A1

DRAWN: SC CHECKED: JH 856/A

www.mobcad.co.uk | 01977 525 078





London Office: 132 - 160 City Road, EC2V 2NX

THIS DRAWING IS TO BE READ IN CONJUNCTION WITH ALL RELEVANT SPECIFICATIONS AND DRAWINGS ISSUED. FOR DISCREPANCIES OR OMISSIONS CONTACT MOBILE CAD SURVEYING SOLUTIONS LTD PRIOR TO WORK COMMENCING. THE CONTRACTOR IS TO CHECK AND VERIFY ALL BUILDING AND SITE DIMENSIONS AND LEVELS BEFORE WORK COMMENCES.

© COPYRIGHT MOBILE CAD SURVEYING SOLUTIONS LTD 2022

DO NOT SCALE THIS DRAWING - CHECK ALL DIMENSIONS ON SITE

Note:
Areas drawn indicatively noted and indicated by grey dashed line as line below

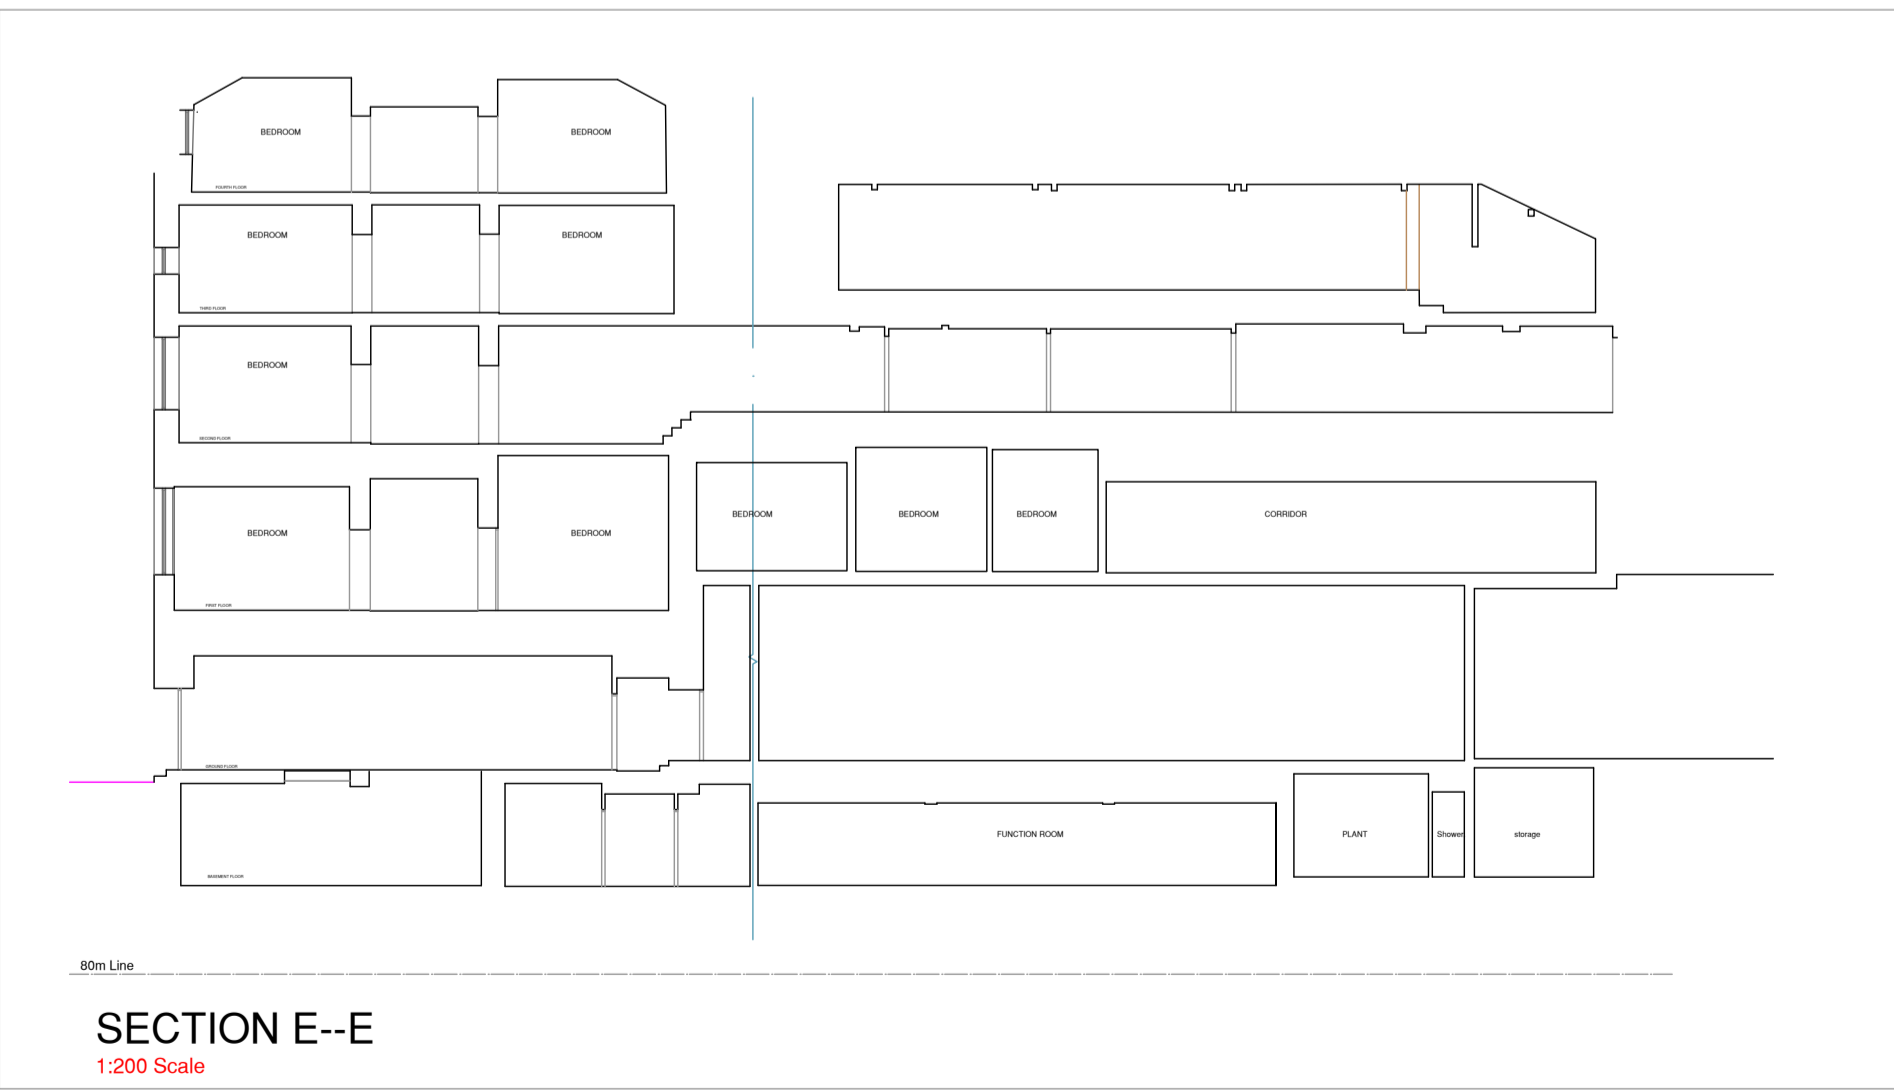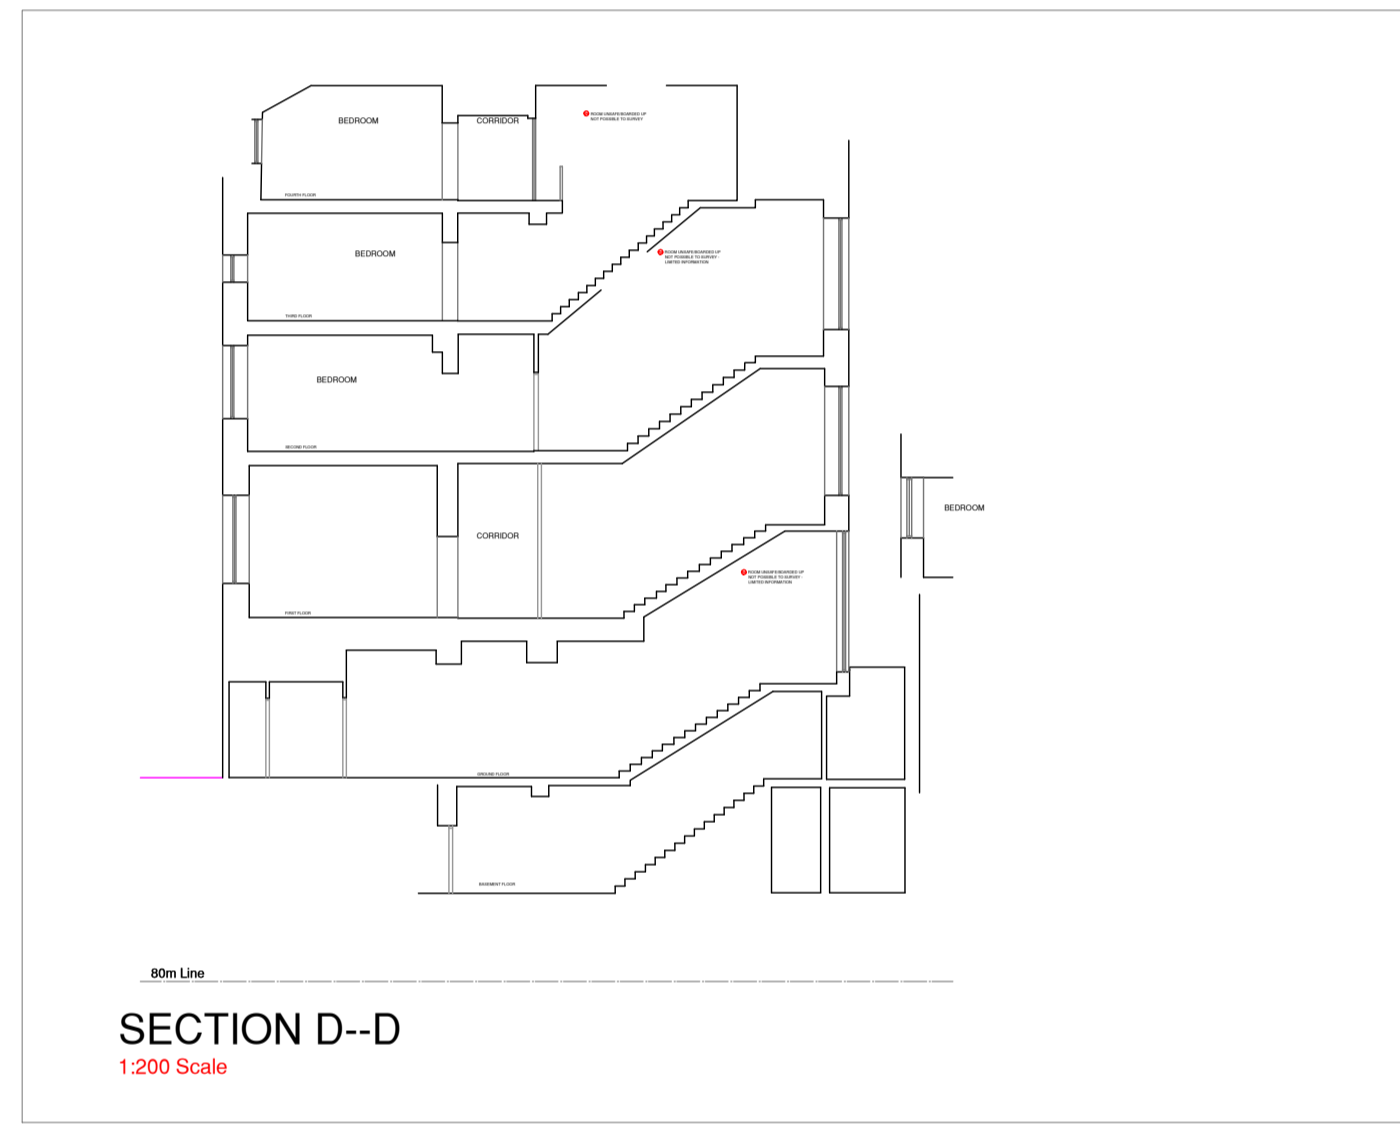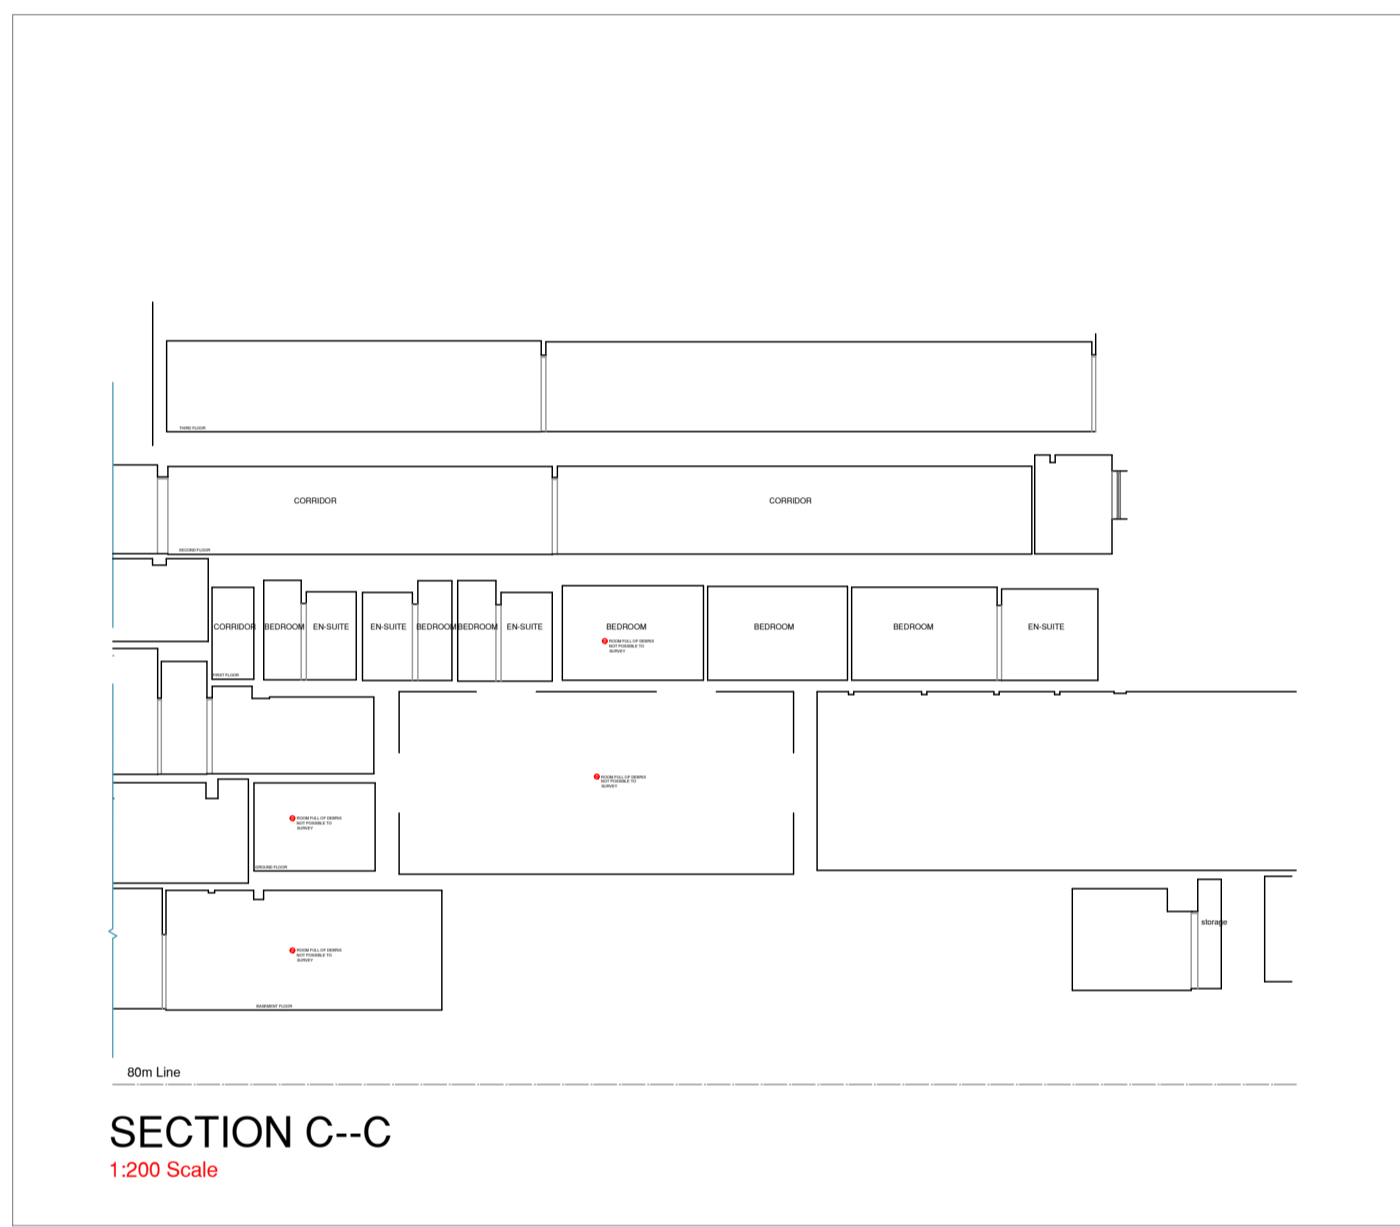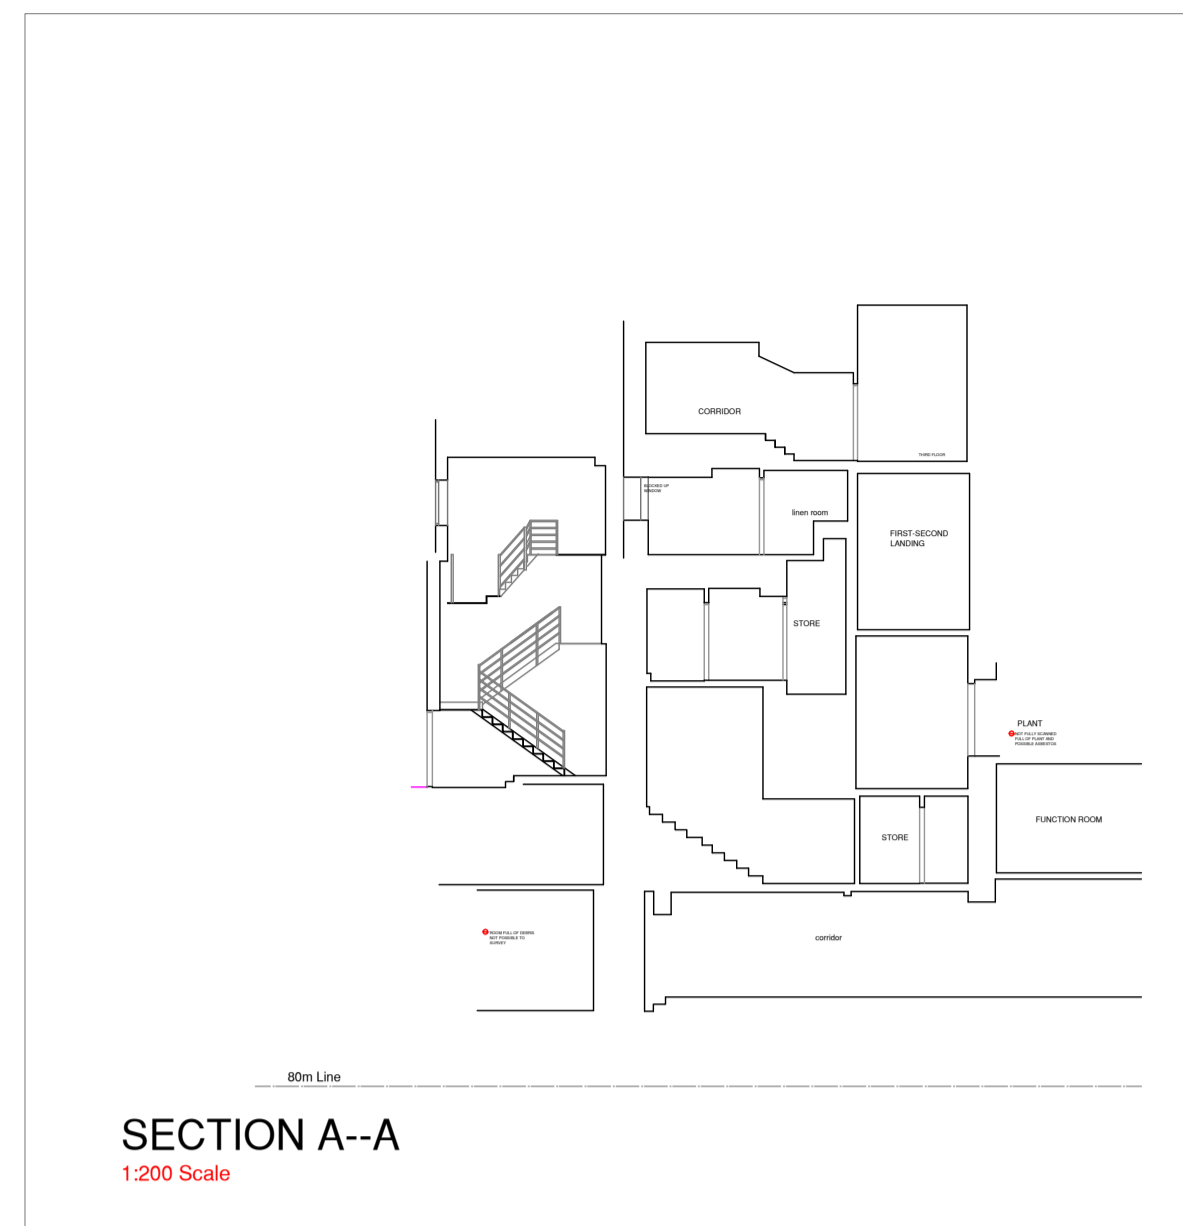

ABBREVIATIONS & LEGEND:	
LEVELS & HEIGHTS	SERVICES
CL - COVER LEVEL	BT - BRITISH TELECOMS
CA - CABLE TELEVISION	CA - CABLE TELEVISION
L - LEVEL	ER - EARTHING ROD
HT - HEIGHT	ES - ELECTRICAL SUPPLY
STN - SURVEY STATION	FH - FIRE HYDRANT
BM - BEAM	GS - GAS SUPPLY
CE - CEILING	PO - POST OFFICE TELEPHONE
J - JOISTS	SV - STOP VALVE
RA - RAFTERS	TSSU - TRAFFIC LIGHT SIGNALS
E - EAVES	
F - FENCE	DRAINAGE
US - UNDERSIDE OF	DC - DRAINAGE CHANNEL
RL - RIDGE LINE	G - GULLY
FR - FLAT ROOF	IC - INSPECTION CHAMBER
HL - HIP LINE	MH - MANHOLE
VL - VALLEY LINE	RE - ROOFING EYE
PW - PARAPET WALL	RWP - RAIN WATER PIPE
SL - SLAB	UTL - UNABLE TO LIFT
SF - SOFFIT	S-V-P - SOIL & VENT PIPE
T - TREE	ST - STOP TAP
THR - THRESHOLD	WM - WATER METER
To - TOP OF	
WH - HEAD HEIGHT	TYPICAL DRAWING SYMBOLS
CH - OPENING HEIGHT	SPOT LEVEL × 96.256
SH - SILL HEIGHT	SPOT HEIGHT × 99.034
GENERAL NOTES	
AB - ADVERTISING BOARD	
AC - AIR CONDITIONING UNIT	
AHU - AIR HANDLING UNIT	
AP - BURGLAR ALARM PANEL	
B - BOLLARD	
BA - BARRIER	
BE - BENCH	
BS - BUS STOP	
BL - BOLLER	
BXD - BOXING OUT	
CAH - CEILING ACCESS HATCH	
CHY - CHIMNEY	
CPD - CLIPBOARD	
DB - DOGS WASTE BIN	
DW - DWARF WALL	
DK - DROP KERB	
EDB - ELECTRICAL DISTRIBUTION BOARD	
EG - EXTRACT GRILLE	
EM - ELECTRIC METER	
FB - FUSE BOX	
FP - FIREPLACE	
FU - FUSE	
FAP - FIRE ALARM PANEL	
GR - GRASS	
GU - GUARDING	
GM - GAS METER	
HWO - HOT WATER CYLINDER	
LB - LITTER BIN	
LP - LAMP POST	
PC - PELICAN CROSSING	
PS - PAVING SLABS	
PL - PAVEMENT LIGHT	
PLT - PLANTING	
PB - POST BOX	
RI - RAILING	
RS - ROAD SIGN	
RFL - ROOF LIGHT	
SB - STREET BUMP	
SG - SIGNAGE	
SN - STREET NAME SIGN	
SWR - SHOWER	
SHV - SHELVE	
TB - TELEPHONE BOX	
TL - TRAFFIC LIGHT	
TM - TICKET MACHINE	
TP - TELEGRAPH POLE	
VE - VEGETATION	
WA - WATER	
WDR - WARDROBE	
WH - WATER HEATER	
ZC - ZEBRA CROSSING	
	MANHOLE / INSPECTION CHAMBER × CL-96.256
	INSPECTION CHAMBER × CL-96.256
	WINDOW TAG
	DOOR TAG
	RADIATOR TAG
	TOP & BOTTOM OF KERB × 34.500
	TOPOGRAPHICAL SYMBOLS
	OVERHEAD ELECTRICAL
	OVERHEAD TELEPHONE
	FENCE LINE
	VEGETATION OUTLINE
	SINGLE GATE
	DOUBLE GATE
	TREE
	CONTOURS 00.000m
	SLOPING DIRECTION LINE

A	21.09	DRAWING LAYWALK AND REVIEW
REV	DATE	AMENDMENTS

MOBILE CAD
Surveying Solutions

PROJECT: MEASURED BUILDING SURVEY
ADDRESS: ST. GEORGES HOTEL,
HUDDERSFIELD,
HD1 1JA

DWG NO.: 3518-05
DWG TITLE: SECTIONS
DWG DATE: JULY 2022
DWG SIZE: SCALE AS SHOWN @ A1
DRAWN: MW CHECKED: JH 856/A

www.mobcad.co.uk
01977 525 076

London Office:
2 Harewood Lane
West Yorkshire
WF3 2JY

London Office:
132 - 140 City Road
London
EC2V 2NX
020 3198 1197