


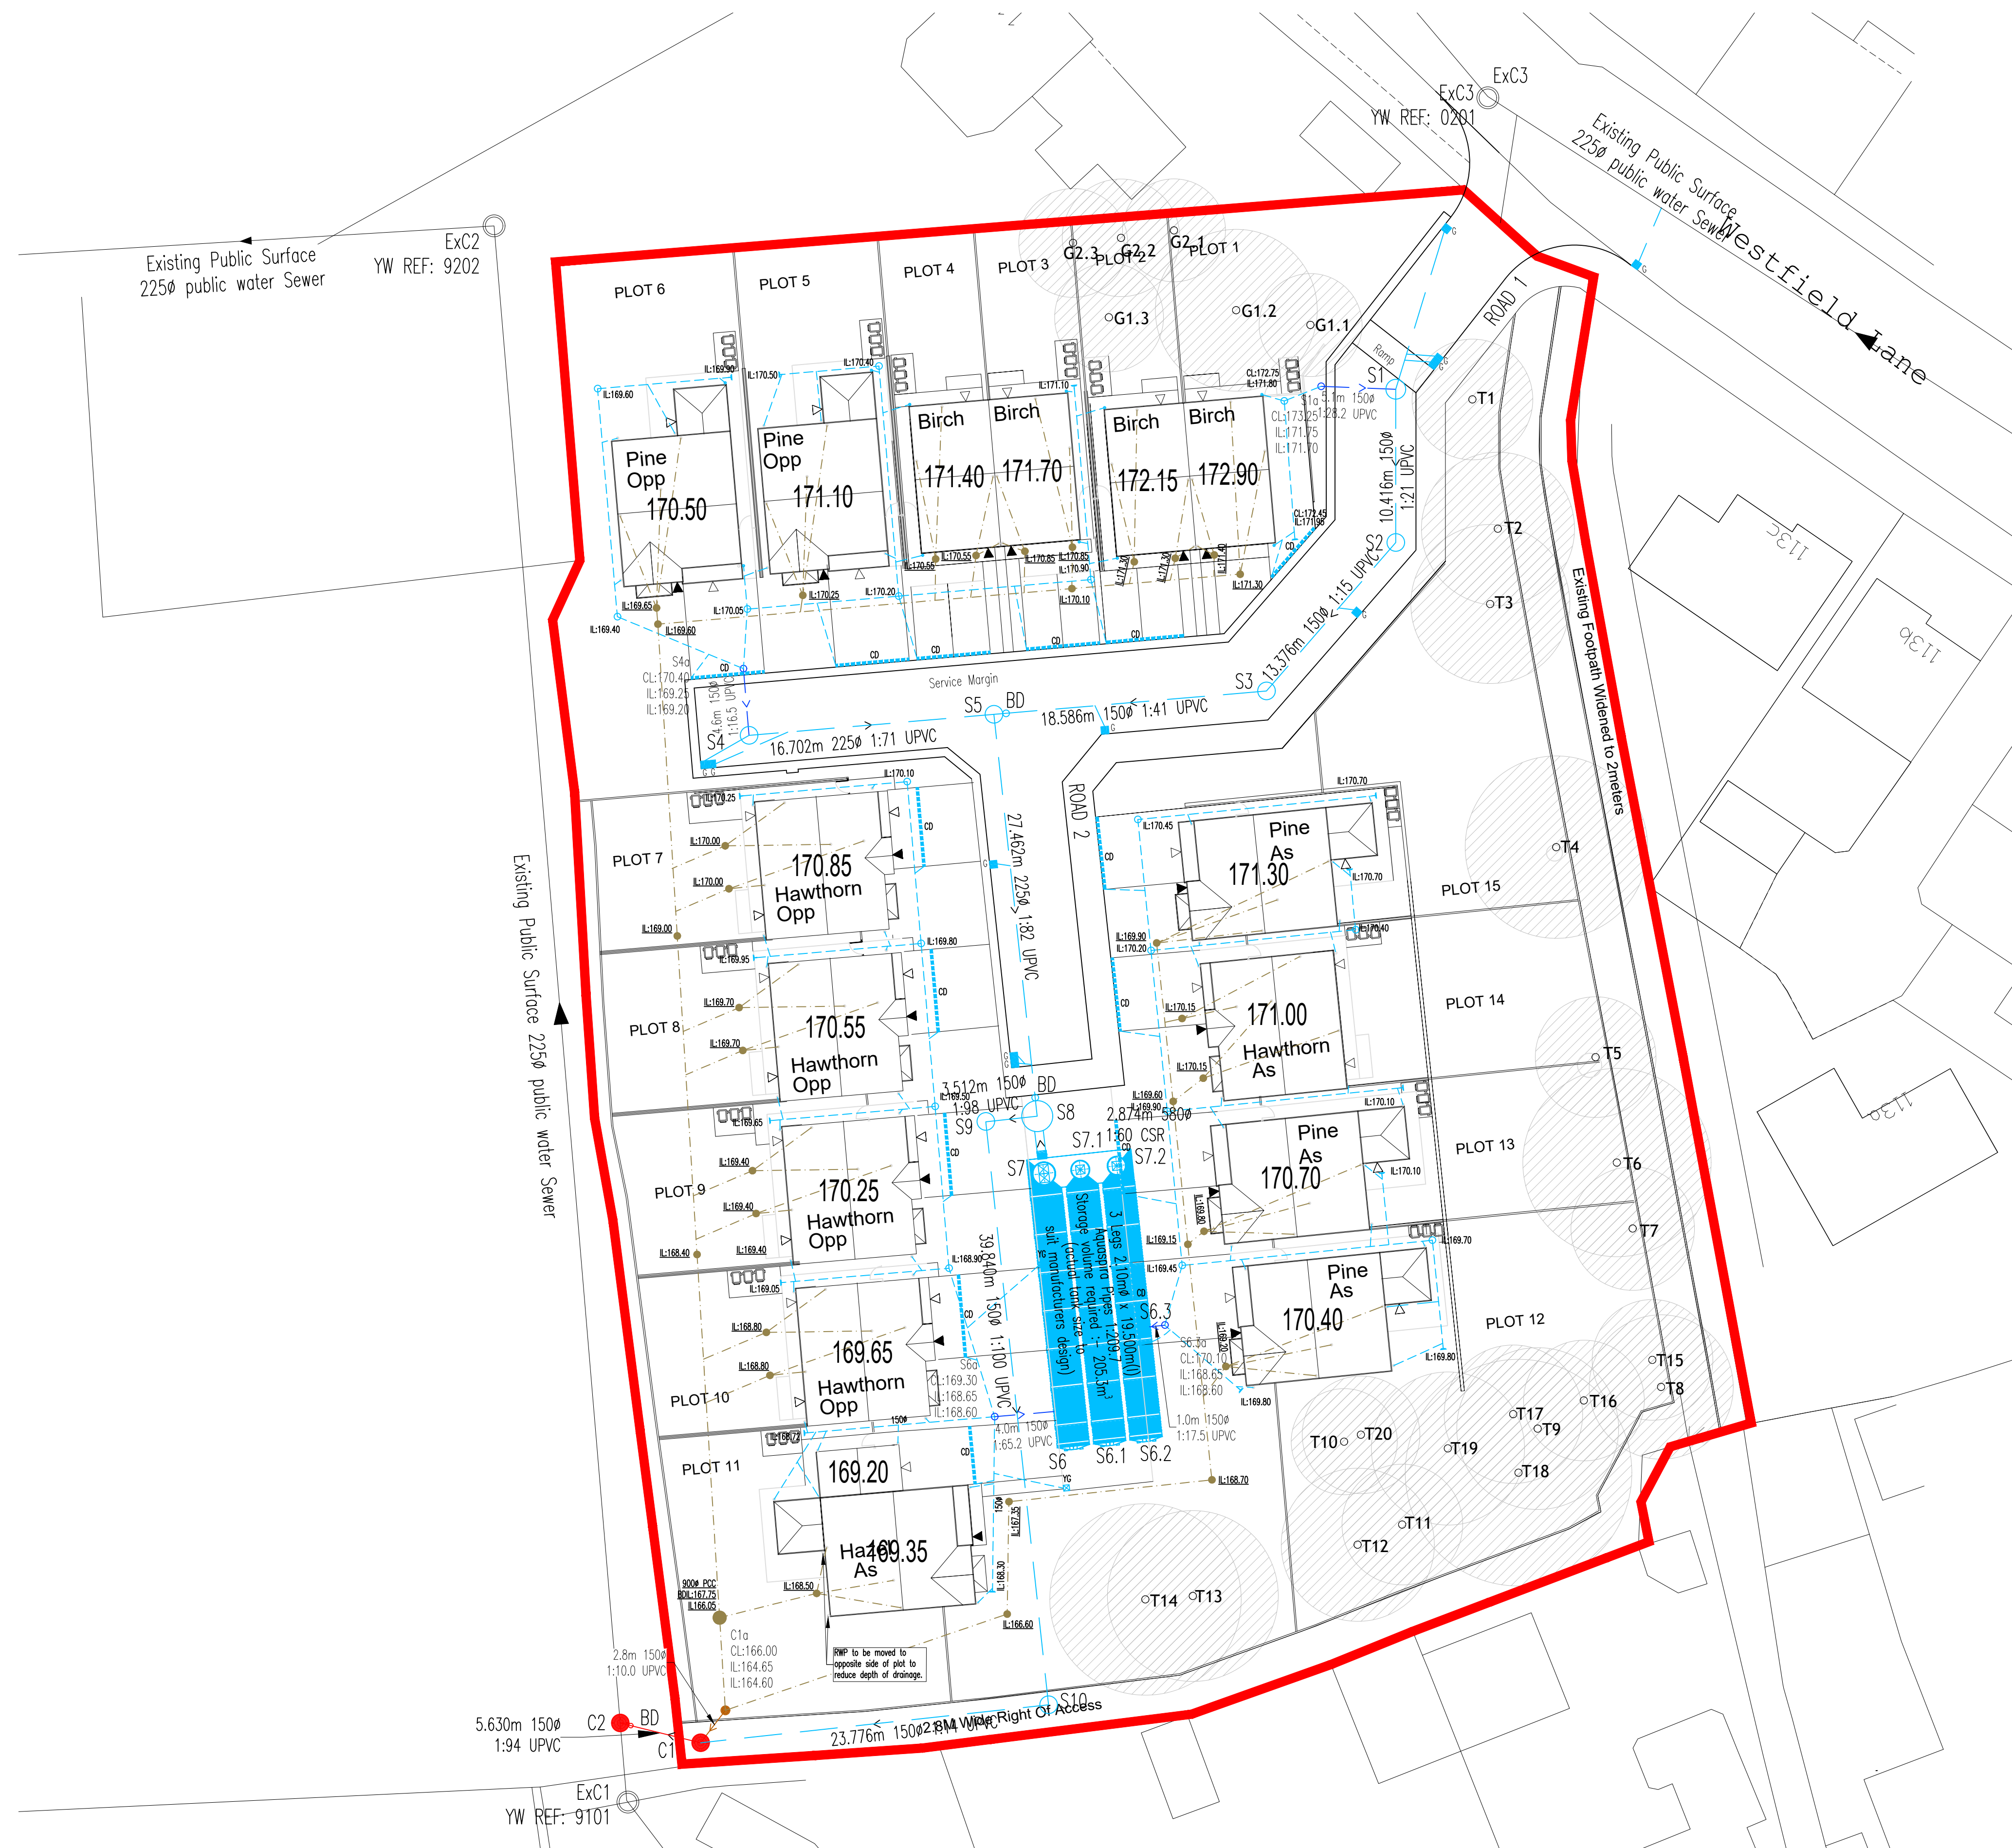

N	O	T	E	S
---	---	---	---	---

SUBJECT TO THE APPROVAL OF ALL RELEVANT AUTHORITIES

DO NOT SCALE	ORIGINAL DRAWING SIZE A1
--------------	--------------------------

KEY

- | | |
|---|----------------------------------|
| ???.??? | Finished Floor Level |
|  | Surface Water Manhole |
|  | Foul Water Manhole |
|  | Surface Water Inspection Chamber |
|  | Foul Water Inspection Chamber |
|  | Surface Water Sewer |
|  | Foul Water Sewer |
|  | Rainwater Pipe |
|  | Soil Vent Pipe |
|  | Rodding Eye |
|  | Channel Drain |
|  | Gully |
| IL86.615 | Surface Water Invert Level |
| <u>IL87.564</u> | Foul Water Invert Level |

- Levels may vary to suit on site working conditions
- Gully/channel/fin drain positions shown are subject to adjustment on site to ensure full drainage and the absence of ponding
- All private drainage to be 100mm dia unless stated otherwise

D	LS	05.07.23	Aquaspira details updated	AB
C	LS	02.06.23	Updated to suit Yorkshire Water Comments	AB
B	LS	22.05.23	Updated to suit new layout	AB
A	ZA	04.05.23	Adoptable drainage updated	AB
/	AB	06.04.23	Issued for approval	AB
Rev	By	Date	Description	Chk



CONSULTING ENGINEERS LTD
Clarke Hall Farm • Aberford Road • Wakefield • WF1 4AL
T: 01924 792312 • E: info@oeconsult.co.uk • W: www.oeconsult.co.uk

Client YORKSHIRE CHOICE HOMES

Project WESTFIELD LANE,
WYKE

Title
PRIVATE DRAINAGE LAYOUT

Scale 1:250	Drawn AB	Checked AB	Date APR.20
----------------	-------------	---------------	----------------

Drawing Status	APPROVAL
----------------	----------

Job No.	Drawing No.	Revision
124.008	05	D