

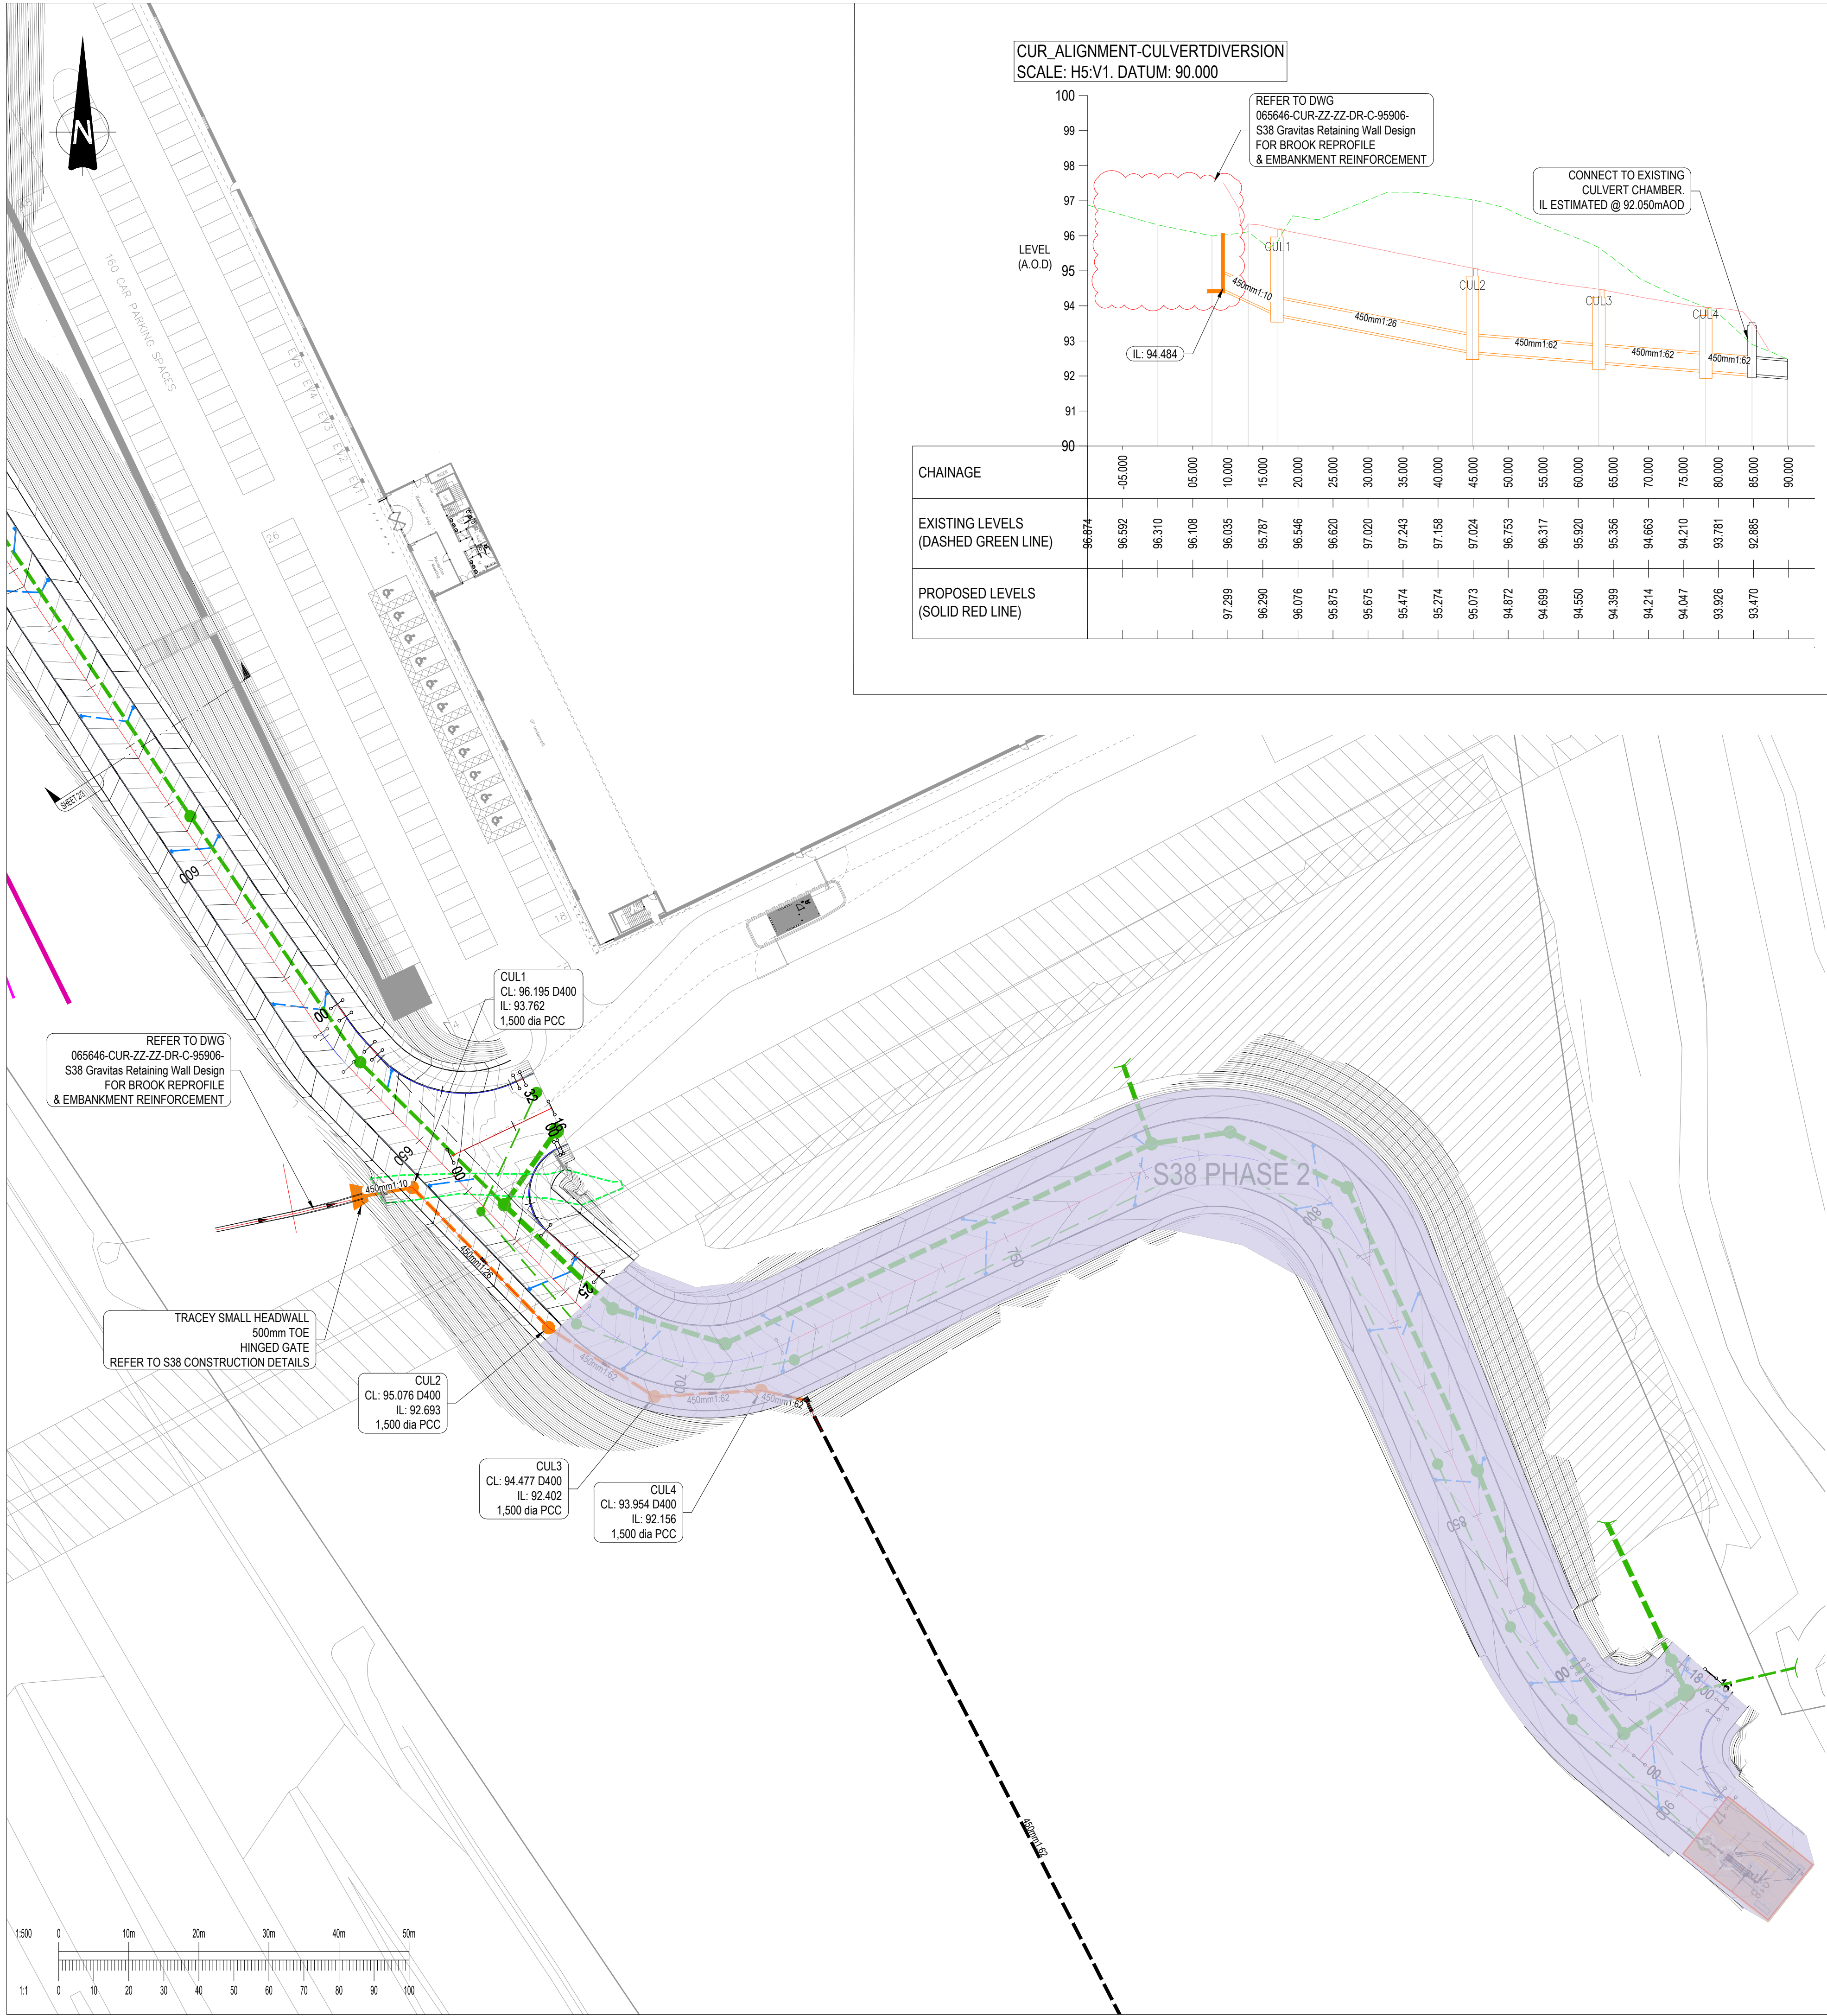


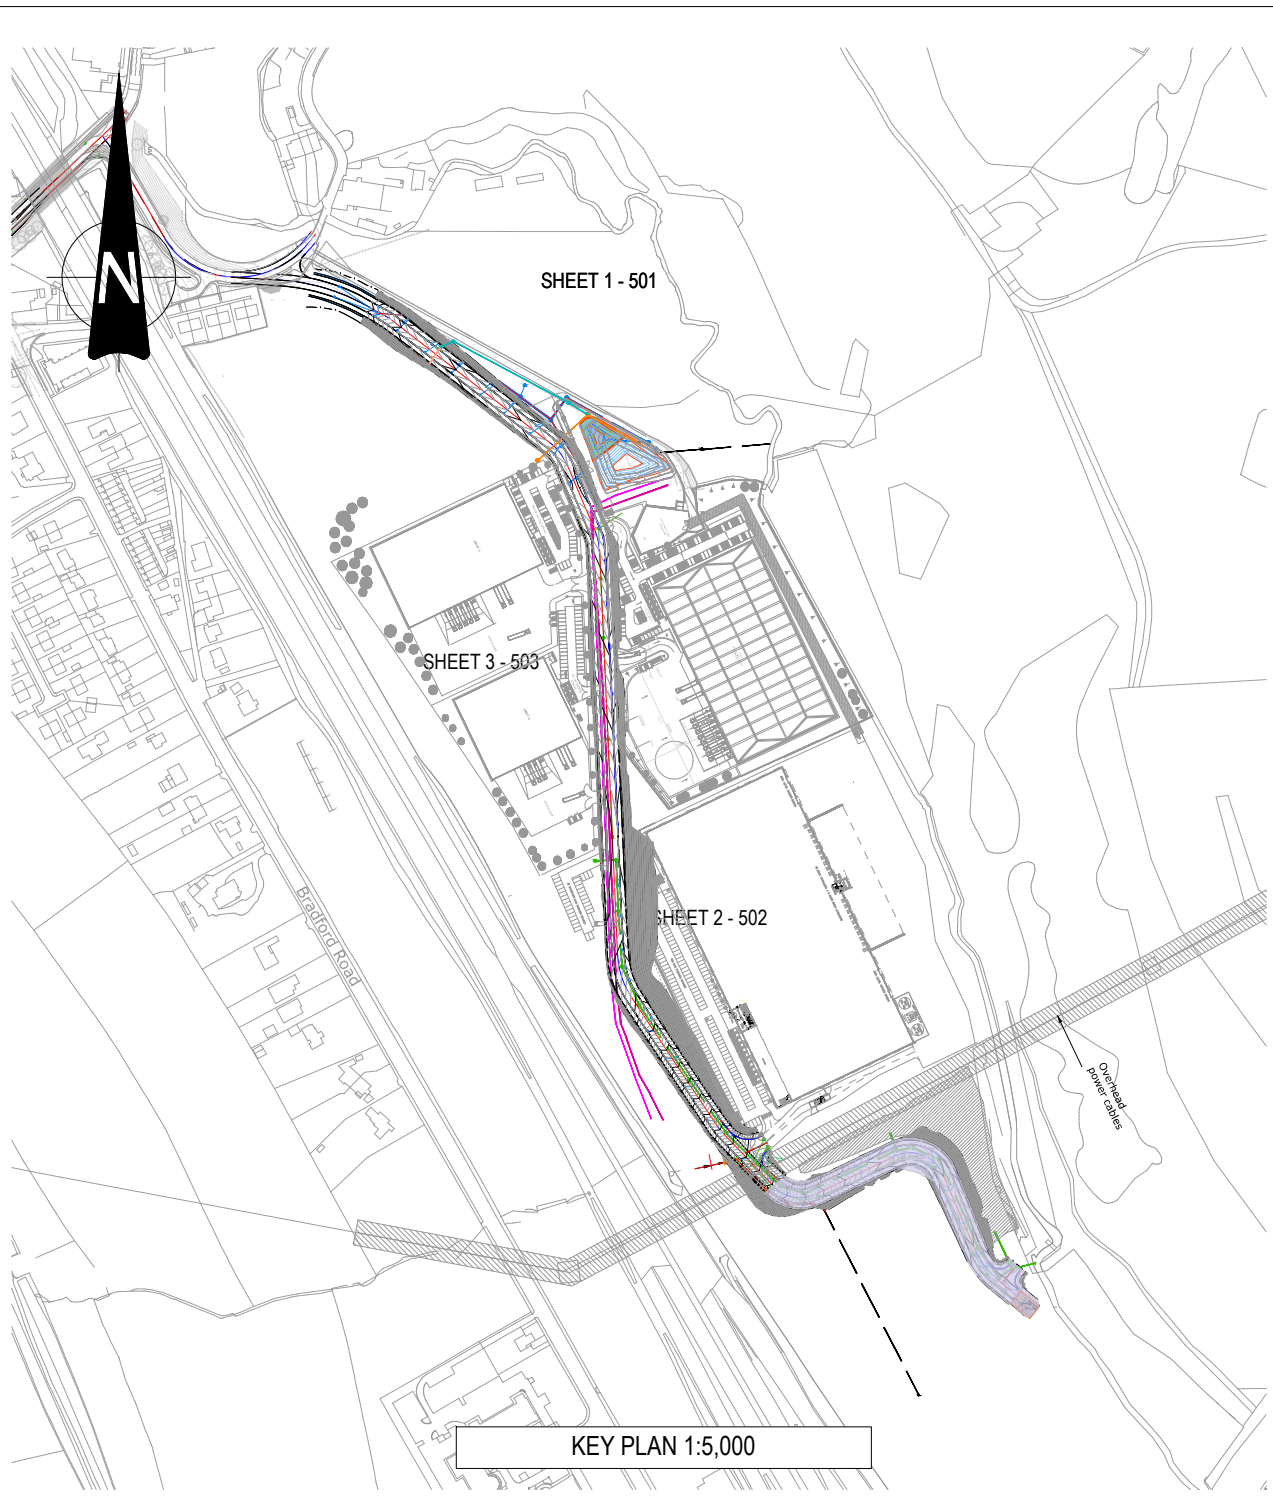

CUR_ALIGNMENT-CULVERTDIVERSION
SCALE: H5:V1. DATUM: 90.000

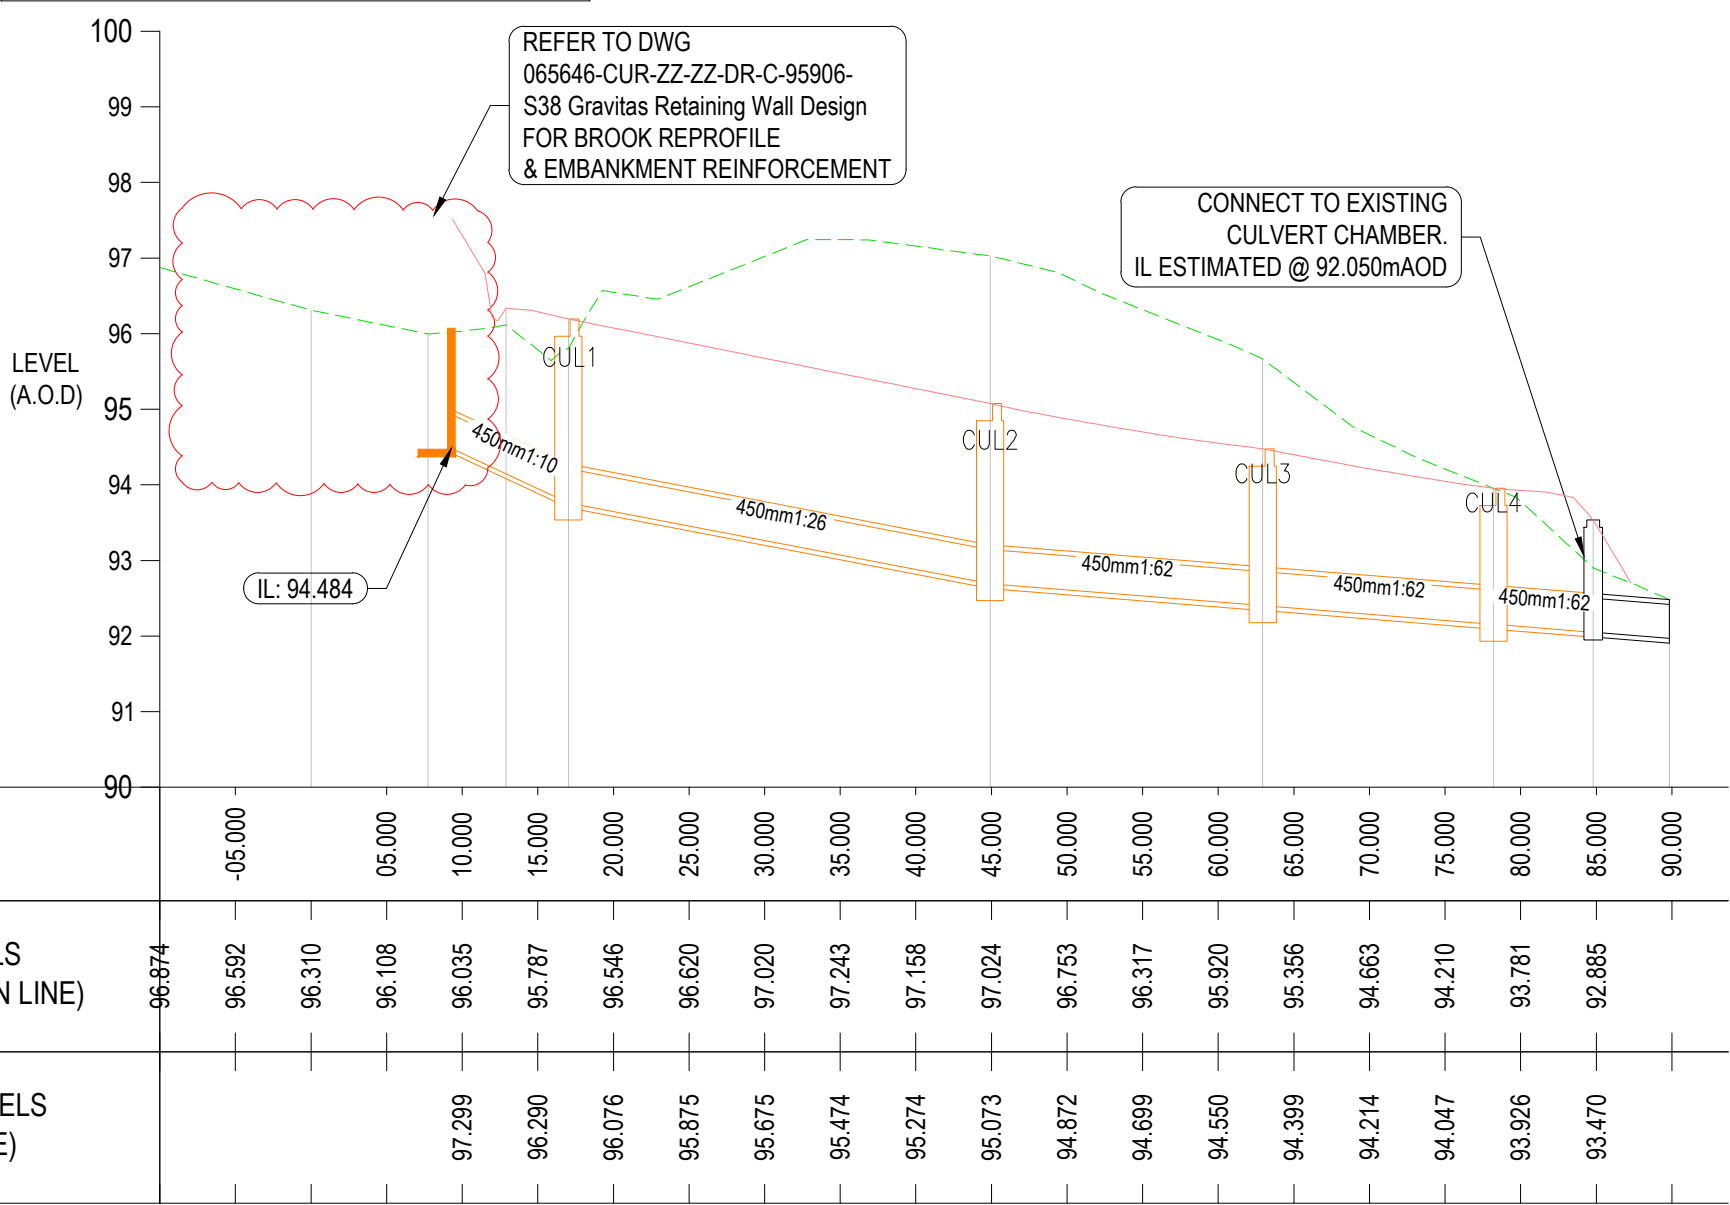

GENERAL NOTES:

- THIS DRAWING IS TO BE READ IN CONJUNCTION WITH ALL RELEVANT ARCHITECTS AND ENGINEERS DRAWINGS AND SPECIFICATIONS.
- DO NOT SCALE FROM THIS DRAWING. ANY OMISSIONS OR ERRORS ON DRAWINGS SHALL BE BROUGHT TO THE ENGINEERS ATTENTION IMMEDIATELY. ALL DIMENSIONS MUST BE CHECKED / VERIFIED ON SITE.
- ALL DIMENSIONS ARE IN MILLIMETRES UNLESS NOTED OTHERWISE.
- ALL LIGHTING COLUMNS, UTILITIES & COMMUNICATION LINES TO BE RELOCATED TO BACK OF PROPOSED FOOTWAY.
- CARRIAGEWAY AND FOOTWAY WORKS SUBJECT TO TECHNICAL APPROVAL BY CBMDC HIGHWAYS AND APPROPRIATE LEGAL AGREEMENTS.
- FOR CONSTRUCTION DETAILS OF PRE-CAST MANHOLES REFER TO KIRKLEES COUNCIL DETAIL HD/SD/05/11A AND FOR INSPECTION CHAMBERS REFER TO KIRKLEES COUNCIL DETAIL HD/SD/05/13A
- ACCESS POINTS TO BE PROVIDED FOR BEANY BLOCKS AT THE HEAD OF PROPOSED RUNS FOR BOTH SIDES OF VEHICULAR CROSSINGS AND EVERY 50m AND A SILT TRAP EVERY 100m

KEY

- KIRKLEES COUNCIL COMPLIANT BEANY BLOCK TO STANDARD HD/SD/05/13A (100mm UPSTAND)
- KIRKLEES COUNCIL COMPLIANT BEANY BLOCK TO STANDARD HD/SD/05/13A (0mm UPSTAND)
- ADAPTABLE HIGHWAY SEWER (S38 AGREEMENT) *SEE NOTE 6
- ADAPTABLE SURFACE WATER SEWER (YW)
- ADAPTABLE FOUL WATER SEWER (YW)
- PROPOSED PRIVATE SURFACE WATER DRAINAGE
- ROAD GULLY
- EXISTING GAS MAIN 600 / 450mm DIAMETER
- EXISTING SURFACE WATER SEWER
- CULVERT DIVERSION (NOT ADOPTED UNDER S38)
- INFILL EXISTING BROOK
- EXISTING Ø450mm GAS MAINS
- EXISTING Ø600mm GAS MAINS

P16	UPDATED FOLLOWING INTERNAL S38 REVIEW	28/11/22	JC	ACS
P15	AMENDED PUMPING STATION LOCATION ADDED	06/05/22	JC	ACS
P14	ALTHON HEADWALL CHANGED TO TRACEY HEADWALL	25/04/22	JC	ACS
P13	CULVERT DIVERSION GRADIENTS AMENDED	10/03/22	JC	ACS
P12	AMENDED FOLLOWING S38 REVIEW	07/03/22	JC	ACS
P11	AMENDED TO KIRKLEES COMMENTS	28/02/22	JC	ACS
P10	HIGHWAY ALIGNMENT AMENDED	05/11/21	JDB	JC
P09	CULVERT DIVERSION AMENDED	05/10/21	JDB	AS
P08	REVISED TO KIRKLEES COMMENTS	21/09/21	JDB	AS
P07	REVISED TO KIRKLEES COMMENTS	16/06/21	OT	OT
P06	REVISED TO KIRKLEES COMMENTS	29/04/21	OT	OT
P05	REVISED TO NEW ALIGNMENT, EXTENTS, AND YW ADOPTION EXTENTS	21/10/20	OT	NT
P04	REVISED TO SUIT S104 DRAWINGS	07/07/20	OT	OT
P03	REMOVED PLOT DETAIL	15/05/20	OT	OT
P02	REVISED TO NEW ROAD ALIGNMENT	17/04/20	OT	OT
P01	FIRST ISSUE	17/01/20	OT	OT
Rev:	Description:	Date:	By:	Chkd:



Rose Wharf Ground Floor, 78-80 East Street, Leeds, LS9 8EE
0113 274 8809
leeds@curtins.com
www.curtins.com

Civils & Structures • Transport Planning • Environmental • Infrastructure • Geotechnical • Conservation & Heritage • Principal Designer
Birmingham • Bristol • Cambridge • Cardiff • Douglas • Dublin • Edinburgh • Glasgow • Kentish • Leeds • Liverpool • London • Manchester • Nottingham

Status: ISSUED FOR INFORMATION **S2**

Project: INTERCHANGE 26, NORTH BIERLEY

Orig Title: S38 DRAINAGE LAYOUT SHEET 2

Size:	Date:	Drawn By:	Designed By:	Checked By:			
A1	17/01/20	OT	OT	OT			
Scale: 1:500							
Project No:	Originator:	Volume:	Level:	Type:	Role:	Category / Number:	Re
065646 - CUR - ZZ - ZZ - DR - C - 95512 - P							