




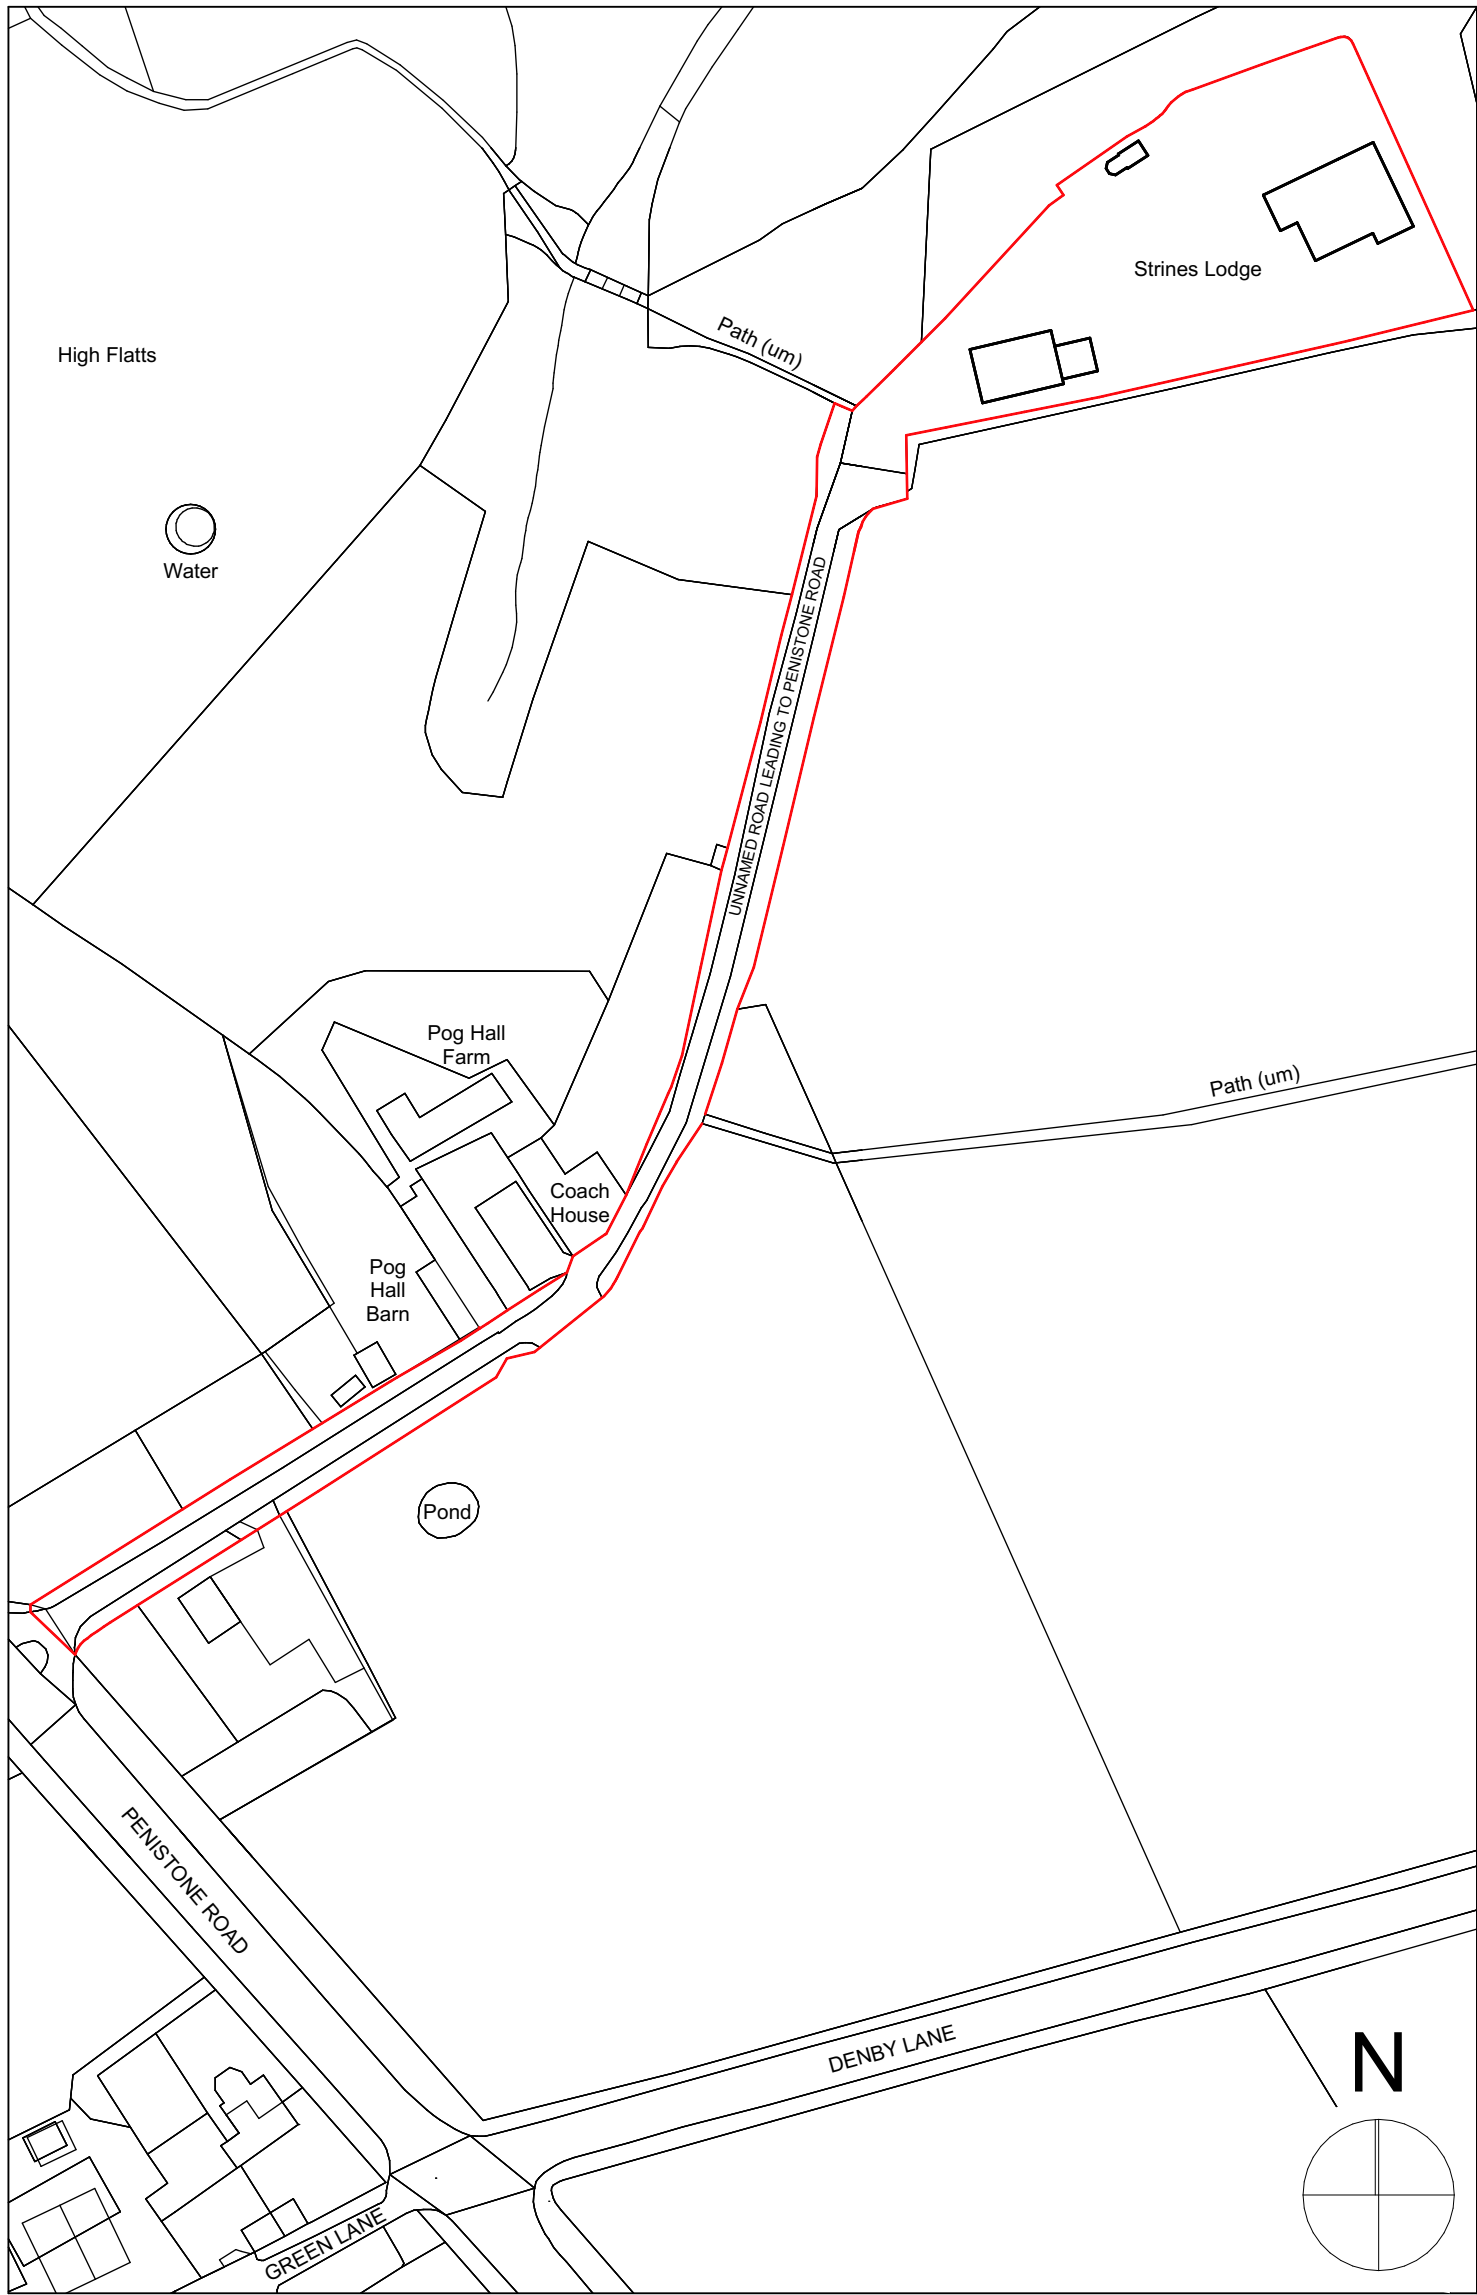

Proposed Site Location Plan 1:1250

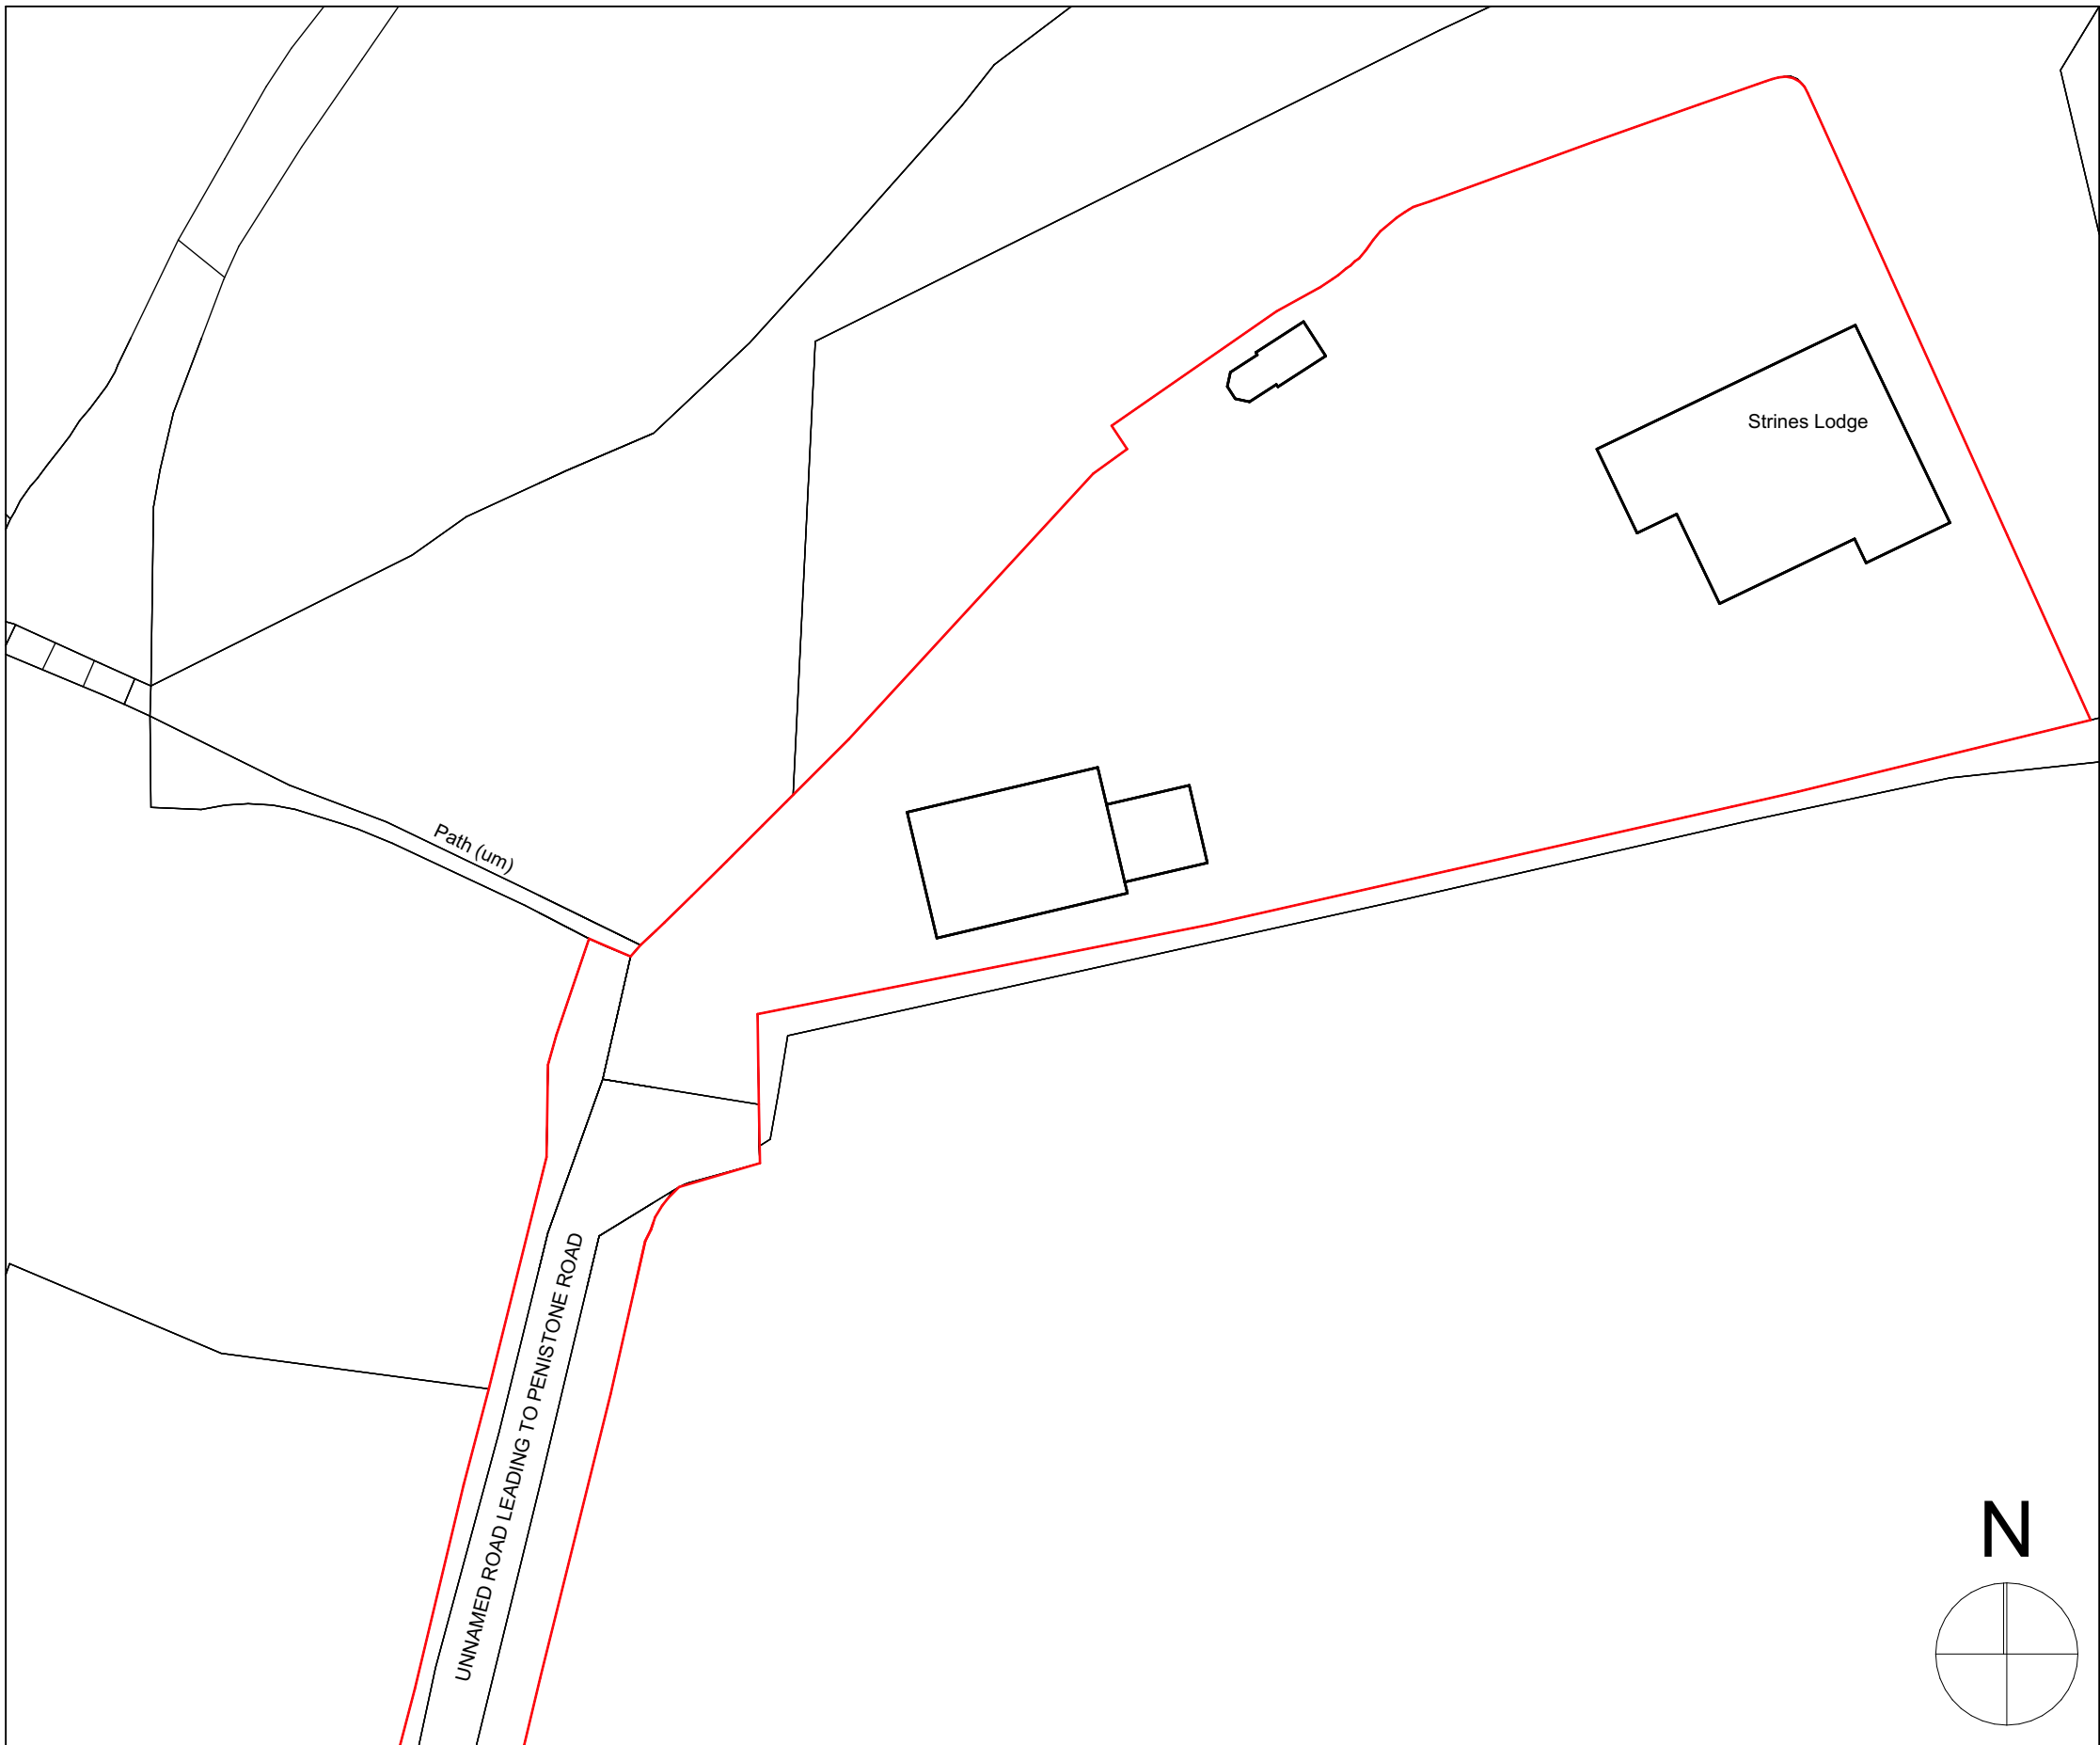

Proposed Site Block Plan 1:500

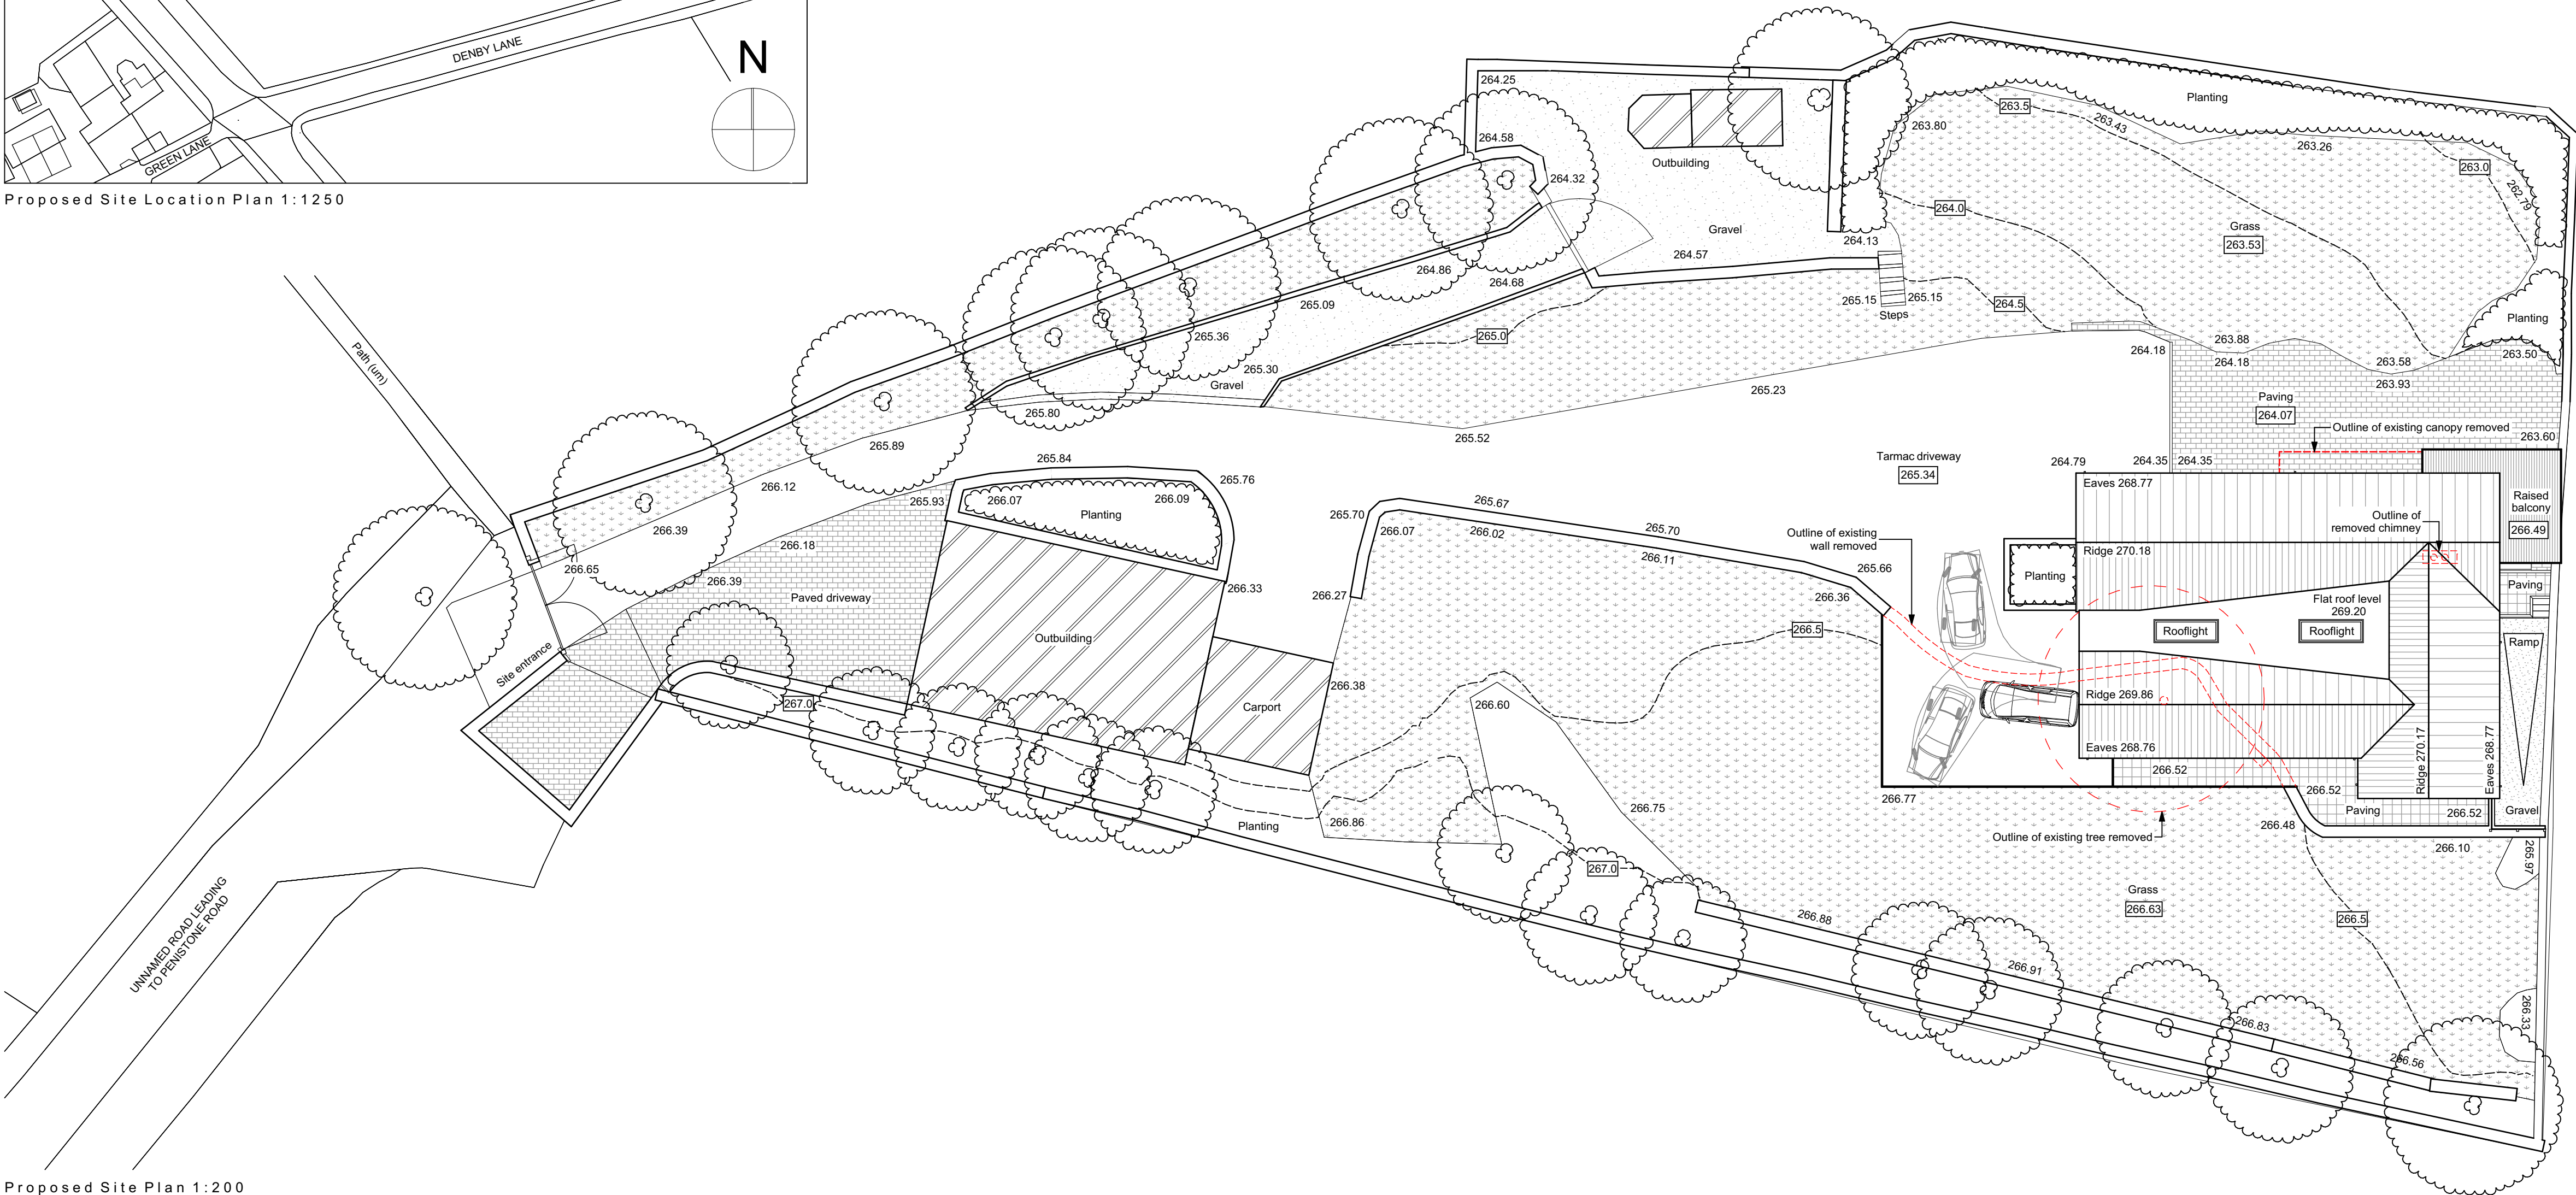

Proposed Site Plan 1:200

Contractor must verify all dimensions on site before commencing any work or shop drawings. If this drawing exceeds the quantities taken in any way, the building designers are to be informed before the work is initiated. Only figured dimensions to be taken from this drawing. Do not scale off this drawing. Drawing based on Ordnance Survey and/or existing record drawings - design and drawing content subject to Site Survey, Structural Survey, Site Investigations, Planning and Statutory Requirements and Approvals. All drainage layouts are schematic and invert levels must be established prior to construction.

08.09.2023 Rev B - The red line boundary has been updated to include the shared access road up to the nearest adopted highway penistone road, as per the planner's request. JN
22.08.2023 Rev A - The extent of the site location plan has been extended to show two named roads, as per the planner's comments. JN

Project Status:	PLANNING ONLY
TransformARCHITECTS	
4 Rushmead Court, Ossett, WF5 0NZ tel: 01924 275 594 web: www.transformarchitects.co.uk email: info@transformarchitects.co.uk	
Project Address:	Strines Lodge High Flatts Birdsedge Huddersfield HD8 8XU
Client:	Ms I Dews
Drawing Title:	Proposed Site Plan A1
Scale:	1:1250, 1:200, 1:500
Date:	10.08.2023
Drawn By:	MNB
Drawing Number:	T1168 - PL15
Revision:	Rev B