
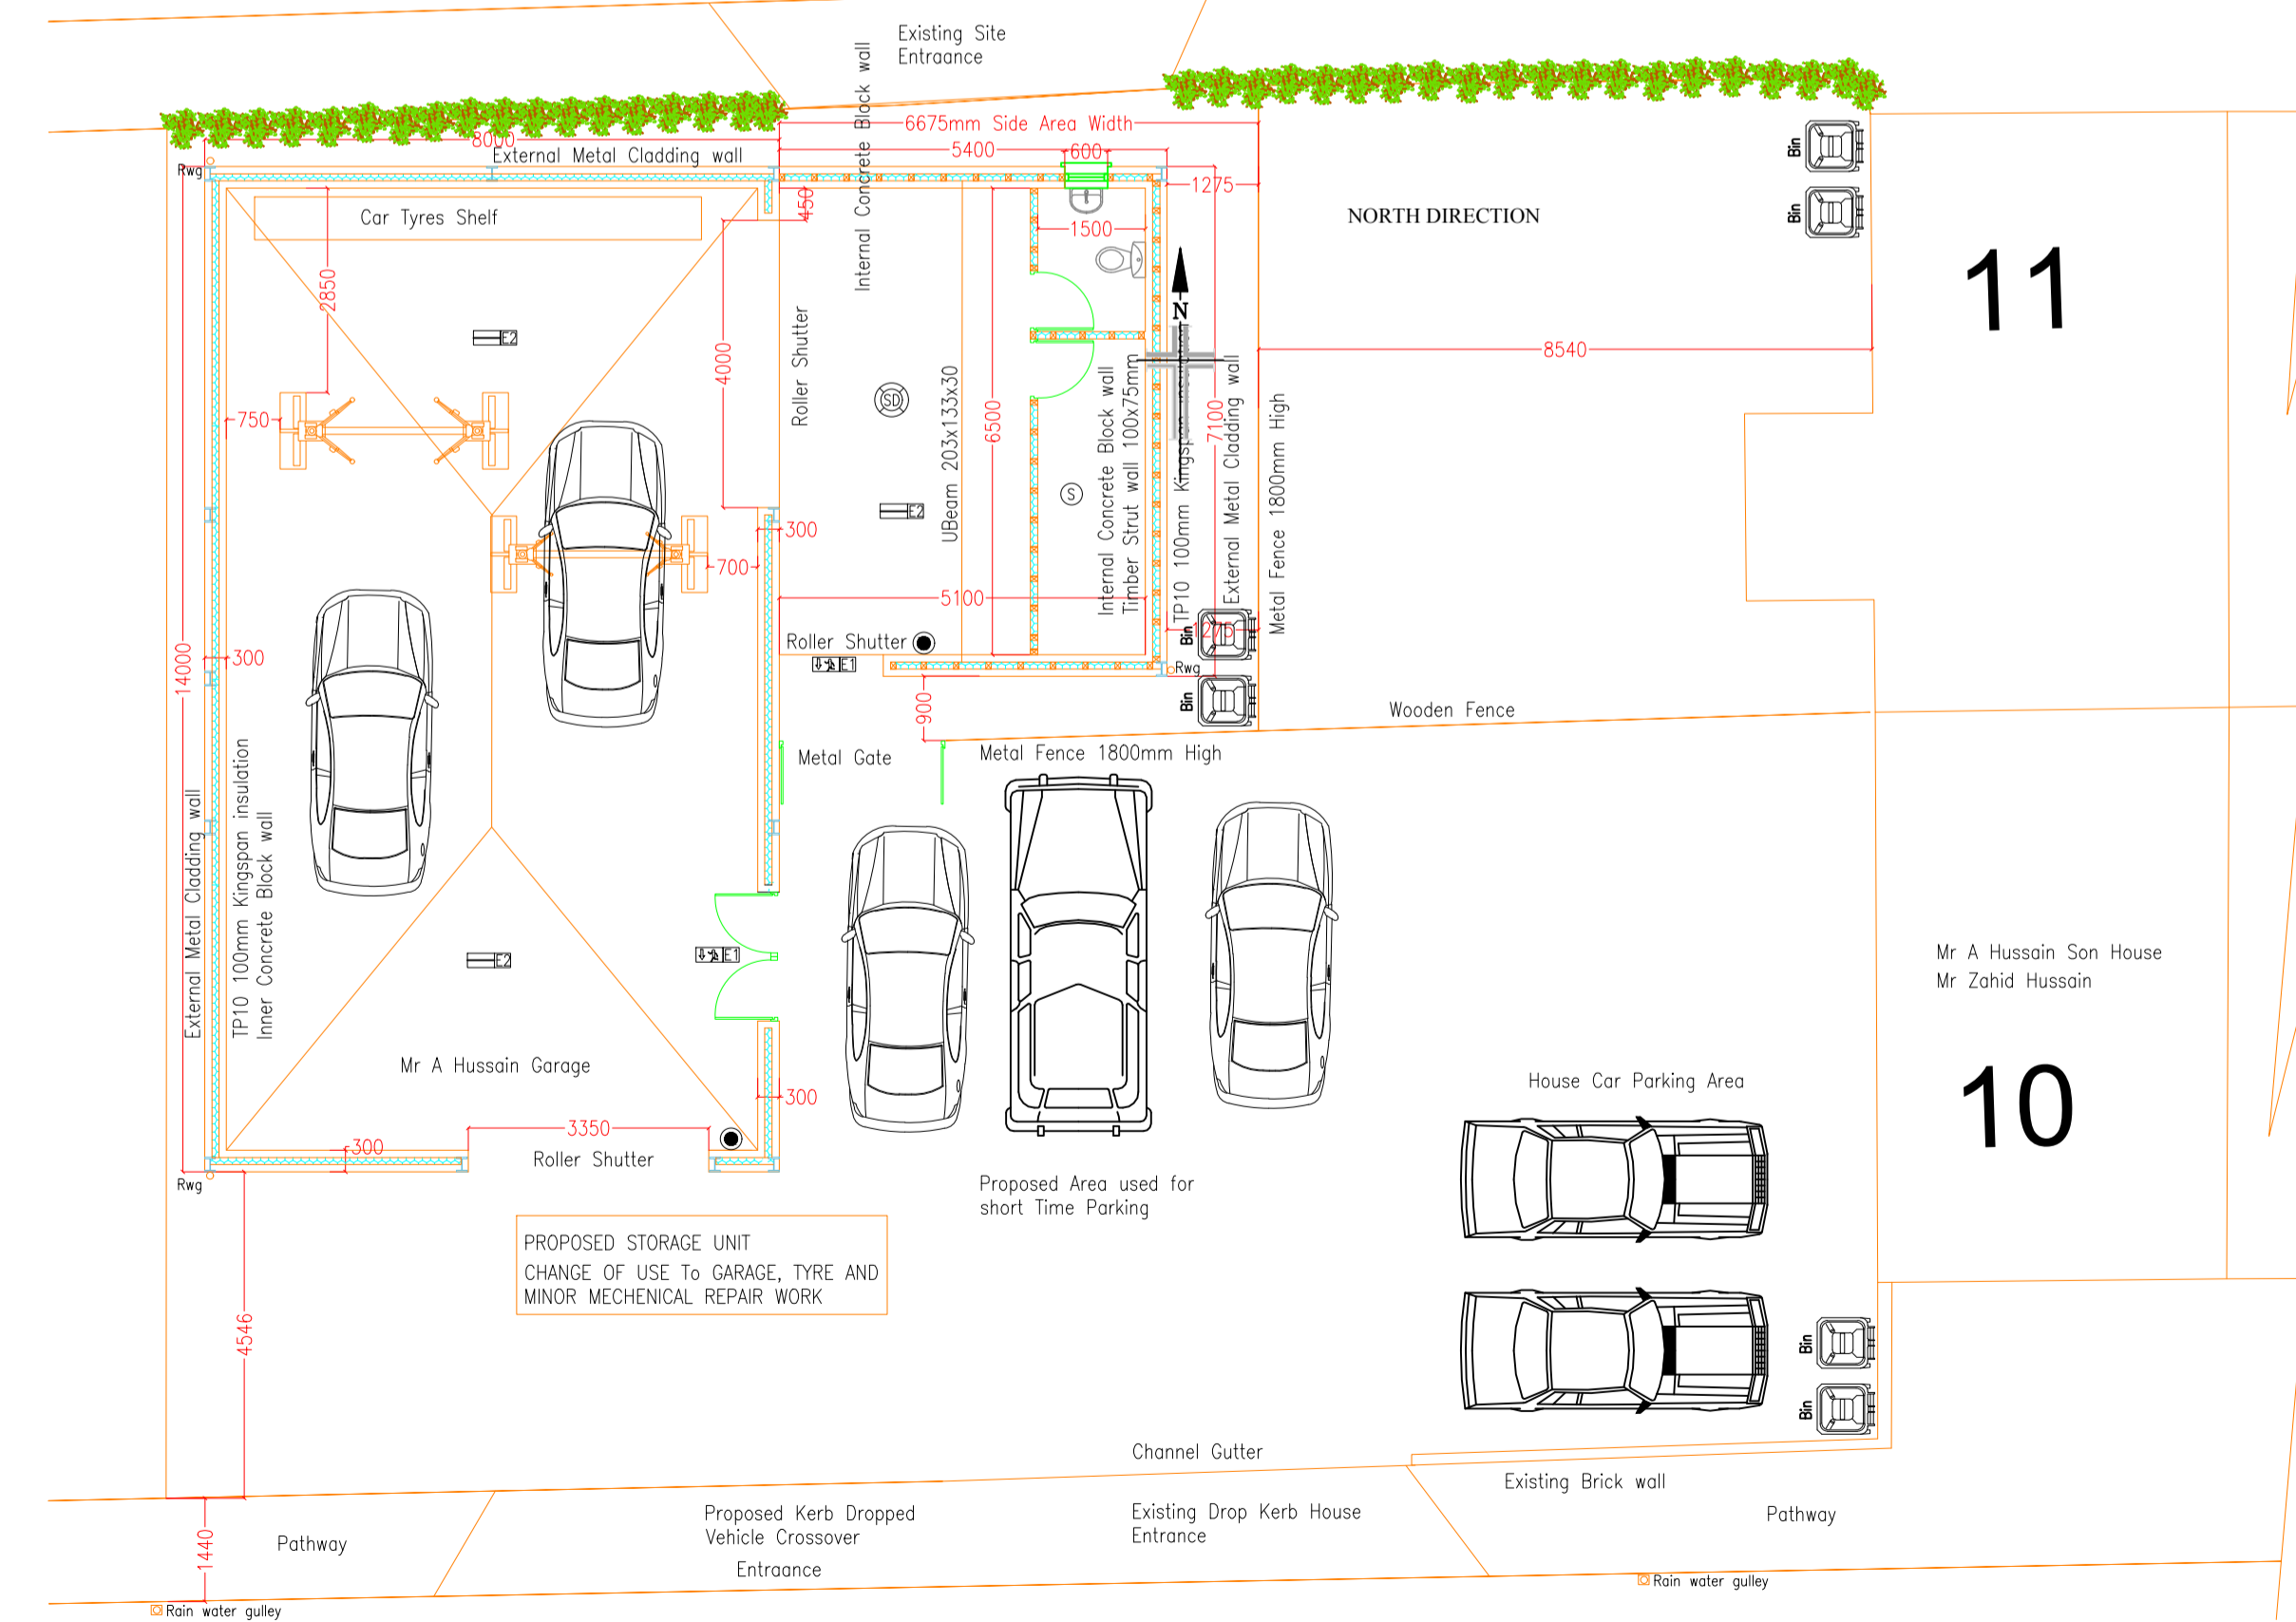


WILLIAM STREET

WILLIAM STREET

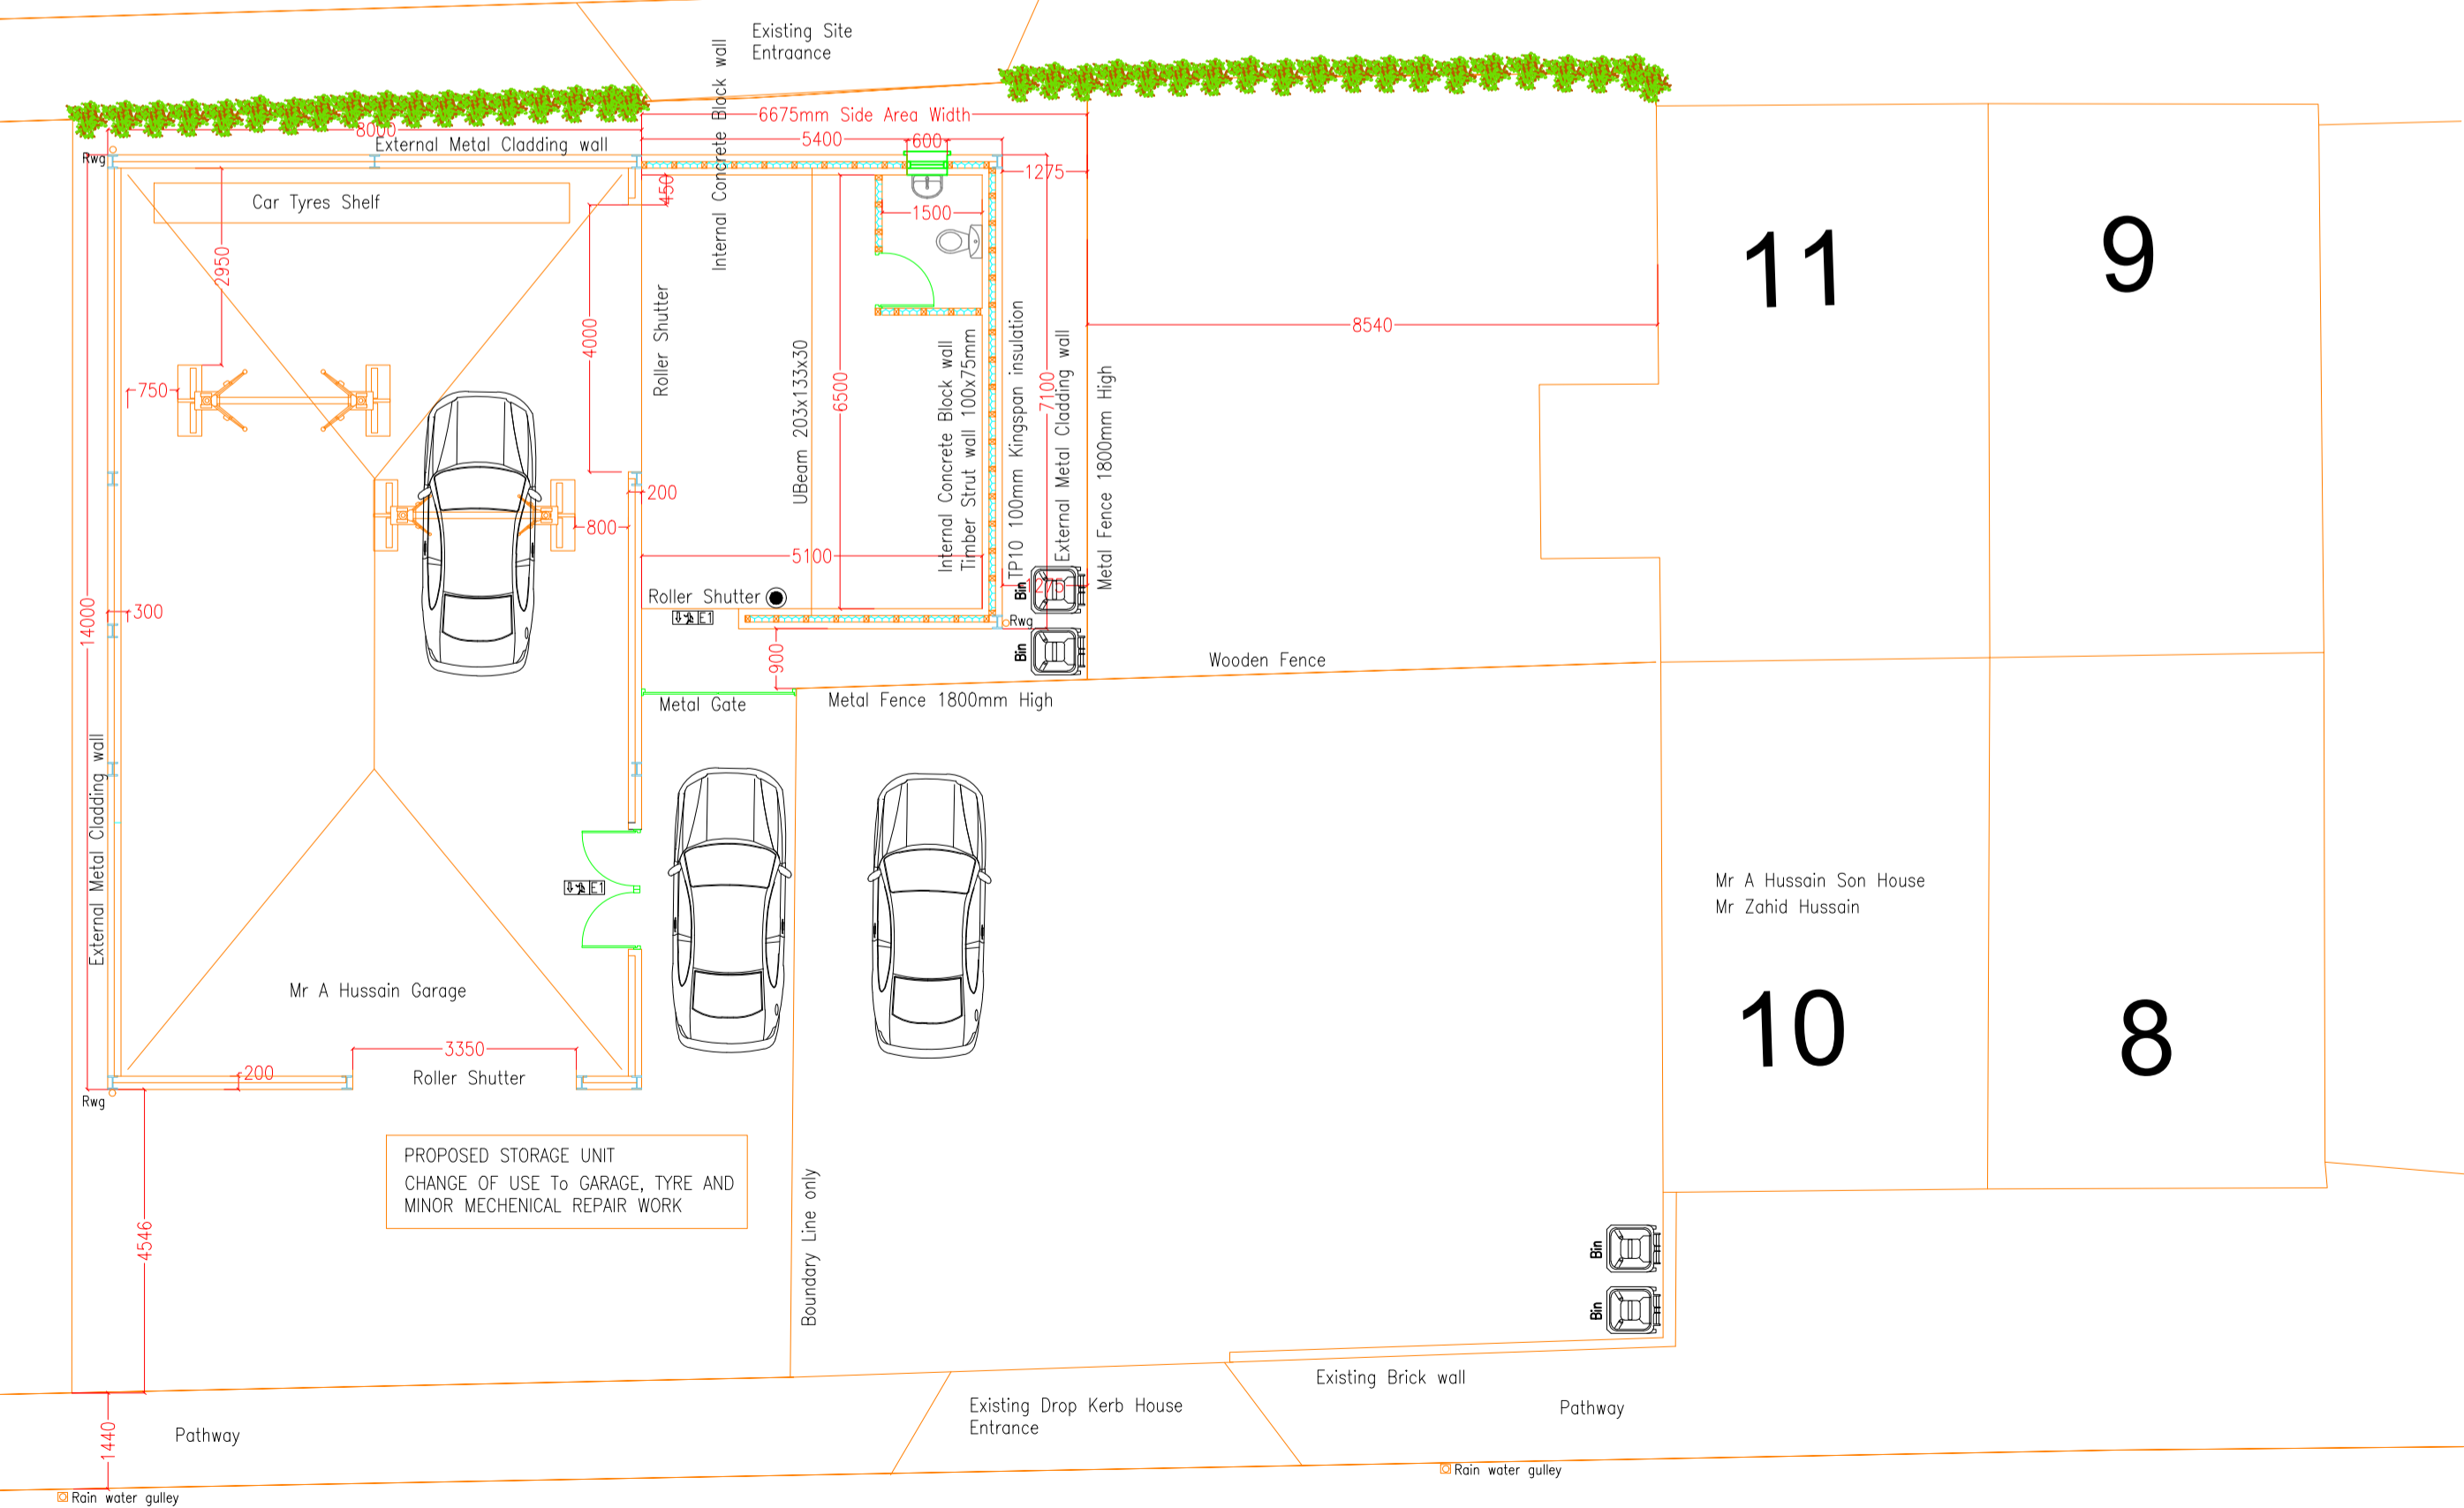

GEORGE STREET

GEORGE STREET

- FIRE SAFETY LEGEND.
- ⊙ Optical Smoke Detector
 - ⊙ Optical Smoke Detector with Sounder
 - ⊙ Heat Detector
 - ⊙ Call Point/Break Glass Unit
 - FD30 Fire Door rating 30minutes min
 - EXIT SIGN
 - EMERGENCY LIGHT 1hr BATTERY

Rev-D 24/03/2025 House 11 Bins and Car Parking
YT&A Post to Allocated in suitable Place
Rev-C 06/08/2024 Highways Comments to be addressed
and Amended Layout

AI_CAD_DESIGN
BRADFORD WEST YORKSHIRE

CONSTRUCTION CONSULTANTS AND
ARCHITECTURAL DESIGN
582 GREAT HORTON ROAD
BRADFORD BD7 3EU
E-mail : amjiden130@gmail.com
TEL (01274) 447699 Mob : 07727182285

CLIENT/PROJECT
MR ABID HUSSAIN
TEE MOTORS
12 GEORGE STREET, RAVENSTHORPE, DEWSBURY
KIRKLEES, WEST YORKSHIRE, WF13 3LL

TITLE
CHANGE OF USE FROM STORAGE TO GARAGE
EXISTING & PROPOSED GROUND FLOOR PLAN
EXISTING & PROPOSED ALL SIDE ELEVATIONS

DRAWING STATUS FOR APPROVAL		DRAWING No A1-CAD/02D	
DRAWN	MAMJID	DATE	24/03/2025
SCALE	1:100 @ A1	REVISION	D