


Schedule						
Symbol	Label	Quantity	Catalog Number	Description	Lumens Per Lamp	Wattage
	A1	1	DSX0.1.LA134.AY Mounted on 6m Column	D-Series 0 Area luminaire	13145	107
	B1	5	DSX0.1.LA134.NR Mounted on 6m Column	D-Series 0 Area luminaire	13681	107
	C1	5	DSX0.1.LA114.FW Mounted on 6m Column	D-Series 0 Area luminaire	11644	88
	D	12	DBD.1.LA014.SU.AY.LS.W006 - 1m High	Denver ID Bollard	572	6

Statistics					
Description	Symbol	Avg	Min	Min/Avg	
Shared Car Park - 20Lux/0.25Uo		25 lux	7 lux	0.28	
Unit 1 Drive-Thru - 50Lux/0.40Uo		51 lux	21 lux	0.41	
Unit 2 Drive-Thru - 50Lux/0.40Uo		49 lux	24 lux	0.49	

DO NOT SCALE FROM THIS DRAWING.
SERVICE INFORMATION ONLY TO BE TAKEN FROM THIS DRAWING.
Where Architects details are shown on this drawing, these are indicative and reference should be made to the appropriate Architect's drawing.

Rev.	Date	Description	Eng.	App.
P1	14-12-23	PRELIMINARY ISSUE	SJ	MH
P2	15-12-23	UPDATED PRELIMINARY ISSUE	SJ	MH

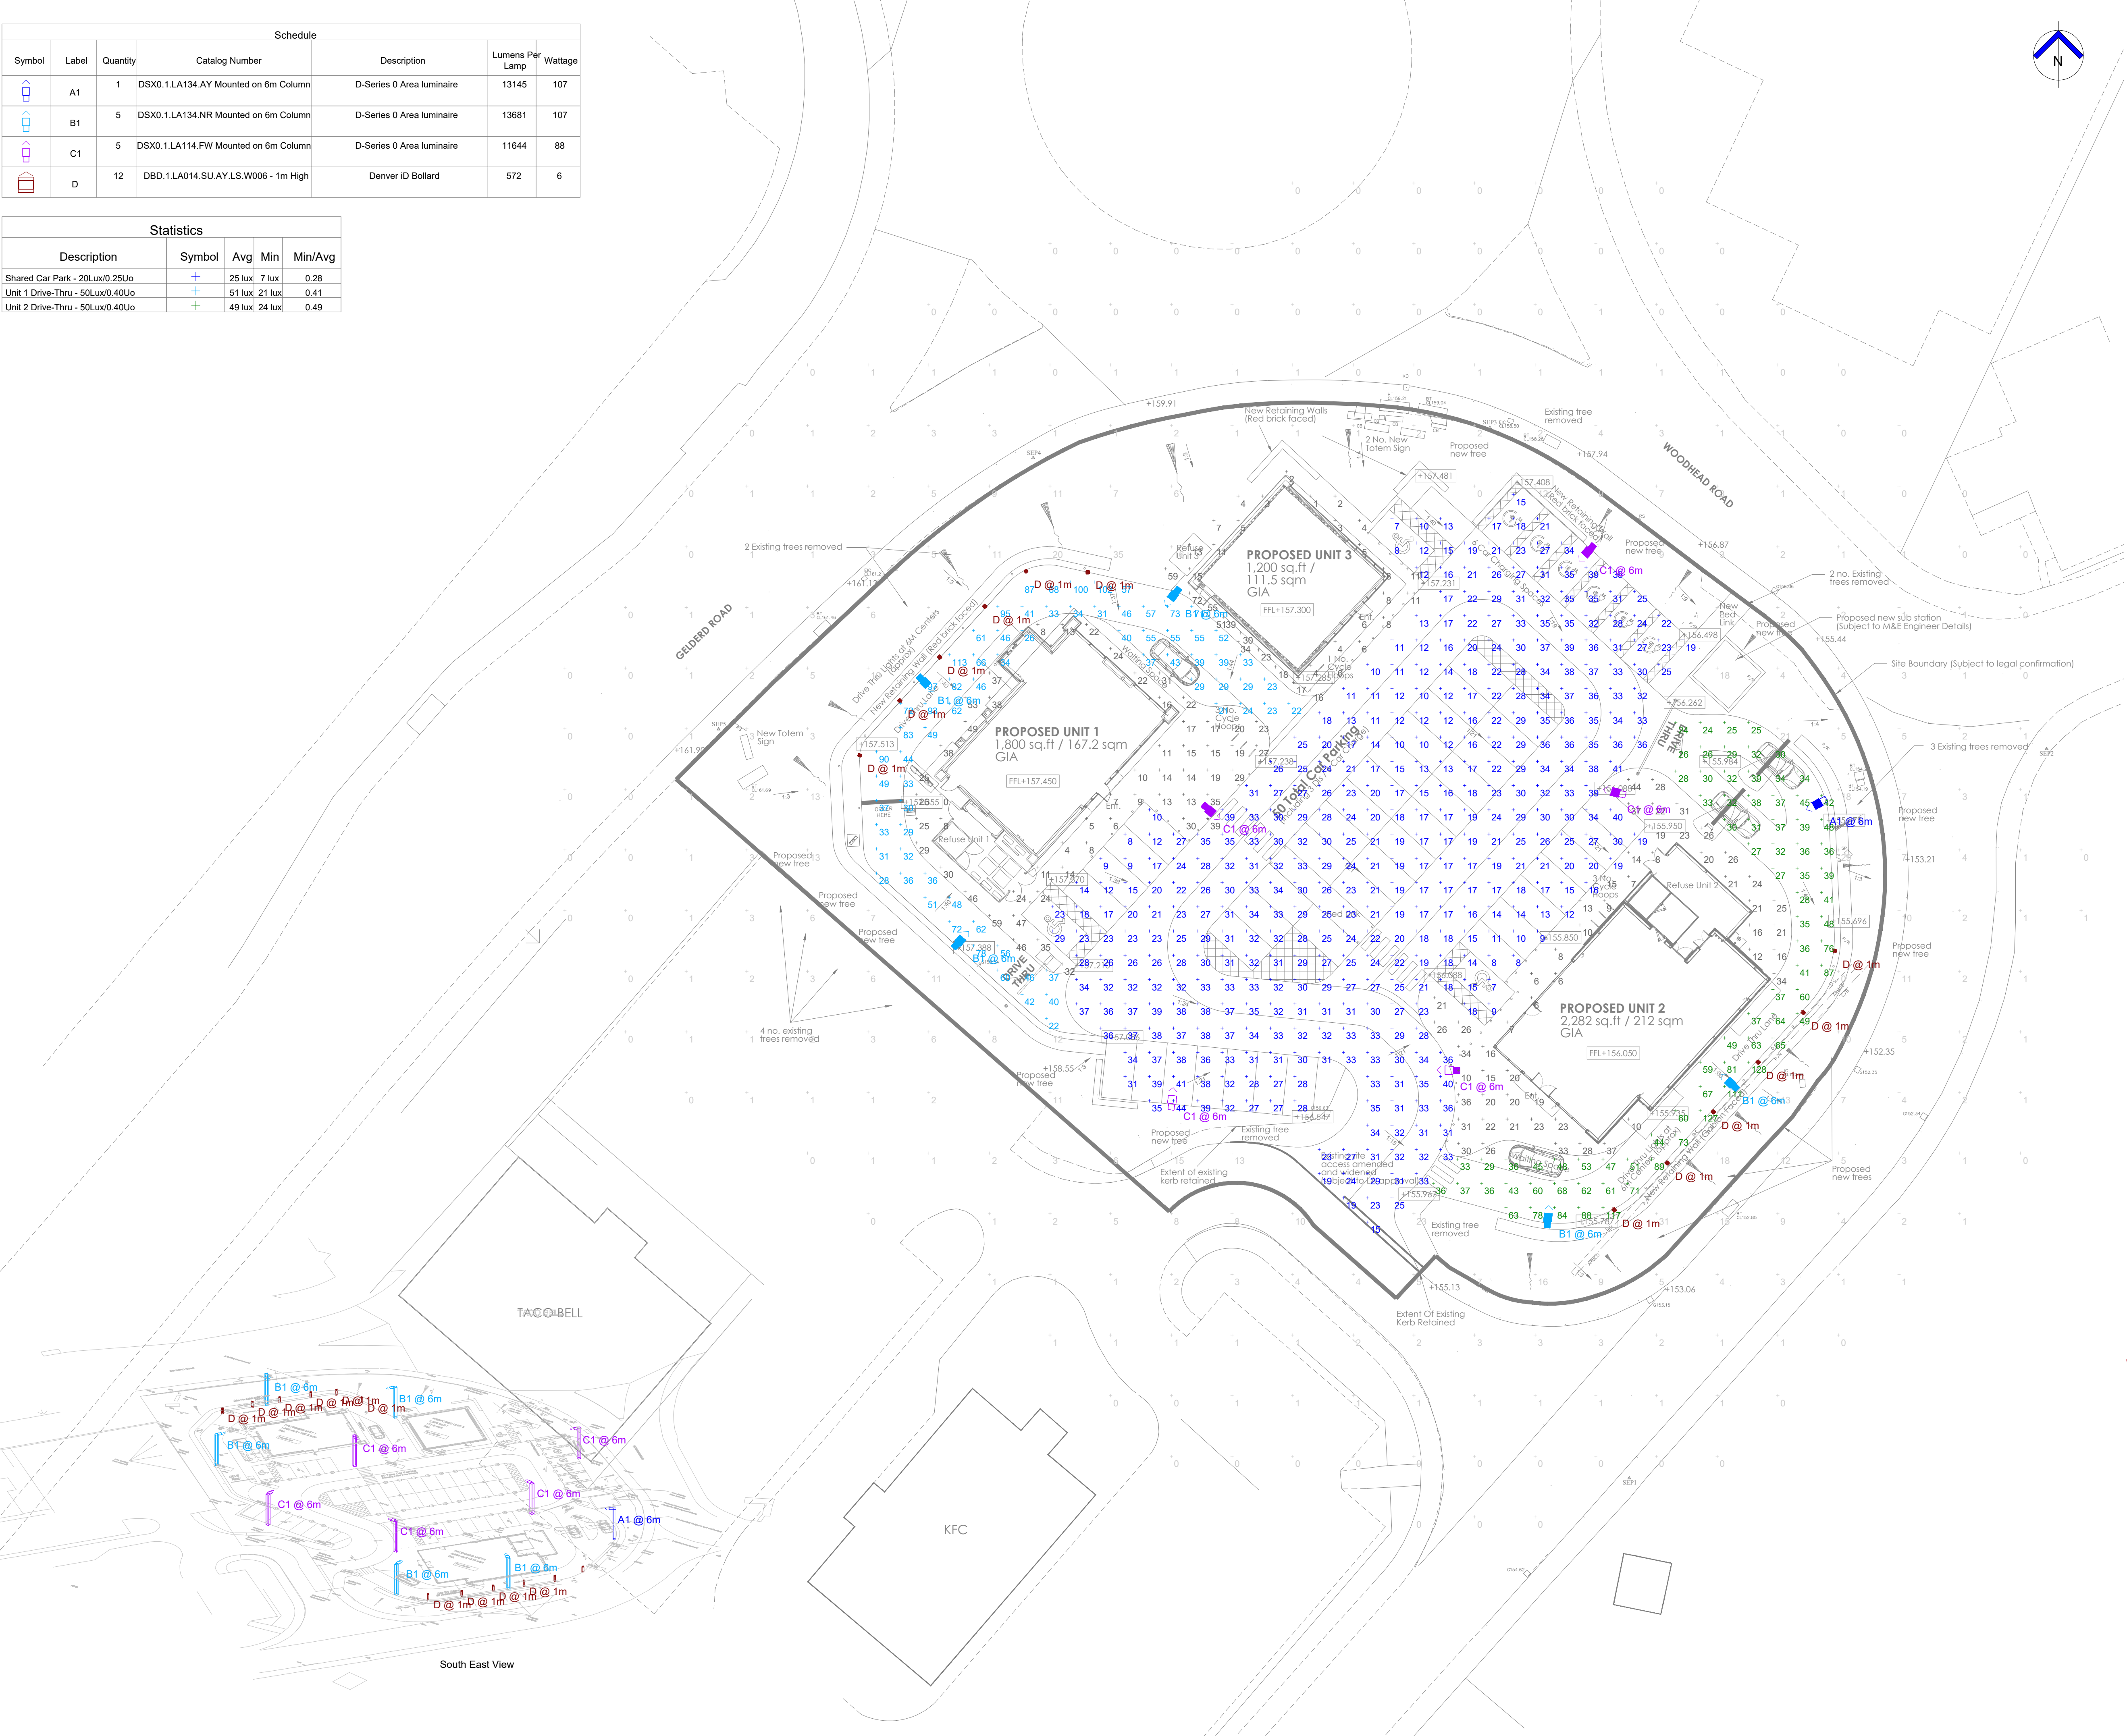

0 2 4 6 8 10M
SCALE
1:250

Client.
LONDONMETRIC
PROPERTY PLC

Insignis
CONSULTING ENGINEERS
48 Dover Street | London | W1S 4FF
t: +44 (0)203 869 8444 e: admin@insignisconsulting.co.uk
www.insignisconsulting.co.uk

Status.
PRELIMINARY ISSUE

Project.
BIRSTALL DRIVE-THRU
GELDERD ROAD

Title.
SITE PLAN
MEP SERVICES LAYOUT
EXTERNAL LIGHTING

Scale.
1:250@A1

Drawn.
SJ

Date.
DEC 2023

Drawing Number.
0364-INSIG-ZZ-00-PL-U96-001-P2