
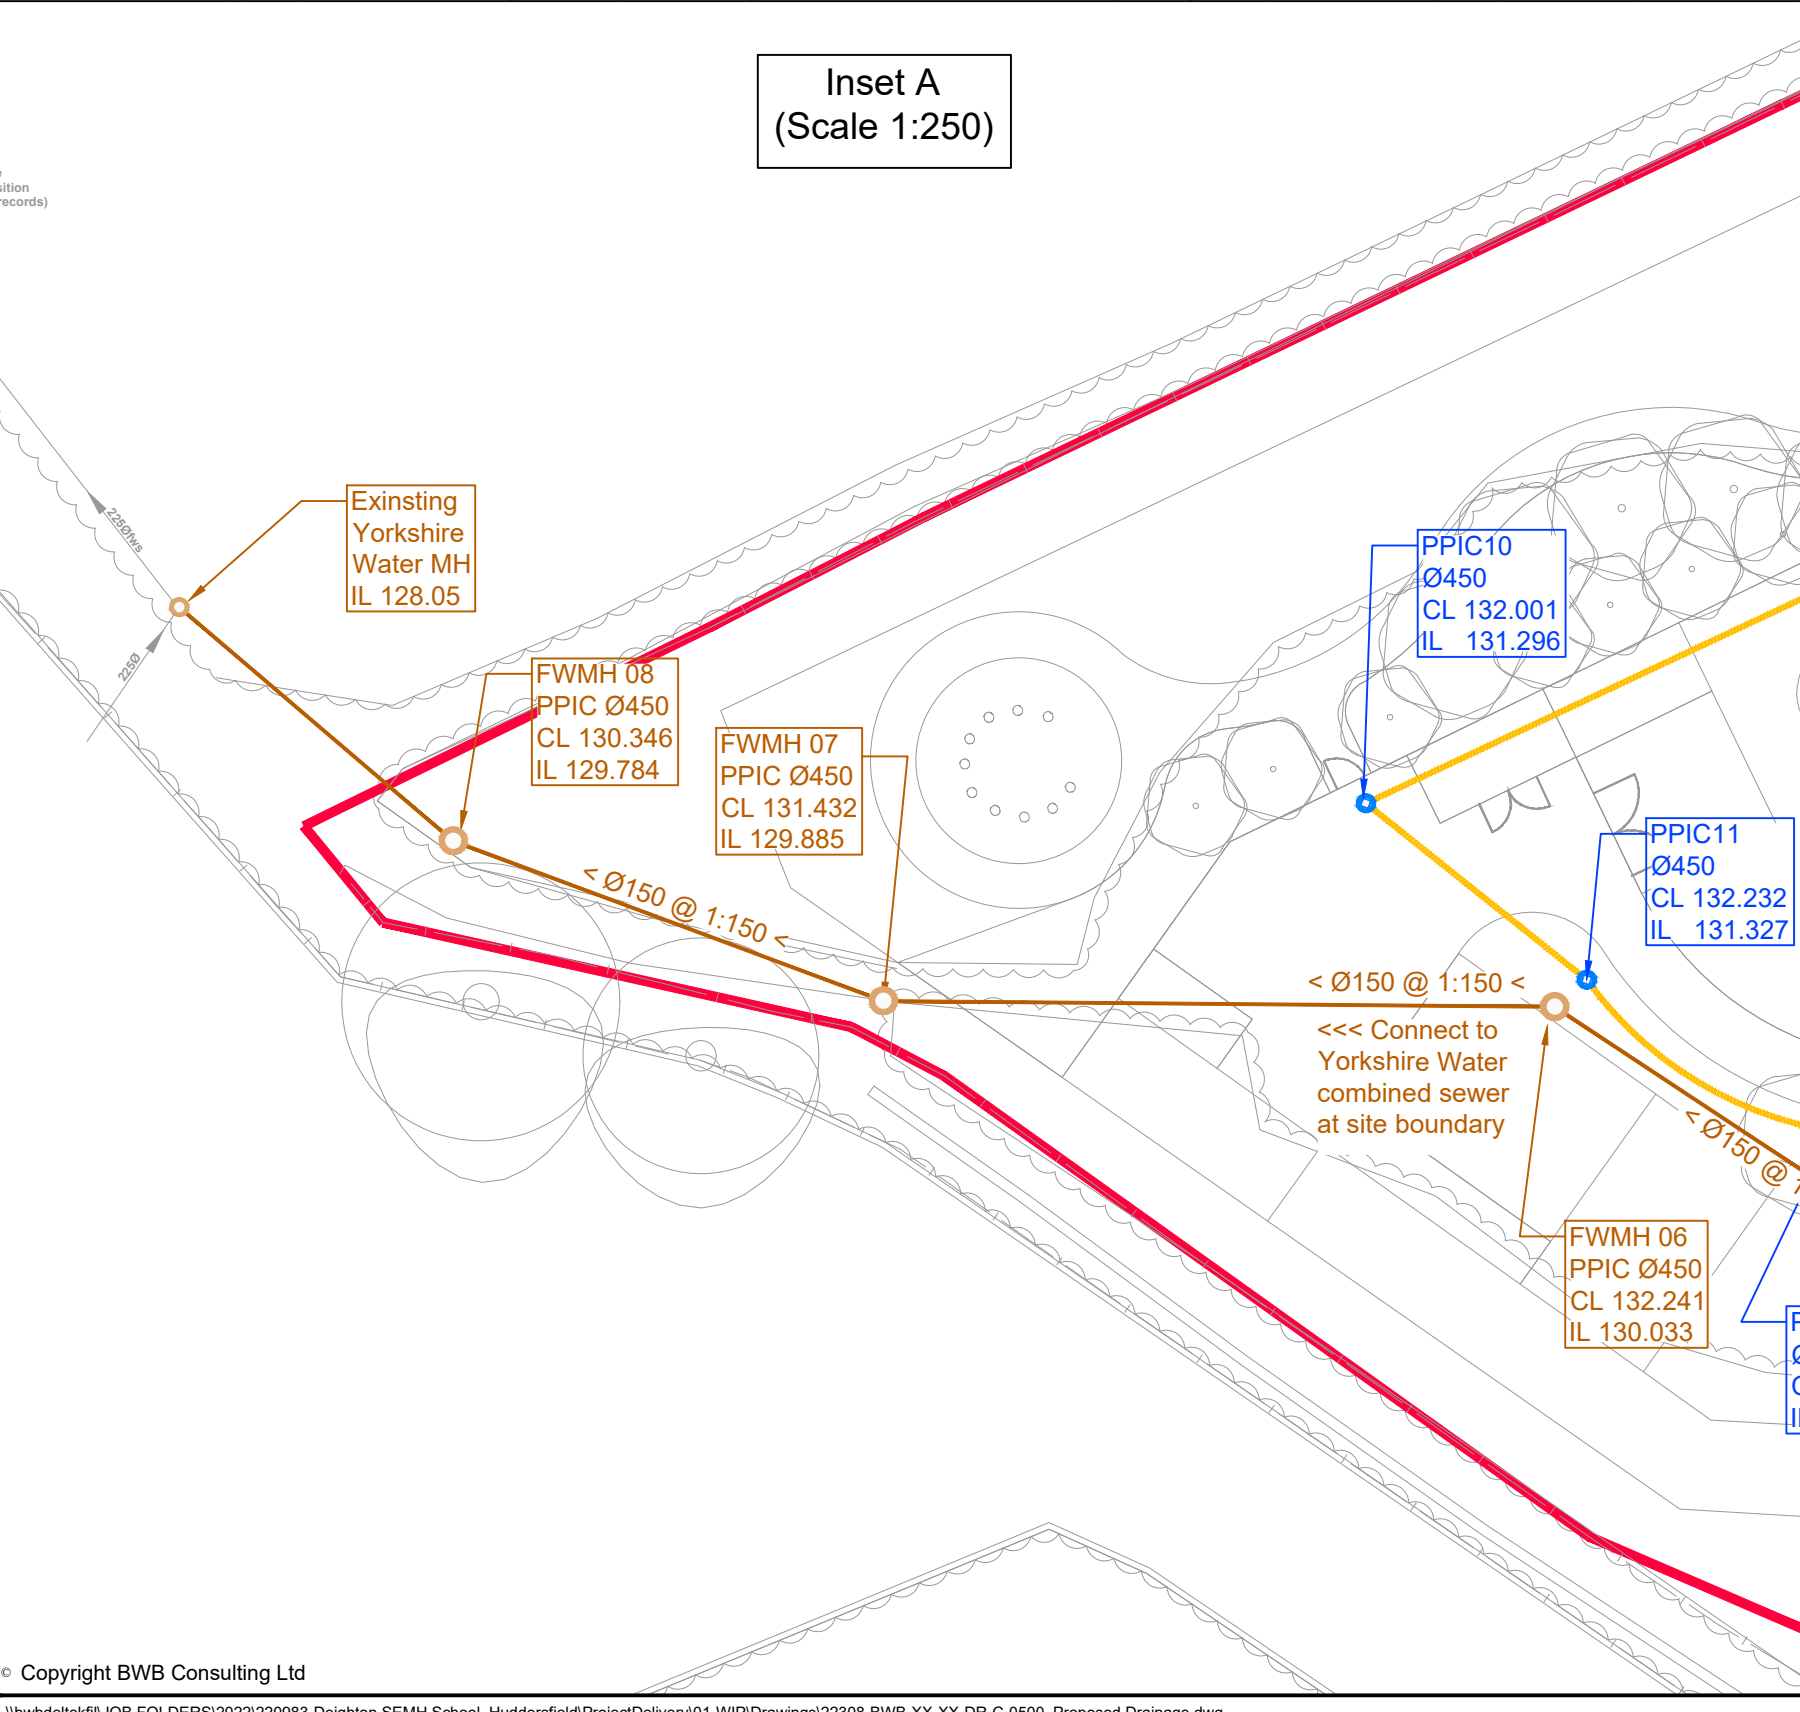


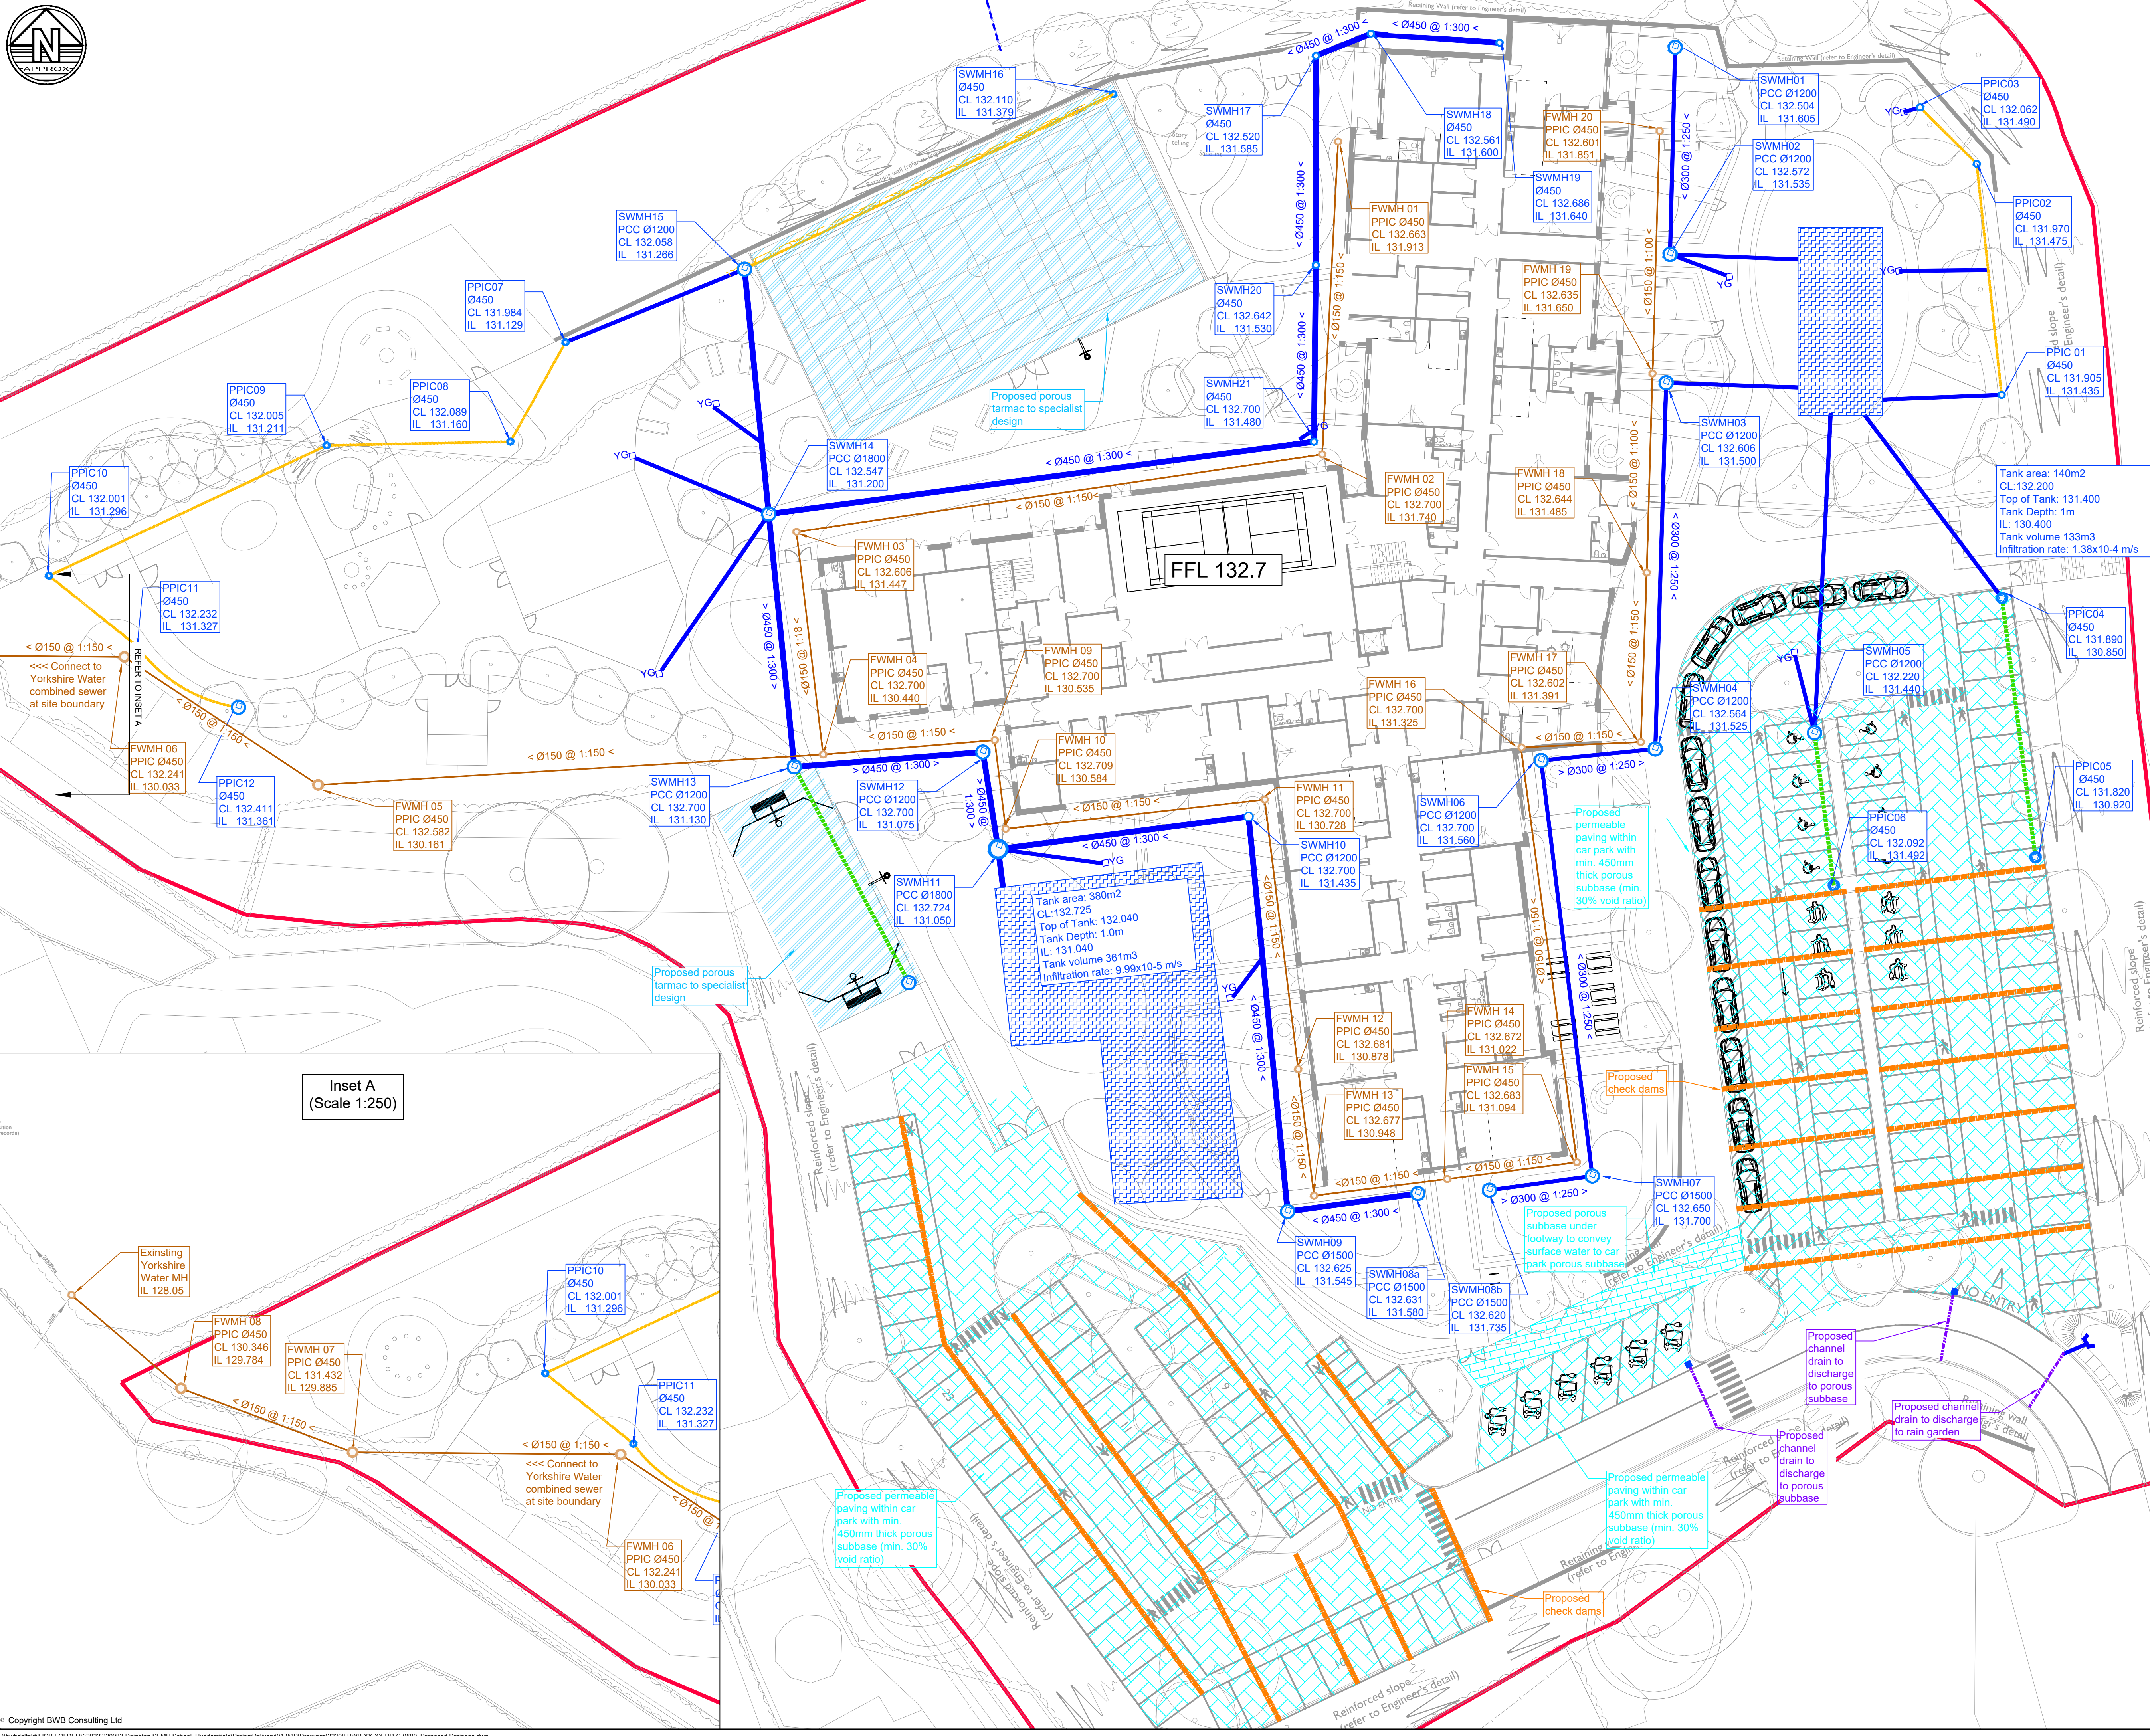

Notes

- Do not scale this drawing. All dimensions must be checked/ verified on site. If in doubt ask.
- This drawing is to be read in conjunction with all relevant architects, engineers and specialists drawings and specifications.
- All dimensions in millimetres unless noted otherwise. All levels in metres unless noted otherwise.
- Any discrepancies noted on site are to be reported to the engineer immediately.

Key Plan

Legend

- Proposed surface water
- Attenuation Cells
- Permeable Paving
- Porous Sub-base
- Channel Drains
- Perforated Pipes
- Proposed Foul Sewer Drainage
- Existing Drainage
- Filter Drain
- Gully

P4	26.09.23	Updated infiltration rate	DA	JB
P3	06.09.23	Updated to reflect soakaway discharge	GK	JB
P2	18.08.23	Updated Drainage Layout	GK	MR
P1	11.05.23	Preliminary Issue	DA	JB
Rev	Date	Details of issue / revision	Drw	Rev

Issues & Revisions

BWB
A CAF GROUP COMPANY

☐ Birmingham | 0121 233 3322
☐ Leeds | 0113 233 8000
☒ London | 020 7407 3879
☐ Manchester | 0161 233 4260
☐ Nottingham | 0115 924 1100
www.bwbconsulting.com

Client

Frank Shaw Architect

Project Title

Deighton SEMH School

Drawing Title

Proposed Drainage

Drawn:	D. Amrouni	Reviewed:	J. Benard
BWB Ref:	220983	Date:	11.05.23
Scale@A1:		1:250	

PRELIMINARY

Project - Originator - Zone - Level - Type - Role - Number	Status	Rev
22308-BWB-XX-XX-DR-C-0500	S2	P04