
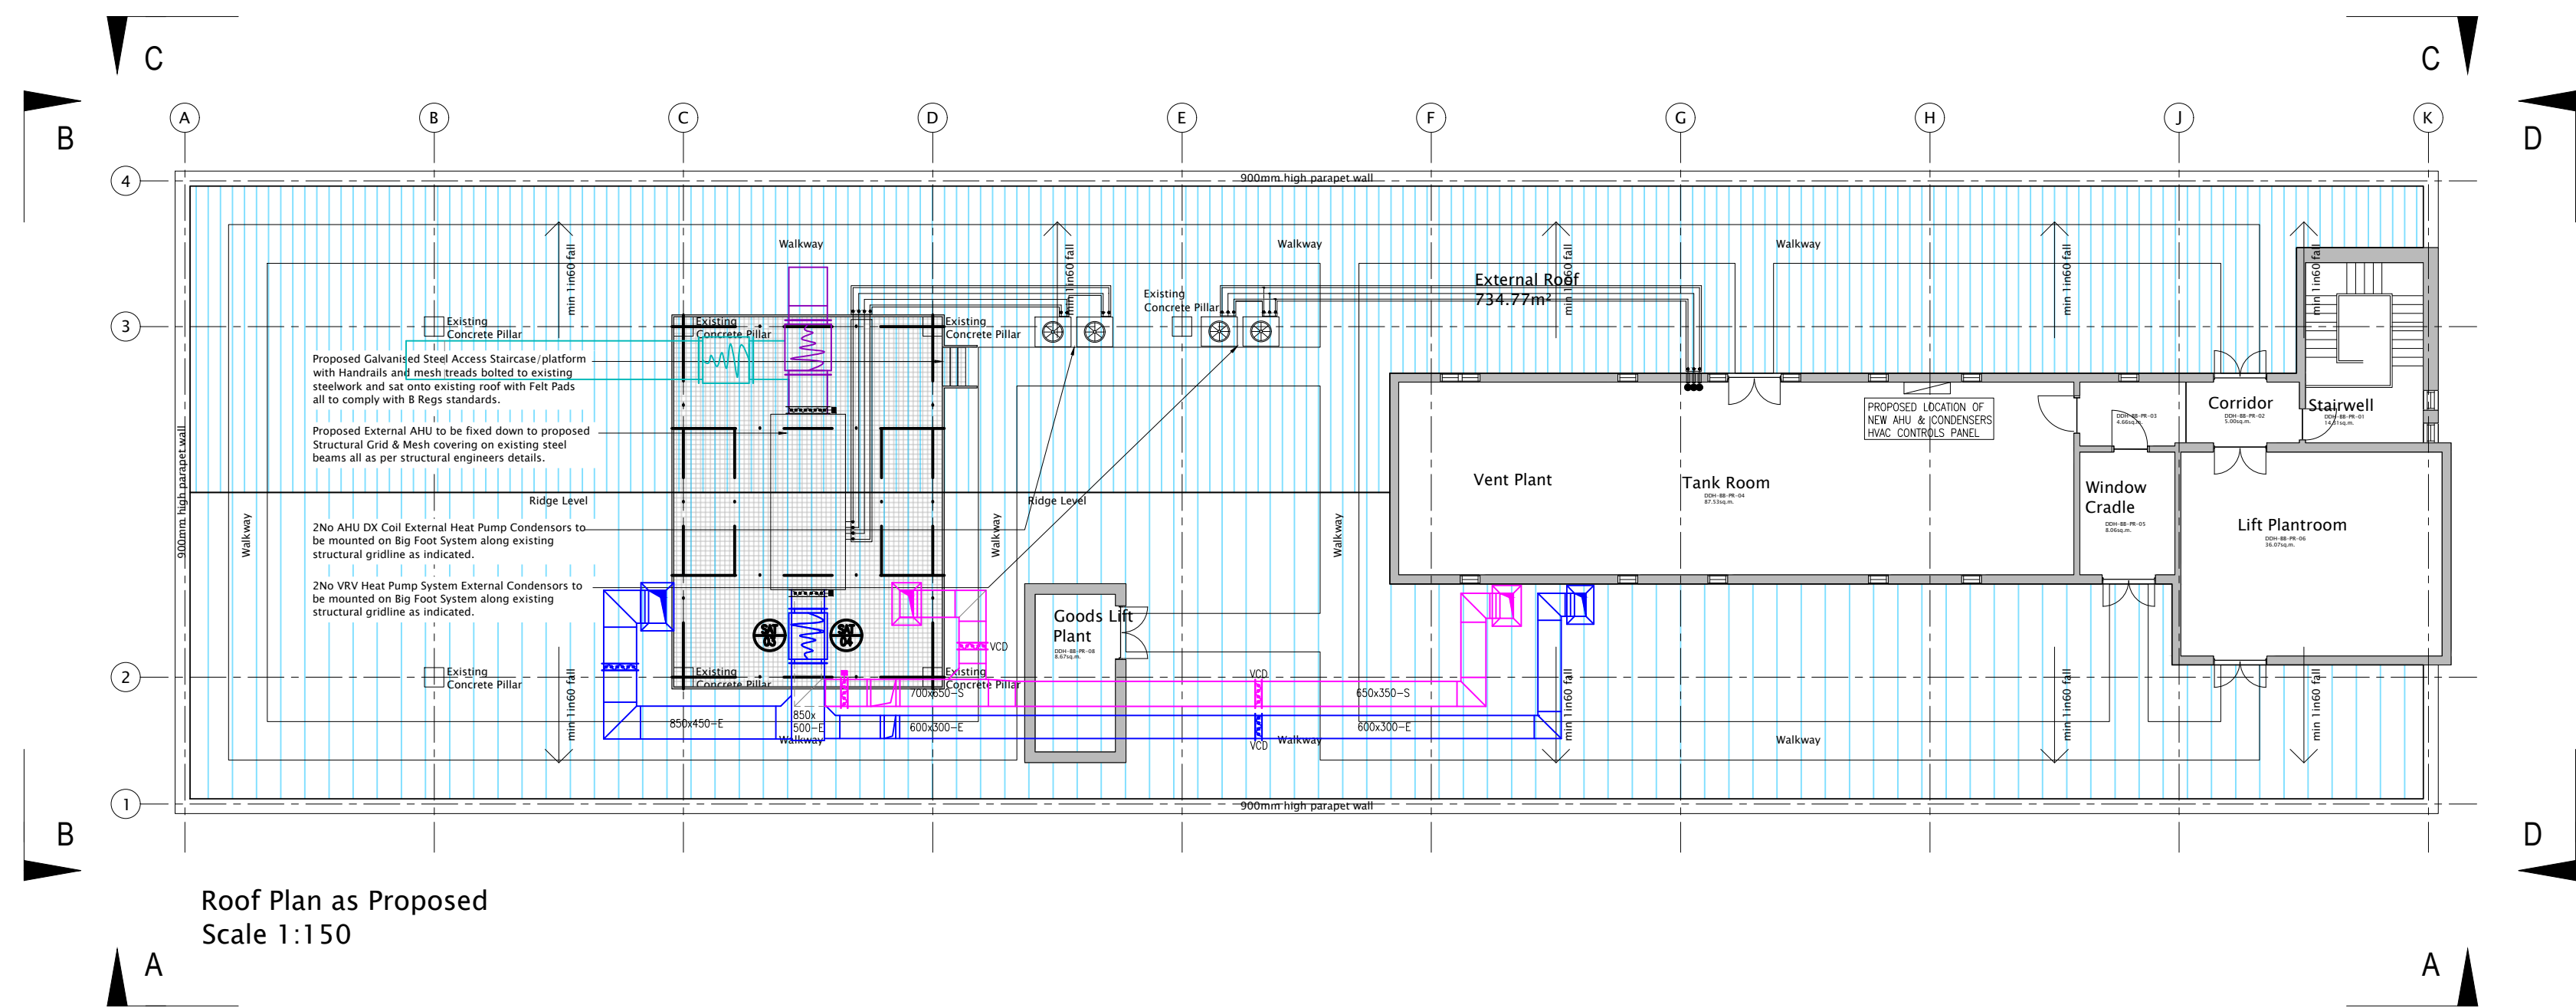
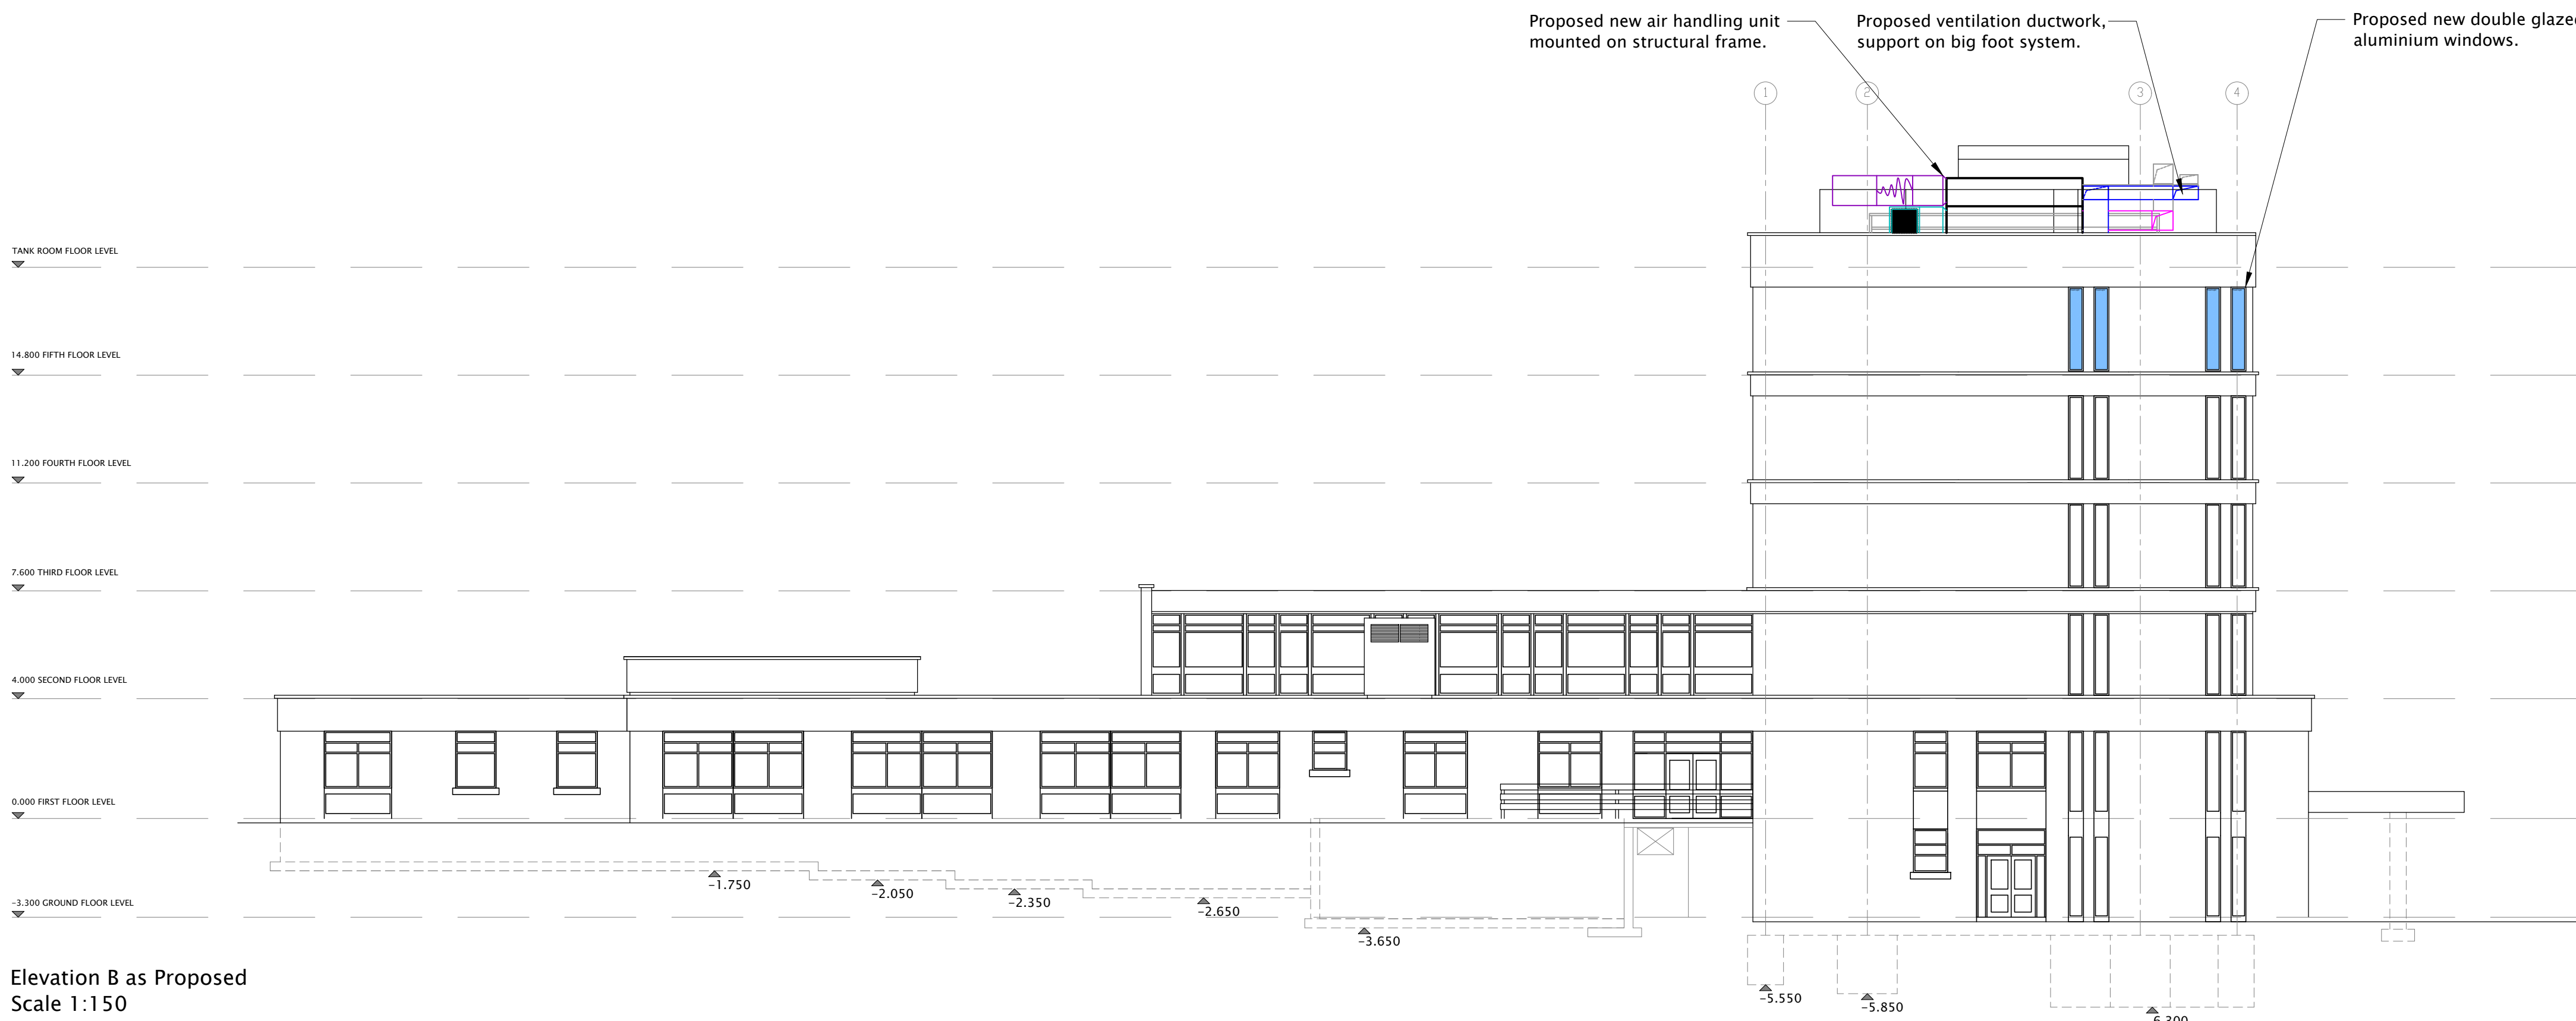


Notes
- Do not scale this drawing.
- All dimensions to be checked on site prior to construction.
- Designer to be notified of discrepancies in figured dimensions.
- This drawing is copyright to PMK Design Associates.

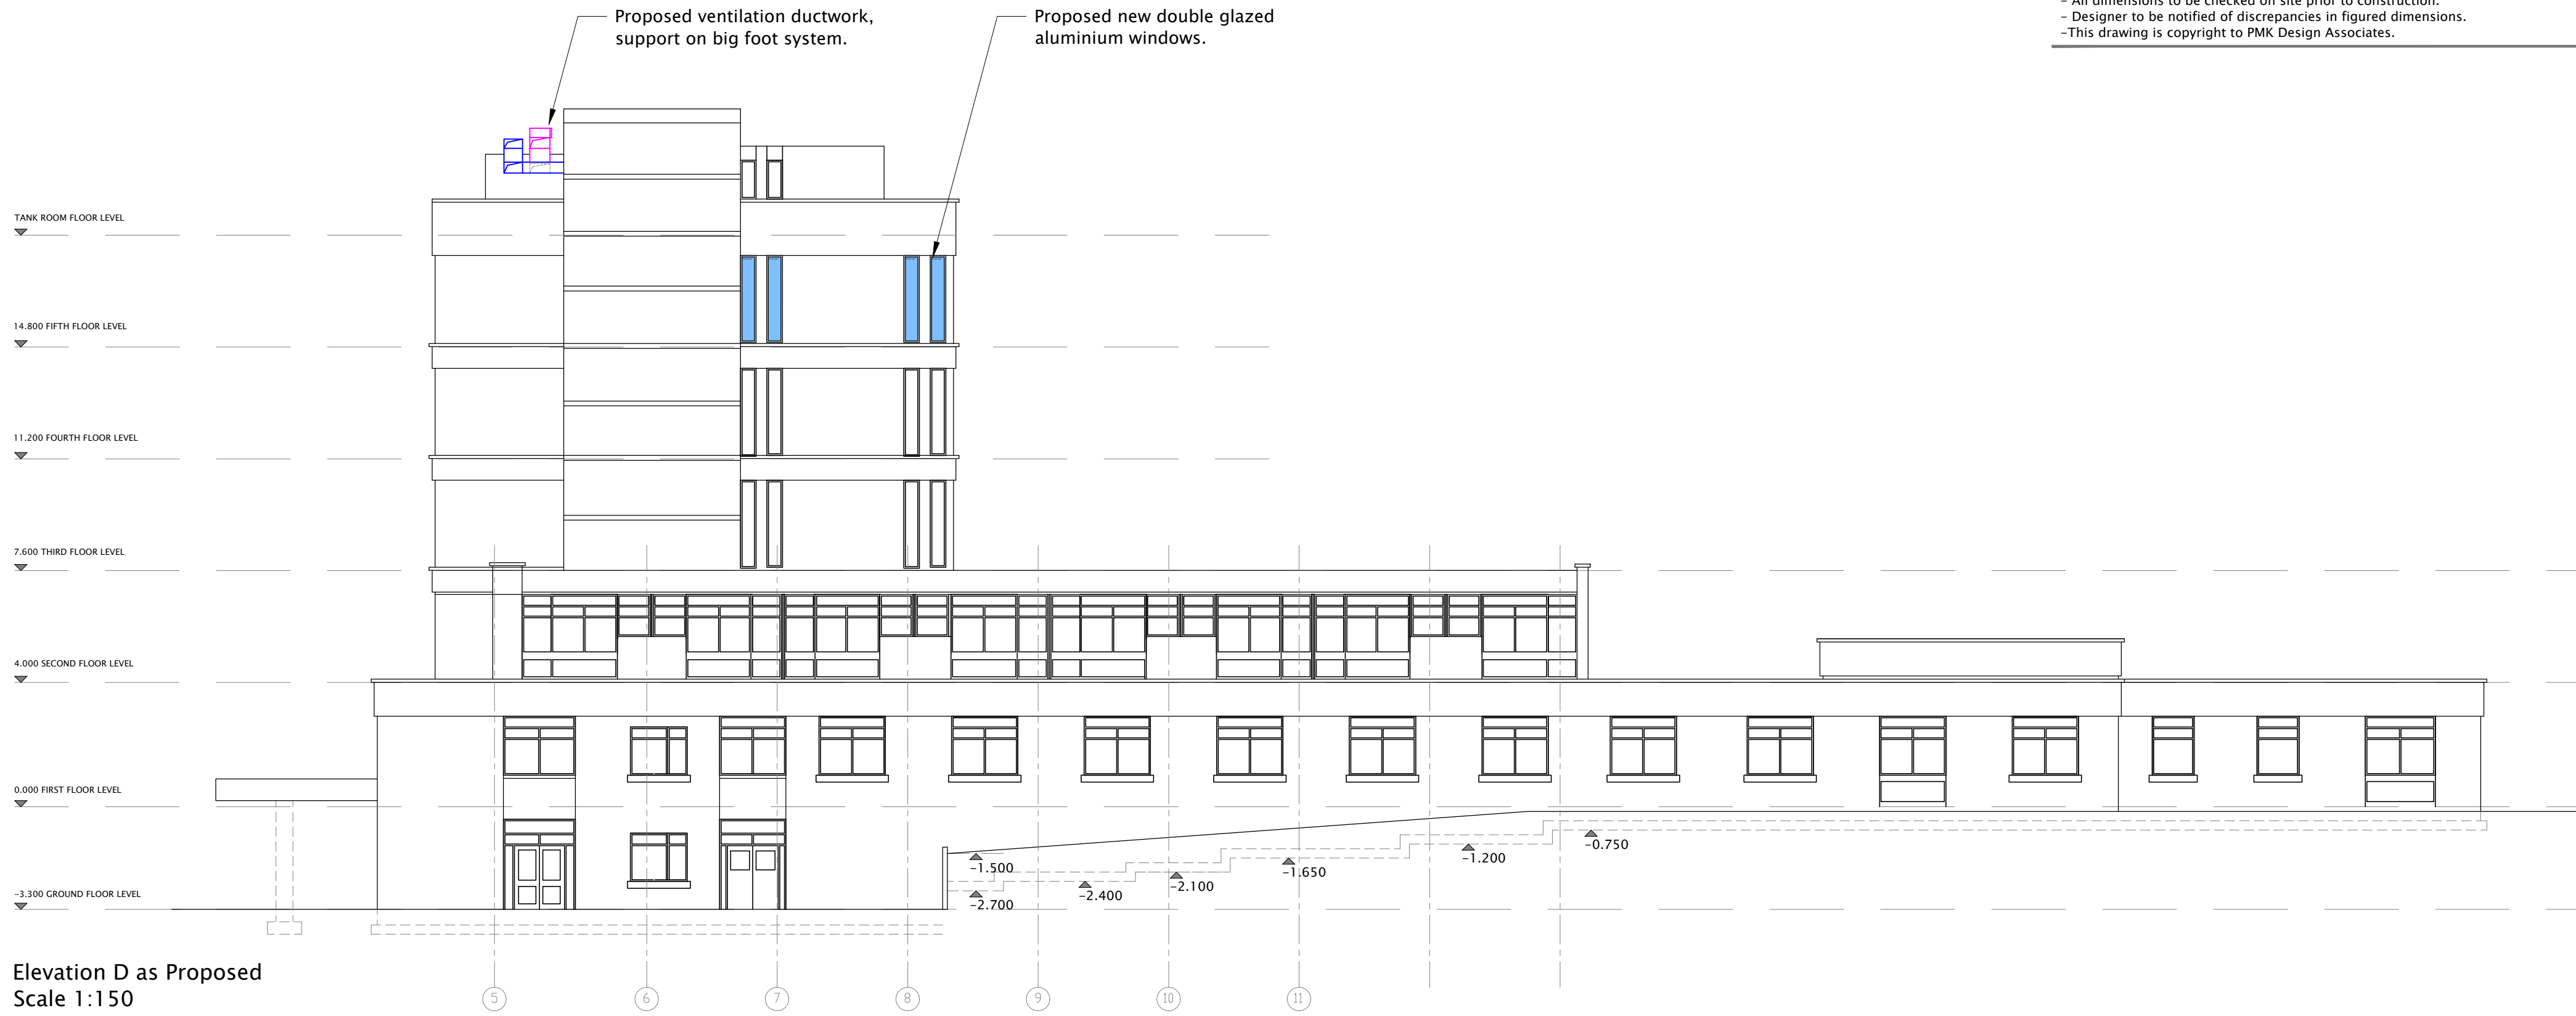

Rev.	Description	Date
1	Planning	
2		
3		
4		
100		

Client: The Mid Yorkshire Hospitals NHS Trust

Project Title: Collocation of ICT Services to Bronte Tower, Fifth Floor, Dewsbury & District Hospital

Drawing Title: Sixth Floor/Roof Plan Plant Room Elevations as Proposed

Date: 31.01.24 Scale: 1:150 Sheet: A0

Project No: 23002 Drawing No: [10] 06 Revision: A

Entrance 3, HCC, Kings Road, Harrogate, HG1 5LA
Tel: 01423 790 146 - Fax: 01423 790 227
Email: info@pmkdesignassociates.com

pmk design associates