


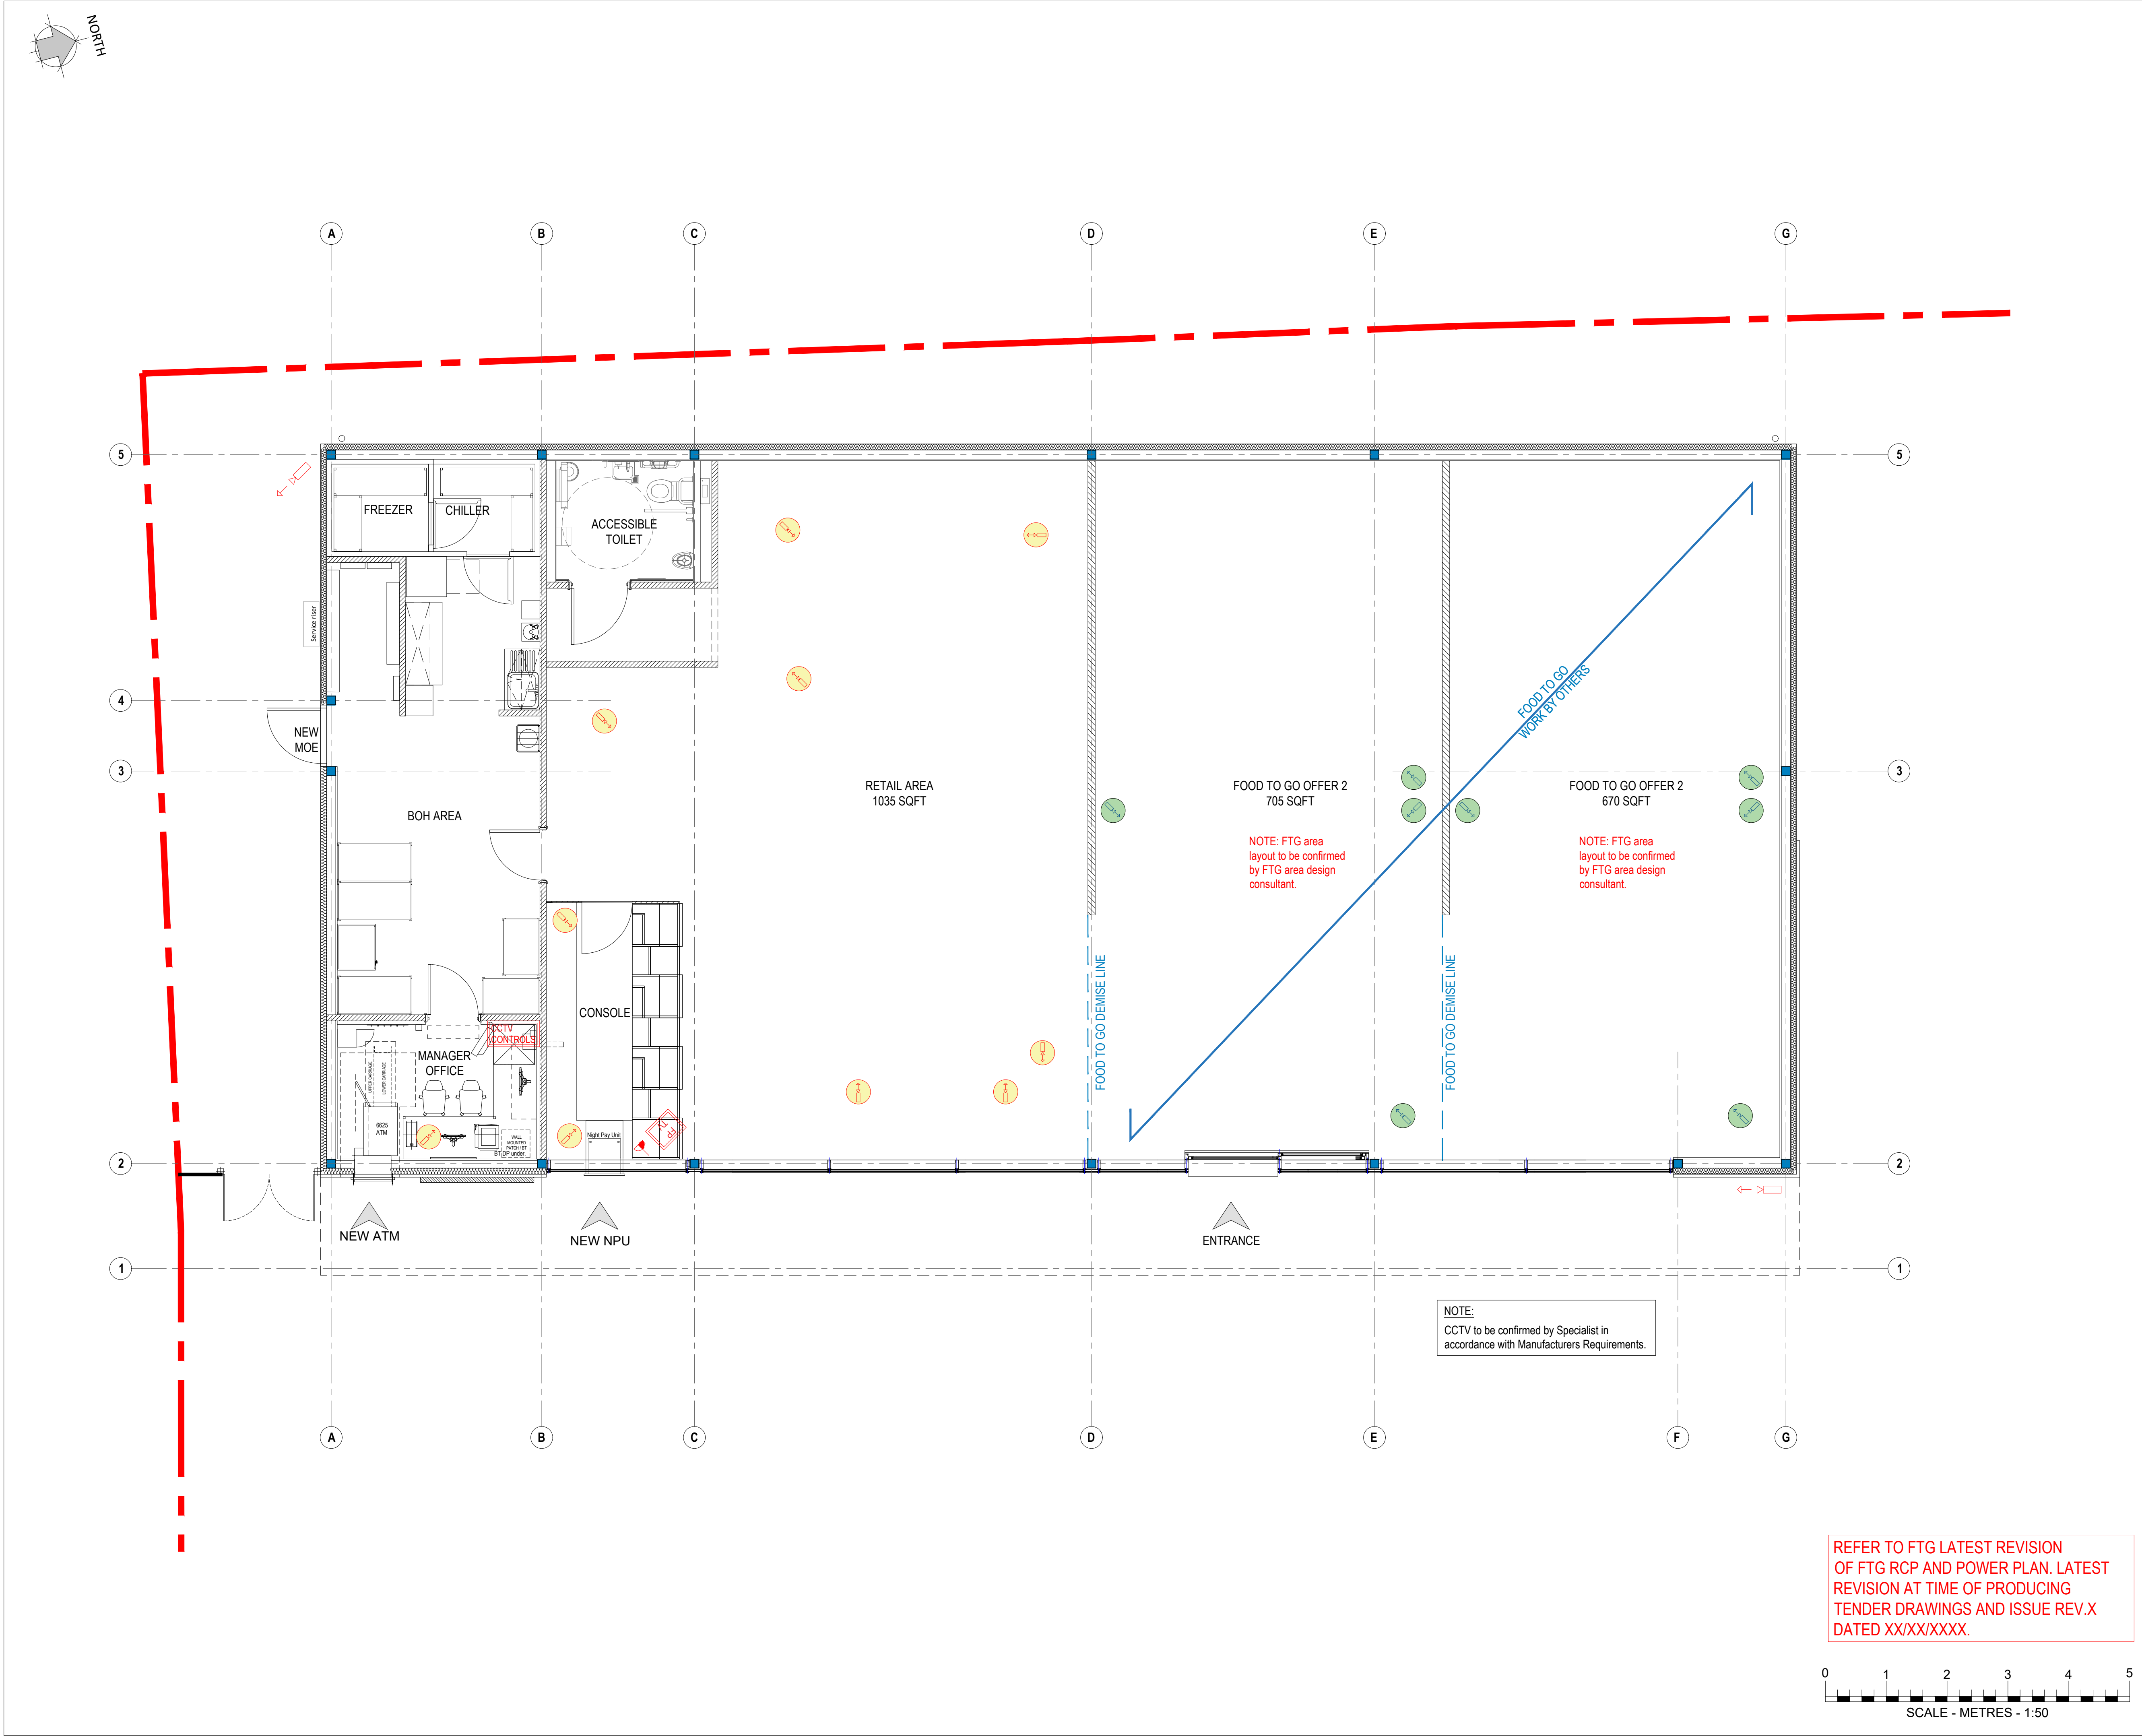

COPYRIGHT ©
This drawing and the details herein are the copyright of MBH Design Studio Ltd. and must not be reproduced, altered or passed to any third party without prior written consent.

This drawing has been produced for the project listed below, is submitted in support of this application application to the Local Planning Authority and is not intended for use by any other person or for any other purpose.

Every effort has been made to ensure the accuracy of these drawings, however MBH Design Studio Ltd. accept no responsibility for any discrepancies arising from the reuse of survey information and preliminary drawings commissioned by the Applicant from others.

INTERNAL CCTV

-  FP TV Monitor
-  CCTV Control Unit
-  4 x Internal dome cameras (Pret) - 2 MP
-  10 x Internal dome cameras (Shop) - 2 MP

4 x Bullet Cameras - 5 MF

REV	DATE	DESCRIPTION	DRAWN/CHECKED
DRAWING NOTES			
PLANNING  MBH Design Studio Ltd. Rosemount House, Rosemount Avenue, West Byfleet, Surrey, KT14 6LB www.mbhLtd.com t: 01932 352 727 f: 01932 351 545			
CLIENT 			
PROJECT FS670 - SALENDINE SERVICE STATION NEW HEY ROAD, HUDDERSFIELD, HD3 3UZ			
DRAWING TITLE PROPOSED CCTV LAYOUT			
DRAWN BY	DATE	SCALE	PAPER SIZE
JP	20.11.2023	1:50	A1
CHECKED BY	DRAWING NUMBER		REV.
ES	13539-312		