
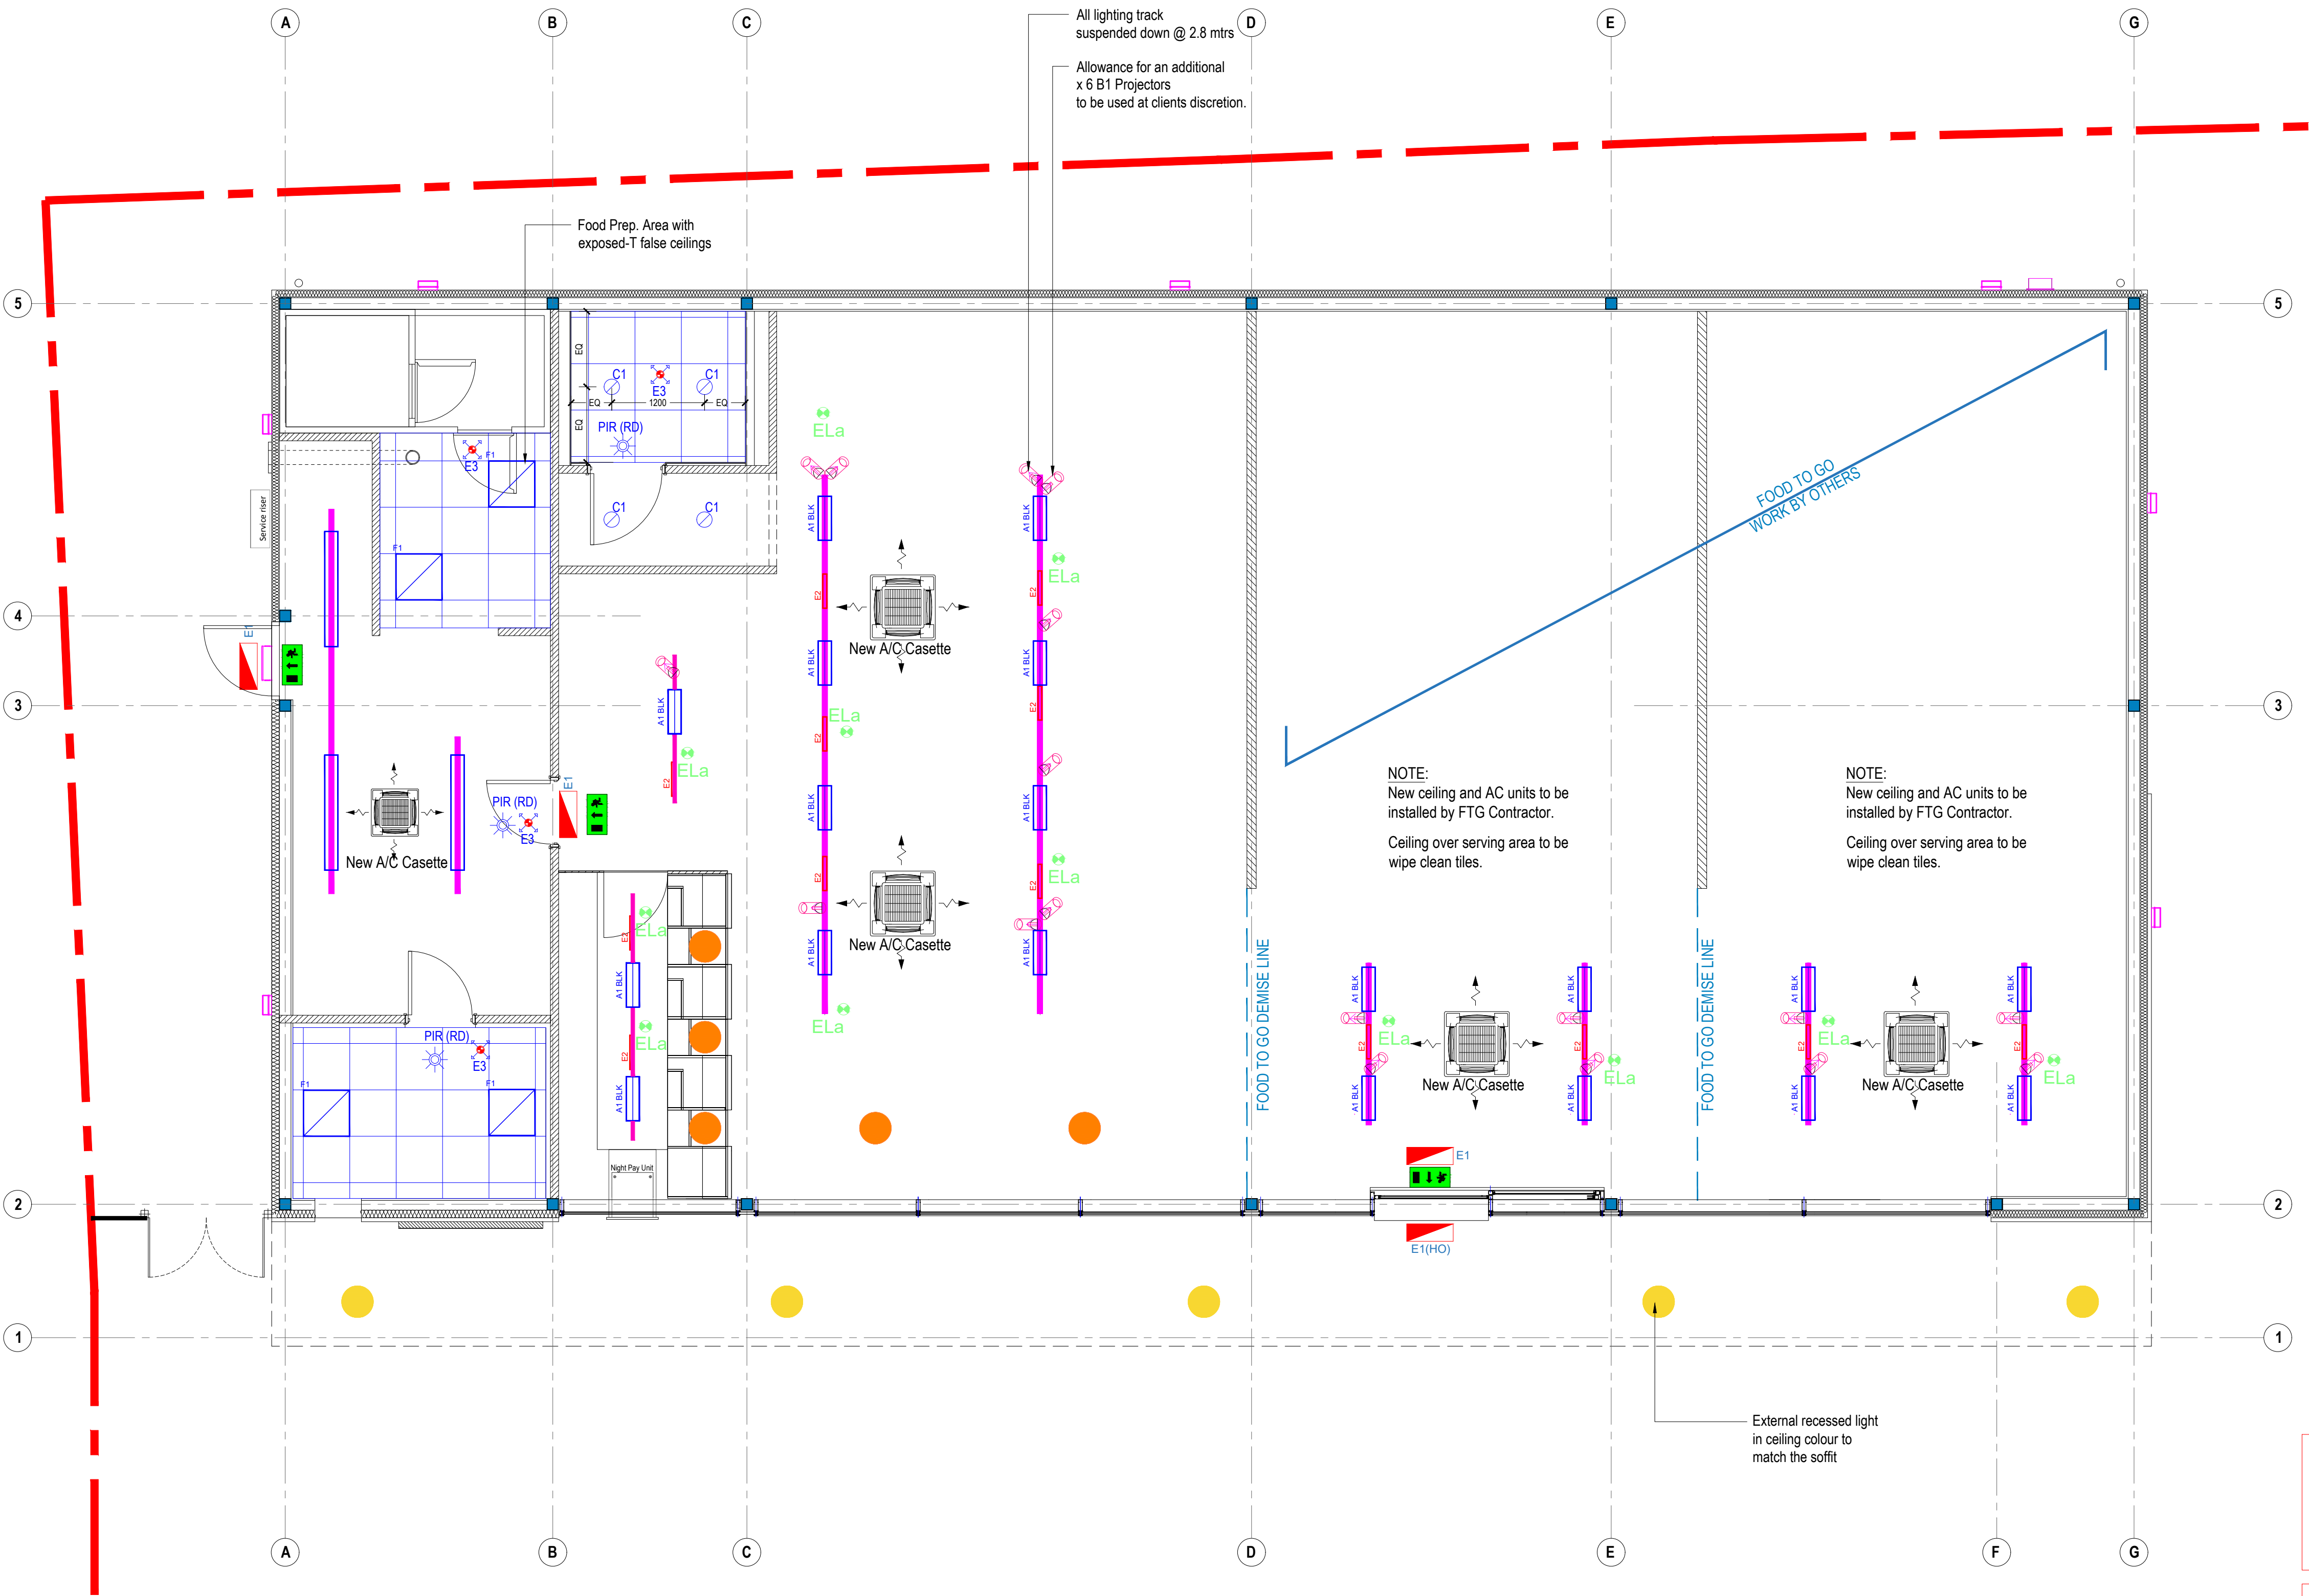


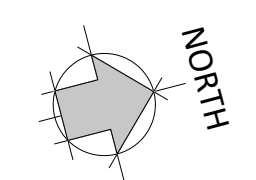

TYPE	DESCRIPTION
STORESET BLACK (TRACK MOUNTED)	
A1 BLK	StoreSet SMS605T 1 X LED66S/840 PSD WB BK A LED 46 watt 575X184mm 4000K (cool white) Wide Beam. Fitting Dali, Track Mounted. Finish Black.
GREENSPACE BLACK ACCENT PROJECTOR	
	GreenSpace Mini Accent Projector ST315T 1xLED27S/830 PSU FR36 BLK Track Mounted (3000K) Wide Beam Projector. Finish Black.
DALI TRACK BLACK	
	Track run
SOLOS PENDANT	
	Pendent Lights
CORELINE RECESSED	
F1	Recessed light to MFG specifications. A 36 watt 600mm x 600mm Recessed 4000K (cool white) LEDs and push in connection.
EMERGENCY STANDALONE	
Optional	Emergency Bulkhead (With Optional Running Man Legend) BKD EM LED SIGN 2.5W LED 3-Hr Maintained or Non-Maintained Emergency Bulkhead 350mm Long x 108mm Wide Fixture.
E3	1.8w LED 80mm Dia 3-hour non-maintained recessed emergency LED head (cut-out 66mm). Stand-alone emergency lighting head for use in open areas corridors.
E2	
ELa	
PIR (RD)	OccuSwitch (Recessed) LRM1070/00 SENSR MOVDET ST LRM1070 Ceiling mounting Box PIR Automatic Switch Surface Mounted
	External / Internal emergency over door light
EXTERNAL	
	External Wall Mounted LED Light

GENERAL NOTES:

Sales Floor Track Mounting Height = 2.8Mtrs

Lighting to be ordered by electrician direct from suppliers

Tracks for lighting to be run across retail & FTG spaces. / underside

Underside of lighting to run in line with top of pelments


Panel lights to be used for general lighting, spaced evenly along the track as per lighting plan.

Spotlights to be used to highlight specific areas/features.

Pendent lights to run in a line from entrance to counter and one pendant over each till point at a height of 2.4m from FFL

REFER TO GREGGS LATEST REVISION OF GREGGS RCP AND POWER PLAN. LATEST REVISION AT TIME OF PRODUCING TENDER DRAWINGS AND ISSUE REV.X DATED XX/XX/XXXX.

NOTE: THE UNISTRUT CHANNEL WITH CLIP ON LID WILL BE REQUIRED AT VARIOUS LOCATIONS FOR ROUTING CABLES FROM THE FRONT TO THE BACK OF THE SHOP SALES AREA.

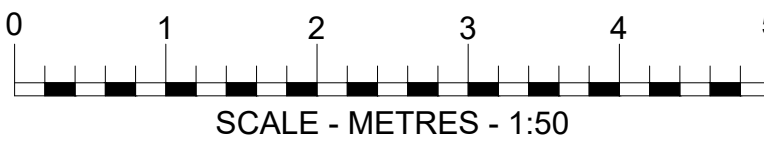

DRAWING NOTES

COPYRIGHT ©

This drawing and the details herein are the copyright of MBH Design Studio Ltd. and must not be reproduced, altered or passed to any third party without prior written consent.

This drawing has been produced for the project listed below, is submitted in support of this application application to the Local Planning Authority and is not intended for use by any other person or for any other purpose.

Every effort has been made to ensure the accuracy of these drawings, however MBH Design Studio Ltd. accept no responsibility for any discrepancies arising from the reuse of survey information and preliminary drawings commissioned by the Applicant from others.

Solos pendant light by Haeel
Fluettin lighting see appendix 6 of MFG spec

Green Accent projector light by Philips lighting
see appendix 6 of MFG spec

Storeset light by Philips lighting
see appendix 6 of MFG spec

REV	DATE	DESCRIPTION	DRAWN/CHECKED
REVISION NOTES			
PLANNING MBH Design Studio Ltd. Rosemount House, Rosemount Avenue, West Byfleet, Surrey, KT14 6LB www.mbhstudio.com t: 01932 352 727 f: 01932 351 545			
CLIENT			
motor fuel group			
PROJECT			
FS670 - SALENDINE SERVICE STATION NEW HEY ROAD, HUDDERSFIELD, HD3 3UZ			
DRAWING TITLE			
LIGHTING LAYOUT			
DRAWN BY	DATE	SCALE	PAPER SIZE
JP	20.11.2023	1:50	A1
CHECKED BY	DRAWING NUMBER	REV.	
ES	13539-309	-	