
 


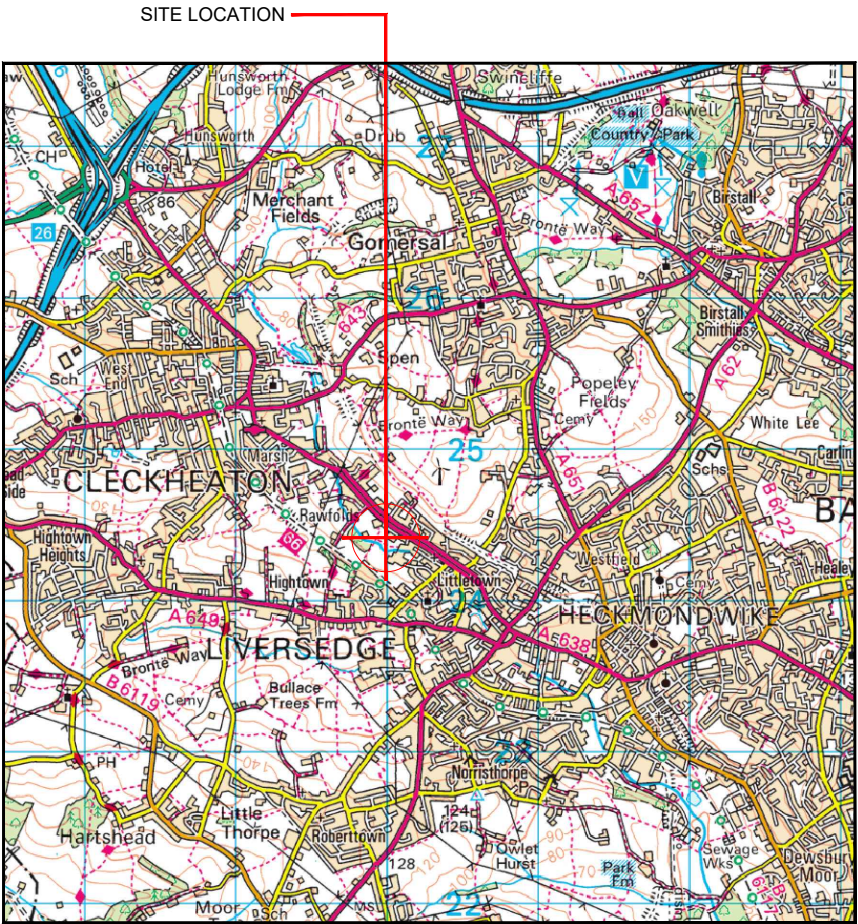

Reproduced by permission of Ordnance Survey on behalf of the Controller of Her Majesty's Stationery Office All rights reserved. © Crown Copyright licence no. 0100031673

SITE AREA PLAN

Scale 1:50,000




SITE PHOTOGRAPH



SITE LOCATION

HINGED ENTRANCE / EXIT BARRIERS SET AT 2.1m CLEARANCE

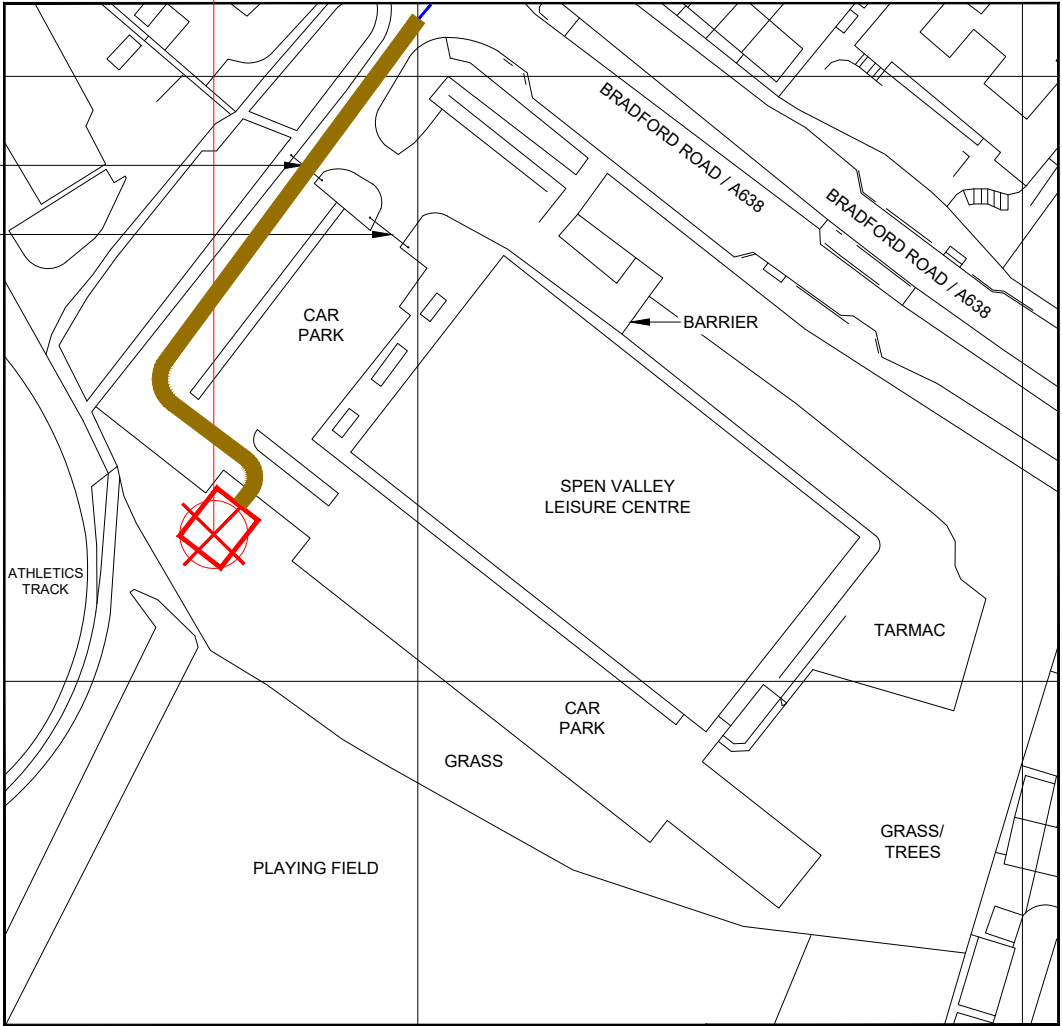


Reproduced by permission of Ordnance Survey on behalf of the Controller of Her Majesty's Stationery Office. All rights reserved. © Crown Copyright licence no. 0100031673

NGR E: 419967 N: 424425

SITE LOCATION PLAN

 Scale 1:1250



GOOGLE MAPS QR CODE

GOOGLE MAP - Hyperlink to map of the site

GOOGLE STREETVIEW - Hyperlink to streetview of the site

NOTES:

1. ALL DIMENSIONS IN MM UNLESS OTHERWISE NOTED.

From the M62 junction 26 take the A638 towards Liversedge. The leisure centre access road is on the right hand side after 2.9km. The site is located straight ahead on the grass at the rear of the car park.

Outline of Proposed Compound:
Access Route To Site:
Access Route:



Master:	MBNL / EE / H3G:	Project:	Purpose of Issue:	Issue:
M001	MBNL	NTQ	Planning	A
Date:	28/03/24	Revision / Upgrade Description:		
Drawn:	J. BOOTE	First Issue		
Checked:	J. STOCKDALE			
Approved:	G. JENNINGS			



Hutchison 3G UK Limited
Green Park, 450 Longwater Avenue,
Reading, RG30 3UR
Tel: 01628 765 000



Hatfield Business Park
Hatfield
Hertfordshire
AL10 9BW
Tel: 01707 315000
Fax: 01707 319001



Mobile Broadband Network Limited
Sixth Floor, Thames Tower, Station Road, Reading, RG1 1LX


Design Consultant & Principal Contractor:




WHP Telecoms
Unit 1 Maple Park,
Low Fields Avenue, Leeds
LS12 6HH

Tel: 01133023550
e-mail: info@whptelecoms.com

Site Name:	SPEN VALLEY LEISURE CENTRE		
Site ID:	1687719		
Address:	SPEN VALLEY LEISURE CENTRE, BRADFORD ROAD, LIVERSEDGE, WEST YORKSHIRE, WF15 6LW		
Title:	002 SITE LOCATION PLAN		
Project:	NTQ		
Purpose of Issue:	GENERAL ARRANGEMENT		
EE Cell ID:	MBNL Cell ID:	3UK Cell ID:	
96591	KKS266	WF0874	
Master Drawing No:			Issue:
1687719_KKS266_96591_WF0874_M001			A

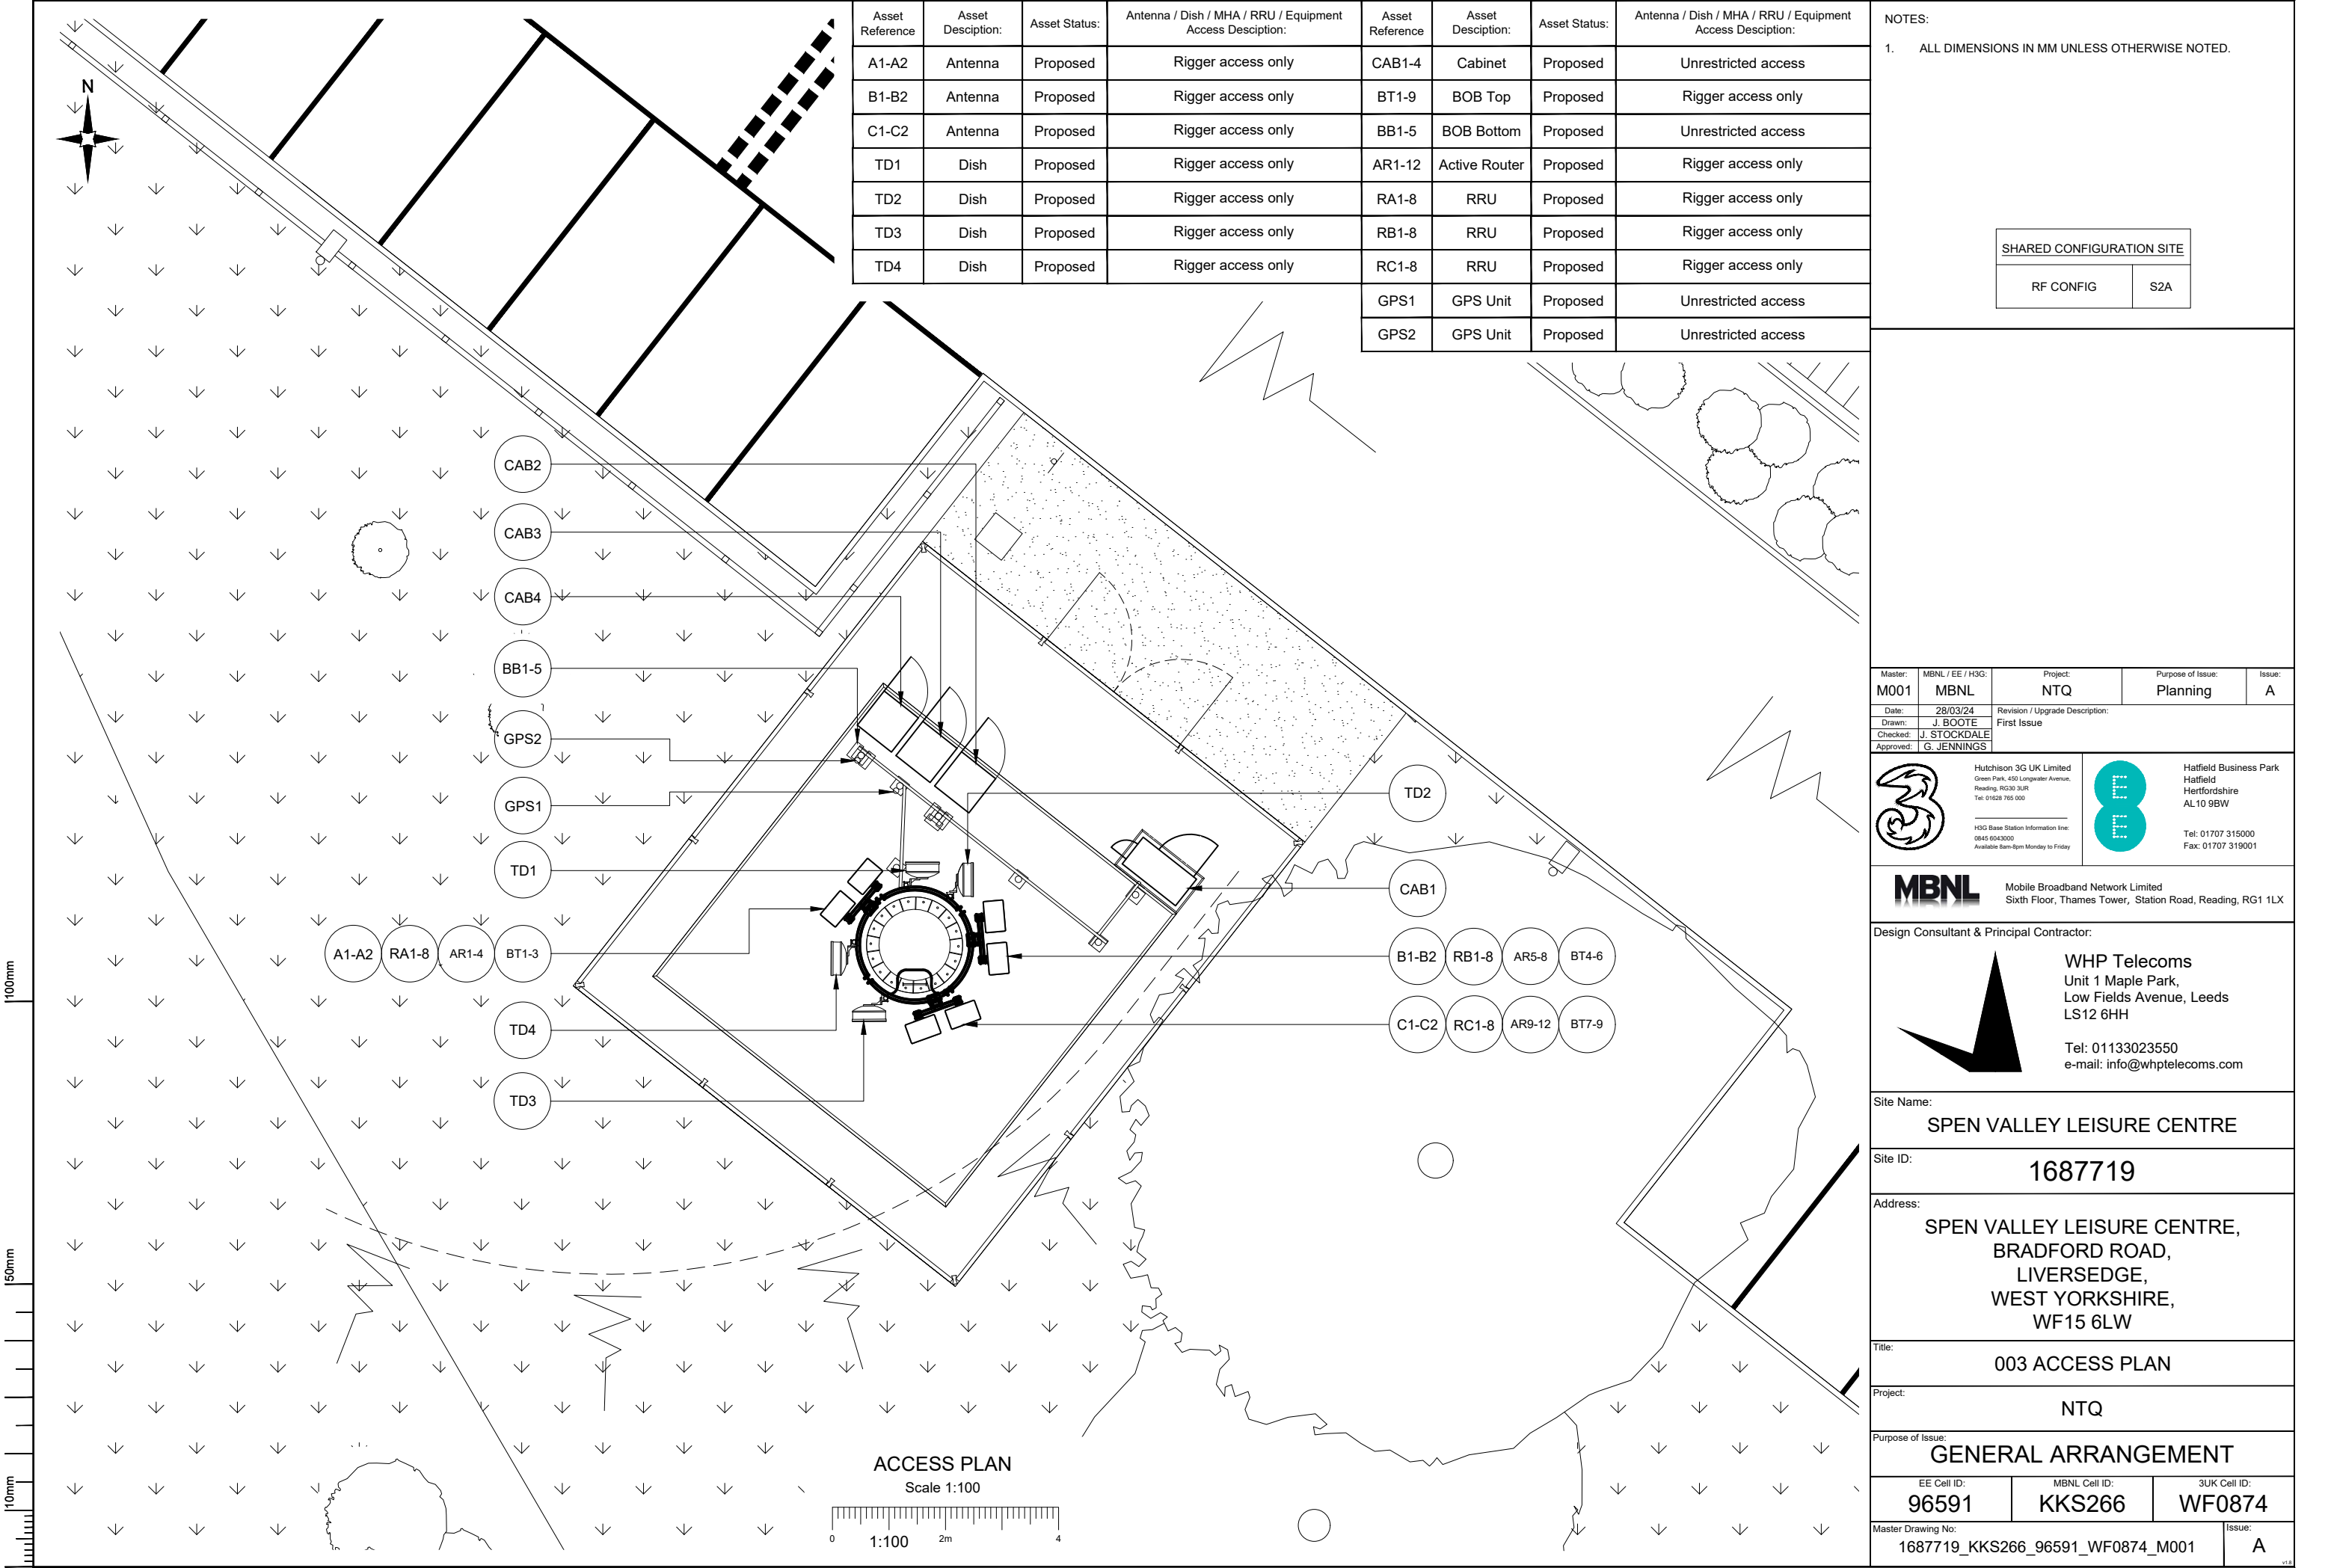

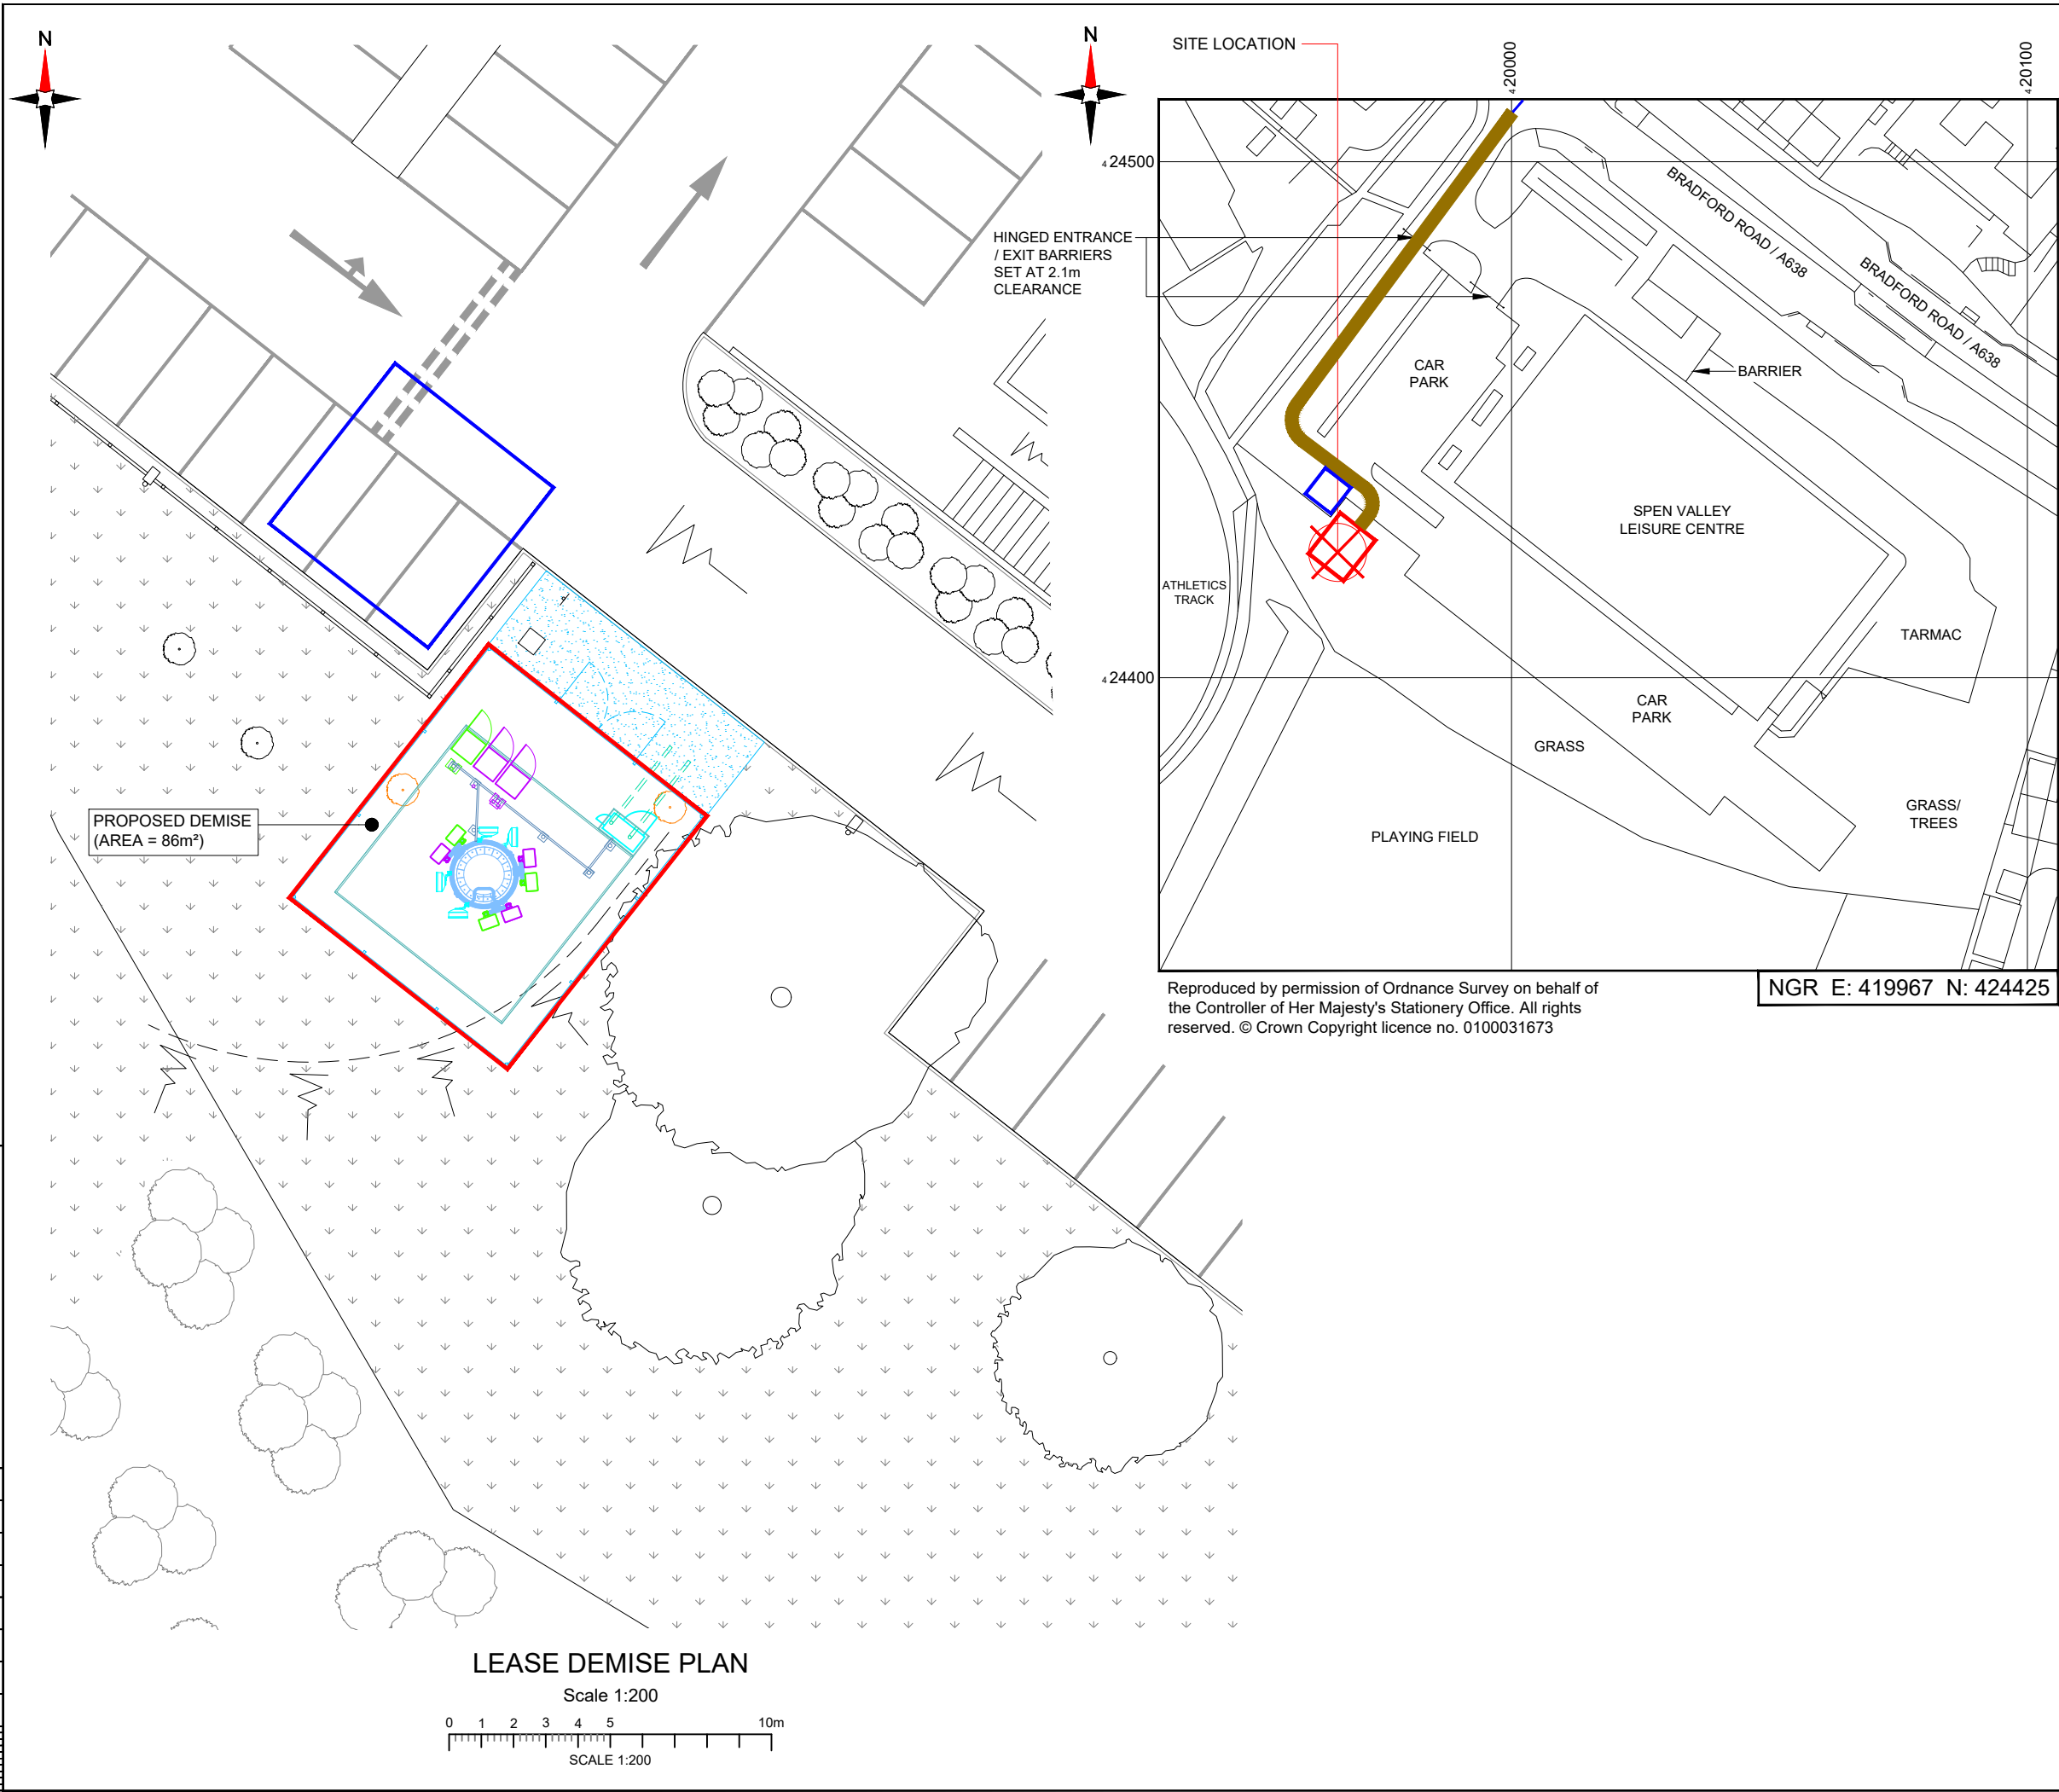

NEW CODE:

Demise: Outlined in Red

Access Route: Solid Brown

Set Down Area: Outlined in Blue

Master: M001	MBNL / EE / H3G: MBNL	Project: NTQ	Purpose of Issue: Planning	Issue: A
Date: 28/03/24	Drawn: J. BOOTE	Revision / Upgrade Description: First Issue		
Checked: J. STOCKDALE	Approved: G. JENNINGS			

Hutchison 3G UK Limited
Green Park, 450 Longwater Avenue,
Reading, RG30 3UR
Tel: 01628 765 000

H3G Base Station Information line:
0845 6043000
Available 8am-8pm Monday to Friday

Hatfield Business Park
Hatfield
Hertfordshire
AL10 9BW

Tel: 01707 315000
Fax: 01707 319001

MBNL Mobile Broadband Network Limited
Sixth Floor, Thames Tower, Station Road, Reading, RG1 1LX

Design Consultant & Principal Contractor:

WHP Telecoms
Unit 1 Maple Park,
Low Fields Avenue, Leeds
LS12 6HH

Tel: 01133023550
e-mail: info@whptelecoms.com

Site Name:

SPEN VALLEY LEISURE CENTRE

Site ID:

1687719

Address:

**SPEN VALLEY LEISURE CENTRE,
BRADFORD ROAD,
LIVERSEDGE,
WEST YORKSHIRE,
WF15 6LW**

Title:

004 LEASE DEMISE

Project:

NTQ


Purpose of Issue:

GENERAL ARRANGEMENT

EE Cell ID: 96591	MBNL Cell ID: KKS266	3UK Cell ID: WF0874
-----------------------------	--------------------------------	-------------------------------

Master Drawing No:
1687719_KKS266_96591_WF0874_M001

Issue:
A

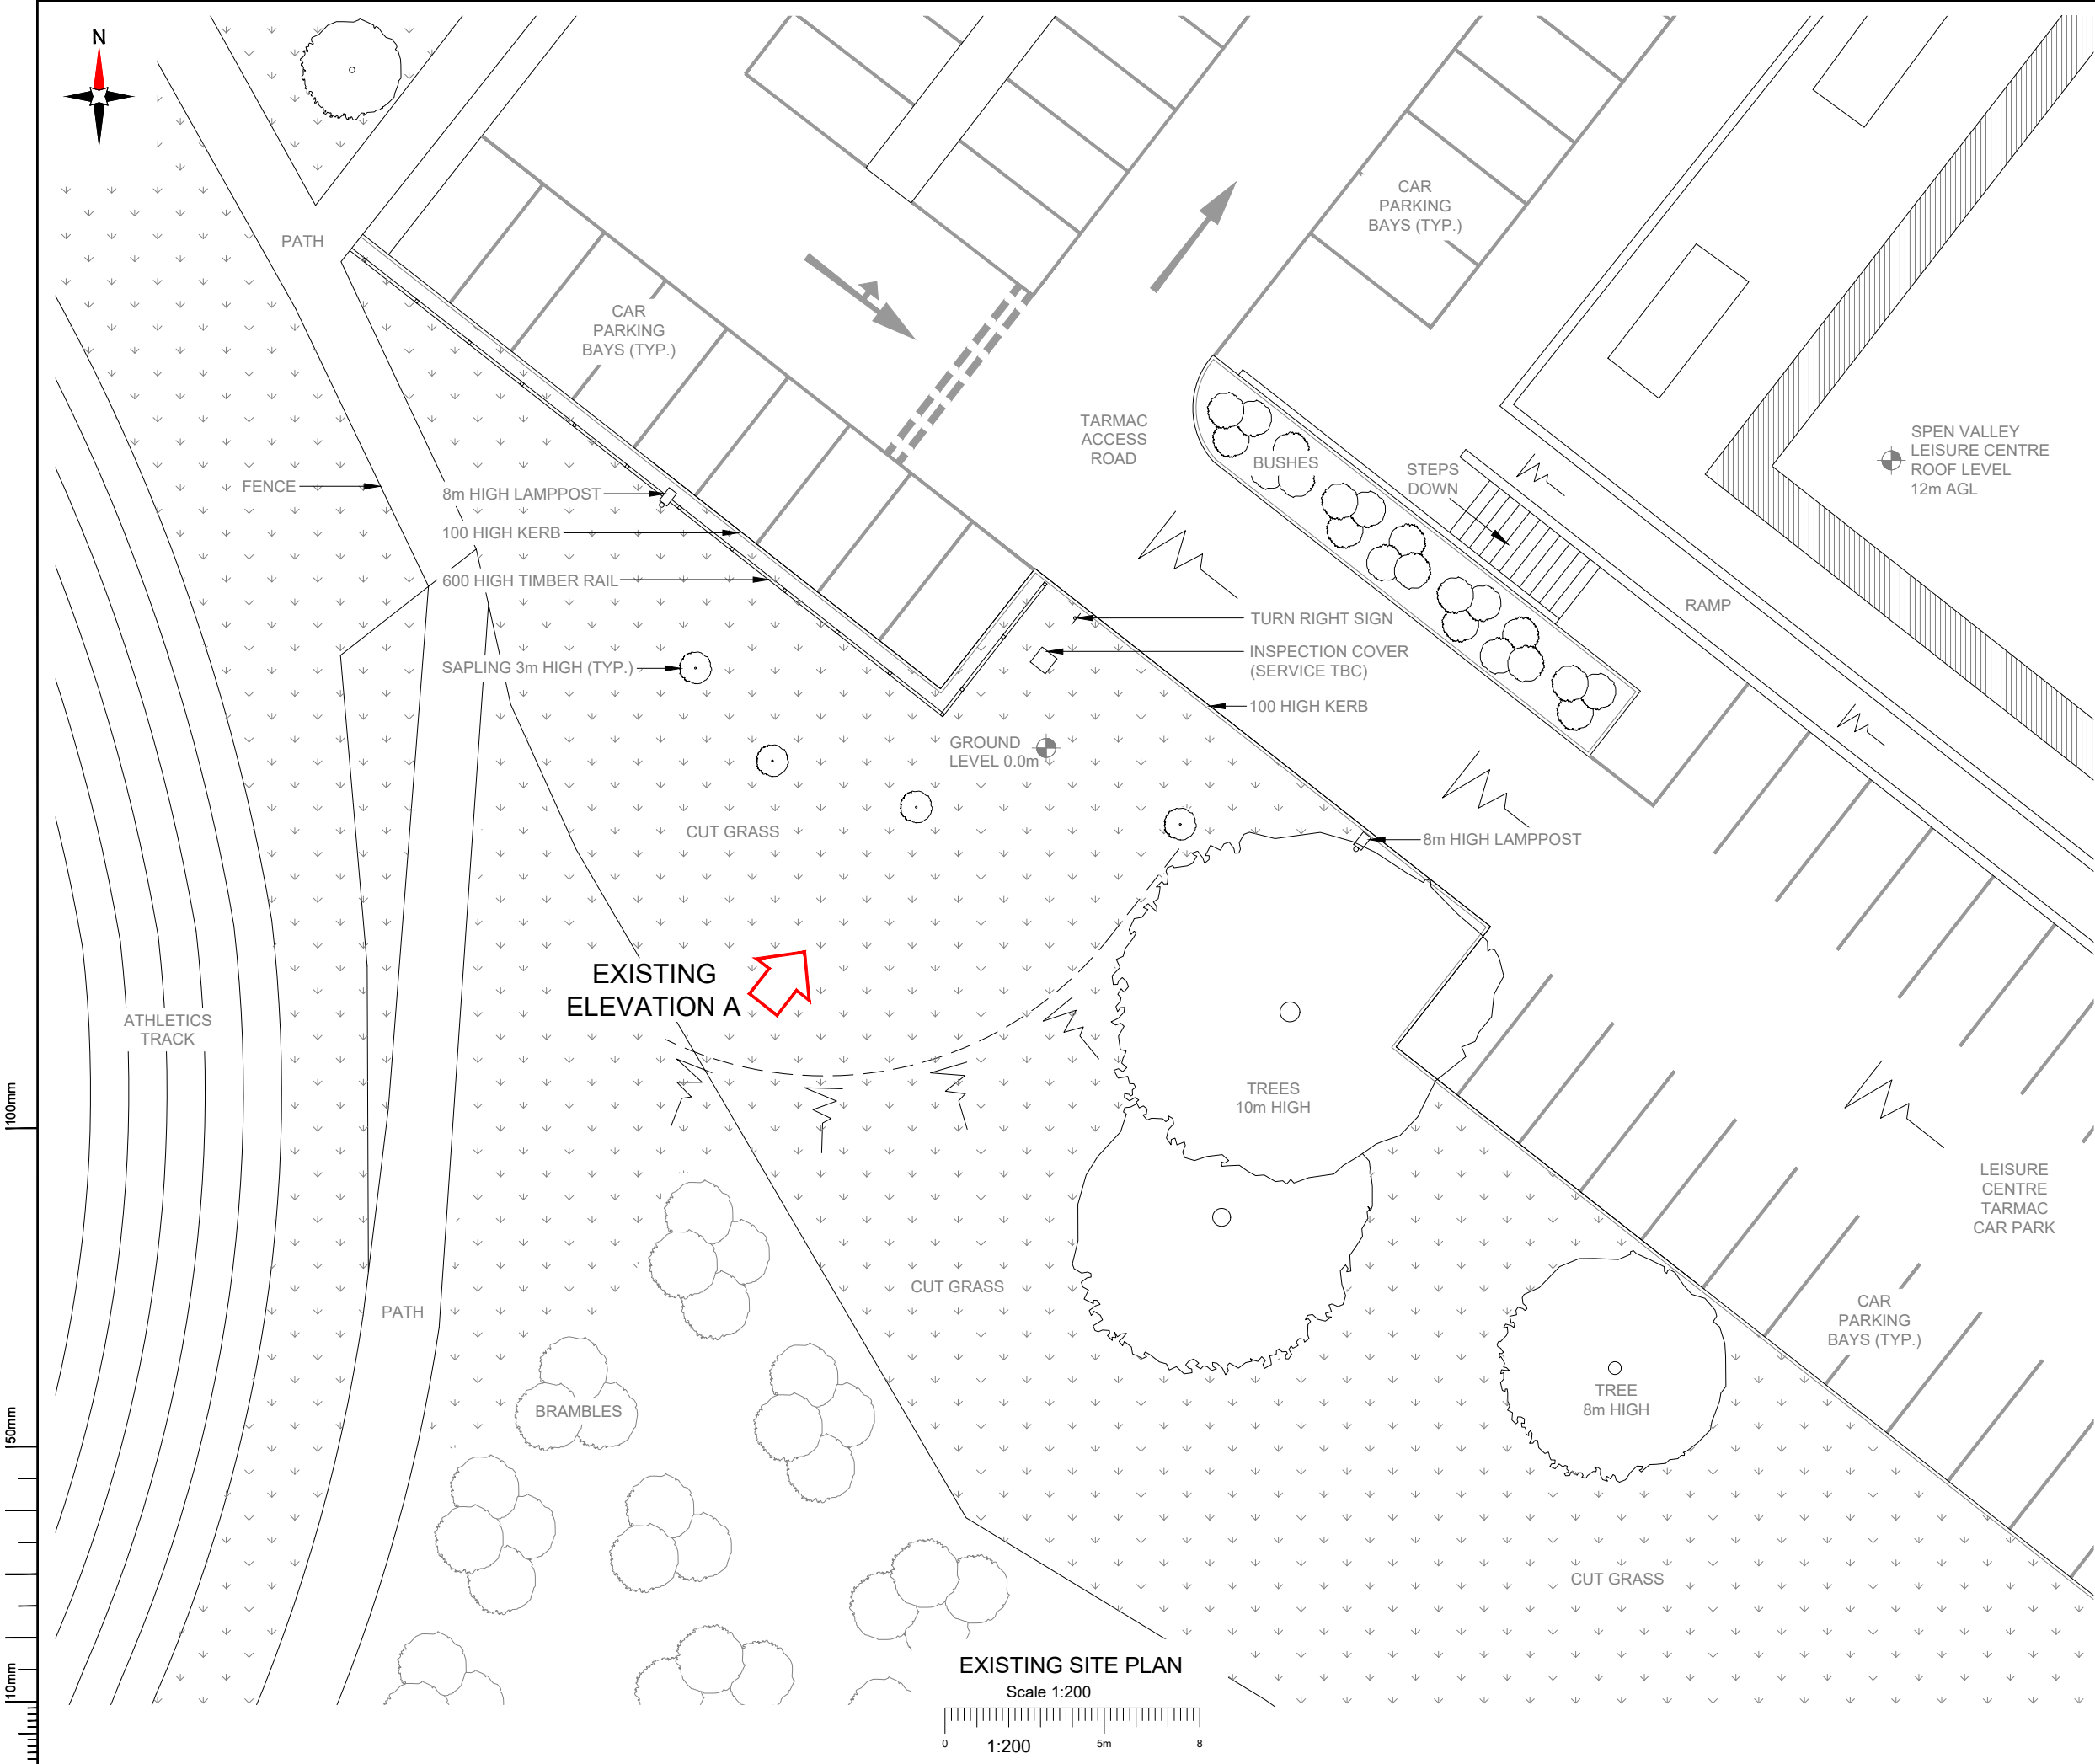

NOTES:


1. ALL DIMENSIONS IN MM UNLESS OTHERWISE NOTED.

Master: M001		MBNL / EE / H3G:		Project: NTQ		Purpose of Issue: Planning		Issue: A	
Date: 28/03/24		Drawn: J. BOOTE		Revision / Upgrade Description: First Issue					
Checked: J. STOOKDALE		Approved: G. JENNINGS							
		Hutchison 3G UK Limited Green Park, 450 Longwater Avenue, Reading, RG30 3UR Tel: 01628 765 000 H3G Base Station Information line: 0845 6043000 Available 8am-8pm Monday to Friday				Hatfield Business Park Hatfield Hertfordshire AL10 9BW Tel: 01707 315000 Fax: 01707 319001			
		Mobile Broadband Network Limited Sixth Floor, Thames Tower, Station Road, Reading, RG1 1LX							
Design Consultant & Principal Contractor:									
		WHP Telecoms Unit 1 Maple Park, Low Fields Avenue, Leeds LS12 6HH Tel: 01133023550 e-mail: info@whptelecoms.com							
Site Name:									
SPEN VALLEY LEISURE CENTRE									
Site ID:									
1687719									
Address:									
SPEN VALLEY LEISURE CENTRE, BRADFORD ROAD, LIVERSEDGE, WEST YORKSHIRE, WF15 6LW									
Title:									
100 EXISTING SITE PLAN									
Project:									
NTQ									
Purpose of Issue:									
GENERAL ARRANGEMENT									
EE Cell ID:		MBNL Cell ID:		3UK Cell ID:					
96591		KKS266		WF0874					
Master Drawing No:									Issue:
1687719_KKS266_96591_WF0874_M001									A

100mm

50mm

10mm

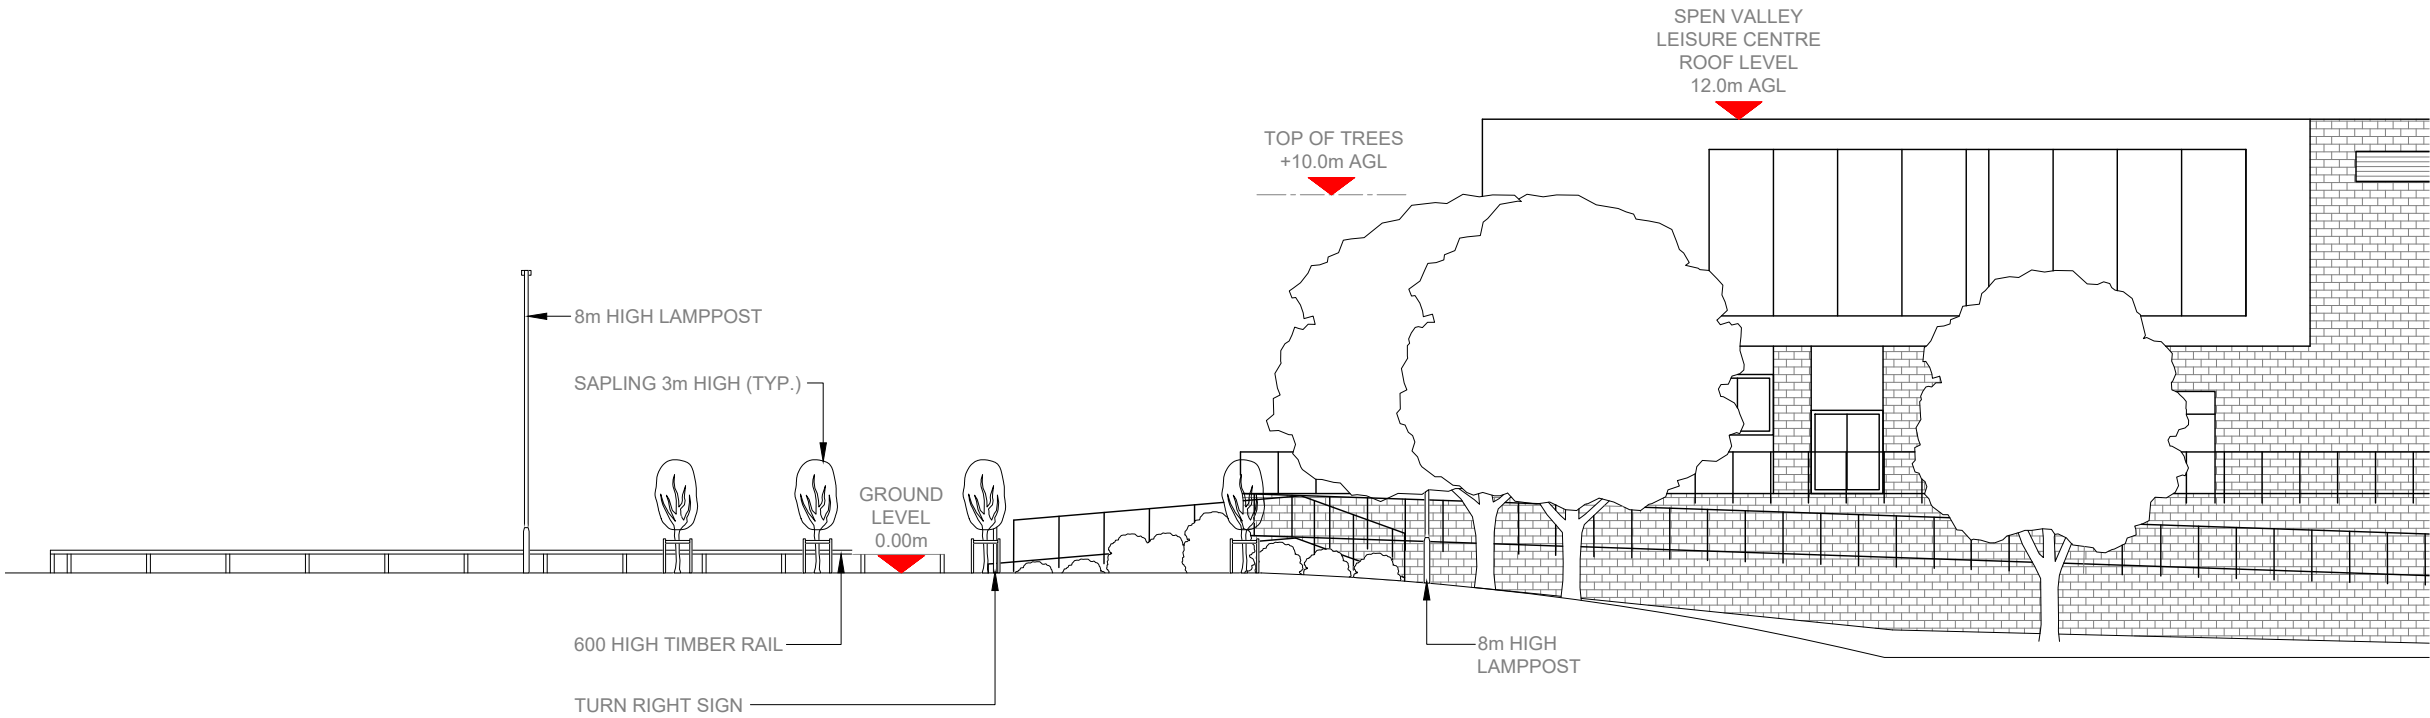

EXISTING ELEVATION A
Scale 1:200
0 1:200 5m 8

- NOTES:
- ALL DIMENSIONS IN MM UNLESS OTHERWISE NOTED.

Master:	MBNL / EE / H3G:	Project:	Purpose of Issue:	Issue:
M001	MBNL	NTQ	Planning	A
Date:	28/03/24	Revision / Upgrade Description:		
Drawn:	J. BOOTE	First Issue		
Checked:	J. STOCKDALE			
Approved:	G. JENNINGS			



Hutchison 3G UK Limited
Green Park, 450 Longwater Avenue,
Reading, RG30 3UR
Tel: 01628 765 000

H3G Base Station Information line:
0845 6043000
Available 8am-8pm Monday to Friday



Hatfield Business Park
Hatfield
Hertfordshire
AL10 9BW
Tel: 01707 315000
Fax: 01707 319001



Mobile Broadband Network Limited
Sixth Floor, Thames Tower, Station Road, Reading, RG1 1LX

Design Consultant & Principal Contractor:



WHP Telecoms
Unit 1 Maple Park,
Low Fields Avenue, Leeds
LS12 6HH

Tel: 01133023550
e-mail: info@whptelecoms.com

Site Name:
SPEN VALLEY LEISURE CENTRE

Site ID:
1687719

Address:
SPEN VALLEY LEISURE CENTRE,
BRADFORD ROAD,
LIVERSEDGE,
WEST YORKSHIRE,
WF15 6LW


Title:
150 EXISTING ELEVATION A

Project:
NTQ

Purpose of Issue:
GENERAL ARRANGEMENT

EE Cell ID:	MBNL Cell ID:	3UK Cell ID:
96591	KKS266	WF0874

Master Drawing No:	Issue:
1687719_KKS266_96591_WF0874_M001	A

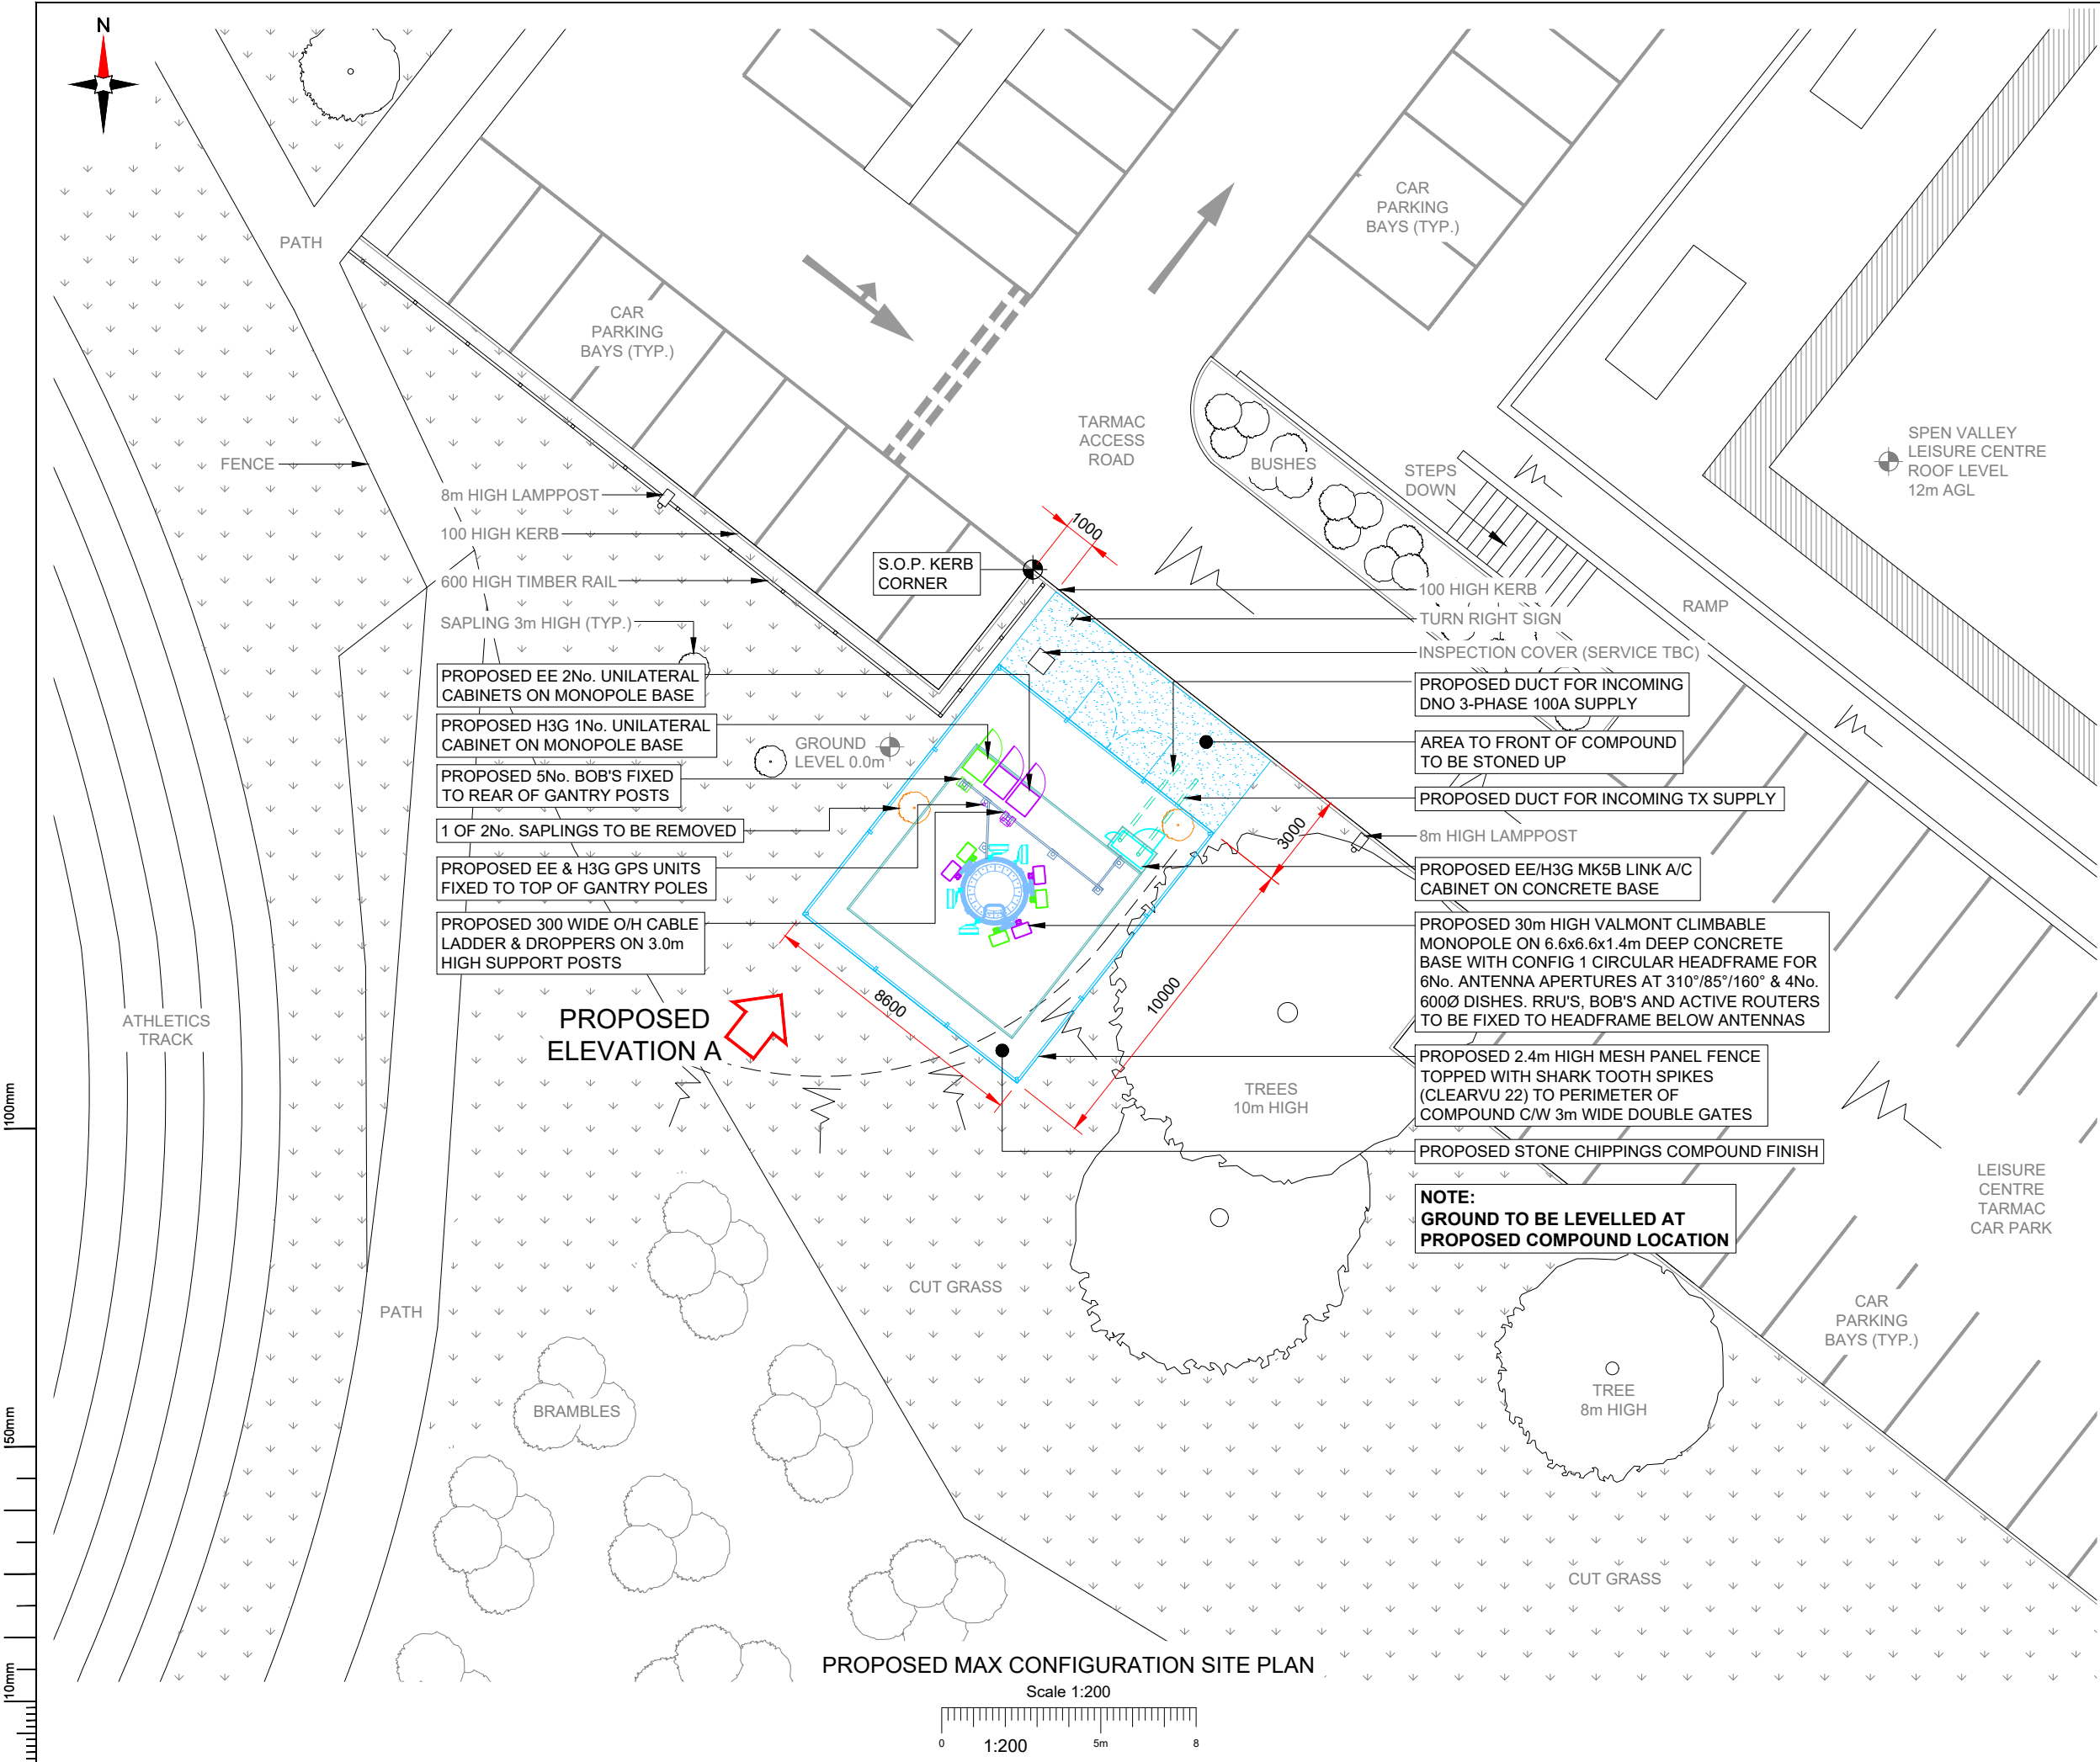

NOTES:

1. ALL DIMENSIONS IN MM UNLESS OTHERWISE NOTED.

SHARED CONFIGURATION SITE	
RF CONFIG	S2A

Master: M001	MBNL / EE / H3G: MBNL	Project: NTQ	Purpose of Issue: Planning	Issue: A
Date: 28/03/24	Revision / Upgrade Description: First Issue			
Drawn: J. BOOTE				
Checked: J. STOCKDALE				
Approved: G. JENNINGS				

Hutchison 3G UK Limited
Green Park, 450 Longwater Avenue,
Reading, RG30 3JR
Tel: 0128 765 000

H3G Base Station Information line:
0845 6043000
Available 8am-8pm Monday to Friday

Hatfield Business Park
Hatfield
Hertfordshire
AL10 9BW

Tel: 01707 315000
Fax: 01707 319001

Design Consultant & Principal Contractor:

WHP Telecoms
Unit 1 Maple Park,
Low Fields Avenue, Leeds
LS12 6HH

Tel: 01133023550
e-mail: info@whptelecoms.com

Site Name:

SPEN VALLEY LEISURE CENTRE

Site ID:

1687719

Address:

**SPEN VALLEY LEISURE CENTRE,
BRADFORD ROAD,
LIVERSEDGE,
WEST YORKSHIRE,
WF15 6LW**

Title:

**215 PROPOSED MAX CONFIGURATION
SITE PLAN**

Project:

NTQ

Purpose of Issue:

GENERAL ARRANGEMENT


EE Cell ID: 96591	MBNL Cell ID: KKS266	3UK Cell ID: WF0874
-----------------------------	--------------------------------	-------------------------------

Master Drawing No: 1687719_KKS266_96591_WF0874_M001	Issue: A
---	--------------------

100mm

50mm

10mm

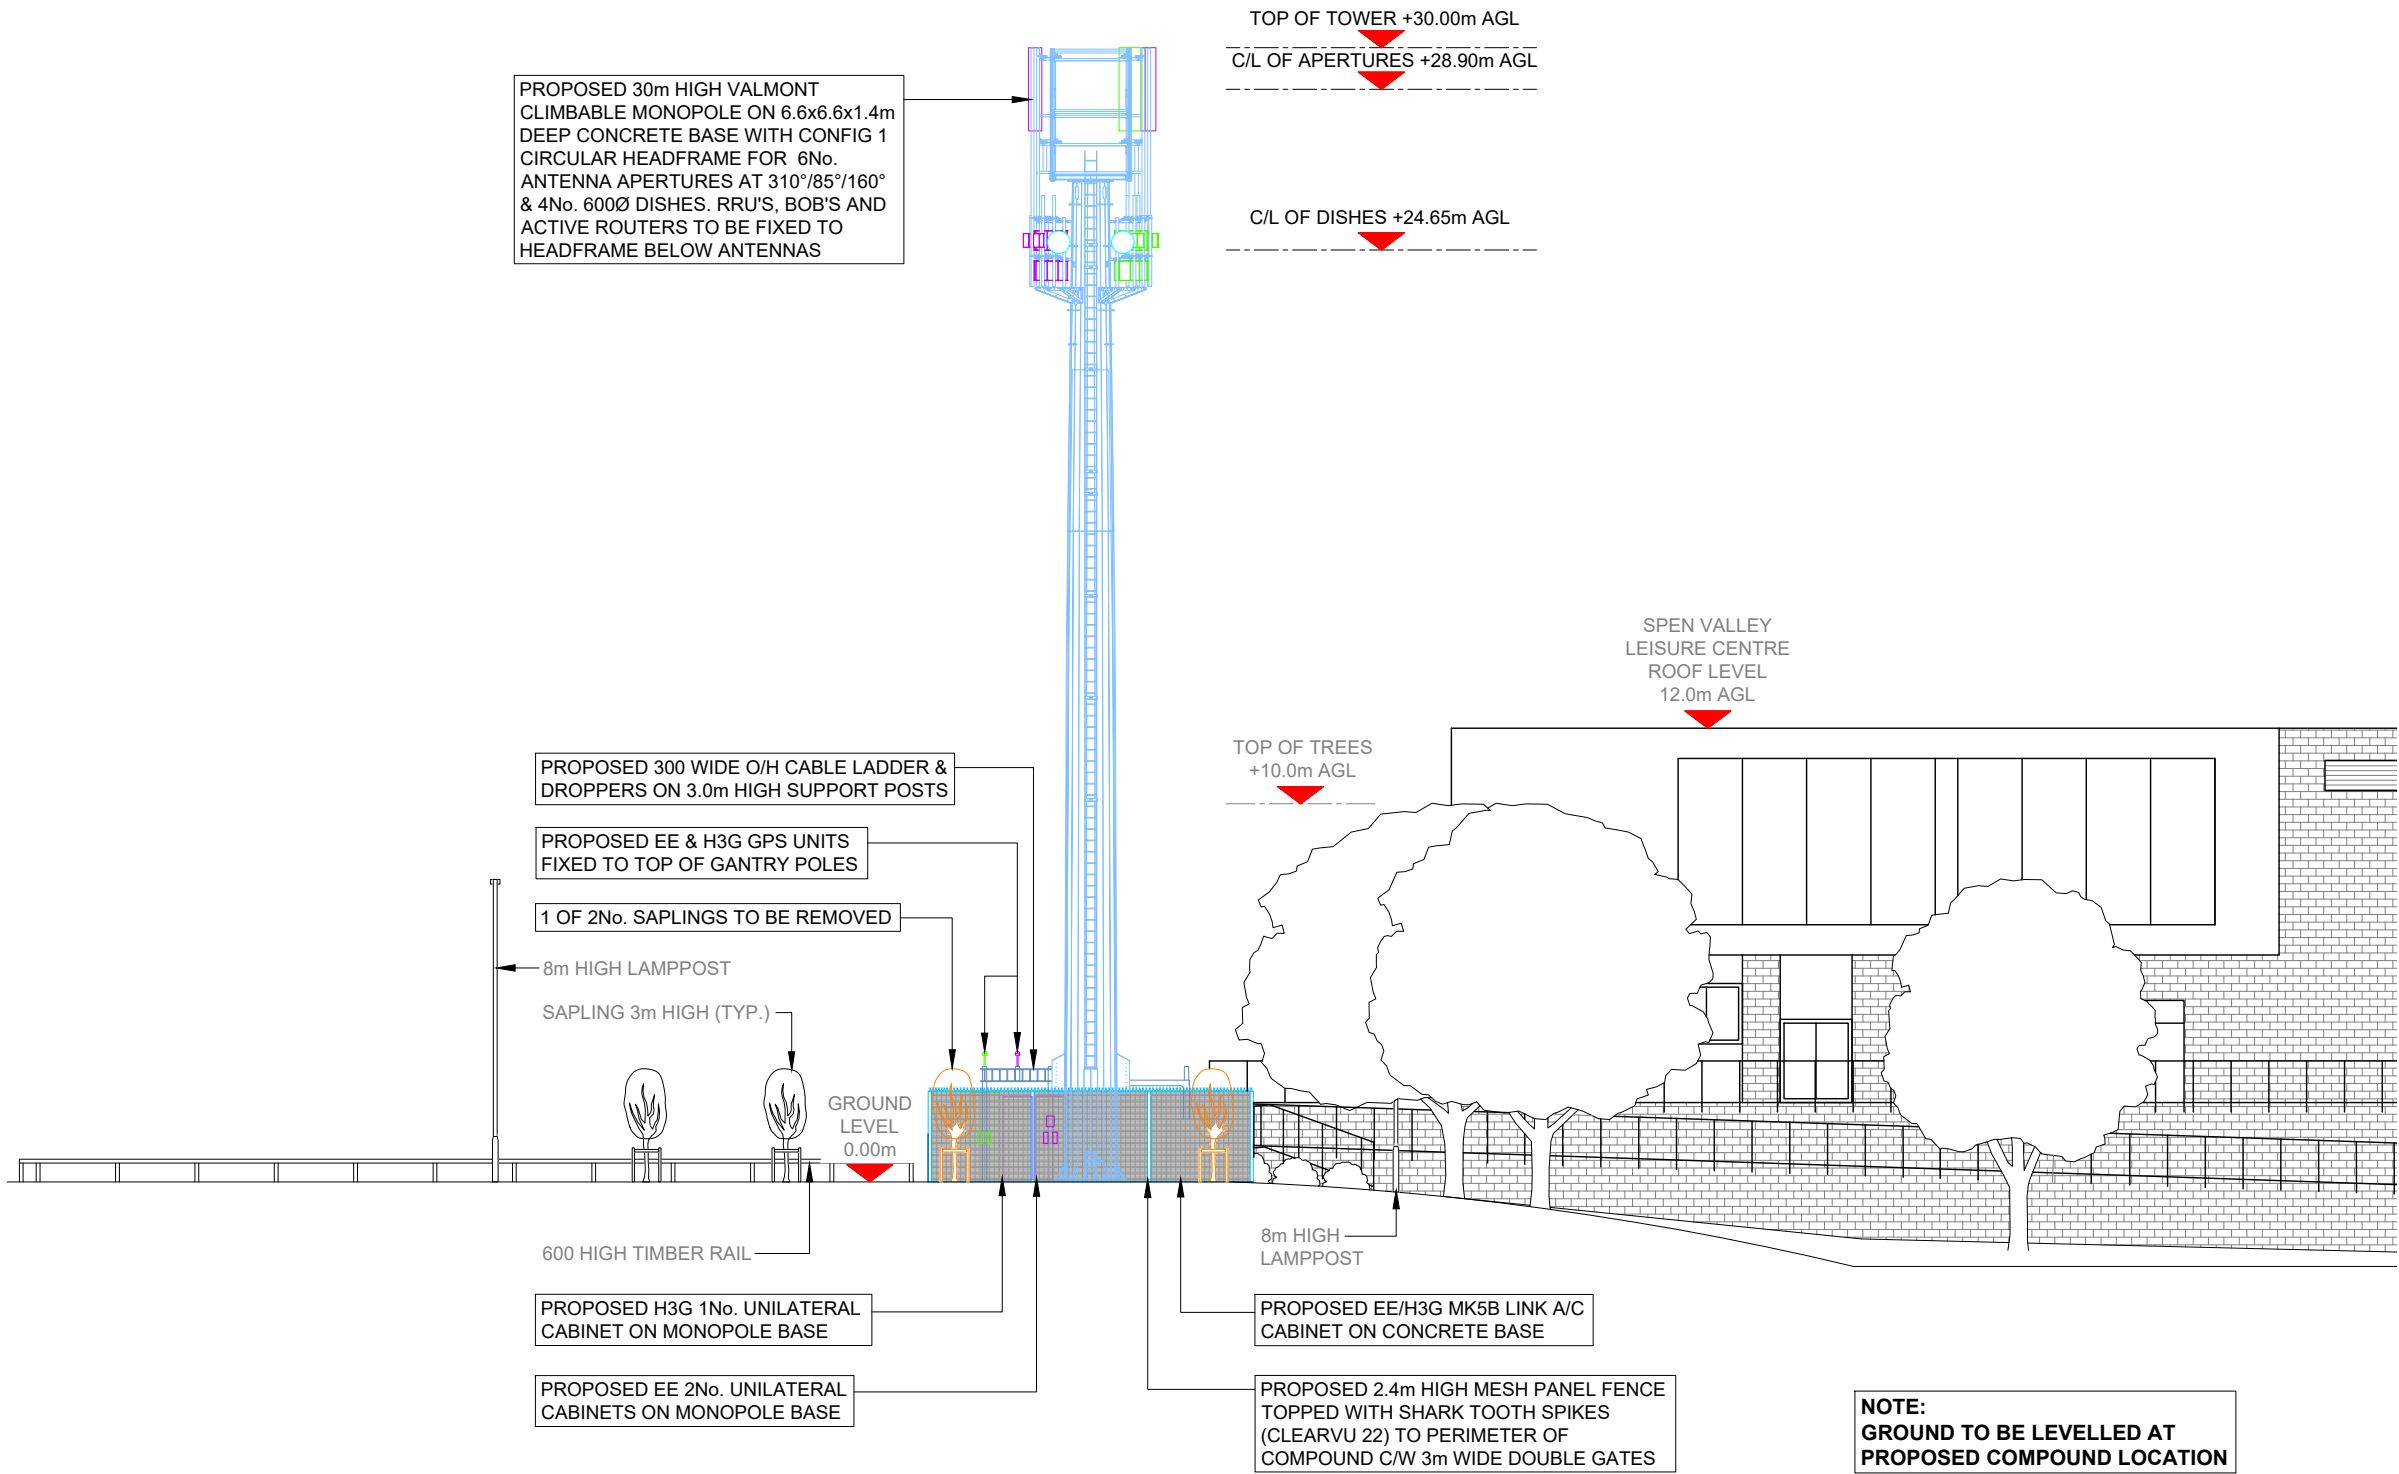

- NOTES:
- ALL DIMENSIONS IN MM UNLESS OTHERWISE NOTED.

SHARED CONFIGURATION SITE

RF CONFIG

S2A

Master:	MBNL / EE / H3G:	Project:	Purpose of Issue:	Issue:
M001	MBNL	NTQ	Planning	A
Date:	28/03/24	Revision / Upgrade Description:		
Drawn:	J. BOOTE	First Issue		
Checked:	J. STOCKDALE			
Approved:	G. JENNINGS			



Hutchison 3G UK Limited
Green Park, 450 Longwater Avenue,
Reading, RG30 3UR
Tel: 01628 765 000

H3G Base Station Information line:
0845 6043000
Available 8am-8pm Monday to Friday



Hatfield Business Park
Hatfield
Hertfordshire
AL10 9BW
Tel: 01707 315000
Fax: 01707 319001



Mobile Broadband Network Limited
Sixth Floor, Thames Tower, Station Road, Reading, RG1 1LX

Design Consultant & Principal Contractor:



WHP Telecoms
Unit 1 Maple Park,
Low Fields Avenue, Leeds
LS12 6HH

Tel: 01133023550
e-mail: info@whptelecoms.com

Site Name:
SPEN VALLEY LEISURE CENTRE

Site ID:
1687719

Address:
SPEN VALLEY LEISURE CENTRE,
BRADFORD ROAD,
LIVERSEDGE,
WEST YORKSHIRE,
WF15 6LW

Title: 265 PROPOSED MAX CONFIGURATION
ELEVATION A

Project:
NTQ

Purpose of Issue:
GENERAL ARRANGEMENT

EE Cell ID:	MBNL Cell ID:	3UK Cell ID:
96591	KKS266	WF0874

Master Drawing No:
1687719_KKS266_96591_WF0874_M001

Issue:
A

Max Configuration Antenna Aperture Schedule & RF Equipment Capacity																	
Antenna Aperture ID	Antenna Aperture Size (Length x Width x Depth)	Aperture Height C/L	Aperture Max Weight (kg)	Proposed Bearing	Tech:	Operator: Shared/ EE/H3G	Antenna Aperture Coordinates		RRU No. Max Size & Weight L=500mm W=400mm D=200mm Weight=38kg	MHA No. Max Size & Weight L=300mm W=300mm D=150mm Weight=15kg	Main Feeder			BOB Max Size & Weight (220x480x180mm & 5kg)		Active Router No. Max Size & Weight (370x260x150mm & 15kg)	Passive Router No. Max Size & Weight (370x260x150mm & 15kg)
							Eastings	Northings			Size	Length	No.	No. Top	No. Bottom		
A1	2200x500x400mm	28.90m	100kg	310°	2G/4G/5G	EE	-	-	4	-	-	-	-	1	1	2	-
A2	2200x500x400mm	28.90m	100kg	310°	4G/5G	H3G	-	-	4	-	-	-	-	2	1	2	-
B1	2200x500x400mm	28.90m	100kg	85°	2G/4G/5G	EE	-	-	4	-	-	-	-	1	1	2	-
B2	2200x500x400mm	28.90m	100kg	85°	4G/5G	H3G	-	-	4	-	-	-	-	2	1	2	-
C1	2200x500x400mm	28.90m	100kg	160°	2G/4G/5G	EE	-	-	4	-	-	-	-	1	1	2	-
C2	2200x500x400mm	28.90m	100kg	160°	4G/5G	H3G	-	-	4	-	-	-	-	2	-	2	-

Passive Infrastructure Equipment Capacity		
A	B	C
S2A	S2A	S2A

STATUS KEY:

Installed:	Existing
Retain:	Existing and to remain
Relocate:	Existing and to be relocated
Remove:	Existing to be removed from site
Proposed:	New on site

Master:	MBNL / EE / H3G:	Project:	Purpose of Issue:	Issue:
M001	MBNL	NTQ	Planning	A
Date:	28/03/24	Revision / Upgrade Description:		
Drawn:	J. BOOTE	First Issue		
Checked:	J. STOCKDALE			
Approved:	G. JENNINGS			



Hutchison 3G UK Limited
Green Park, 450 Longwater Avenue,
Reading, RG30 3UR
Tel: 01628 765 000

H3G Base Station Information line:
0845 6043000
Available 8am-8pm Monday to Friday



Hatfield Business Park
Hatfield
Hertfordshire
AL10 9BW

Tel: 01707 315000
Fax: 01707 319001



Mobile Broadband Network Limited
Sixth Floor, Thames Tower, Station Road, Reading, RG1 1LX

Design Consultant & Principal Contractor:



WHP Telecoms
Unit 1 Maple Park,
Low Fields Avenue, Leeds
LS12 6HH

Tel: 01133023550
e-mail: info@whptelecoms.com

Site Name:		
SPEN VALLEY LEISURE CENTRE		
Site ID:		
1687719		
Address:		
SPEN VALLEY LEISURE CENTRE, BRADFORD ROAD, LIVERSEDGE, WEST YORKSHIRE, WF15 6LW		
Title:		
304 PROPOSED MAX CONFIGURATION ANTENNA SCHEDULE		
Project:		
NTQ		
Purpose of Issue:		
GENERAL ARRANGEMENT		
EE Cell ID:	MBNL Cell ID:	3UK Cell ID:
96591	KKS266	WF0874
Master Drawing No:		Issue:
1687719_KKS266_96591_WF0874_M001		A