


1:57

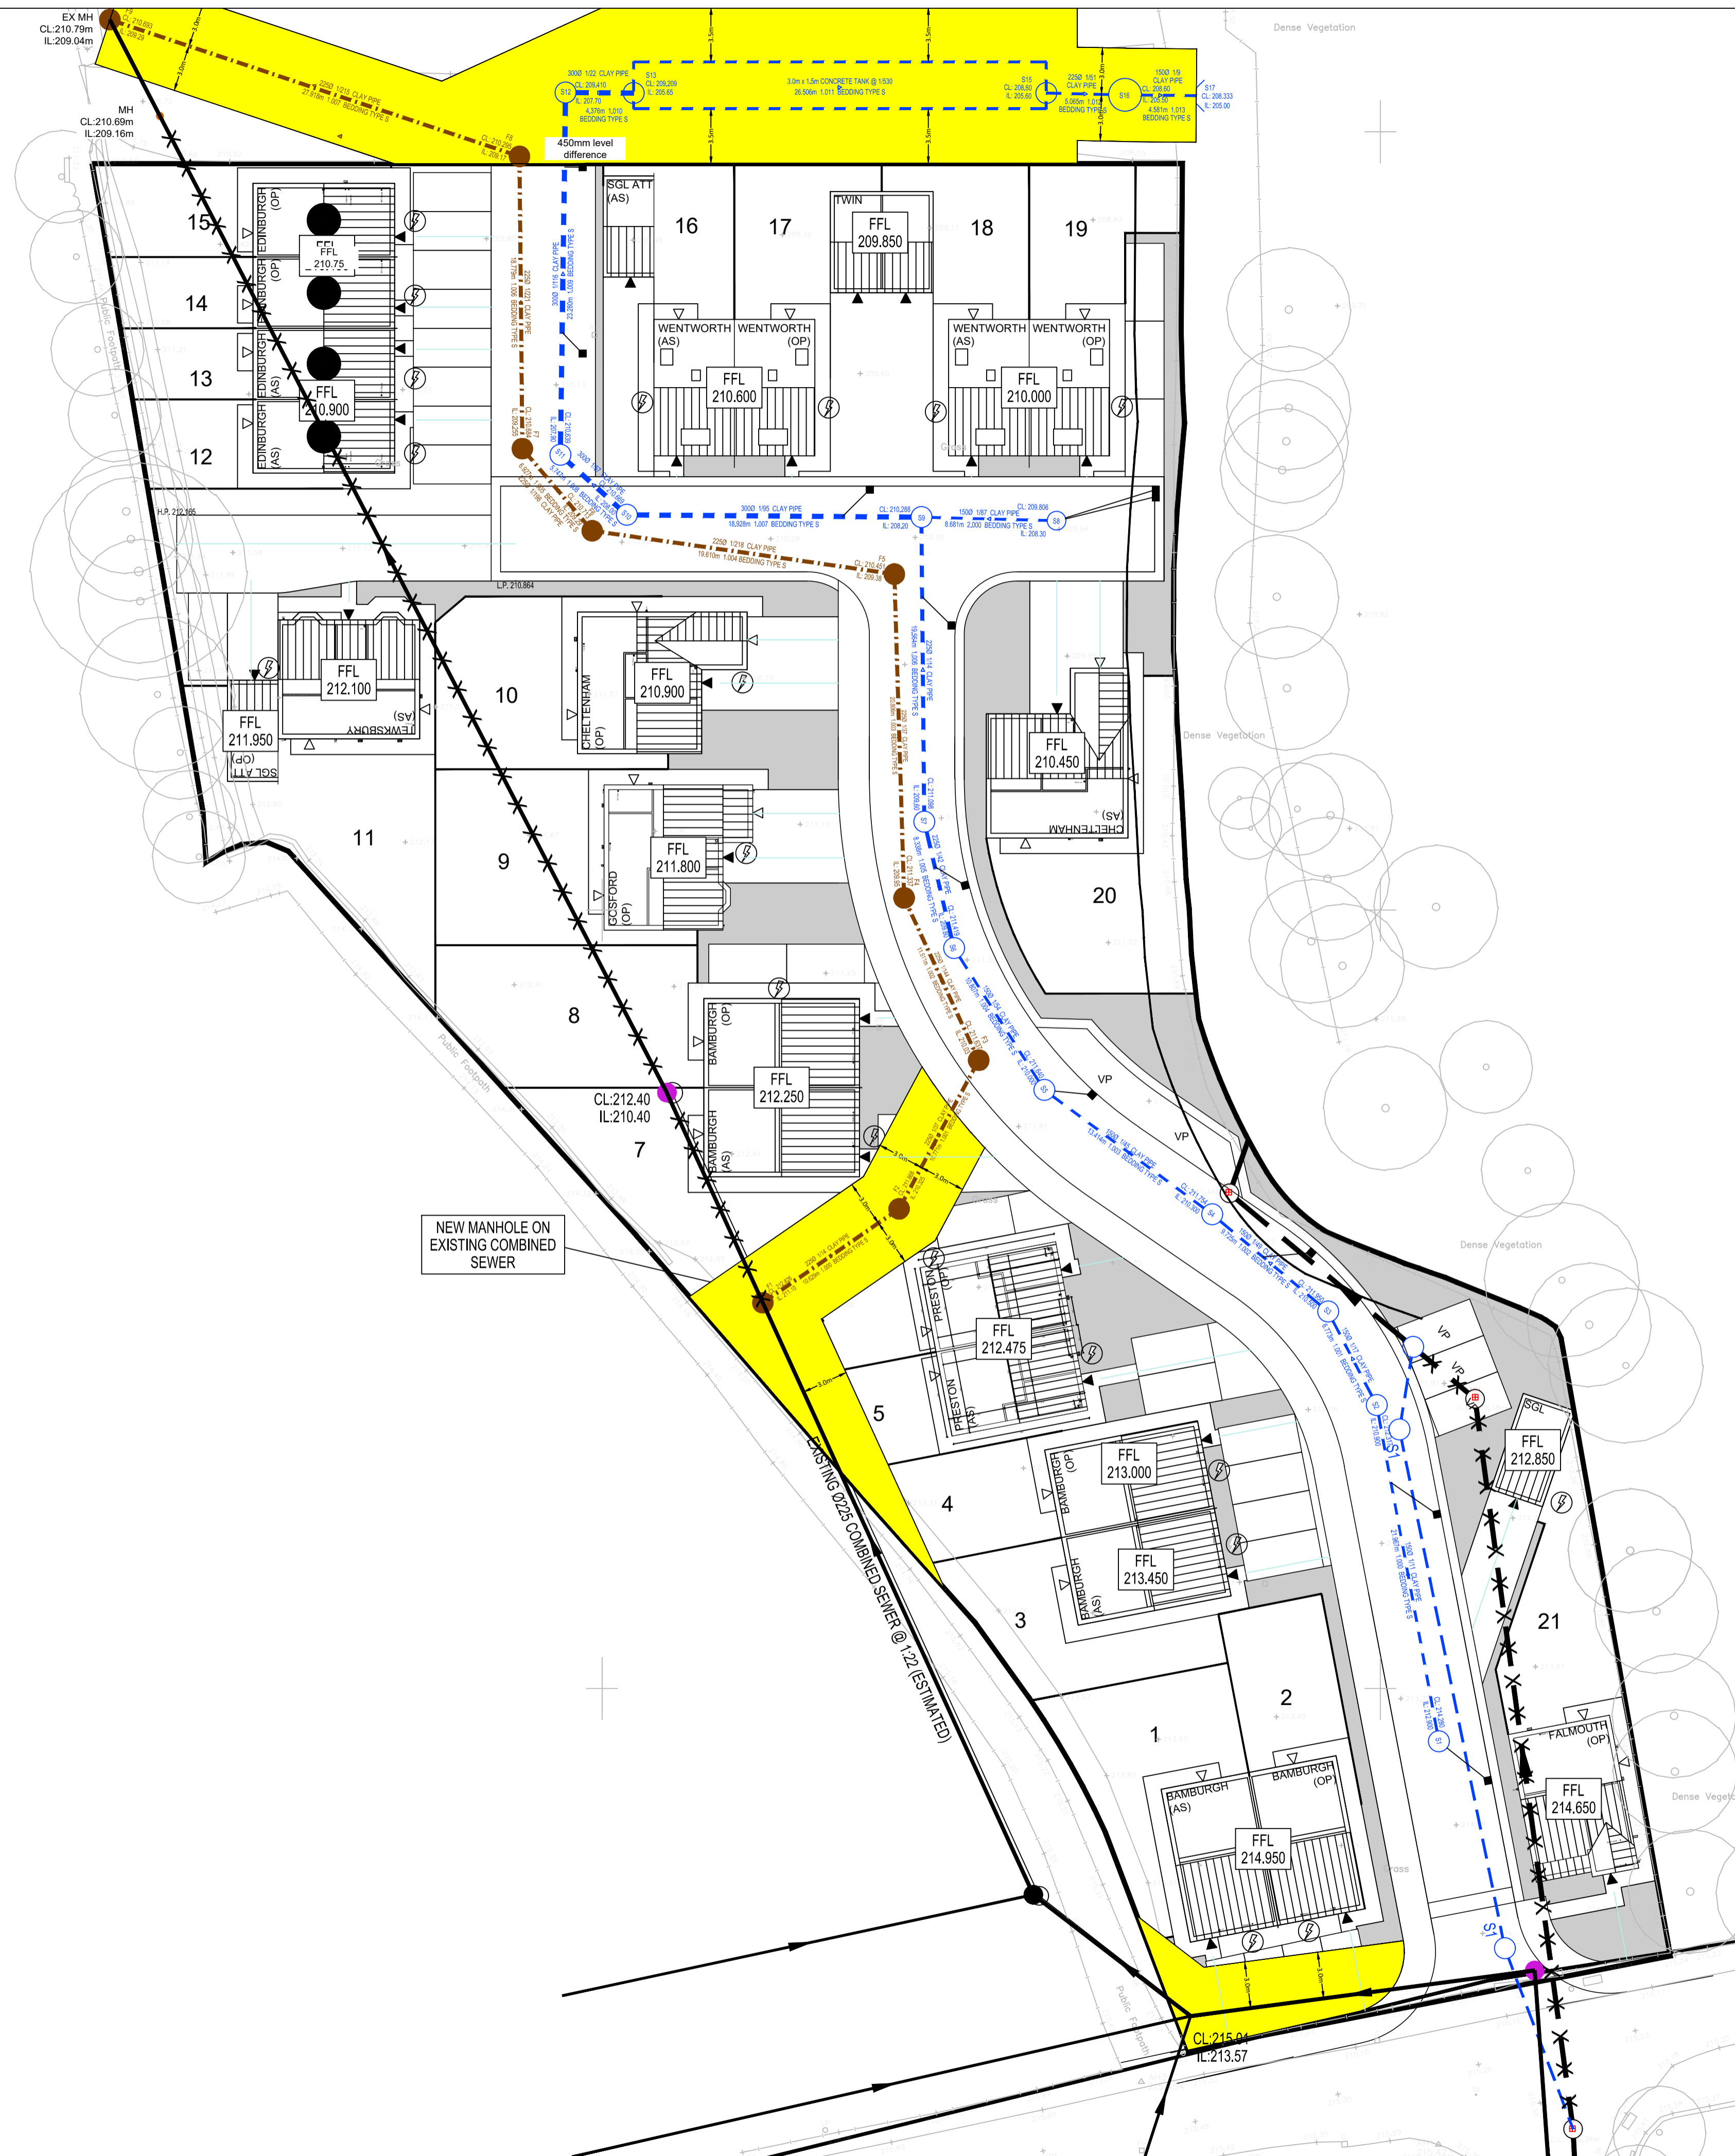

NOTES

1. THIS DRAWING IS PRODUCED FOR USE IN THIS PROJECT ONLY AND MAY NOT BE USED FOR ANY OTHER PURPOSE. THE CONSULTING ENGINEERS ACCEPT NO LIABILITY FOR THE USE OF THIS DRAWING OTHER THAN THE PURPOSE FOR WHICH IT WAS INTENDED IN CONNECTION WITH THIS PROJECT AS RECORDED ON THE TITLE BLOCK FIELDS 'PURPOSE FOR ISSUE' AND 'FILE STATUS CODE'.
2. THIS DRAWING MAY NOT BE REPRODUCED IN ANY FORM WITHOUT PRIOR WRITTEN AGREEMENT FROM ADVANT ENGINEERS.
3. DO NOT SCALE FROM THE DRAWING. USE WRITTEN DIMENSIONS ONLY.
4. ALL DIMENSIONS ARE IN MILLIMETRES UNLESS OTHERWISE SPECIFIED.
5. DISCREPANCIES MUST BE REPORTED BACK TO THE ENGINEER PRIOR TO CONSTRUCTION.
6. THIS DRAWING TO BE READ IN CONJUNCTION WITH ALL RELEVANT ADVANT ENGINEERS DRAWINGS AND SPECIFICATIONS.

KEY

- EXISTING COMBINED SEWER
- - -○- - - EXISTING SURFACE WATER SEWER
- - -○- - - PROP S104 SURFACE WATER SEWER
- - -○- - - PROP S104 FOUL WATER SEWER
- ✕ ✕ ✕ SEWER TO BE ABANDONED
- SEWER EASEMENT

E	LEVELS UPDATED	MJM	03.07.24
D	DRAINAGE DIVERSIONS UPDATED	MJM	28.05.24
C	DRAINAGE & LAYOUT UPDATED	MJM	20.05.24
B	FOUL SEWER DIVERSION UPDATED	MJM	15.05.24
A	INITIAL ISSUE	MJM	20.03.24
REV	AMENDMENTS	BY	DATE

PRELIMINARY

STATUS	CHK'D
PRELIMINARY	MJM
FOR COMMENT	
FOR APPROVAL	
FOR CONSTRUCTION	
AS BUILT	

advant ENGINEERS

Building 3 Leeds City West Business Park,
Geldard Road, Leeds, LS12 6LN
0113 873 0607
leeds@advantengineers.co.uk

CLIENT
ORION HOMES LTD

CONTRACT
DENBY LANE GRANGE MOOR

TITLE
S104 DRAINAGE LAYOUT

DRAWN	MJM	CHK'D	MJM
SCALE	1:250 @ A1	DATE	20.03.24

JOB No	DRG No	REV
24017	101	E