


Do not scale from this drawing. Northlight Architectural Consultants Ltd must be notified immediately should any discrepancies be found. The contractor must check all dimensions on site before construction or manufacture of materials. This drawing or any portion of it may not be reproduced without the consent of Northlight Architectural Consultants Ltd.

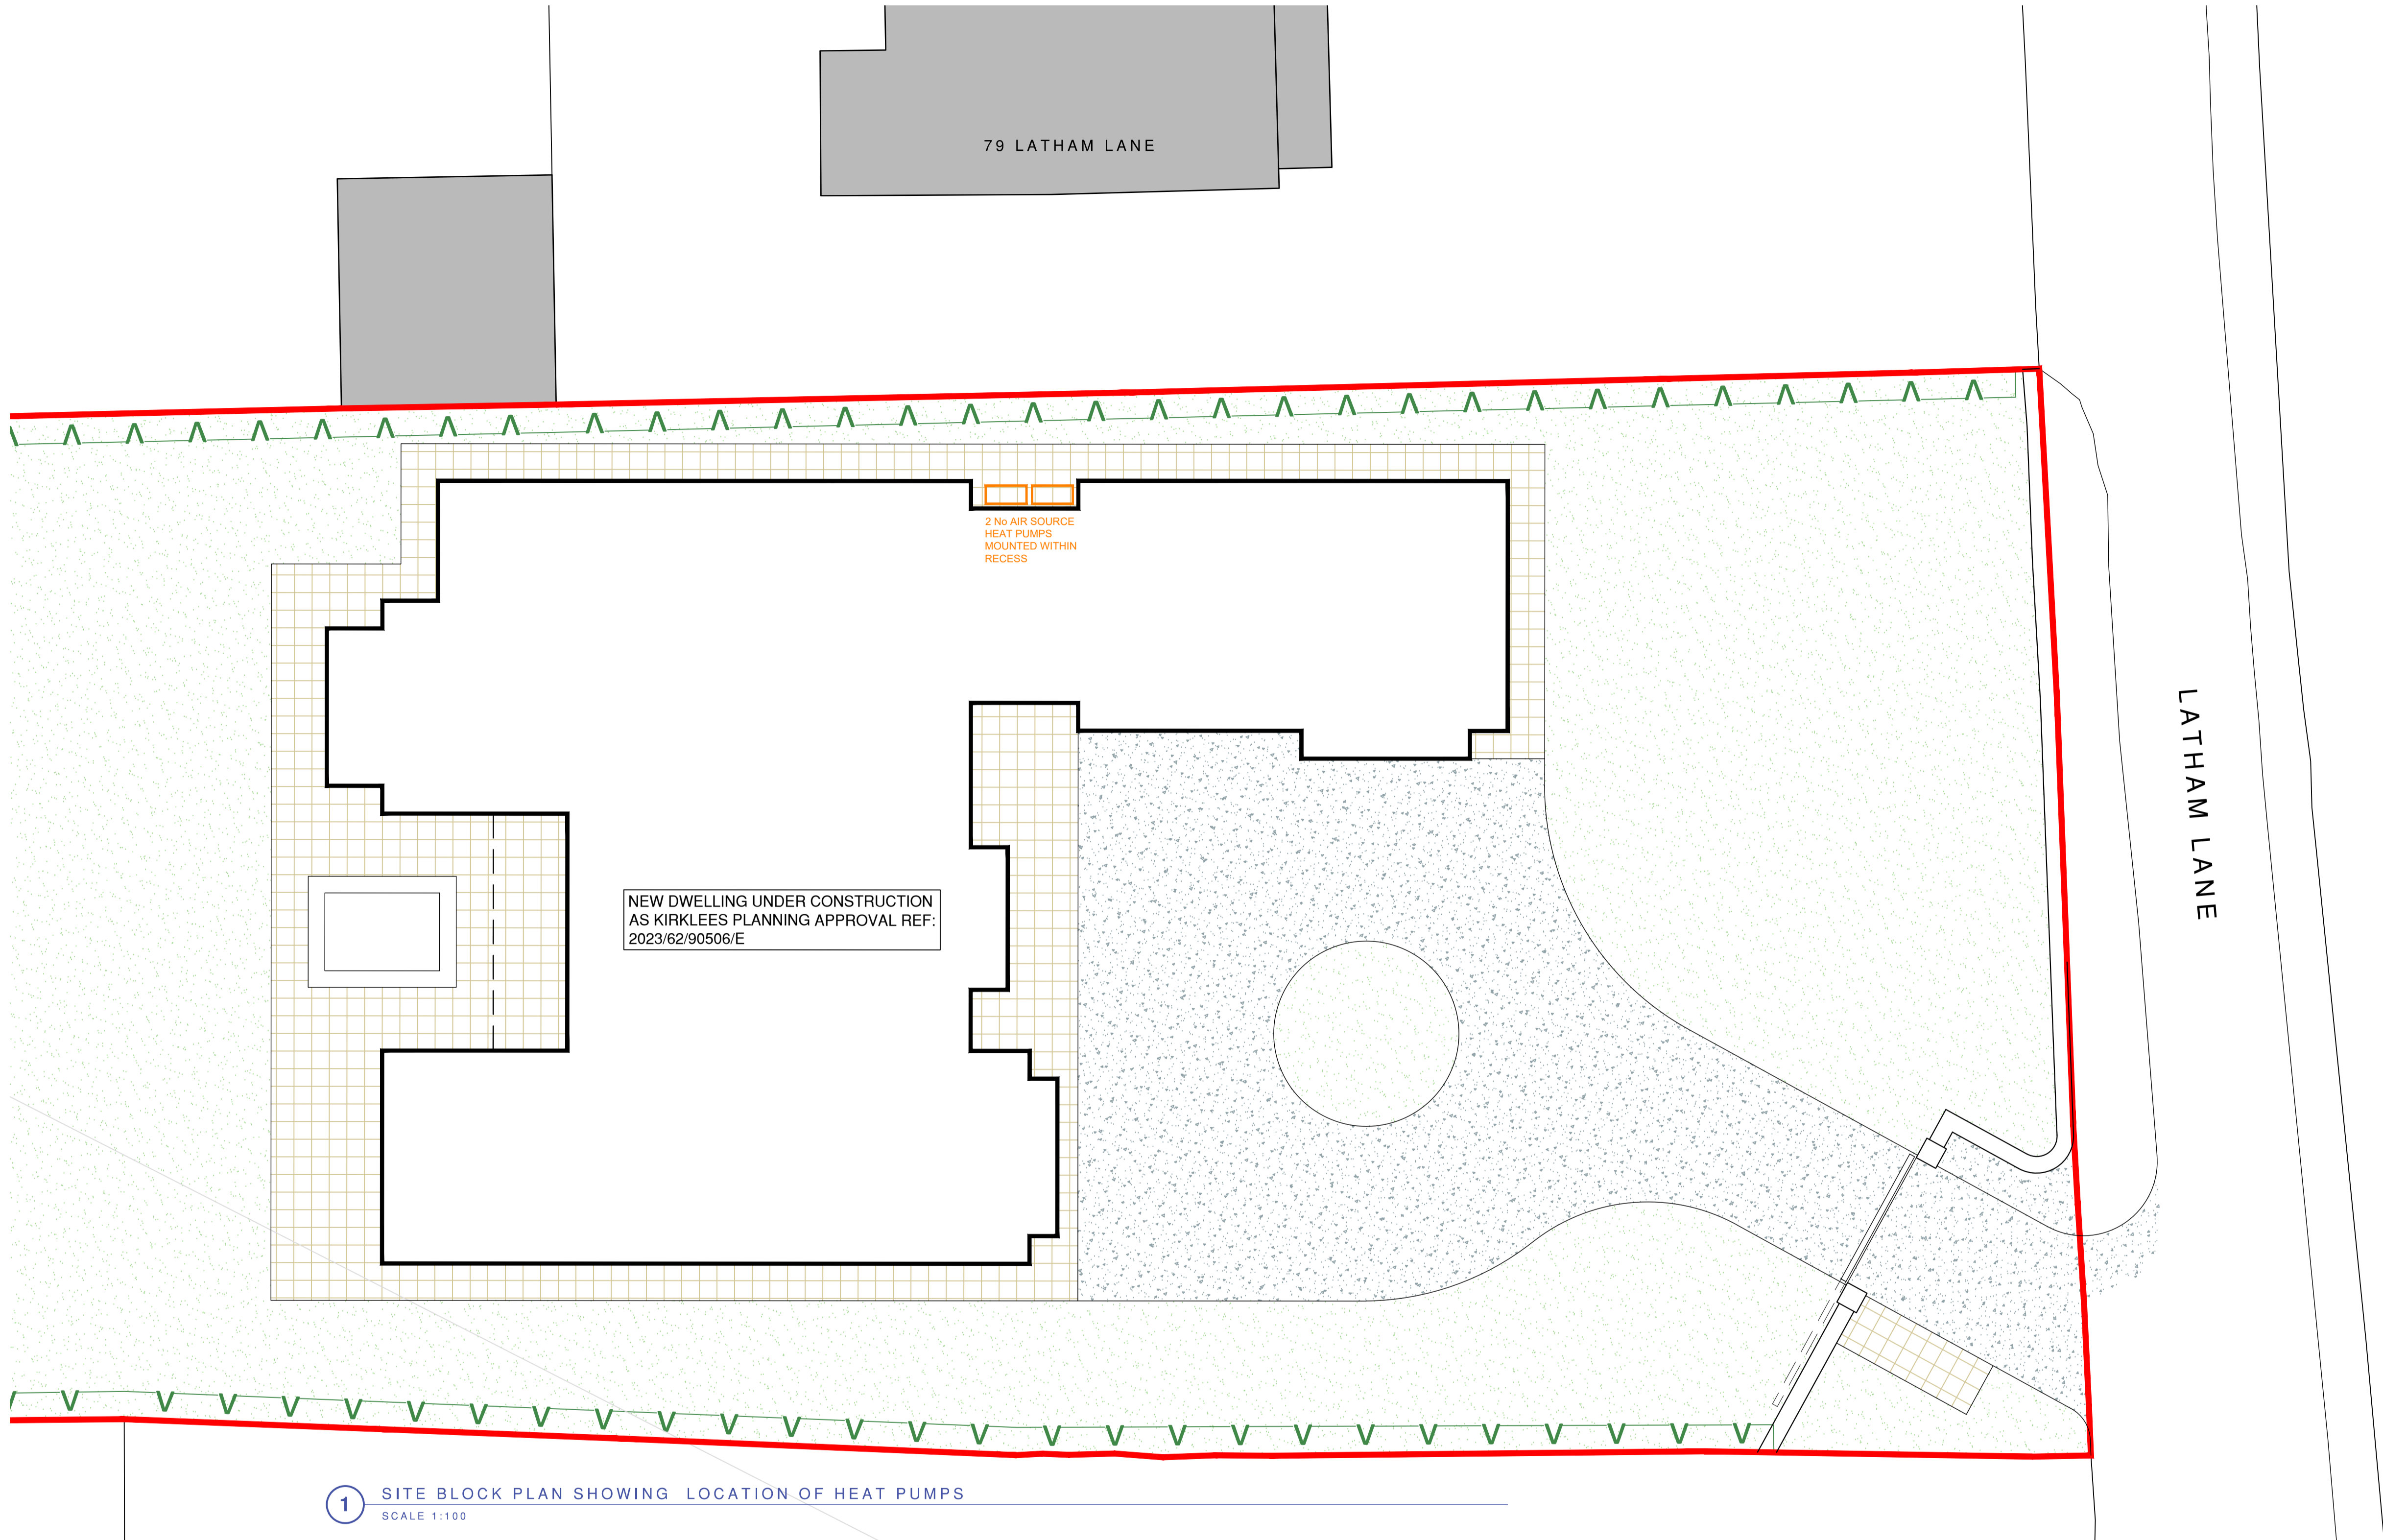

1 SITE BLOCK PLAN SHOWING LOCATION OF HEAT PUMPS
SCALE 1:100



(c) Crown Copyright and Database Rights 2022 OS 100060020

3 SITE LOCATION PLAN
SCALE 1:1250

NOTE:
REFER TO SEPARATE SPECIFICATION SHEET FOR DETAILS OF AIR SOURCE HEAT PUMPS

REFER TO ACOUSTIC REPORT REF: DRUK/ACC/RS/JLL/LGC/3292 V2 FOR ASSESSMENT OF THE EXISTING NOISE CLIMATE IN THE VICINITY OF THE PROPOSED AIR SOURCE HEAT PUMPS

Revisions

NORTHLIGHT
ARCHITECTURAL CONSULTANTS

The Media Centre
7 Northumberland Street
Huddersfield
HD1 1RL
t: 01484 209466
e: chris@northlight@gmail.com

Client
John Valente

Project
**The Gables,
Latham Lane, Gomersal
CLECKHEATON, BD19 4AP**

Drawing title
**Air Source Heat Pumps
Location Plan & Elevation**

PLANNING APPLICATION

Scale: @ A0
1:100

Drawn by
CG

Date
Sept '24

App'd

Drawn by
24.007/(AL)07

Rev
-

2 NORTH-WEST ELEVATION SHOWING LOCATION OF HEAT PUMPS
SCALE 1:100

