


CONTINUED ON SRP1088-ITR-XX-00-DR-L-0210

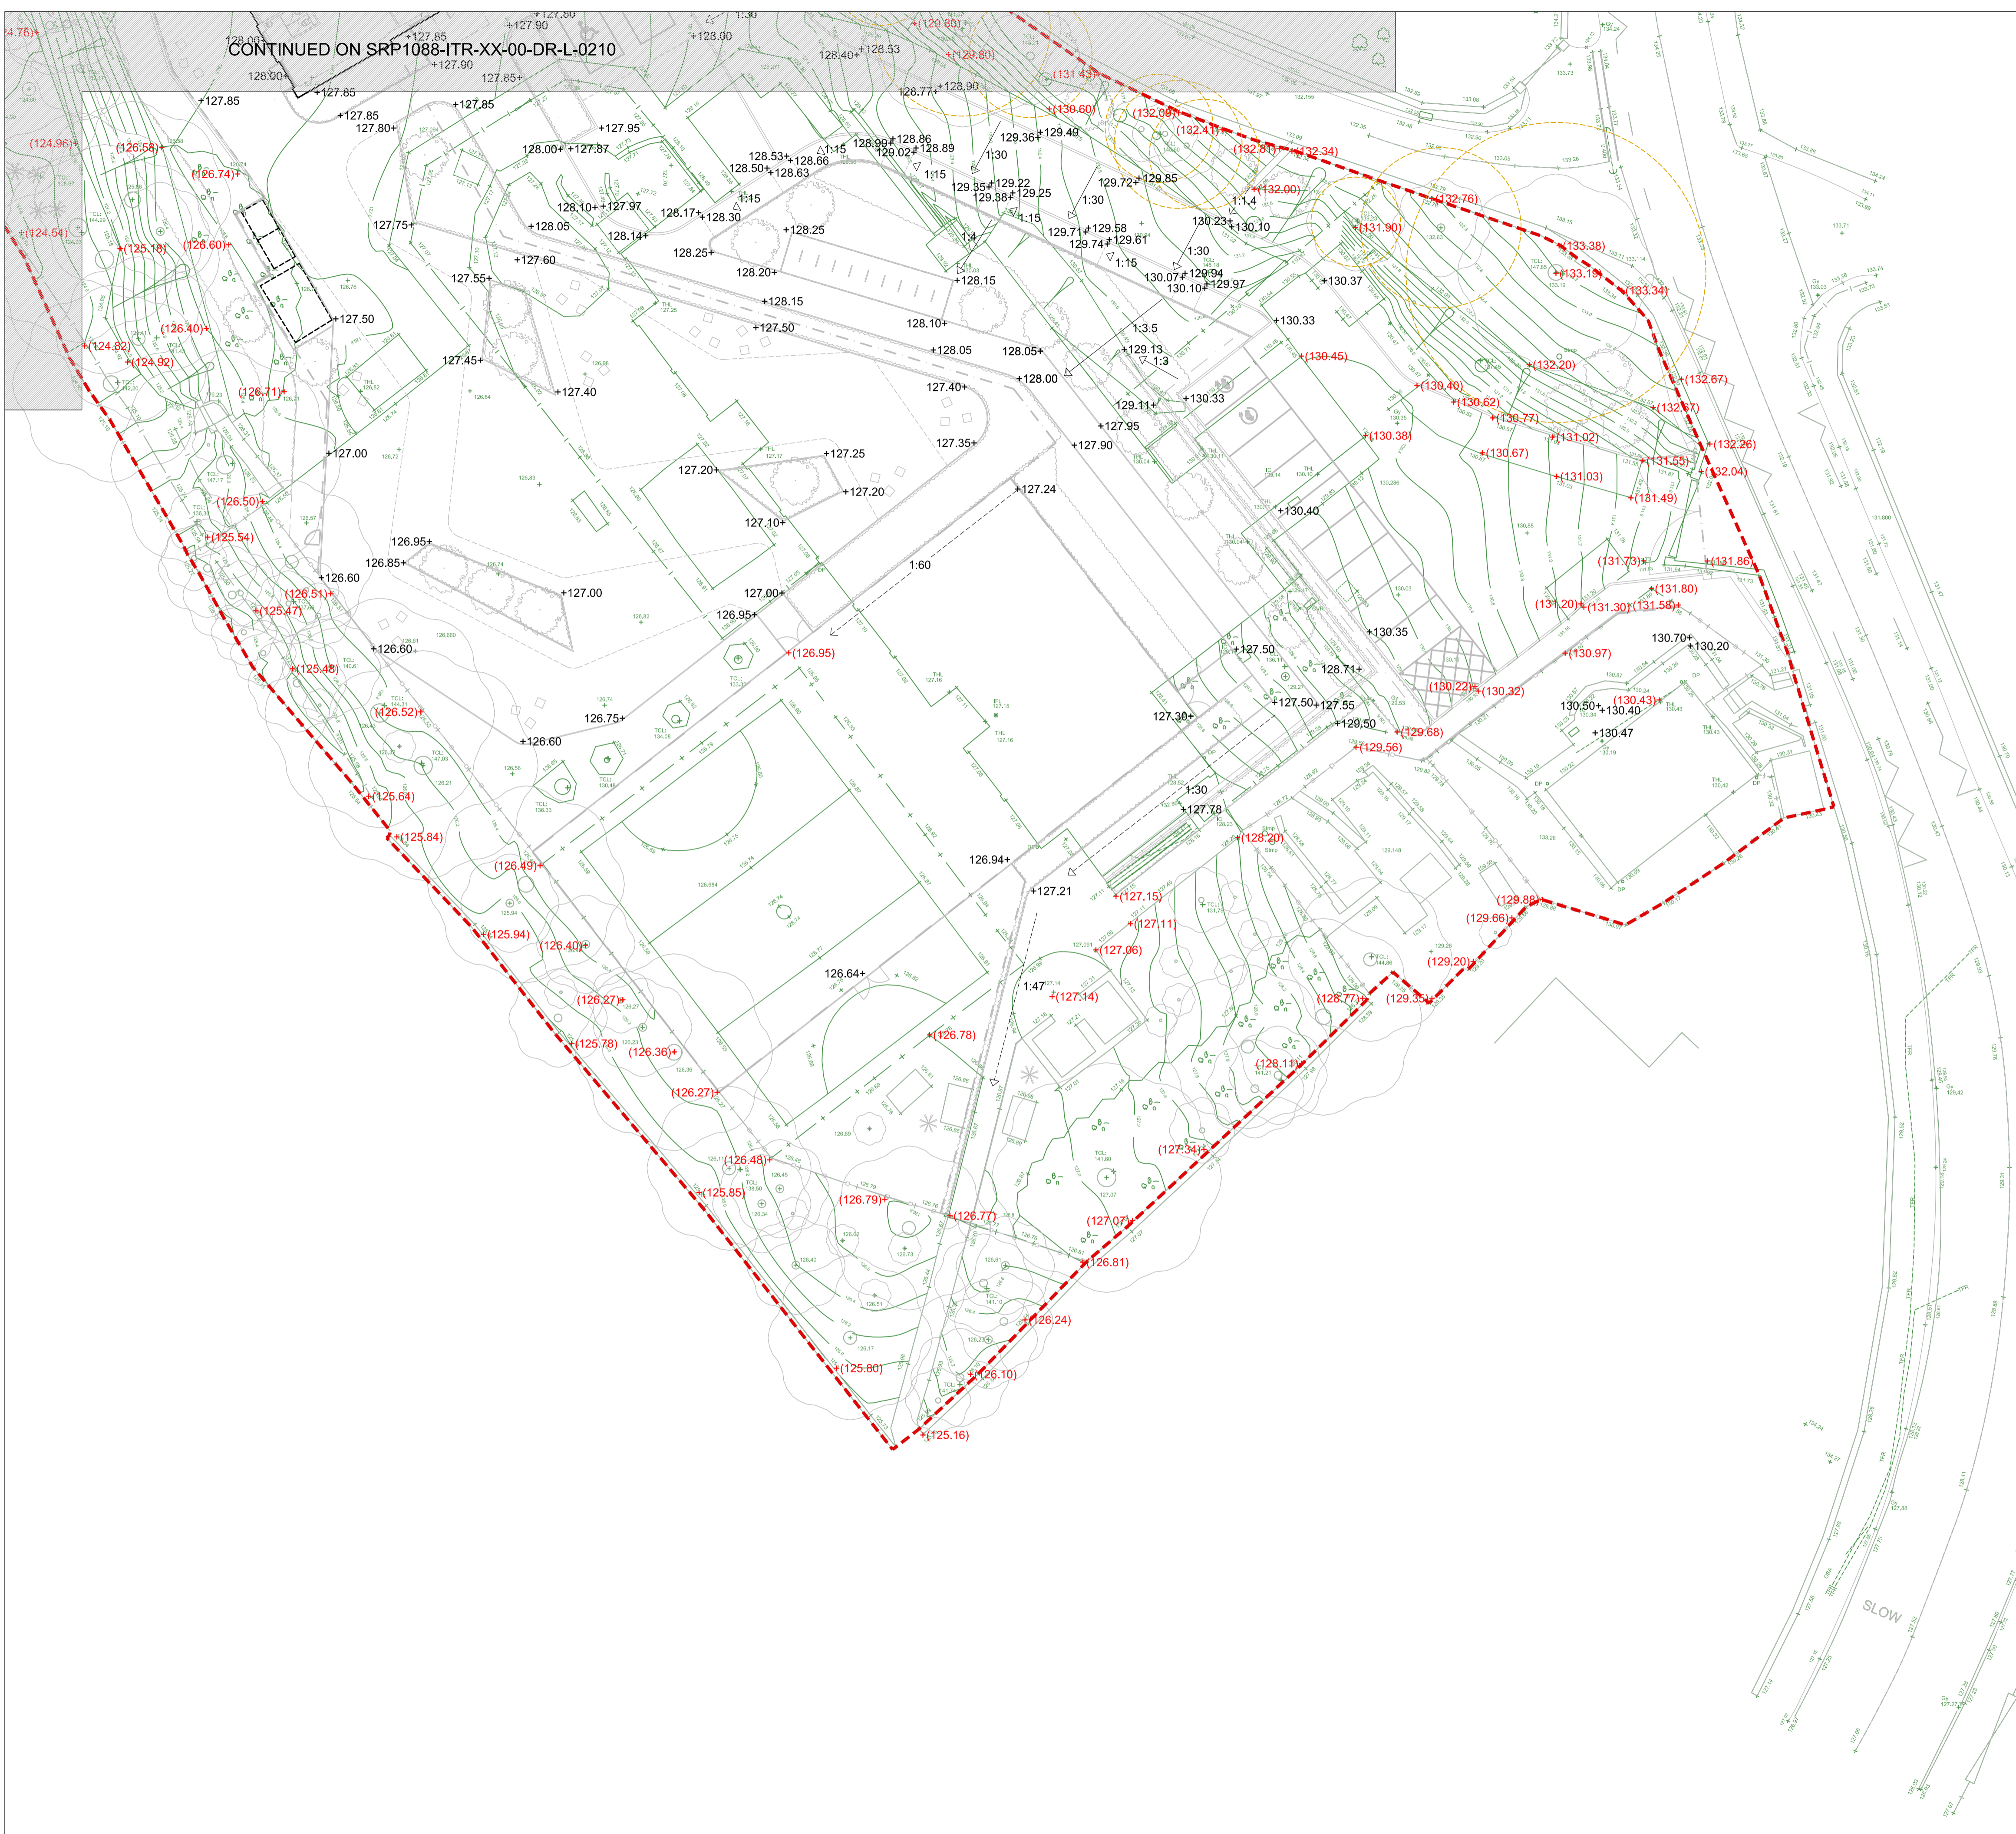

- Key
- Proposed Site Boundary
 - Design - Existing Level Retained
 - Design - Proposed Level
 - Existing Levels / Features as Topo Survey SRP1088-GRH-ZZ-ZZ-D-Y-0001-059

NOTES:
 DO NOT SCALE. Use figured dimensions only. The contractor is requested to check all dimensions before the work is put in hand. Copyright of this drawing belongs solely to Iteriad Ltd. This drawing must only be used for the purpose for which it is supplied and its contents must not be reproduced for any purpose without written permission. Areas indicated, or areas calculated from this drawing should be used for valuation purposes or as the basis for development contracts. Iteriad Ltd is a limited liability company registered in England and Wales. Number 7966573

KEY PLAN

TO BE READ IN CONJUNCTION WITH:

- SRP1088-ITR-XX-00-DR-L-0001 - Landscape Masterplan
- SRP1088-ITR-XX-00-DR-L-0002 - Landscape Strategy Plan
- SRP1088-ITR-XX-00-DR-L-0003 - External Access and Security Plan
- SRP1088-ITR-XX-00-DR-L-0004 - Existing Site Plan
- SRP1088-ITR-XX-00-DR-L-0005 - Landscape BB103 Comparison Plan
- SRP1088-ITR-XX-00-DR-L-0101 - Landscape GA 1 of 2
- SRP1088-ITR-XX-00-DR-L-0102 - Landscape GA 2 of 2
- SRP1088-ITR-XX-00-DR-L-0201 - Landscape Levels 1 of 2
- SRP1088-ITR-XX-00-DR-L-0202 - Landscape Levels 2 of 2
- SRP1088-ITR-XX-00-M3-L-8001 - Landscape Revit Model
- SRP1088-ITR-VV-XX-SP-L-1000 - Outline Hard and Soft Landscape Material Specification

P10	Issued for planning resubmission	IF	MS	08.09.24
P09	Issued for planning resubmission. Updated in line with G.A.'s	IF	MS	24.07.24
P08	TURNING HEAD ENLARGED IN LINE WITH PLANNING REQUIREMENTS	MS	KH	06.09.23
P07	PLANNING UPDATE ISSUE	MS	KH	30.06.23
P06	PROPOSED BUILDING PERIMETER LEVELS UPDATE	MS	KH	16.06.23
P05	STAGE 4 ISSUE	MS	KH	13.06.23
P04	ACCESSIBLE PARKING BAY RE-ORIENTATION, EXISTING TREES RETAINED UPDATE	MS	KH	11.05.23
P03	EXISTING LEVEL UPDATE	MS	KH	30.03.23
P02	TURNING HEAD AND SUBSTATION UPDATES	MS	KH	28.03.23
P01	FIRST ISSUE	MS	KH	23.03.23
REV	DETAILS	DRAWN BY	CHECKED BY	CHECKED DATE

DRAWING RECORD

STATUS

FOR REVIEW, COMMENT AND APPROVAL

CLIENT

MASTERPLANNERS/LANDSCAPE ARCHITECTS

(iteriad)

Studio
 2 Craigwood Cottages,
 Eskdalemuir,
 Windermere,
 Cumbria
 LA23 1LQ

T: (+44) 15394 43018
 E: studio@iteriad.com
 W: www.iteriad.com

PROJECT TITLE

St Peter's Primary

DRAWING TITLE

**Existing / Proposed Levels
 (Sheet 2 of 2)**

SCALE DRAWN BY DATE

1:200@A1 MS MAR '23

JOB/DRAWING NUMBER REVISION

SRP1088-ITR-XX-00-DR-L-0211 P10

