


Proposed Ground Floor Plan
And Drainage Layout
Scale 1:100

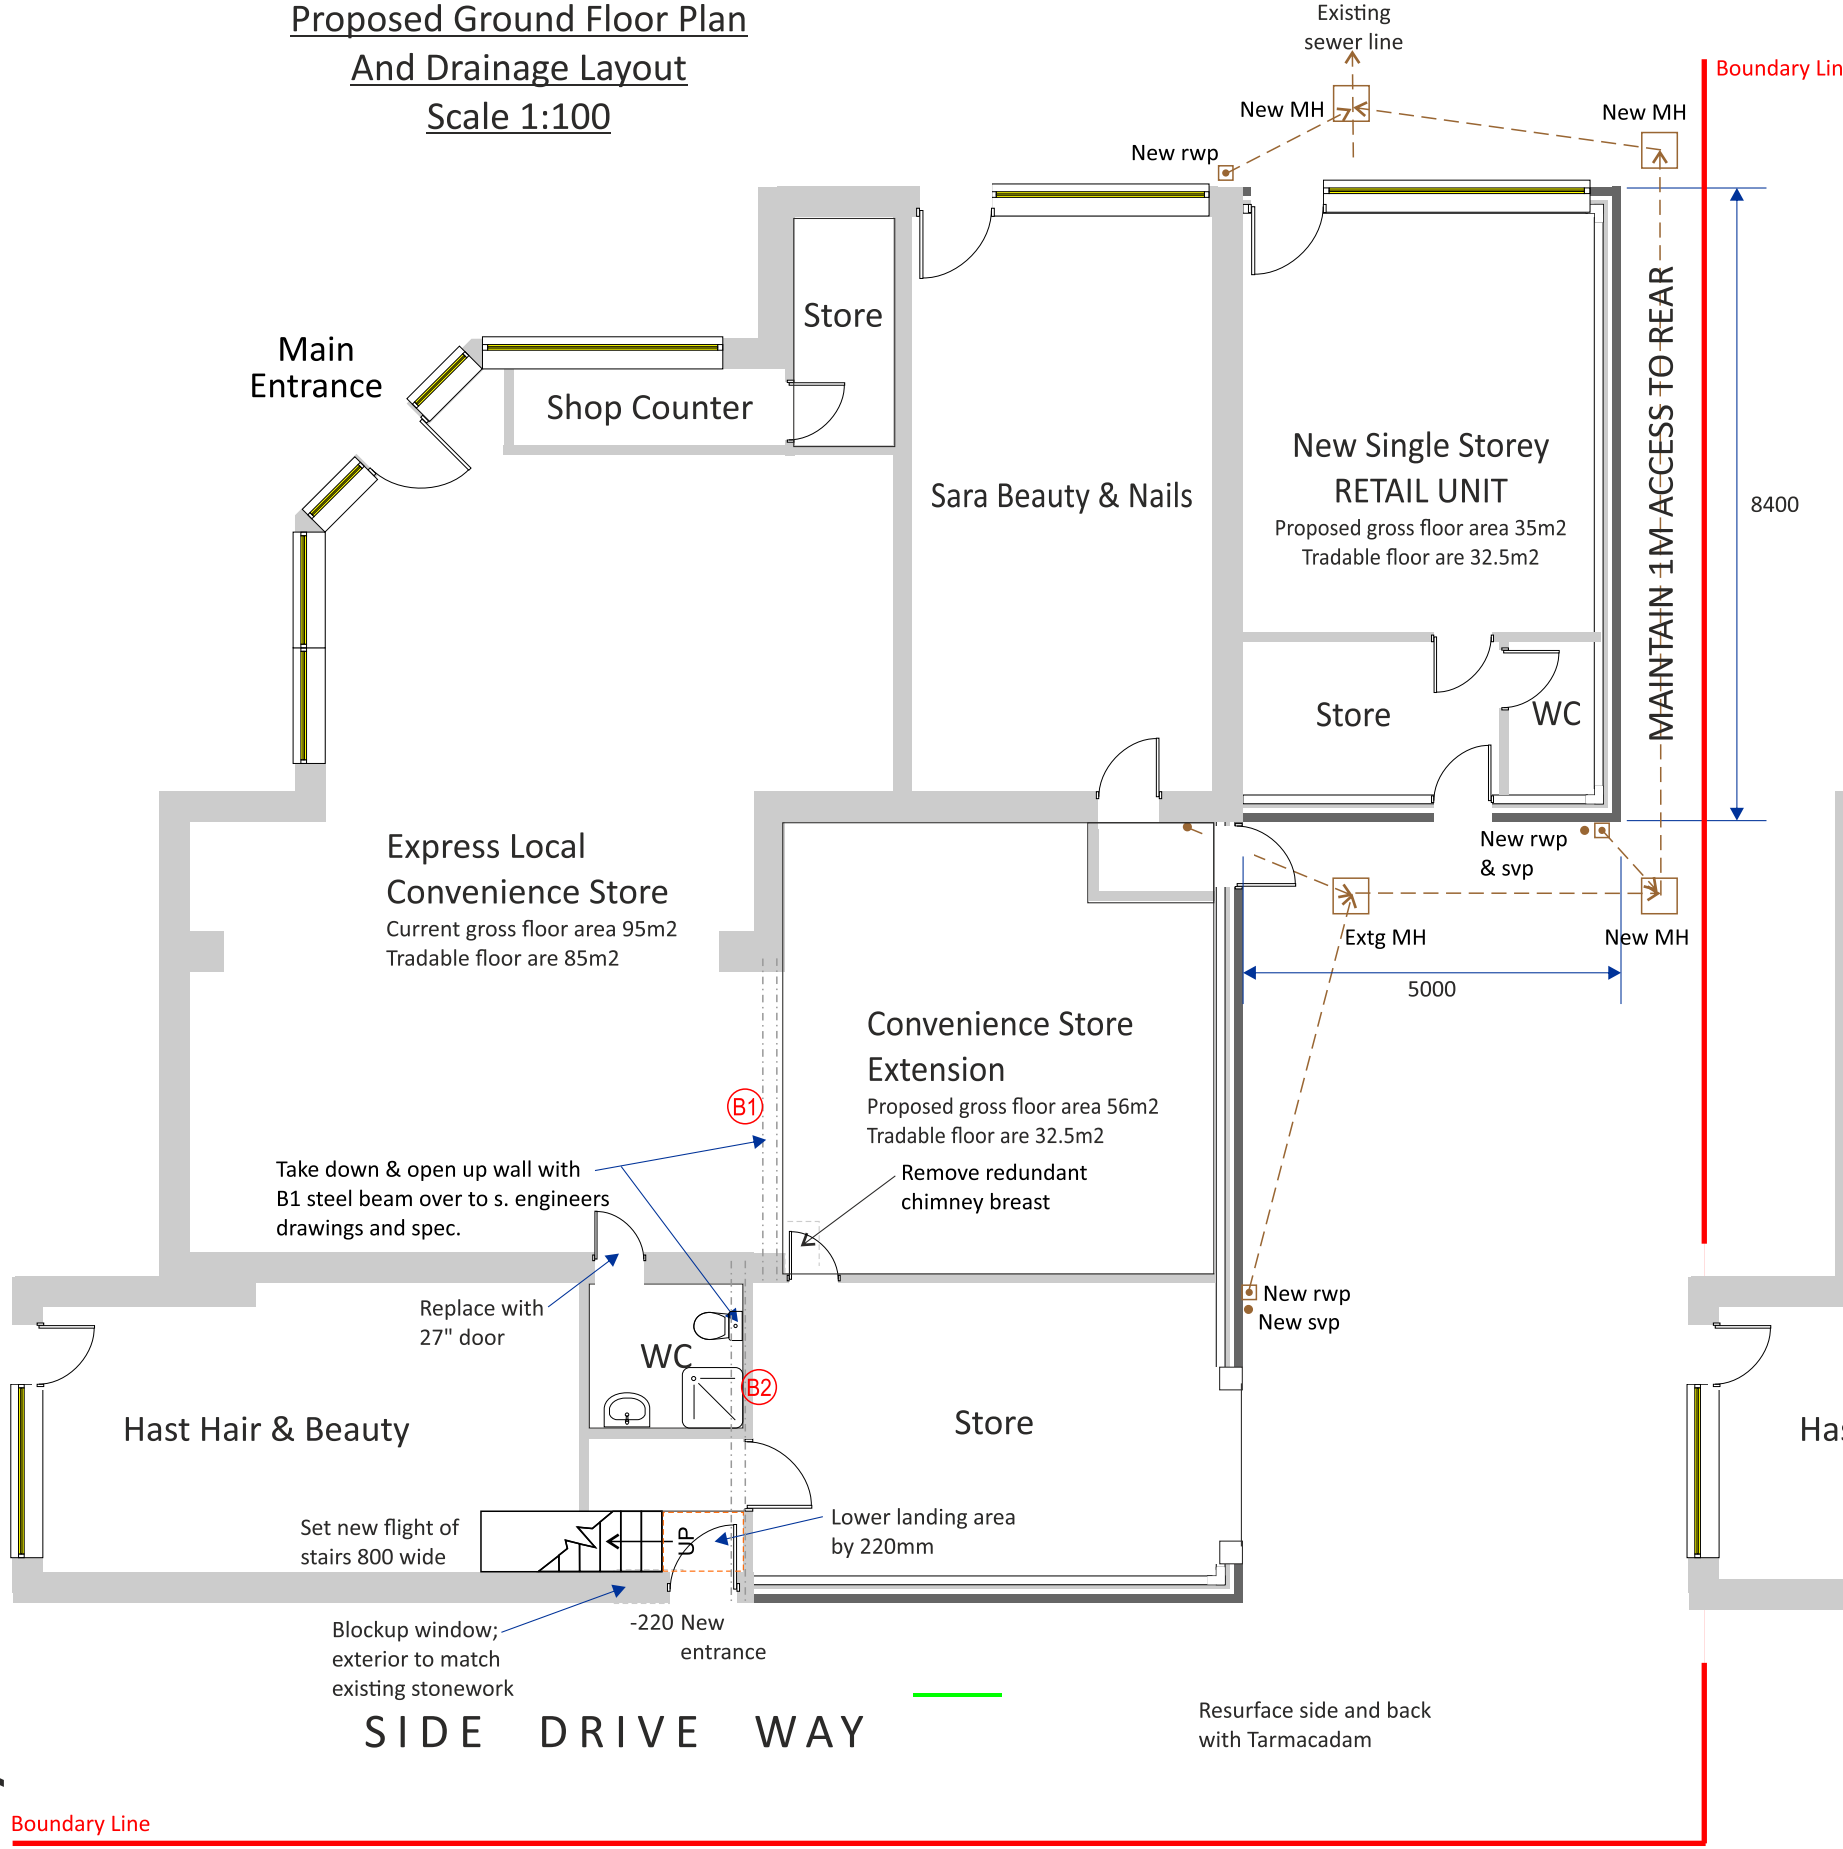

Existing Ground Floor Plan Scale 1:100

